


## LOCATION MAP

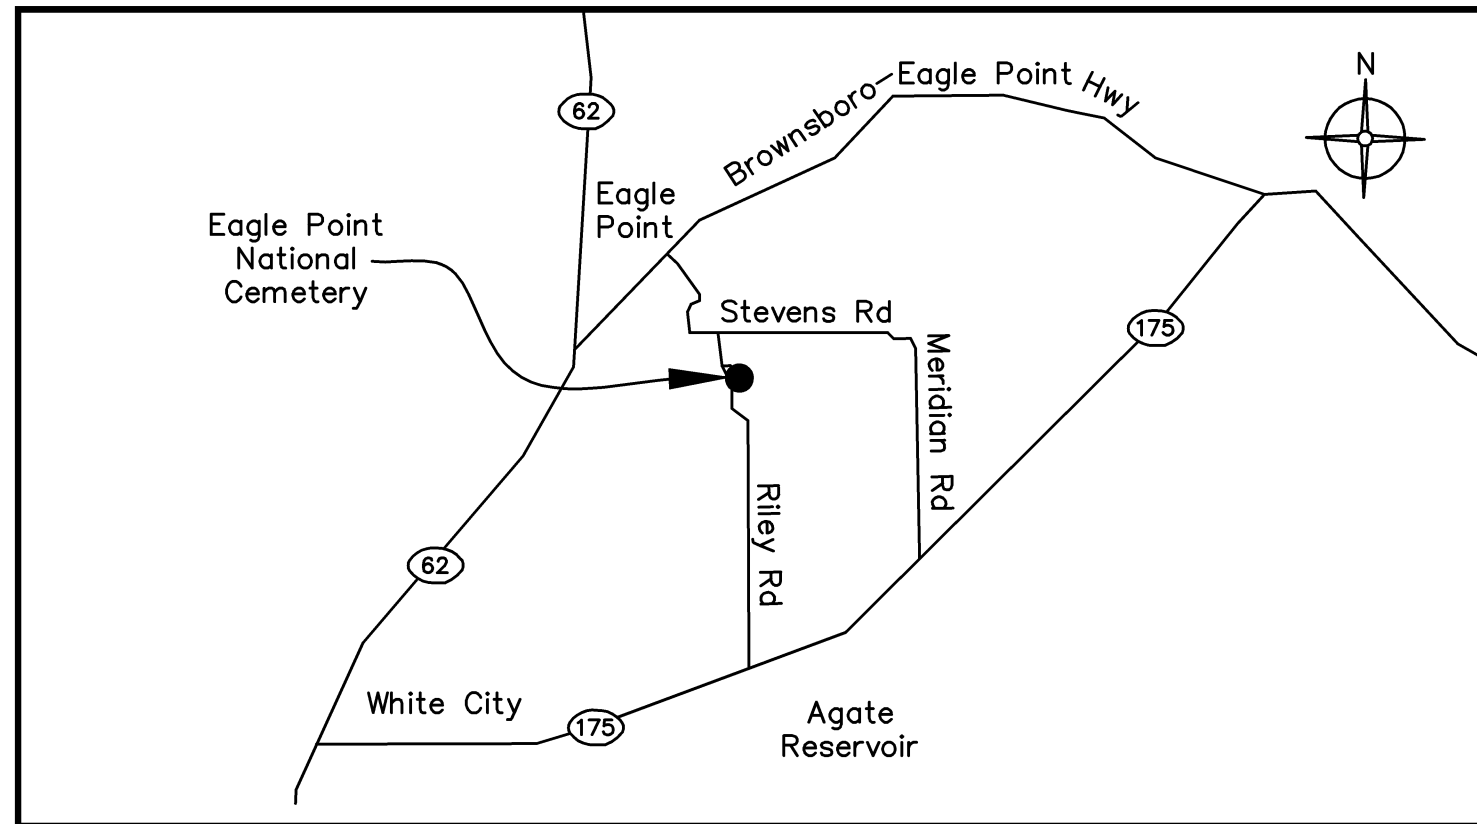

## VICINITY MAP

DEPARTMENT OF  
VETERANS AFFAIRSEAGLE POINT NATIONAL CEMETERY  
EAGLE POINT, OREGON  
REPLACE ADMINISTRATION AND MAINTENANCE  
BUILDING AND SITE IMPROVEMENTS  
PROJECT NUMBER 906CM3009

## GENERAL SHEETS

DWG. NO.	TITLE	SHEET NO.
X-1.1	COVER SHEET/DRAWING INDEX	1 OF 181
X-2.1	GENERAL NOTES, SYMBOLS & ABBREVIATIONS	2 OF 181
X-3.1	PHASING PLAN/STAGING PLAN	3 OF 181
X-3.2	TEMPORARY MAINTENANCE YARD LAYOUT PLAN	4 OF 181
B-1.1	EXISTING CONDITIONS MAP - OVERALL	5 OF 181
B-1.2	EXISTING CONDITIONS MAP - NORTH	6 OF 181
B-1.3	EXISTING CONDITIONS MAP - CENTRAL	7 OF 181
B-1.4	EXISTING CONDITIONS MAP - SOUTH	8 OF 181
B-1.5	EXISTING CONDITIONS MAP - WEST	9 OF 181
B-2.1	GEOTECHNICAL BORING MAP	10 OF 181
B-2.2	BORING LOGS	11 OF 181
B-2.3	BORING LOGS	12 OF 181
D-1.1	DEMOLITION - BLDG. COMPLEX SITE	13 OF 181
D-1.2	DEMOLITION - #1301 ADMIN. BLDG. SITE	14 OF 181
L-1.1	SITE PLAN - NEW BUILDING COMPLEX	15 OF 181
L-1.2	SITE PLAN - FORMER 1301 BLDG. - NEW BURIAL SECTION F-4	16 OF 181
L-1.3	CREMAINS LAYOUT PLAN - SECTION F-4	17 OF 181
L-1.4	ALIGNMENT & LAYOUT PLAN (SOUTHEAST)	18 OF 181
L-1.5	ALIGNMENT & LAYOUT PLAN (NORTHWEST)	19 OF 181
L-2.1	EROSION CONTROL PLAN - NEW BUILDING COMPLEX SITE	20 OF 181
L-2.2	EROSION CONTROL PLAN - FORMER 1301 BLDG. SITE	21 OF 181
L-2.3	EROSION CONTROL PLAN - SANITARY SEWER CONSTRUCTION	22 OF 181
L-2.4	EROSION CONTROL PLAN - SANITARY SEWER CONSTRUCTION	23 OF 181
L-3.1	GRADING PLAN - NEW BUILDING COMPLEX	24 OF 181
L-3.2	GRADING PLAN - CREMAINS SECTION F-4	25 OF 181
L-3.3	GRADING PLAN - SANITARY SEWER CONSTRUCTION	26 OF 181
L-3.4	ROAD REALIGNMENT PLAN	27 OF 181
L-3.5	CONCRETE PAVING PLAN	28 OF 181
L-3.6	PAVEMENT & SITE DETAILS	29 OF 181
L-3.7	SITE DETAILS	30 OF 181
L-4.1	UTILITY PLAN - BLDG. COMPLEX SITE	31 OF 181
L-4.2	STORM SEWER PLAN & PROFILE	32 OF 181
L-5.1	STORM UTILITY DETAILS	33 OF 181
L-5.2	UTILITY DETAILS	34 OF 181
L-6.0	LANDSCAPE PLAN - NEW BUILDING COMPLEX SITE	35 OF 181
L-6.1	LANDSCAPE PLAN - FORMER 1301 BLDG./NEW CREMAINS SECTION F-4	36 OF 181
L-6.2	LANDSCAPE DETAILS	37 OF 181
L-6.3	LANDSCAPE DETAILS	38 OF 181
L-6.4	LANDSCAPE DETAILS	39 OF 181
L-7.1	SIGN PLAN	40 OF 181
S-1.1	RETAINING WALL PLAN, IMAGES & SECTIONS	41 OF 181
W-1.1	SANITARY SEWER PLAN & PROFILE	42 OF 181
W-1.2	SANITARY SEWER & WATERMAIN PLAN & PROFILE	43 OF 181
W-1.3	SANITARY SEWER & WATERMAIN PLAN & PROFILE	44 OF 181
W-2.1	SANITARY SEWER & WATERMAIN DETAILS	45 OF 181
I-1.1	IRRIGATION NOTES & LEGEND	46 OF 181
I-1.2	IRRIGATION DEMOLITION PLAN	47 OF 181
I-1.3	IRRIGATION PLAN	48 OF 181
I-1.4	IRRIGATION CONTROLLER PLAN	49 OF 181
I-1.5	IRRIGATION CONTROLLER PLAN	50 OF 181
I-1.6	IRRIGATION CONTROLLER PLAN	51 OF 181
I-1.7	IRRIGATION DETAILS	52 OF 181
I-1.8	IRRIGATION DETAILS	53 OF 181
H-1.1	MECHANICAL SITE PLAN	54 OF 181
E-1.1	ELECTRICAL DEMOLITION SITE PLAN	55 OF 181
E-2.1	ELECTRICAL SITE PLAN	56 OF 181
E-2.2	ELECTRICAL SITE PLAN	57 OF 181
E-2.3	SECURITY SITE PLAN	58 OF 181
E-3.1	ELECTRICAL DETAILS	59 OF 181
E-4.1	ELECTRICAL ONE-LINE DIAGRAM AND DISCONNECTS	60 OF 181

## DRAWING INDEX

## ADMINISTRATION BUILDING - BLDG NO. 1001

DWG. NO.	TITLE	SHEET NO.
A-1001-1.1	ADMINISTRATION BLDG. CODE REVIEW PLAN	61 OF 181
A-1001-2.1	ADMINISTRATION BLDG. FLOOR PLAN	62 OF 181
A-1001-2.2	ADMINISTRATION BLDG. ROOF PLAN	63 OF 181
A-1001-2.3	ADMINISTRATION BLDG. CEILING PLAN	64 OF 181
A-1001-3.1	ADMINISTRATION BLDG. EXTERIOR ELEVATIONS	65 OF 181
A-1001-4.1	ADMINISTRATION BLDG. BLDG. SECTIONS	66 OF 181
A-1001-5.1	ADMINISTRATION BLDG. WALL SECTIONS	67 OF 181
A-1001-6.1	ADMINISTRATION BLDG. EXTERIOR DETAILS	68 OF 181
A-1001-6.2	ADMINISTRATION BLDG. EXTERIOR DETAILS	69 OF 181
A-1001-6.3	ADMINISTRATION BLDG. EXTERIOR DETAILS	70 OF 181
A-1001-7.1	ADMINISTRATION BLDG. DOOR SCHEDULE, DETAILS	71 OF 181
A-1001-7.2	ADMINISTRATION BLDG. WINDOW DETAILS	72 OF 181
A-1001-8.1	ADMINISTRATION BLDG. AND INTERIOR ELEVATIONS	73 OF 181
A-1001-8.2	ADMINISTRATION BLDG. INTERIOR DETAILS, WALL TYPES	74 OF 181
A-1001-8.3	ADMINISTRATION BLDG. MISCELLANEOUS DETAILS	75 OF 181
A-1001-9.1	ADMINISTRATION BLDG. ROOM FINISH SCHEDULE FURNITURE/FINISHES PLAN	76 OF 181
S-1001-0.1	STRUCTURAL GENERAL NOTES - ADMIN	77 OF 181
S-1001-1.1	SPECIAL INSPECTIONS/TESTING/SUBMITTALS	78 OF 181
S-1001-2.1	ADMINISTRATION BLDG. - FOUNDATION PLAN	79 OF 181
S-1001-3.1	ADMINISTRATION BLDG. - ROOF FRAMING PLAN	80 OF 181
S-1001-4.1	FOUNDATION DETAILS/SECTIONS	81 OF 181
S-1001-5.1	ROOF/FRAMING DETAILS/SECTIONS	82 OF 181
S-1001-6.1	TYPICAL MASONRY SECTIONS/DETAILS	83 OF 181
H-1001-0.1	MECHANICAL GENERAL NOTES - ADMIN	84 OF 181
H-1001-2.1	ADMINISTRATION BLDG. FLOOR PLAN - VENTILATION	85 OF 181
H-1001-3.1	ADMINISTRATION BLDG. CONTROL FLOW DIAGRAM	86 OF 181
H-1001-4.1	ADMINISTRATION BLDG. HVAC SCHEDULES	87 OF 181
H-1001-5.1	ADMINISTRATION BLDG. HVAC DETAILS	88 OF 181
P-1001-2.1	ADMINISTRATION BLDG. FLOOR PLAN - PLUMBING	89 OF 181
P-1001-3.1	ADMINISTRATION BLDG. PLUMBING RISER DIAGRAMS	90 OF 181
P-1001-4.1	ADMINISTRATION BLDG. PLUMBING DETAILS AND SCHEDULES	91 OF 181
E-1001-0.1	ELECTRICAL GENERAL NOTES - ADMIN	92 OF 181
E-1001-2.1	ADMINISTRATION BLDG. FLOOR PLAN - LIGHTING	93 OF 181
E-1001-3.1	ADMINISTRATION BLDG. FLOOR PLAN - POWER & SYSTEMS	94 OF 181
E-1001-5.1	ELECTRICAL MATERIAL LIST - ADMIN	95 OF 181
E-1001-6.1	ELECTRICAL LUMINAIRE SCHEDULE - ADMIN	96 OF 181
E-1001-7.1	TECHNOLOGY COVER SHEET	97 OF 181
E-1001-7.2	TECHNOLOGY RISERS AND DETAILS	98 OF 181
E-1001-7.3	TECHNOLOGY RISERS AND DETAILS	99 OF 181
E-1001-7.4	TECHNOLOGY MATERIALS LIST	100 OF 181
E-1001-7.5	ADMINISTRATION FLOOR PLAN - TECHNOLOGY	101 OF 181
E-1001-7.6	SECURITY SCHEDULES	102 OF 181

## MAINTENANCE BUILDING - BLDG NO. 3002

DWG. NO.	TITLE	SHEET NO.
A-3002-1.1	MAINTENANCE BLDG. CODE REVIEW	103 OF 181
A-3002-2.1	MAINTENANCE BLDG. FLOOR PLAN	104 OF 181
A-3002-2.2	MAINTENANCE BLDG. ROOF PLAN	105 OF 181
A-3002-2.3	MAINTENANCE BLDG. CEILING PLAN	106 OF 181
A-3002-2.4	WASHBAY FLOOR PLAN & SECTIONS	107 OF 181
A-3002-3.1	MAINTENANCE BLDG. EXTERIOR ELEVATIONS	108 OF 181
A-3002-4.1	MAINTENANCE BLDG. BLDG. SECTIONS	109 OF 181
A-3002-5.1	MAINTENANCE BLDG. WALL SECTIONS	110 OF 181
A-3002-6.1	MAINTENANCE BLDG. EXTERIOR DETAILS	111 OF 181
A-3002-6.2	MAINTENANCE BLDG. EXTERIOR DETAILS	112 OF 181
A-3002-6.3	MAINTENANCE BLDG. EXTERIOR DETAILS	113 OF 181
A-3002-7.1	MAINTENANCE BLDG. DOOR SCHEDULE, DETAILS	114 OF 181
A-3002-7.2	MAINTENANCE BLDG. WINDOW DETAILS	115 OF 181
A-3002-8.1	MAINTENANCE BLDG. INTERIOR ELEVATIONS, DETAILED FLOOR PLANS	116 OF 181
A-3002-8.2	MAINTENANCE BLDG. INTERIOR DETAILS, WALL TYPES	117 OF 181
A-3002-8.3	MAINTENANCE BLDG. MISC. DETAILS	118 OF 181
A-3002-9.1	MAINTENANCE BLDG. ROOM FINISH SCHEDULE/FURNITURE/FINISHES PLAN	119 OF 181
S-3002-0.1	STRUCTURAL GENERAL NOTES - MAINTENANCE	120 OF 181
S-3002-1.1	SPECIAL INSPECTIONS/TESTING/SUBMITTALS	121 OF 181
S-3002-2.1	MAINTENANCE BLDG. - FOUNDATION PLAN	122 OF 181
S-3002-3.1	MAINTENANCE BLDG. - ROOF FRAMING PLAN	123 OF 181
S-3002-4.1	FOUNDATION DETAILS/SECTIONS	124 OF 181
S-3002-5.1	ROOF/FRAMING DETAILS/SECTIONS	125 OF 181
S-3002-6.1	TYPICAL MASONRY SECTIONS/DETAILS	126 OF 181
H-3002-0.1	MECHANICAL GENERAL NOTES - MAINTENANCE	127 OF 181
H-3002-2.1	MAINTENANCE BLDG. FLOOR PLAN - VENTILATION	128 OF 181
H-3002-3.1	MAINTENANCE BLDG. CONTROL DIAGRAMS	129 OF 181
H-3002-4.1	MAINTENANCE BLDG. HVAC SCHEDULES	130 OF 181
H-3002-5.1	MAINTENANCE BLDG. DETAILS	131 OF 181
P-3002-2.1	MAINTENANCE BLDG. FLOOR PLAN - PLUMBING	132 OF 181
P-3002-3.1	MAINTENANCE BLDG. PLUMBING RISER DIAGRAMS	133 OF 181
P-3002-4.1	MAINTENANCE BLDG. PLUMBING SCHEDULE	134 OF 181
P-3002-5.1	MAINTENANCE BLDG. PLUMBING DETAILS	135 OF 181
E-3002-0.1	ELECTRICAL GENERAL NOTES - MAINTENANCE	136 OF 181
E-3002-2.1	MAINTENANCE BLDG. FLOOR PLAN - LIGHTING	137 OF 181
E-3002-3.1	MAINTENANCE BLDG. FLOOR PLAN - POWER & SYSTEMS	138 OF 181
E-3002-5.1	ELECTRICAL MATERIAL LIST - MAINT.	139 OF 181
E-3002-6.1	ELECTRICAL LUMINAIRE SCHEDULE - MAINT.	140 OF 181
E-3002-7.1	TECHNOLOGY COVER SHEET	141 OF 181
E-3002-7.2	TECHNOLOGY RISERS AND DETAILS	142 OF 181
E-3002-7.3	TECHNOLOGY RISERS AND DETAILS	143 OF 181
E-3002-7.4	TECHNOLOGY MATERIAL LIST	144 OF 181
E-3002-7.5	MAINTENANCE BUILDING FLOOR PLAN - TECHNOLOGY	145 OF 181
E-3002-7.6	SECURITY SCHEDULES	146 OF 181

## VEHICLE STORAGE BUILDING - BLDG NO. 3003

DWG. NO.	TITLE	SHEET NO.
A-3003-1.1	VEHICLE STORAGE BLDG. CODE REVIEW PLAN	147 OF 181
A-3003-2.1	VEHICLE STORAGE BLDG. FLOOR PLAN	148 OF 181
A-3003-2.2	VEHICLE STORAGE BLDG. ROOF PLAN	149 OF 181
A-3003-2.3	VEHICLE STORAGE BLDG. CEILING PLAN	150 OF 181
A-3003-3.1	VEHICLE STORAGE BLDG. EXTERIOR ELEVATIONS	151 OF 181
A-3003-4.1	VEHICLE STORAGE BLDG. SECTIONS	152 OF 181
A-3003-5.1	VEHICLE STORAGE BLDG. WALL SECTIONS	153 OF 181
A-3003-6.1	VEHICLE STORAGE BLDG. EXTERIOR DETAILS	154 OF 181
A-3003-7.1	VEHICLE STORAGE BLDG. DOOR SCHEDULE, FRAME TYPES, DETAILS, ROOM FINISH SCHEDULE	155 OF 181
A-3003-8.1	STORAGE BIN PLAN & ELEVATIONS	156 OF 181
A-3003-8.2	STORAGE BIN DETAILS	157 OF 181
S-3003-0.1	STRUCTURAL GENERAL NOTES - VEHICLE STORAGE	158 OF 181
S-3003-1.1	SPECIAL INSPECTIONS/TESTING/SUBMITTALS	159 OF 181
S-3003-2.1	VEHICLE STORAGE BLDG. - FOUNDATION PLAN	160 OF 181
S-3003-3.1	VEHICLE STORAGE BLDG. - ROOF FRAMING PLAN	161 OF 181
S-3003-4.1	FOUNDATION DETAILS/SECTIONS	162 OF 181
S-3003-5.1	ROOF/FRAMING DETAILS/SECTIONS	163 OF 181
S-3003-6.1	TYPICAL MASONRY SECTIONS/DETAILS	164 OF 181
S-3003-7.1	STORAGE BINS FOUNDATION / ROOF FRAMING PLANS	165 OF 181
S-3003-7.2	STORAGE BINS SECTIONS AND DETAILS	166 OF 181
H-3003-0.1	MECHANICAL GEN. NOTES - VEHICLE STORAGE	167 OF 181
H-3003-2.1	VEHICLE STORAGE BLDG. FLOOR PLAN - HVAC	168 OF 181
H-3003-4.1	HVAC SCHEDULES VEHICLE STORAGE BUILDING	169 OF 181
E-3003-0.1	ELECTRICAL GENERAL NOTES - VEHICLE STORAGE	170 OF 181
E-3003-2.1	VEHICLE STORAGE BLDG. FLOOR PLAN - LIGHTING	171 OF 181
E-3003-3.1	VEHICLE STORAGE BLDG. FLOOR PLAN - POWER & SYSTEMS	172 OF 181
E-3003-4.1	VEHICLE STORAGE BLDG. ROOF PLAN - ELECTRICAL	173 OF 181
E-3003-5.1	ELECTRICAL MATERIAL LIST - VEHICLE STOR.	174 OF 181
E-3003-6.1	ELECTRICAL LUMINAIRE SCHEDULE - VEHICLE STOR.	175 OF 181
E-3003-7.1	TECHNOLOGY COVER SHEET	176 OF 181
E-3003-7.2	TECHNOLOGY RISERS AND DETAILS	177 OF 181
E-3003-7.3	TECHNOLOGY RISERS AND DETAILS	178 OF 181
E-3003-7.4	TECHNOLOGY MATERIALS LIST	179 OF 181
E-3003-7.5	VEHICLE AND EQUIPMENT STORAGE FLOOR PLAN - TECHNOLOGY	180 OF 181
E-3003-7.6	SECURITY SCHEDULES	181 OF 181

## GRAVESITE SUMMARY TABLE

EX. SECTION 27	
8'x4' DIRECT BURIAL SPACES REMOVED	-109
8'x4' DIRECT BURIAL SPACES REMAINING	879
EX. SECTION A	
3'x3' CREMATED REMAINS SPACES REMOVED	-1455
3'x3' CREMATED REMAINS SPACES REMAINING	0
SECTION F4 (FORMER ADMIN)	
NEW 3'x3' CREMATED REMAINS SPACES	917
TOTAL 3'x3' CREMATED REMAINS SPACES	917

## CIVIL ENGINEERING, ARCHITECTURE, LANDSCAPE ARCHITECTURE AND SURVEYING

ANDERSON ENGINEERING OF MINNESOTA, LLC  
17505 1st AVENUE NORTH, SUITE 100  
Plymouth, MN 55441  
(763) 412-4000 TEL  
(763) 412-4090 FAX  
web: www.ae-mn.com

## STRUCTURAL ENGINEER

ADVANCED STRUCTURAL TECHNOLOGIES  
5001 AMERICAN BLVD. WEST SUITE 800  
BLOOMINGTON, MN 84437  
(952) 854-9302 TEL.  
(952) 854-9690 FAX  
WEB: www.astmn.com

## MECHANICAL AND ELECTRICAL ENGINEER

KJWW ENGINEERING CONSULTANTS  
623 26TH AVENUE  
ROCK ISLAND, ILLINOIS 61201  
(309) 788-0673 TEL.  
(309) 786-5967 FAX  
WEB: www.klww.com

## IRRIGATION DESIGN

AQUA ENGINEERING, INC.  
5803 INNOVATION DRIVE  
FORT COLLINS, COLORADO 80525  
(970) 229-9668 TEL.  
(970) 226-3855 FAX  
WEB: www.aquaengineering.com

## GEOTECHNICAL ENGINEER

APPLIED GEOTECHNICAL ENGINEERING  
1314-B CENTER DRIVE NO. 452  
MEDFORD, OREGON 97501  
(541) 226-6658 TEL.  
WEB: www.agegc.com

## BID DOCUMENTS 7/1/2011

Revisions		Date		Drawing Title		Project Title		Date	
				COVER SHEET / DRAWING INDEX		REPLACE ADMINISTRATION AND MAINTENANCE BUILDING AND SITE IMPROVEMENTS		7-1-2011	
				Approved: Director, Office of Construction Management		Building Number		Project No.	
						Checked		906CM3009	
						GRJ		DRAWING NO.	
						Drawn		X-1.1	
						AMT/PSH		Dwg. 1 OF 181	
				Approved: Director, Project Management Service		Location			
						EAGLE POINT NATIONAL CEMETERY			
						2763 RILEY ROAD			
						EAGLE POINT, OR 97524			