



# GENERAL SHEET NOTES

1. REFER TO PLUMBING FIXTURE SCHEDULE ON SHEET P-1001-4.1 FOR SIZES OF BRANCH PIPING TO FIXTURES.

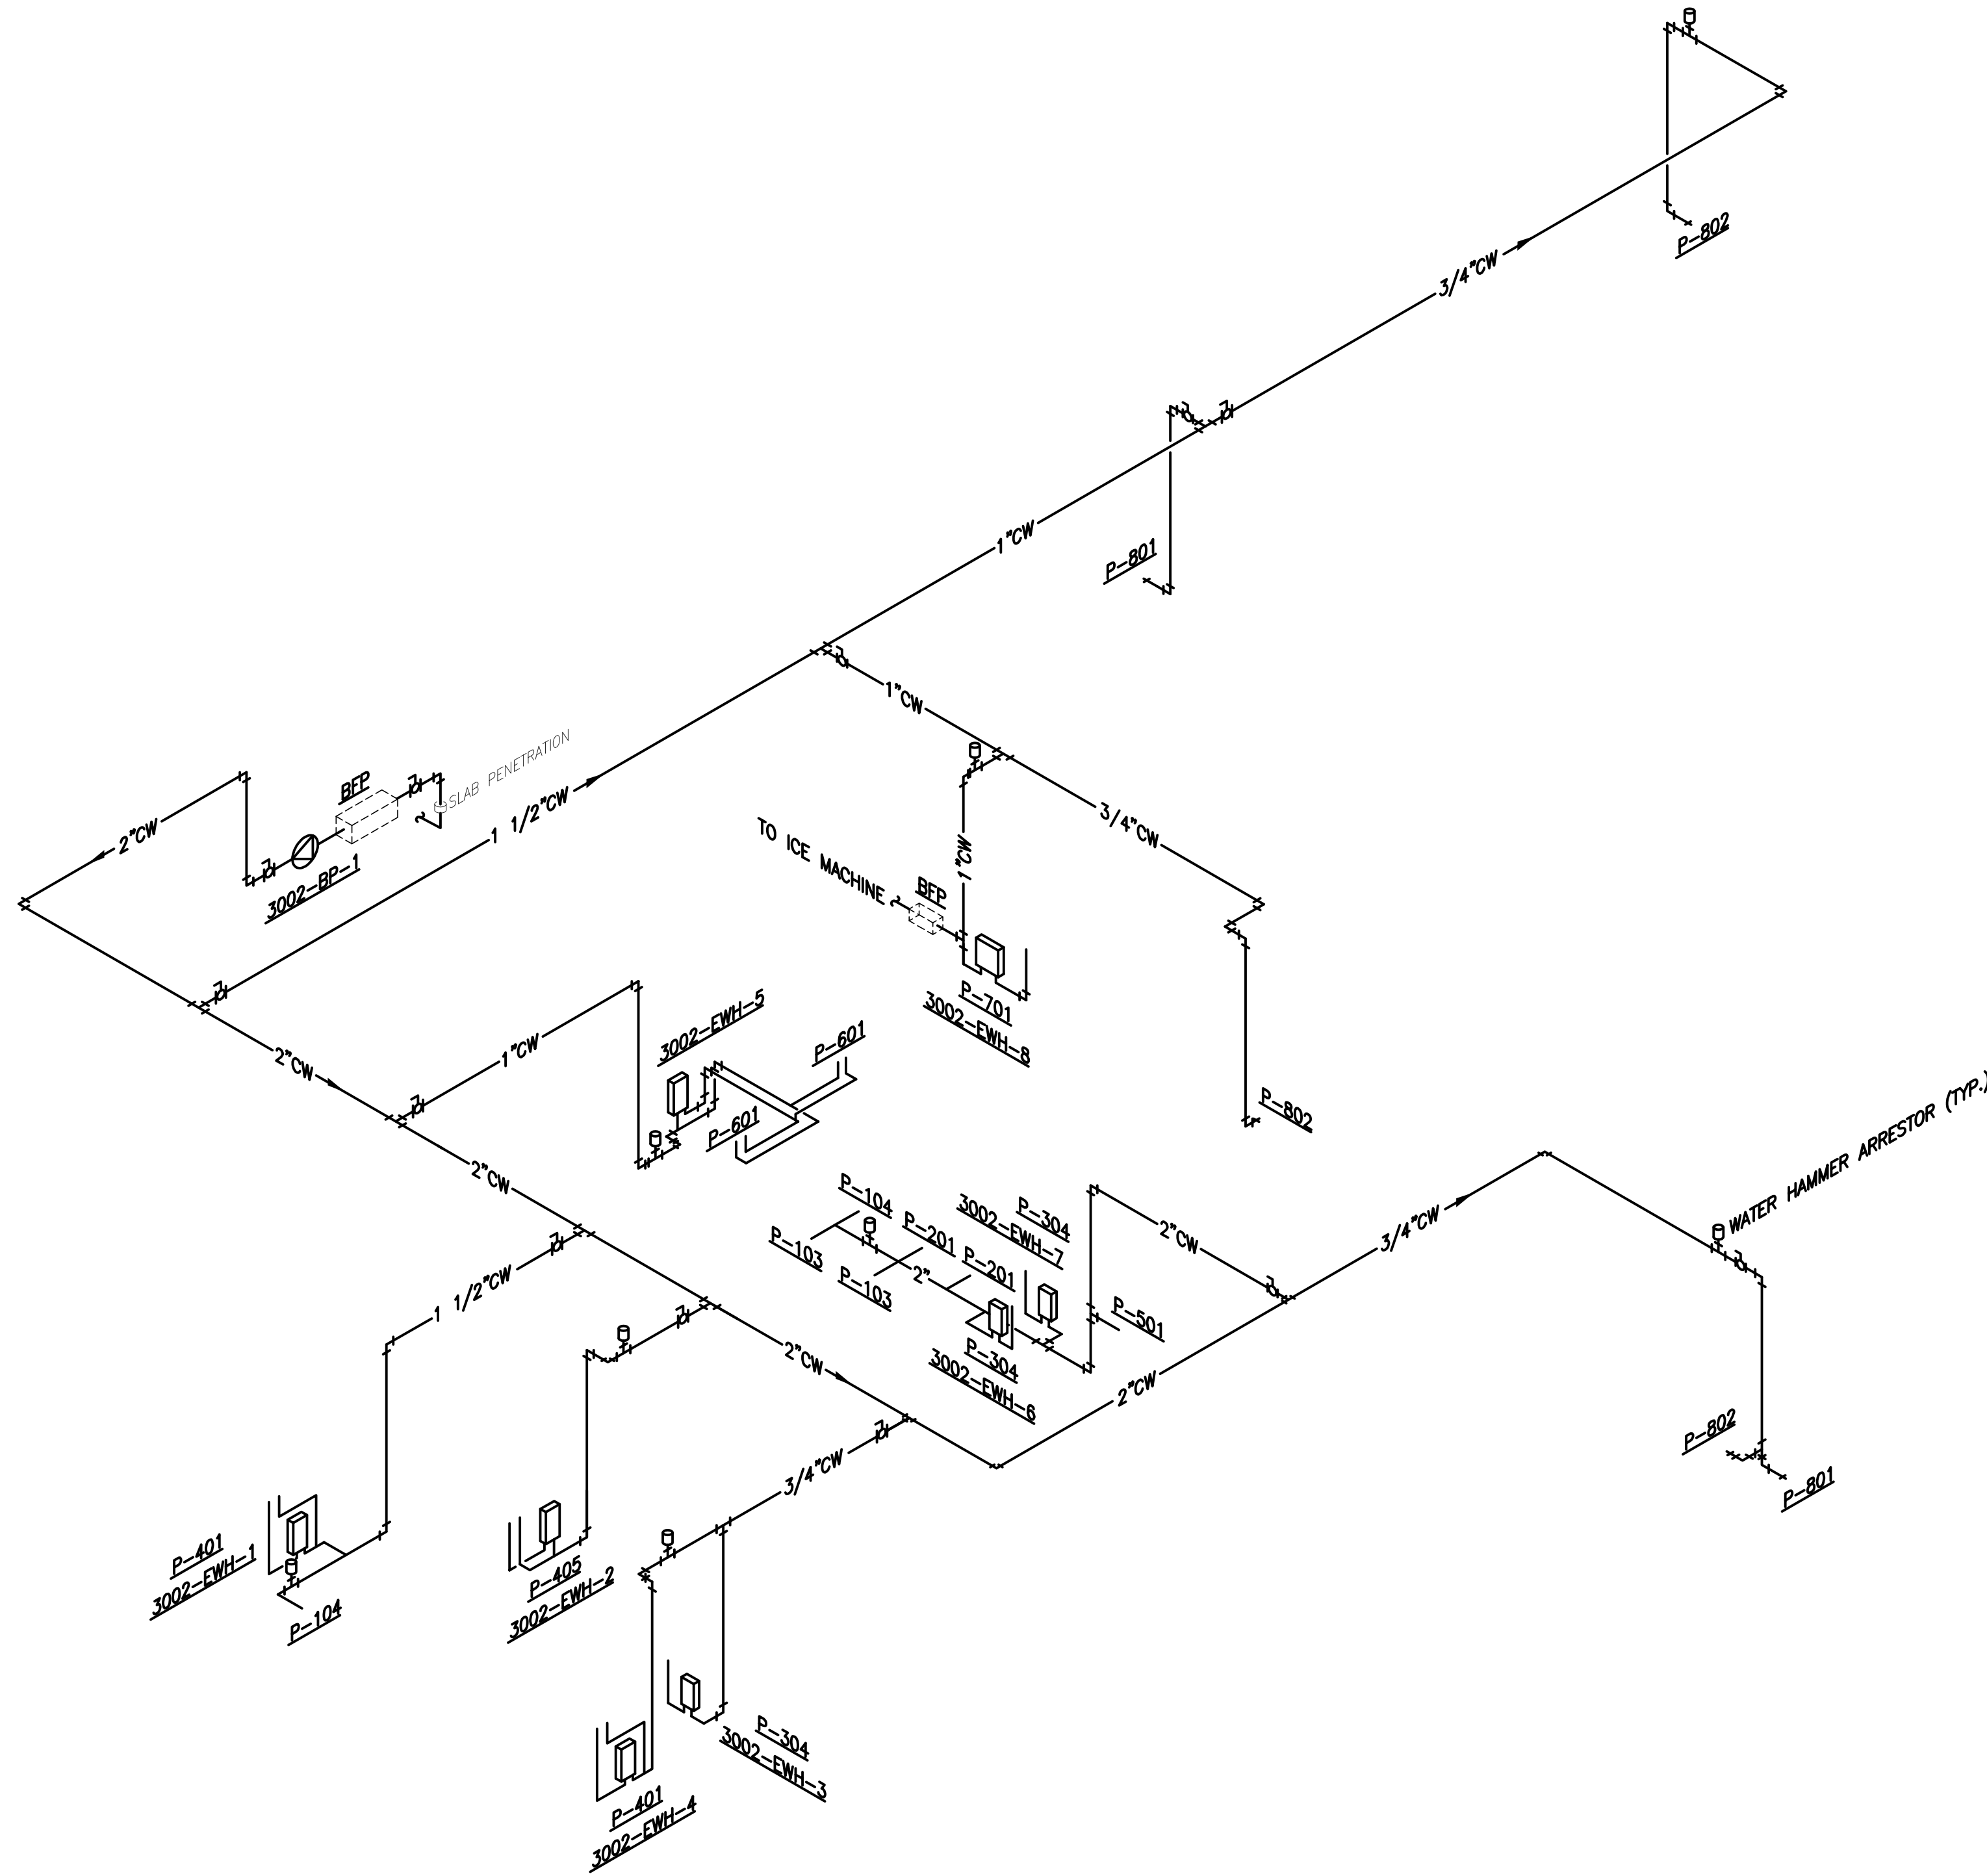

**1 MAINTENANCE BUILDING - WATER RISER DIAGRAM**  
NO SCALE

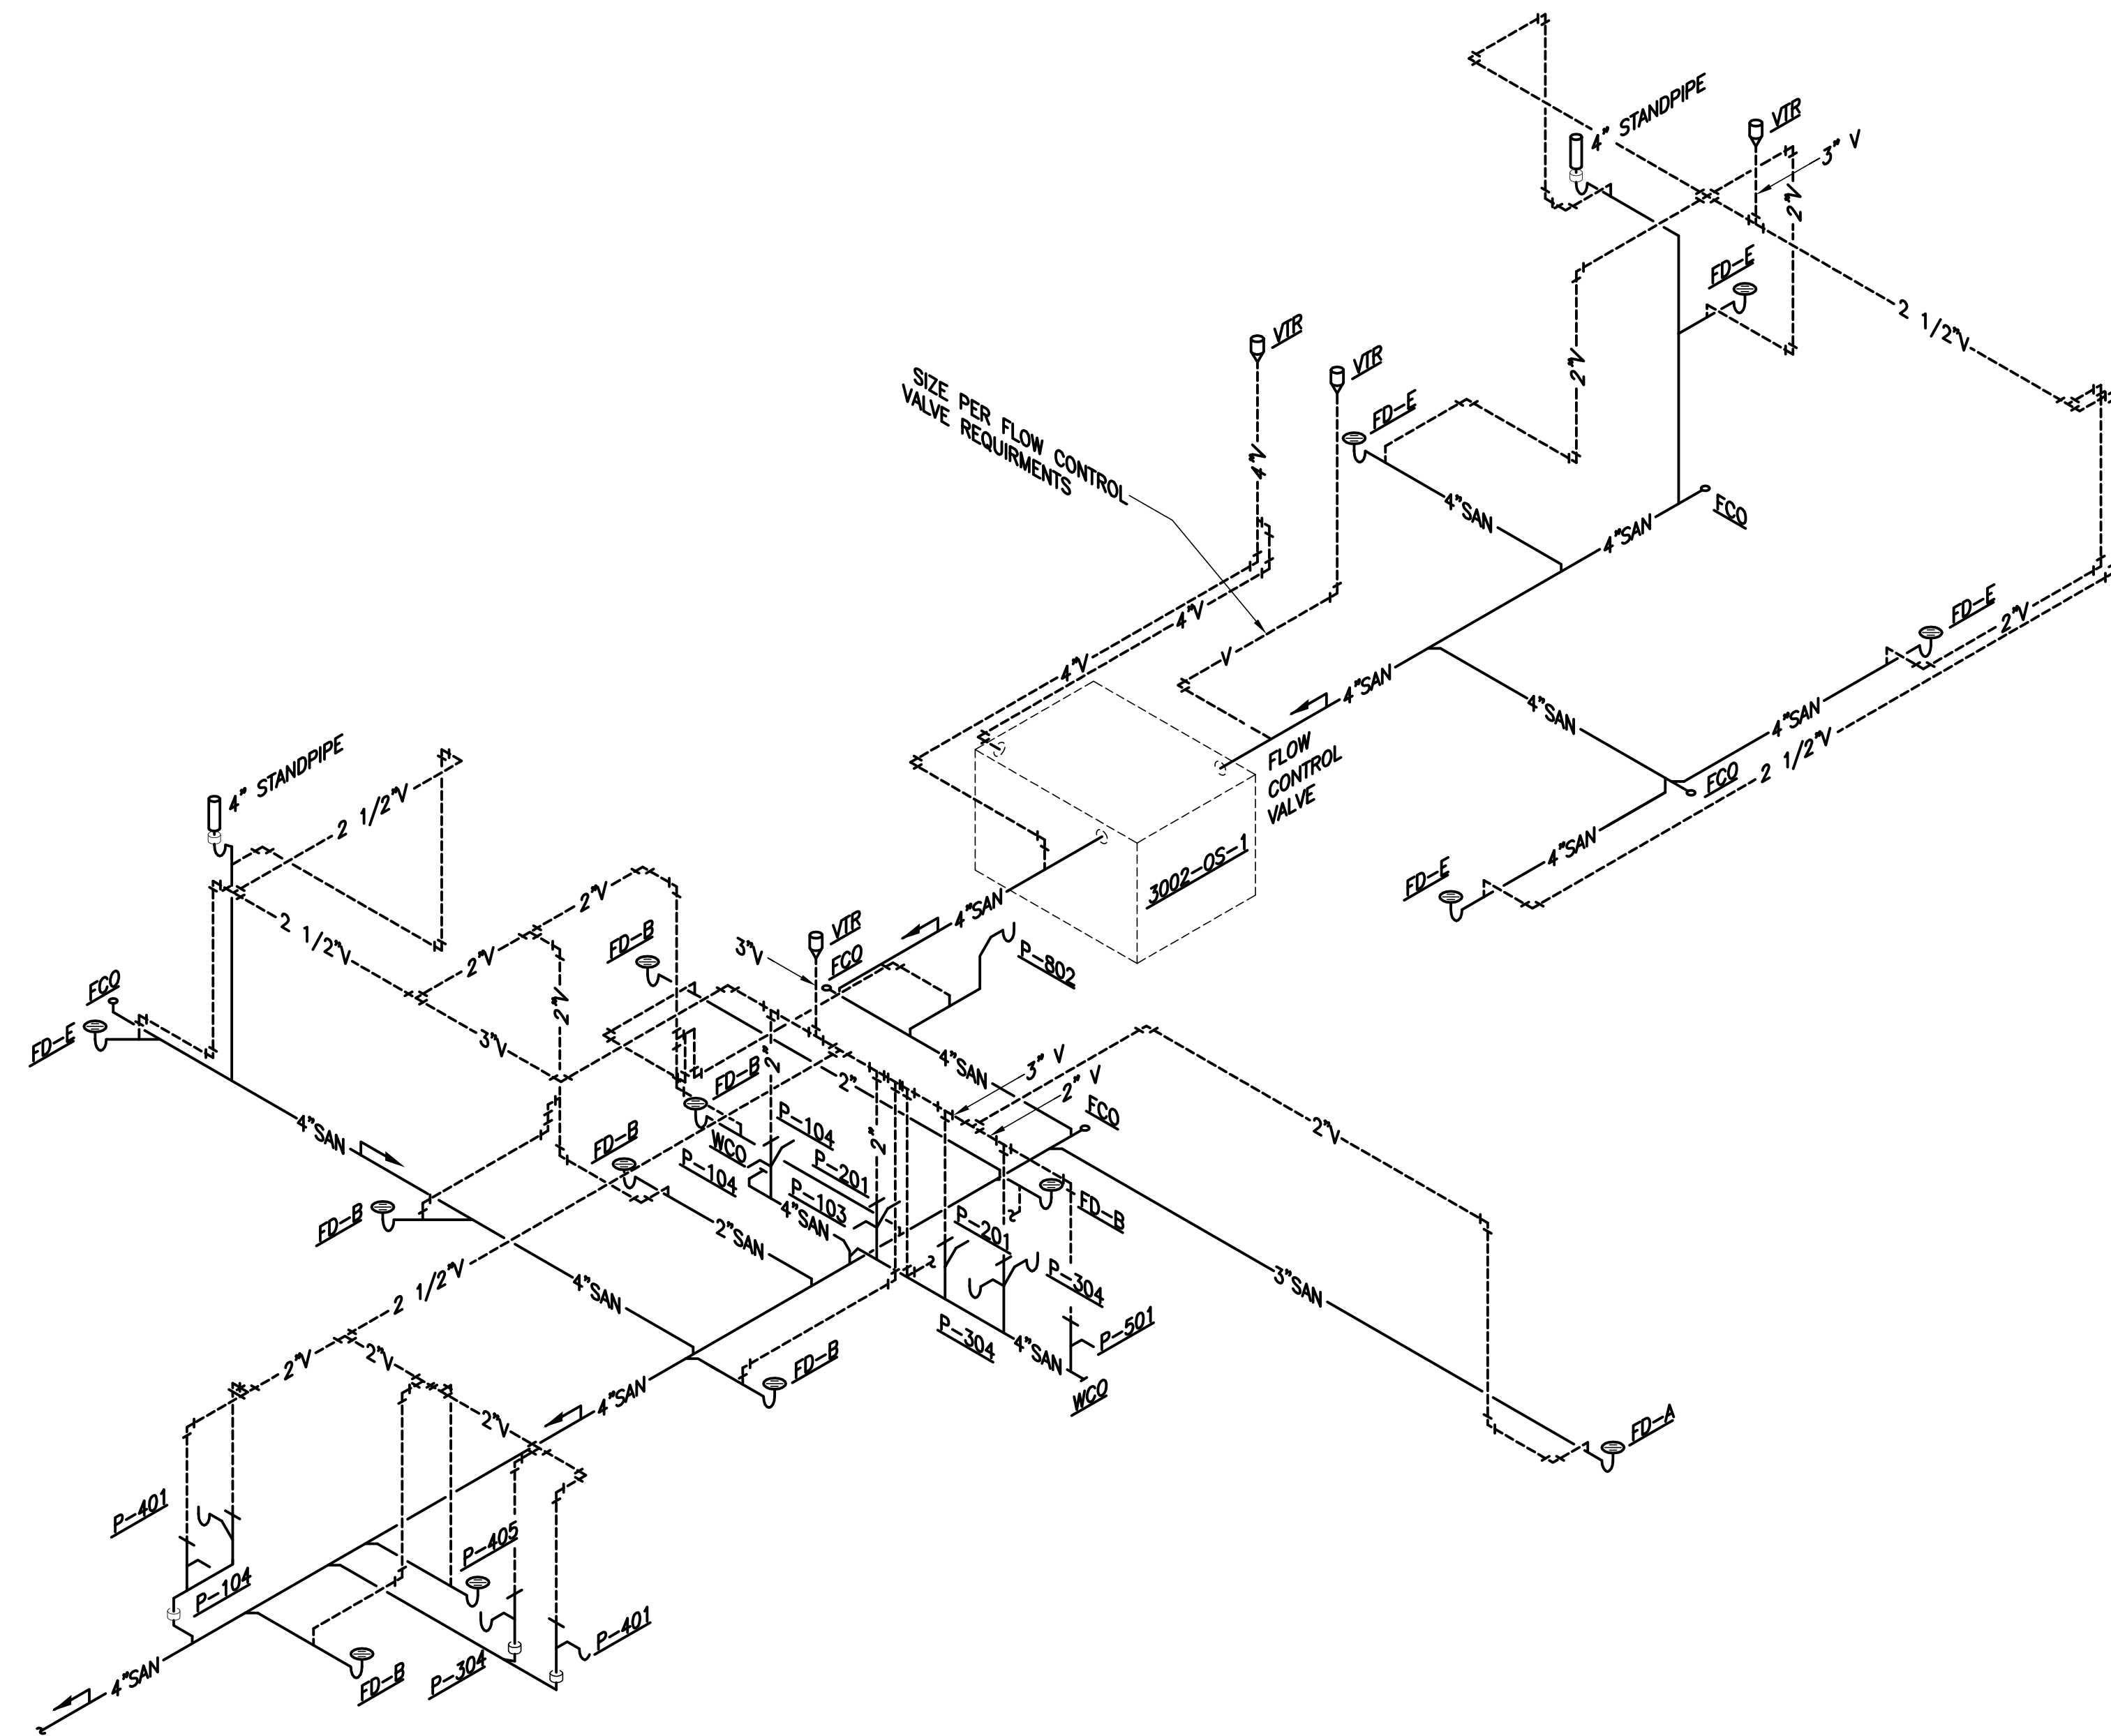

**2 MAINTENANCE BUILDING - SANITARY/VENT RISER DIAGRAM**  
NO SCALE

## BID DOCUMENTS 7/1/2011

Revisions	Date

**KJW ENGINEERING CONSULTANTS**  
Experience you can build on.<sup>™</sup>  
623 25TH AVENUE  
ROCK ISLAND, IL 61201  
309.786.0673 FAX: 309.786.5967  
www.kjw.com  
KJW Project # 10.0356.00  
**STRUCTURAL / MECHANICAL / ELECTRICAL /  
TECHNOLOGY / MEDICAL EQUIPMENT SOLUTIONS**

I hereby certify that this Plan, Specification, or Report was prepared by me, or under my direct supervision and that I am a duly licensed Professional Engineer under the laws of the State of Oregon.  
Signature: Warren L. Lloyd  
Name: Warren L. Lloyd  
Discipline: Mechanical  
Oregon Registration No. 78701PE Expiration date: 12.31.12  
Date Issued: \*\*/\*\*/\*\*

### Anderson Engineering of Minnesota, LLC

13605 1st AVENUE NORTH, SUITE 100, PLYMOUTH, MN 55441  
TEL (763) 412-4000 FAX (763) 412-4090  
www.ae-mn.com



N ATIONAL  
C EMETERY  
A DMINISTRATION

Drawing Title <b>MAINTENANCE BLDG PLUMBING RISER DIAGRAMS</b>	Project Title REPLACE ADMINISTRATION AND MAINTENANCE BUILDING AND SITE IMPROVEMENTS	Date 7-1-2011
Approved: Director, Office of Construction Management	Building Number <b>3002</b>	Checked <b>DavBod</b>
Approved: Director, Project Management Service	Location EAGLE POINT NATIONAL CEMETERY 2763 RILEY ROAD EAGLE POINT, OR 97524	Drawn <b>JamTho</b>
		DRAWING NO. <b>P-3002-31</b>
		Dwg. 133 OF 181