

PLUMBING ABBREVIATIONS

A/E ARCHITECT / ENGINEER
AD AREA DRAIN
AFF ABOVE FINISH FLOOR
AFG ABOVE FINISH GRADE
AG AIR GAP
AP ACCESS PANEL
ASHRAE AMERICAN SOCIETY HEATING, REFRIGERATION, AIR CONDITIONING ENGINEERS
ASME AMERICAN SOCIETY MECHANICAL ENGINEERS
ASPE AMERICAN SOCIETY PLUMBING ENGINEERS

BFP REDUCED PRESSURE BACKFLOW PREVENTER
BHP BREAK HORSEPOWER
BTU BRITISH THERMAL UNIT
BTUH BRITISH THERMAL UNIT PER HOUR

C CELSIUS
CGA COMPRESSED GAS ASSOCIATION
CI CAST IRON
CO CLEANOUT

CW DOMESTIC COLD WATER
HW DOMESTIC HOT WATER
DN DOWN
DOE DEPARTMENT OF ENERGY
DS DOWNSPOUT
DWG DRAWING

EL ELEVATION
ESC ESCUTCHION
ET EXPANSION TANK
EWC ELECTRIC WATER COOLER
EWH ELECTRIC WATER HEATER
EWS EYE WASH STATION

F FAHRENHEIT
FOO FLOOR CLEANOUT
FD FLOOR DRAIN
FS FLOOR SINK
FU FIXTURE UNITS

GAL GALLON
GPM GALLONS PER MINUTE

HB HOSE BIBB
HD HUB DRAIN
HP HORSEPOWER

INV INVERT
IPC INTERNATIONAL PLUMBING CODE
IRW IRRIGATION WATER
IW INDIRECT WASTE
IWH INSTANTANEOUS WATER HEATER

KW KILOWATT
KWHR KILOWATT-HOUR

LAV LAVATORY
LBS/HR POUNDS PER HOUR

M METER
MBH 1000 BTUH
MH MANHOLE
MB MOP BASIN

NC NORMALLY CLOSED
NO NORMALLY OPEN
NOM. NOMINAL
NTC NOT TO SCALE

PD PRESSURE DROP OR DIFFERENCE
PDI PLUMBING AND DRAINAGE INSTITUTE
PG PRESSURE GAGE
PRV PRESSURE REDUCING VALVE
PSI POUNDS PER SQUARE INCH
PSIG POUNDS PER SQUARE INCH GAUGE

SAN SANITARY SEWER
SMACNA SHEET METAL AND AIR CONDITIONING CONTRACTORS NATIONAL ASSOCIATION
SCFM STANDARD CUBIC FOOT/MINUTE
SQFT SQUARE FEET
SK SINK

TD TEMPERATURE DIFFERENCE
TEMP TEMPERATURE
TSTAT THERMOSTAT
TYP TYPICAL

UPC UNIFORM PLUMBING CODE
V VENT
VTR VENT THROUGH ROOF

WC WATER CLOSET
WCO WALL CLEANOUT
WH WATER HEATER
WHA WATER HAMMER ARRESTER
WM WATER METER
WPD WATER PRESSURE DROP

YCO YARD CLEANOUT
YH YARD HYDRANT

HVAC ABBREVIATIONS

A/E ARCHITECT / ENGINEER
AB AIR BLENDER
AAV AUTOMATIC AIR VENT
ACC AIR COOLED CONDENSER
ADD ACCESS DOOR
AF AFTER FILTER
AFF ABOVE FINISHED FLOOR
AHU AIR-HANDLING UNIT
AP ACCESS PANEL
APD AIR PRESSURE DROP

BDD BACKDRAFT DAMPER
BFP BACKFLOW PREVENTER
BHP BREAK HORSEPOWER
BTU BRITISH THERMAL UNIT
BTUH BRITISH THERMAL UNIT PER HOUR

CC COOLING COIL
CFM CUBIC FEET PER MINUTE
CI CAST IRON
CO CLEAN OUT
COMP COMPRESSOR UNIT
COP COEFFICIENT OF PERFORMANCE
CR CEILING REGISTER
CU CONDENSING UNIT
CUH CABINET UNIT HEATER
CW COLD WATER (POTABLE)

D DAMPER -- AUTOMATIC
DB DECIBELS
Db DRY-BULB TEMPERATURE
DEG DEGREE
DIA DIAMETER
DP DEW POINT TEMPERATURE
DX DIRECT EXPANSION

EA EXHAUST AIR
EAT ENTERING AIR TEMPERATURE
EDU EVAPORATIVE CONDENSER UNIT
EDH ELECTRIC DUCT HEATER
EER ENERGY EFFICIENCY RATIO
EF EXHAUST FAN
EG EXHAUST GRILLE
EH EXHAUST HOOD
ERC ELECTRIC REHEAT COIL
ESP EXTERNAL STATIC PRESSURE
ET EXPANSION TANK
EUH ELECTRIC UNIT HEATER
EWC EVAPORATIVE WATER COOLER
EWT ENTERING WATER TEMPERATURE

F FAHRENHEIT
F/SDPR COMBINATION FIRE SMOKE DAMPER
FA FREE AREA
FC FLEXIBLE CONNECTION
FD FLOOR DRAIN
FD FIRE DAMPER
FPM FEET PER MINUTE
FPS FEET PER SECOND
FTTU FAN POWERED TERMINAL UNIT
FS FLOW SWITCH
FSTAT FREEZE/STAT
FT FEET
FT-LB FOOT-POUND
FV FACE VELOCITY

GA GAUGE
GH GRAVITY HOOD
GPD GALLONS PER DAY
GPM GALLONS PER MINUTE

HW HOT WATER
HAC HOUSEKEEPING AID CLOSET
HB HOSE BIBB
HC HEATING COIL
HOA HAND/OFF/AUTOMATIC
HP HEAT PUMP
HP HORSEPOWER
HPS HIGH PRESSURE SUPPLY (STEAM)
HW HOT WATER
HX HEAT EXCHANGER
HZ HERTZ

I/O INPUT/OUTPUT
IAQ INDOOR AIR QUALITY
IN WC INCH WATER COLUMN
KW KILOWATT

LAT LEAVING AIR TEMPERATURE
LB/HR POUNDS PER HOUR
LSD LINEAR SLOT DIFFUSER
LVR LOUVER
LWT LEAVING WATER TEMPERATURE

M METER
MA MIXED AIR
MAT MIXED AIR TEMPERATURE
MAU MAKE-UP AIR UNIT
MBH 1000 BTUH
MERV MINIMUM EFFICIENCY REPORTING VALVE
MHP MOTOR HORSEPOWER
MIN MINIMUM
MYD MANUAL VOLUME DAMPER

NA NOT APPLICABLE
NC NOISE CRITERIA
NC NORMALLY CLOSED
NO NORMALLY OPEN
NOM NOMINAL
NTS NOT TO SCALE
OA OUTSIDE AIR

PD PRESSURE DROP
PF PRE-FILTER
PG PRESSURE GAGE
PHC PREHEAT COIL
PSI POUNDS PER SQUARE INCH

RA RETURN AIR
RG RETURN GRILLE
RH RELATIVE HUMIDITY


SA SUPPLY AIR
SAT SUPPLY AIR TEMPERATURE
SD SUPPLY AIR DIFFUSER
SEN SENSIBLE HEAT
SF SUPPLY FAN
SG SUPPLY AIR GRILLE
SI SQUARE INCHES
SP STATIC PRESSURE

TAB TESTING, ADJUSTING, BALANCE
TD TEMPERATURE DIFFERENCE
TSP TOTAL STATIC PRESSURE
TSTAT THERMOSTAT


GENERAL NOTES

- ALL PIPING AND DUCTS IN FINISHED ROOMS OR SPACES SHALL BE CONCEALED IN A FURRED CHASE OR ABOVE THE HARD SUSPENDED CEILING.
- THE FIRST FIGURE OF DUCT SIZE INDICATES DIMENSION OF FACE SHOWN OR INDICATED. DUCT SIZES ARE NET INSIDE DIMENSIONS.
- ACCESS PANELS IN HARD SUSPENDED CEILINGS ARE REQUIRED FOR ALL VALVES, TRAPS, DAMPERS, CLEANOUTS, CONTROLS, ETC. ACCESS PANELS SHALL BE FURNISHED AND INSTALLED UNDER THE ARCHITECTURAL SPECIFICATIONS.
- EXTERNAL STATIC PRESSURE NOTED IN THE SCHEDULES INCLUDES DUCT SYSTEM, AND FILTER LOADING. IT DOES NOT INCLUDE INTERNAL EQUIPMENT COMPONENTS. TERMINAL
- REFER TO ARCHITECTURAL REFLECTED CEILING PLANS FOR EXACT LOCATIONS OF CEILING DIFFUSERS, REGISTERS, AND GRILLES.


DRAWING SYMBOLS

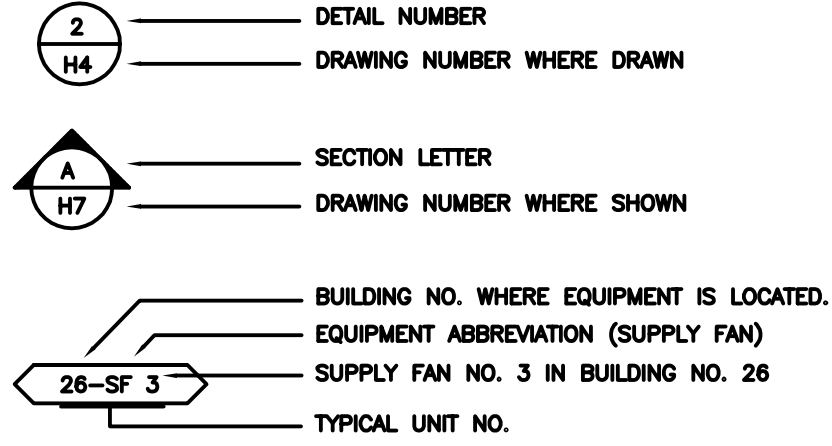

PIPING SYMBOLS

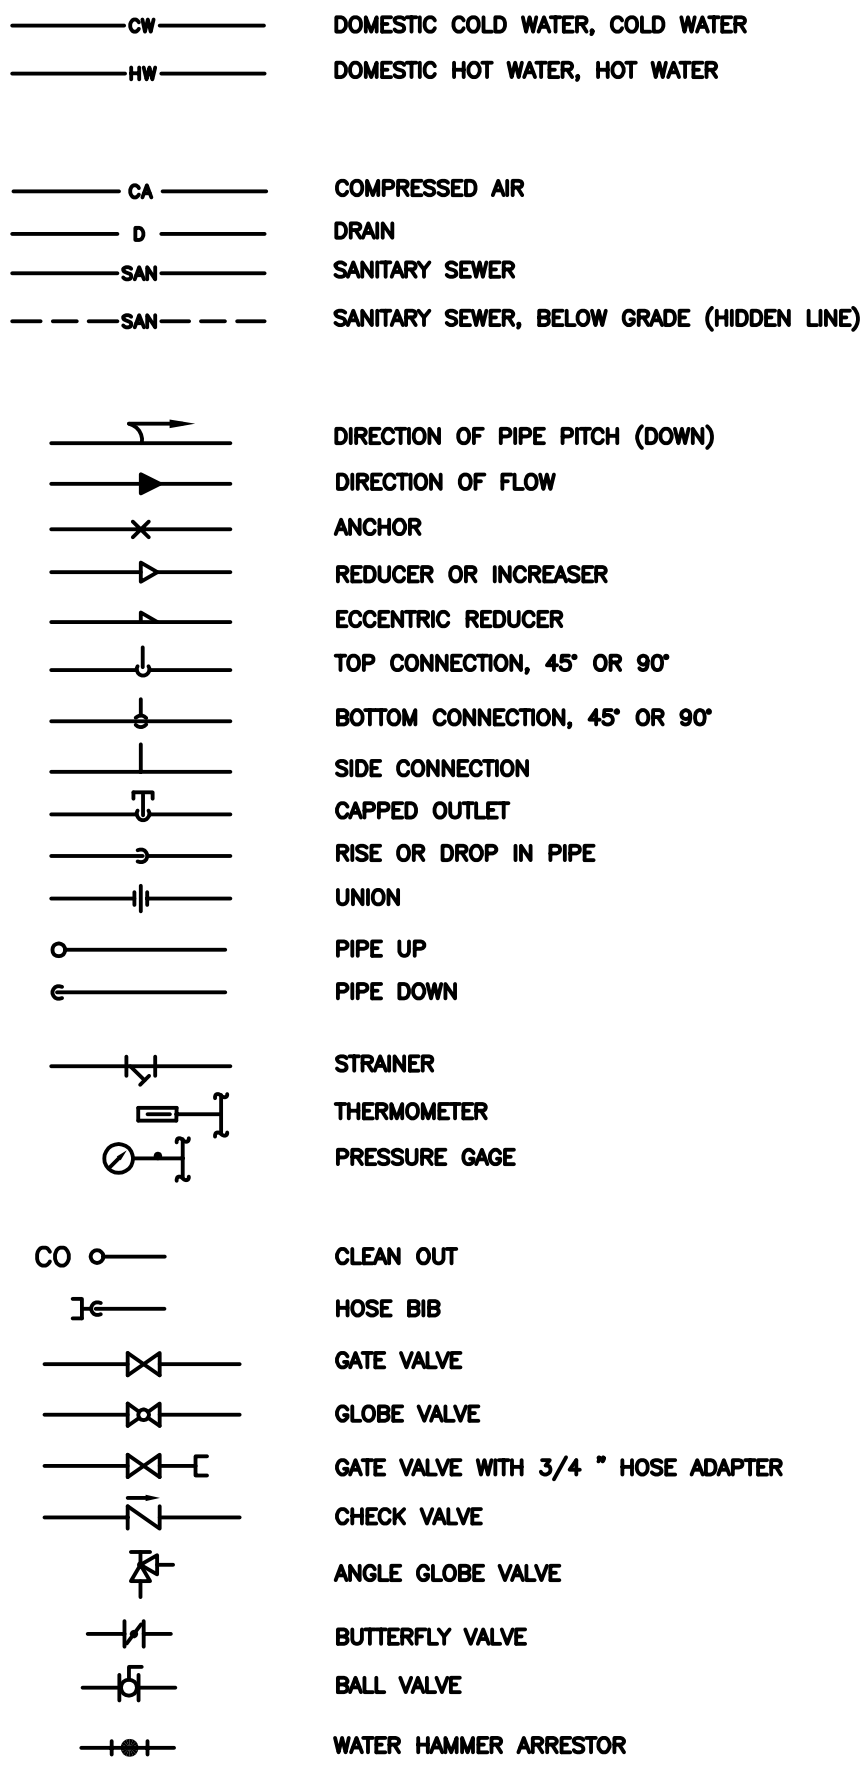

DUCTWORK SYMBOLS

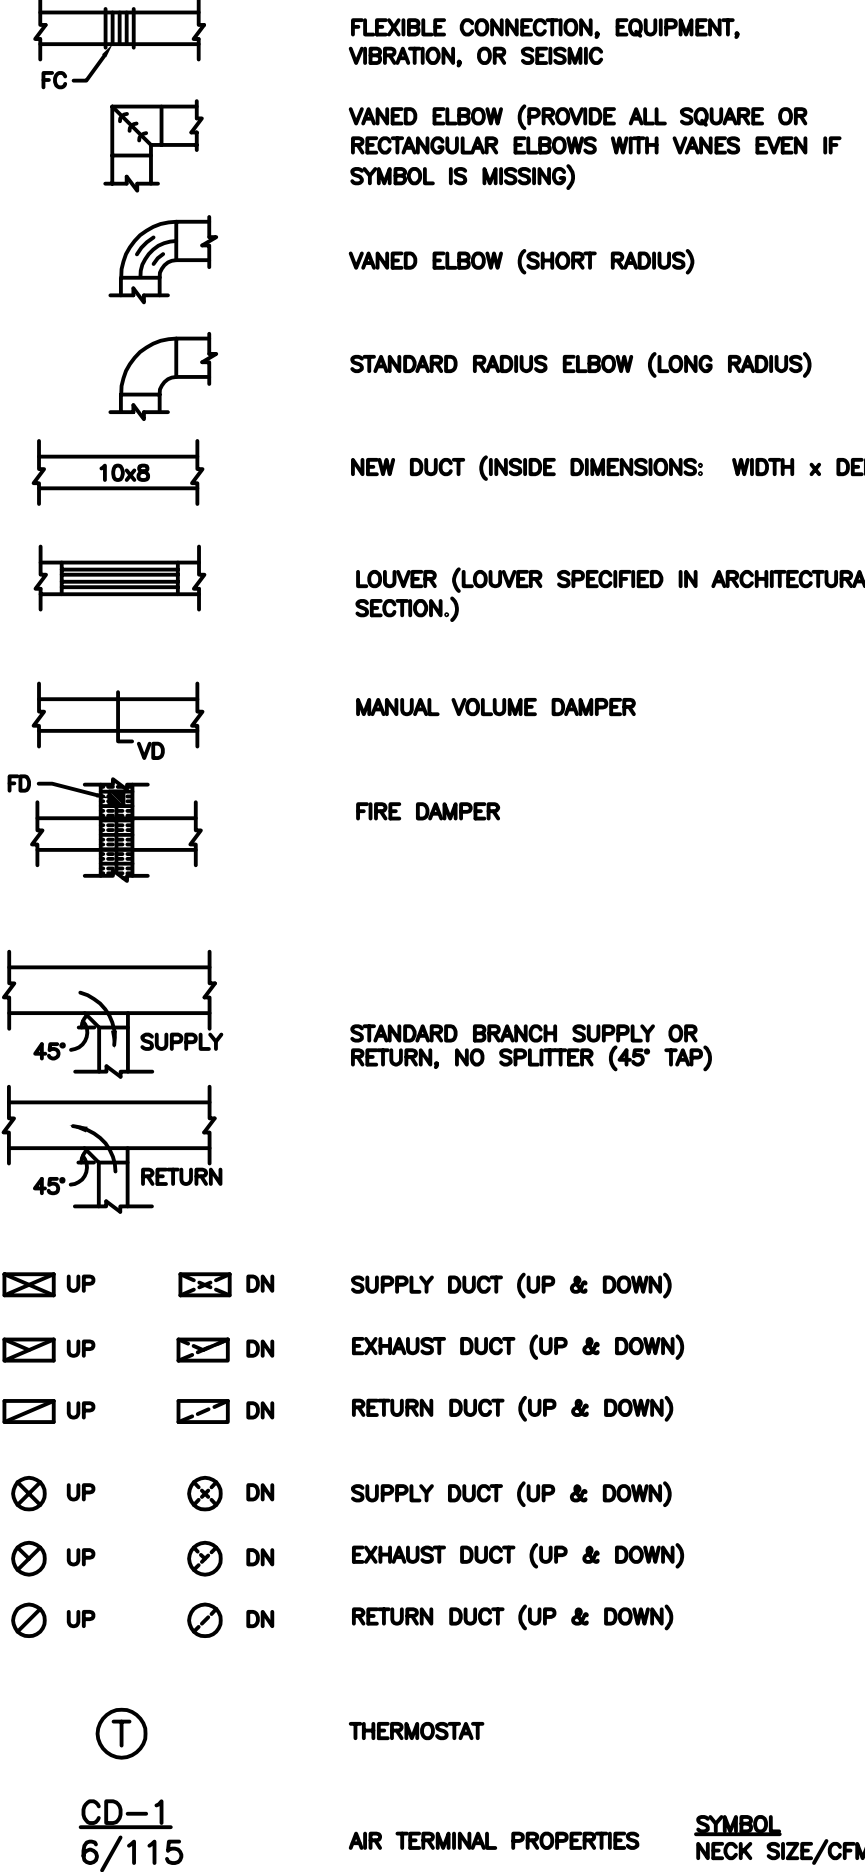

BID DOCUMENTS 7/1/2011

Anderson Engineering of Minnesota, LLC

13605 1st AVENUE NORTH, SUITE 100, PLYMOUTH, MN 55441
TEL (763) 412-4000 FAX (763) 412-4090
www.ae-mn.com



NATIONAL
CEMETERY
ADMINISTRATION

MECHANICAL GENERAL NOTES -
VEHICLE STORAGE

Approved: Director, Office of Construction Management
Approved: Director, Project Management Service

REPLACE ADMINISTRATION AND
MAINTENANCE BUILDING
AND SITE IMPROVEMENTS

Building Number
3003
Checked
DavBod
Drawn
JamTho
Location
EAGLE POINT NATIONAL CEMETERY
2763 RILEY ROAD
EAGLE POINT, OR 97524

Date
7-1-2011

Project No.
906CM3009

DRAWING NO.

H-3003-01

Dwg. 167 OF 181

KJ
W ENGINEERING
CONSULTANTS
Experience you can build on.
623 26TH AVENUE
ROCK ISLAND, IL 61201
309.786.0673 FAX: 309.786.5967
www.kjw.com
KJW Project # 10.0356.00
STRUCTURAL / MECHANICAL / ELECTRICAL /
TECHNOLOGY / MEDICAL EQUIPMENT SOLUTIONS

I hereby certify that this Plan, Specification, or Report was prepared
by me, or under my direct supervision and that I am a duly licensed
Professional Engineer under the laws of the State of Oregon.
Signature: Warren L. Lloyd
Discipline: Mechanical
Oregon Registration No. 78701PE Expiration date: 12.31.12
Date Issued: **/**/11