


ENVIRONMENT OF CARE UPGRADES

BUILDING SCHEDULE	
NO	NAME
2	DORMITORY
3	DUPLEX QUARTERS
4	DUPLEX QUARTERS
5	DUPLEX QUARTERS
11	DUPLEX QUARTERS
12	DUPLEX QUARTERS
13	DUPLEX QUARTERS
14	SINGLE QUARTERS
15	POWDER MAGAZINE
16	FIRE STATION
17	WAREHOUSE
20	ENGR. SHOPS
31	ENGINEER'S HOUSE
35	MANAGERS QUARTERS
41	SINGLE QUARTERS
42	SINGLE QUARTERS
43	SINGLE
47	SUPPLY STORAGE
52	FLAG POLE & MEMORIAL
54	MISC. STORAGE
141	ADMINISTRATION BUILDING
142	HEATING PLANT
144	7-CAR GARAGE
145	SINGLE GARAGE
146	7-CAR GARAGE
150	DICTETICS
151	GAS METER HOUSE
152	RESERVOIR "IRRIGATION"
153	WATER TOWER
154	WATER TOWER
154A	WATER TOWER
155	BULK OXYGEN STORAGE
156	GENERATOR HOUSE
157	HIGH VOLTAGE SWITCH GEAR
158	GENERATOR HOUSE
159	BOOSTER PUMP HOUSE
160	WELL VALVE HOUSE
161	RESERVOIR "DOMESTIC WATER"
162	GARAGE
163	DOMESTIC WATER METER VAULT
164	DOMESTIC WATER METER VAULT
165	PRV VAULT
166	HAZARDOUS WASTE
167	VBA REGIONAL OFFICE BLDG
168	LIBERTY HOUSE

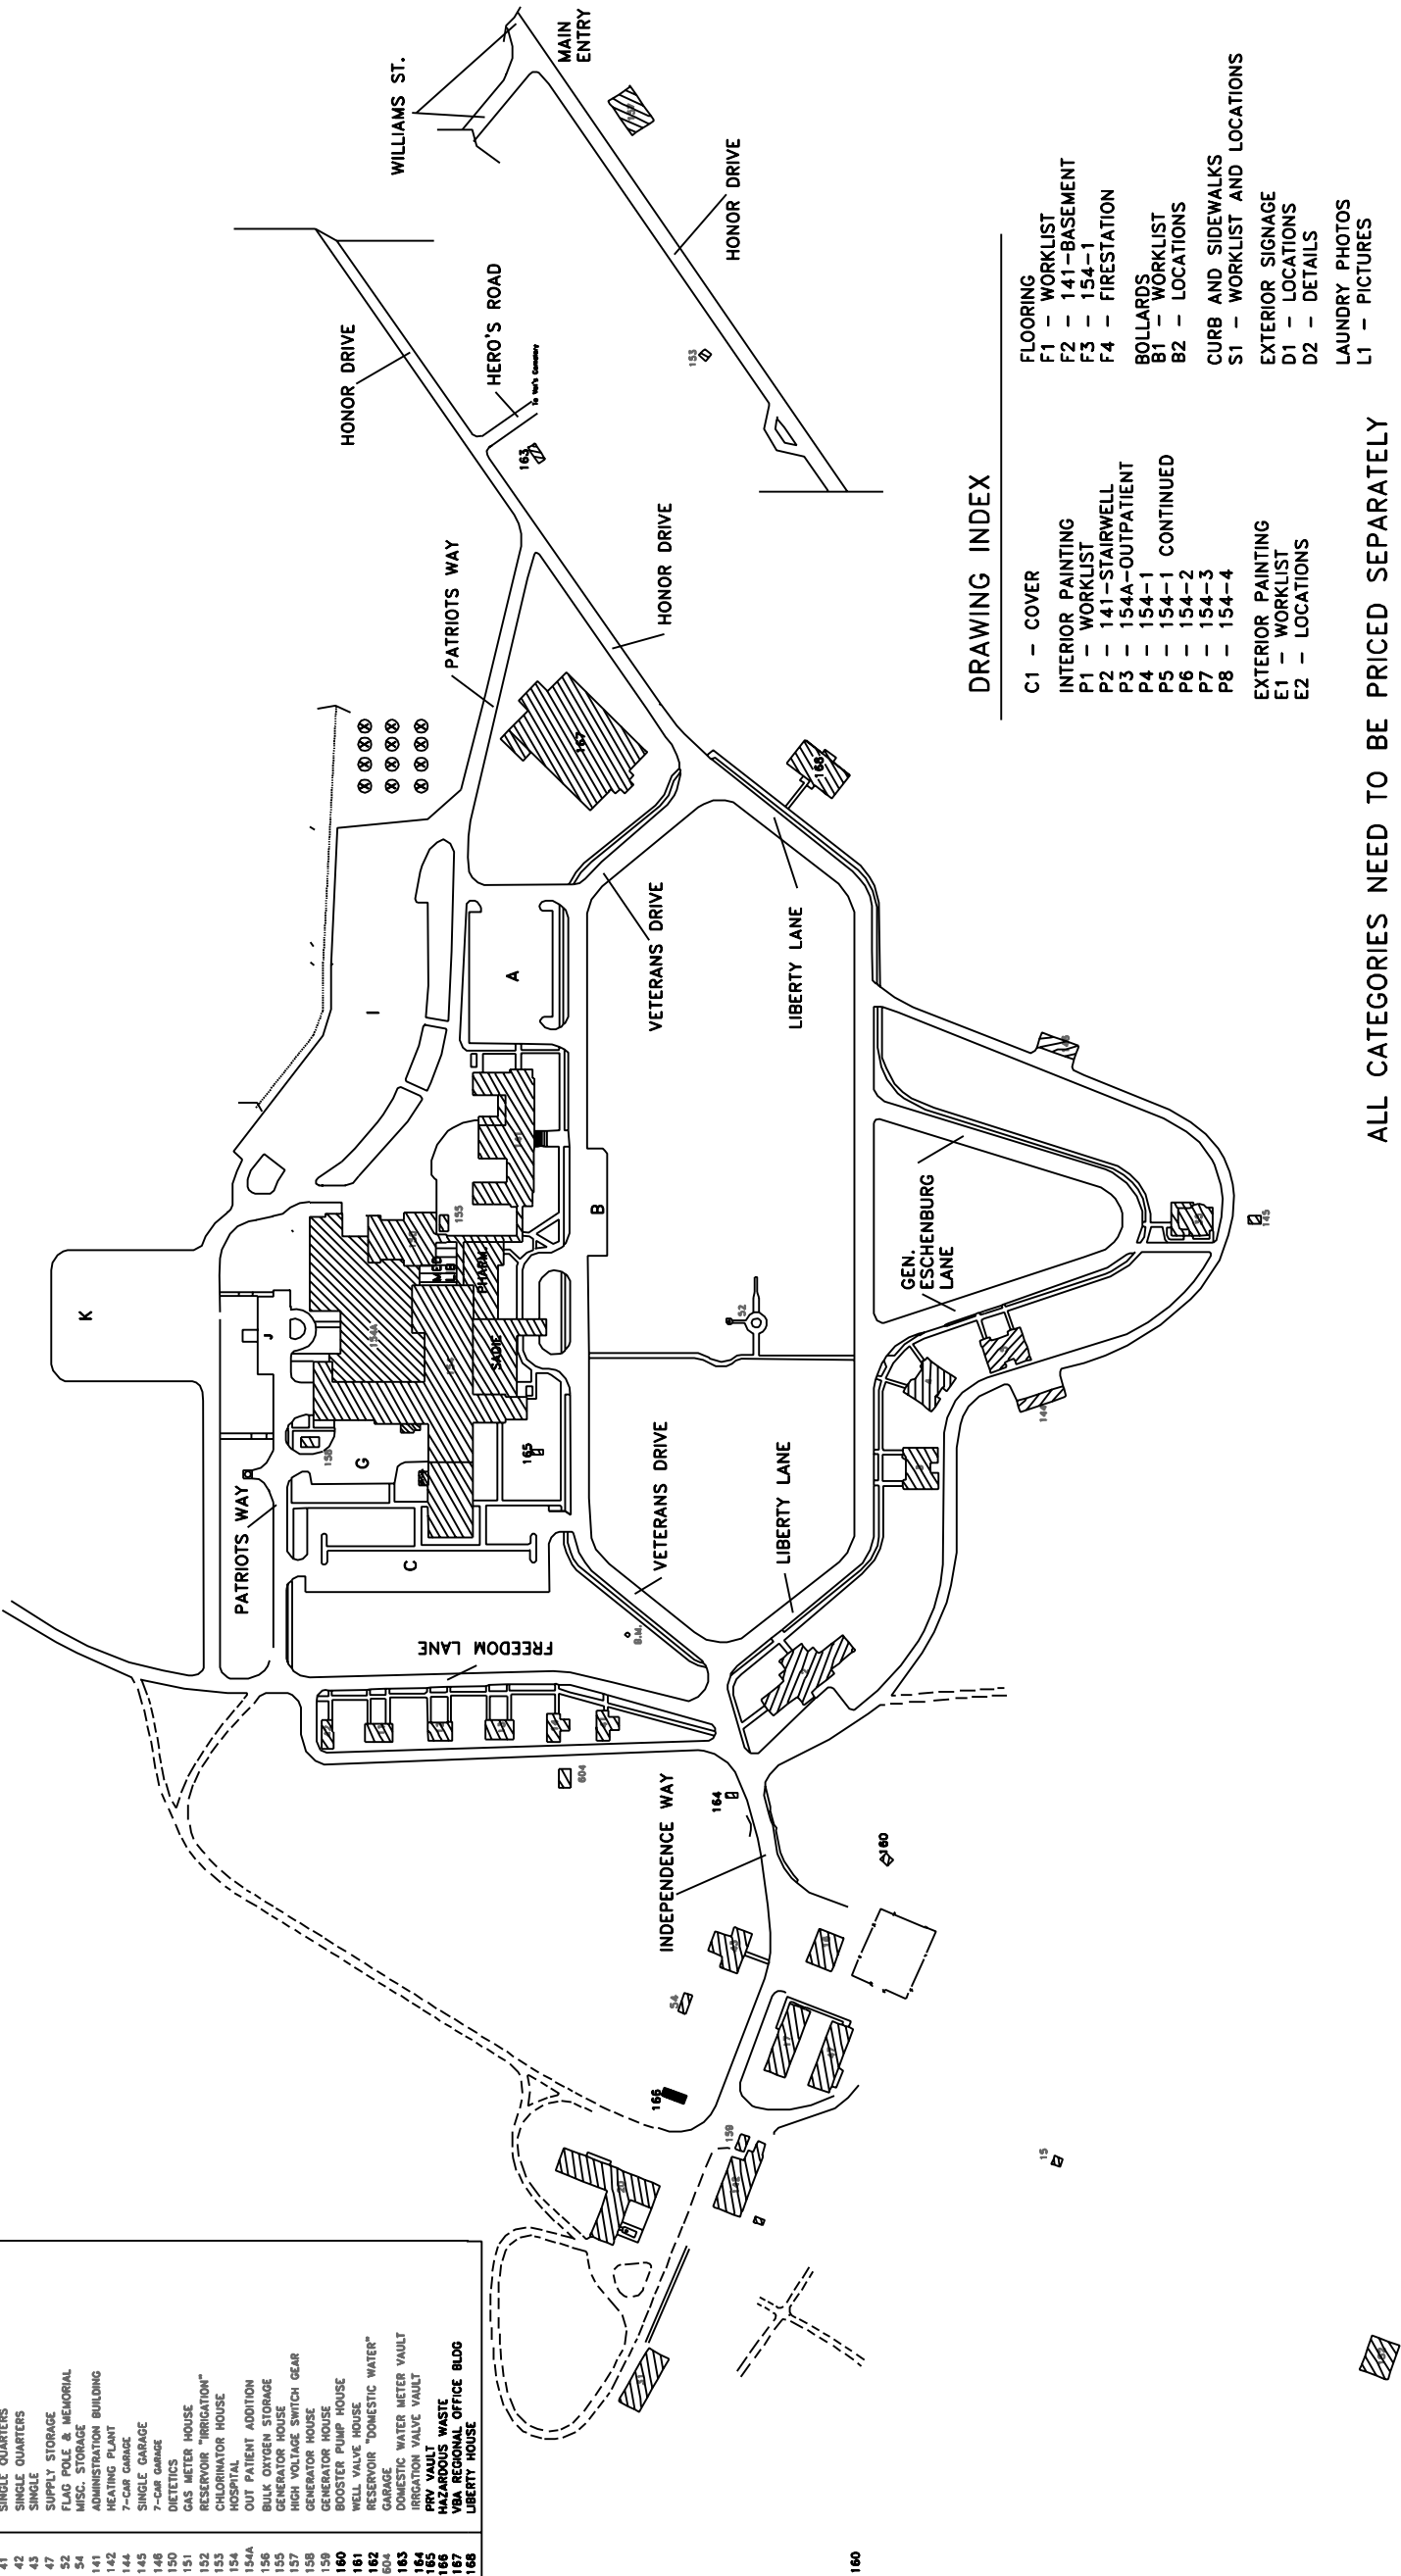

DRAWING INDEX

- C1 - COVER

INTERIOR PAINTING

P1 - WORKLIST

P2 - 141-STAIRWELL

P3 - 154A-OUTPATIENT

P4 - 154-1

P5 - 154-1 CONTINUED

P6 - 154-2

P7 - 154-3

P8 - 154-4
- FLOORING

F1 - WORKLIST

F2 - 141-BASEMENT

F3 - 154-1

F4 - FIRESTATION
- BOLLARDS

B1 - WORKLIST

B2 - LOCATIONS
- CURB AND SIDEWALKS

S1 - WORKLIST AND LOCATIONS
- EXTERIOR PAINTING

E1 - WORKLIST

E2 - LOCATIONS
- LAUNDRY PHOTOS

L1 - PICTURES

ALL CATEGORIES NEED TO BE PRICED SEPARATELY
WITHIN EACH CATEGORY, SEE SPECS FOR ALTERNATES

VA MONTANA HEALTHCARE SYSTEM
FT. HARRISON, MT

Revisions	Drawing Title		Project Title		Date
	SITE PLAN		ENVIRONMENT OF CARE UPGRADES		9/4/08
	APPROVED:DIRECTOR		Building Number		Project No.
	CONSTRUCTION/ENGINEERING		154		436-07-118
Date		Location		Drawing NO.	
		FT HARRISON, MT		COVER	
				Dwg 1 Of 21	