

three eighths inch = one foot
one eighth inch = one foot
one quarter inch = one foot
one half inch = one foot
three quarters inch = one foot
one inch = one foot
one and one half inches = one foot
two inches = one foot
three inches = one foot
four inches = one foot
five inches = one foot
six inches = one foot
seven inches = one foot
eight inches = one foot
nine inches = one foot
ten inches = one foot
eleven inches = one foot
twelve inches = one foot
thirteen inches = one foot
fourteen inches = one foot
fifteen inches = one foot
sixteen inches = one foot
seventeen inches = one foot
eighteen inches = one foot
nineteen inches = one foot
twenty inches = one foot
twenty one inches = one foot
twenty two inches = one foot
twenty three inches = one foot
twenty four inches = one foot
twenty five inches = one foot
twenty six inches = one foot
twenty seven inches = one foot
twenty eight inches = one foot
twenty nine inches = one foot
thirty inches = one foot
thirty one inches = one foot
thirty two inches = one foot
thirty three inches = one foot
thirty four inches = one foot
thirty five inches = one foot
thirty six inches = one foot
thirty seven inches = one foot
thirty eight inches = one foot
thirty nine inches = one foot
forty inches = one foot
forty one inches = one foot
forty two inches = one foot
forty three inches = one foot
forty four inches = one foot
forty five inches = one foot
forty six inches = one foot
forty seven inches = one foot
forty eight inches = one foot
forty nine inches = one foot
fifty inches = one foot
fifty one inches = one foot
fifty two inches = one foot
fifty three inches = one foot
fifty four inches = one foot
fifty five inches = one foot
fifty six inches = one foot
fifty seven inches = one foot
fifty eight inches = one foot
fifty nine inches = one foot
sixty inches = one foot
sixty one inches = one foot
sixty two inches = one foot
sixty three inches = one foot
sixty four inches = one foot
sixty five inches = one foot
sixty six inches = one foot
sixty seven inches = one foot
sixty eight inches = one foot
sixty nine inches = one foot
seventy inches = one foot
seventy one inches = one foot
seventy two inches = one foot
seventy three inches = one foot
seventy four inches = one foot
seventy five inches = one foot
seventy six inches = one foot
seventy seven inches = one foot
seventy eight inches = one foot
seventy nine inches = one foot
eighty inches = one foot
eighty one inches = one foot
eighty two inches = one foot
eighty three inches = one foot
eighty four inches = one foot
eighty five inches = one foot
eighty six inches = one foot
eighty seven inches = one foot
eighty eight inches = one foot
eighty nine inches = one foot
ninety inches = one foot
ninety one inches = one foot
ninety two inches = one foot
ninety three inches = one foot
ninety four inches = one foot
ninety five inches = one foot
ninety six inches = one foot
ninety seven inches = one foot
ninety eight inches = one foot
ninety nine inches = one foot
one hundred inches = one foot

- KEYED NOTES

①

REBALANCE EXISTING GRILLE TO 100 CFM.

②

14x14 EXHAUST DUCT UP TO NEW EXHAUST FAN, 160-EF21 ON ROOF.

③

CAP EXISTING EXHAUST DUCT.

④


10x12 EXHAUST DUCT UP TO NEW EXHAUST FAN, 160-EF22 ON ROOF.

⑤


10x10 EXHAUST DUCT UP TO NEW EXHAUST FAN, 160-EF23 ON ROOF.

GENERAL NOTES

A. REFER TO PHASING SHEETS FOR SEQUENCE OF WORK.

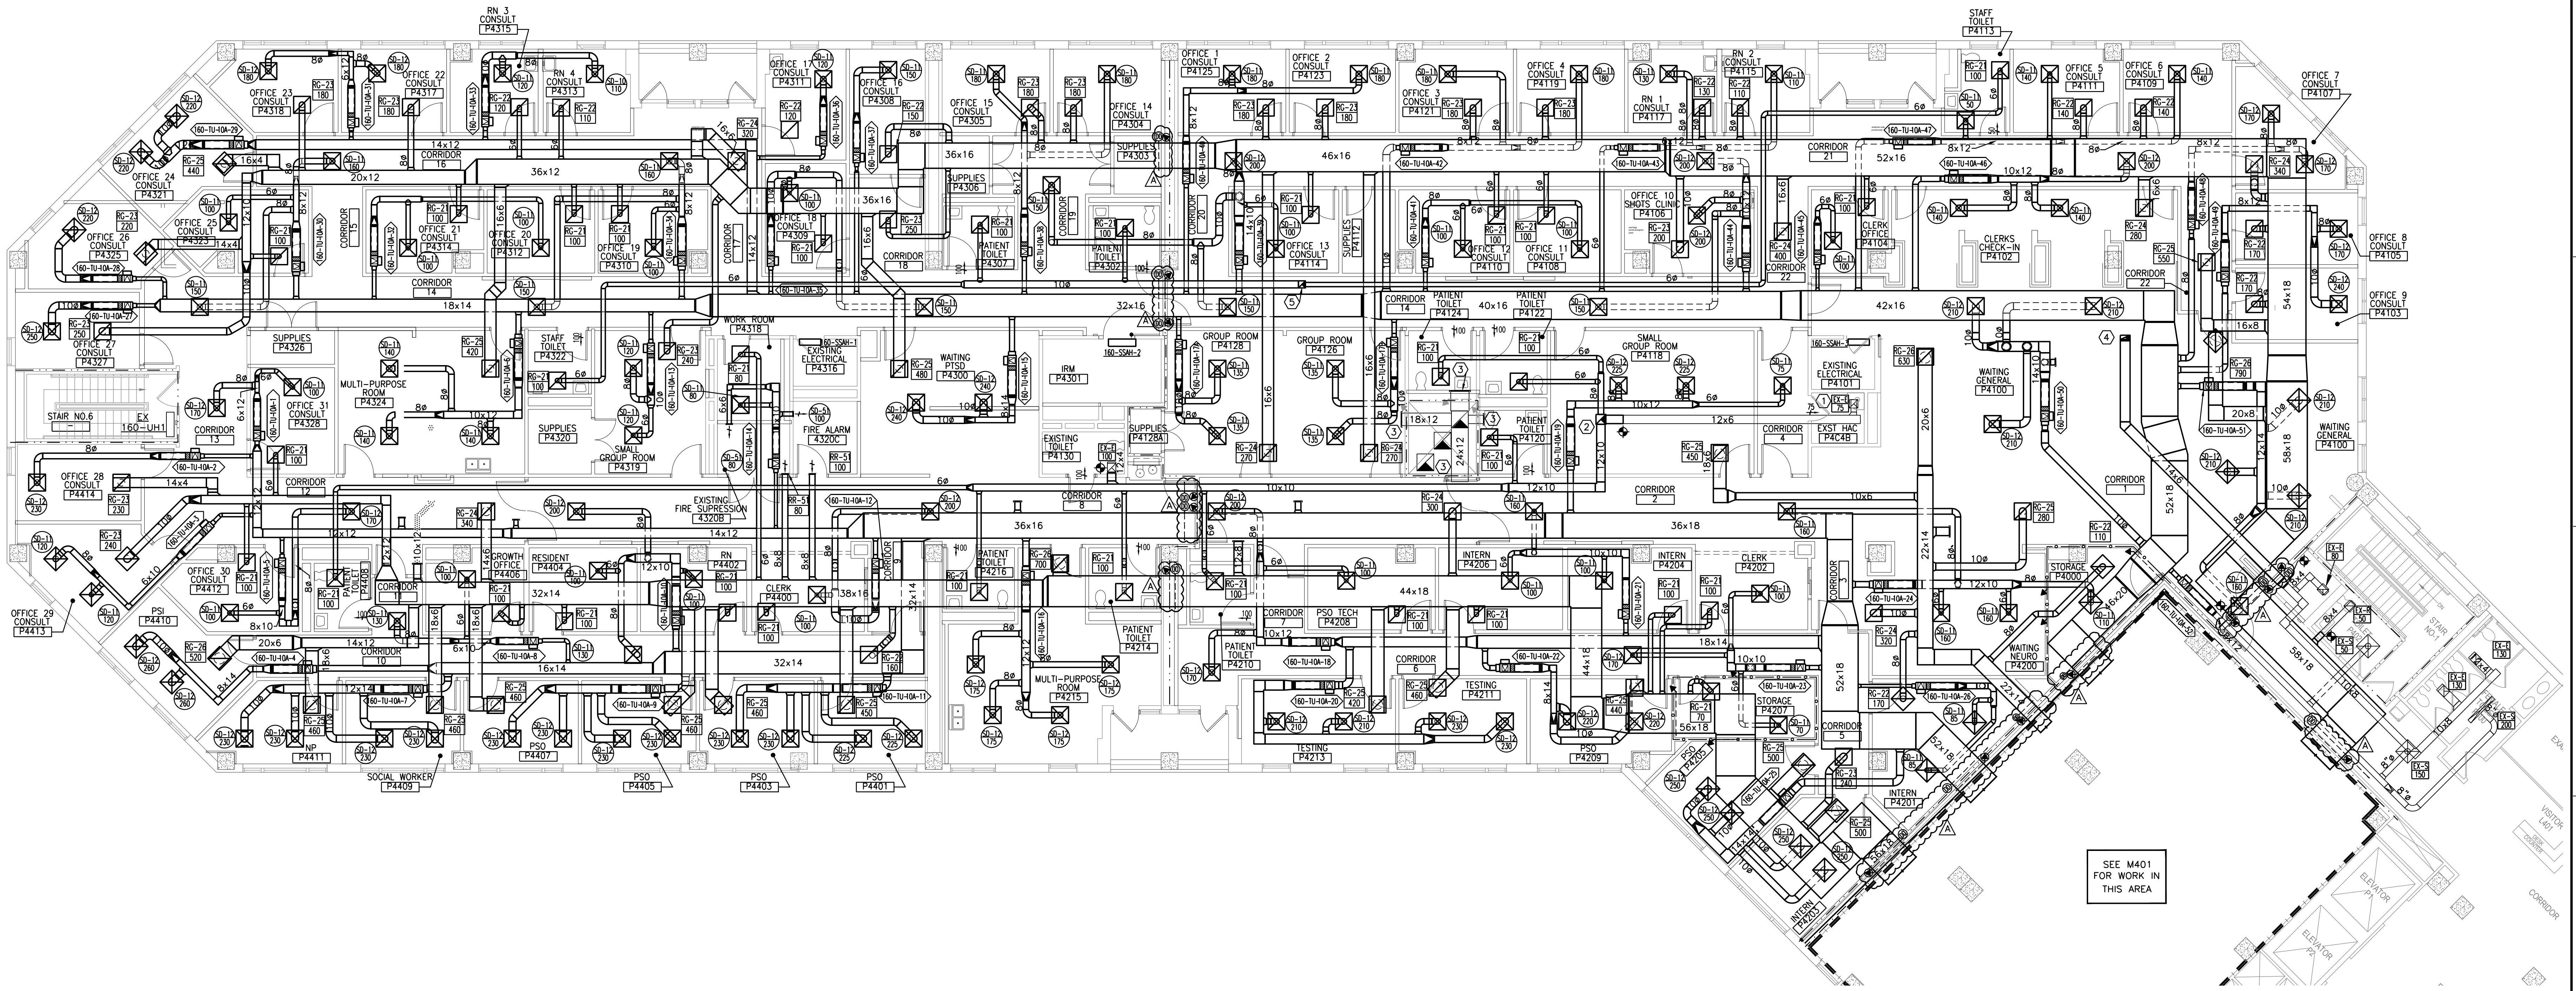

① MECHANICAL THIRD FLOOR PLAN NEW DUCTWORK
SCALE: 1/8" = 1'-0"

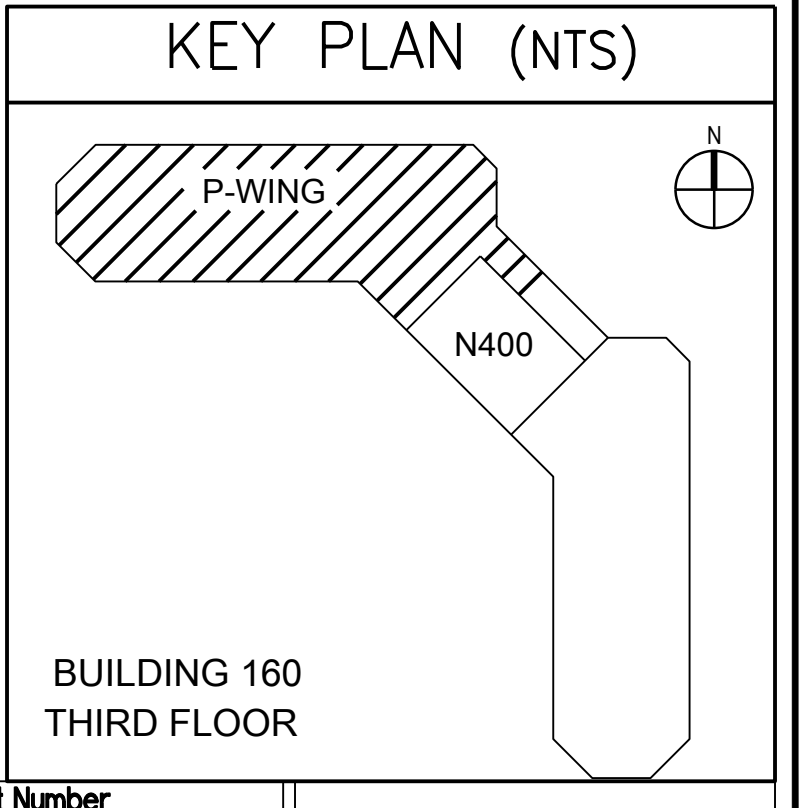

CONSULTANTS: <div><div>FreemanWhite 8845 Red Oak Blvd. Charlotte, NC 28217-5593 Phone: 704.523.2230 Fax: 704.523.2235</div><div>LeGrand Engineering, Inc. 215 Park Ave SE Aiken, SC 29801 Phone: 803.502.0657 Fax: 803.643.4648</div></div>		ARCHITECT/ENGINEERS: <div><div>Atriax, pllc 102 3rd Avenue, NE PO Box 1629, Hickory, NC 28603 Phone: 828.315.9962 Fax: 828.315.9964 www.atriaxgroup.com NC Engineering License No.: P-0214 NC Architectural License No.: 51254</div><div></div></div>		Drawing Title MECHANICAL THIRD FLOOR PLAN NEW DUCTWORK Approved Project Director		Project Title RENOVATE P-SIDE FOR SUPER POD PHASE 2 Location J.H. QUILLEN VAMC MTN. HOME TN Date DECEMBER 21, 2015 Checked AGT Drawn AGT		Project Number 621-15-120 Building Number 160 Drawing Number MH101 Dwg. 73 of 118		Office of Construction and Facilities Management 	
---	--	---	--	---	--	---	--	--	--	---	--