



three inches = one foot
one and one half inch = one foot
one inch = one foot
three-quarters inch = one foot
one-half inch = one foot
three-eighths inch = one foot
one-quarter inch = one foot
one-eighth inch = one foot

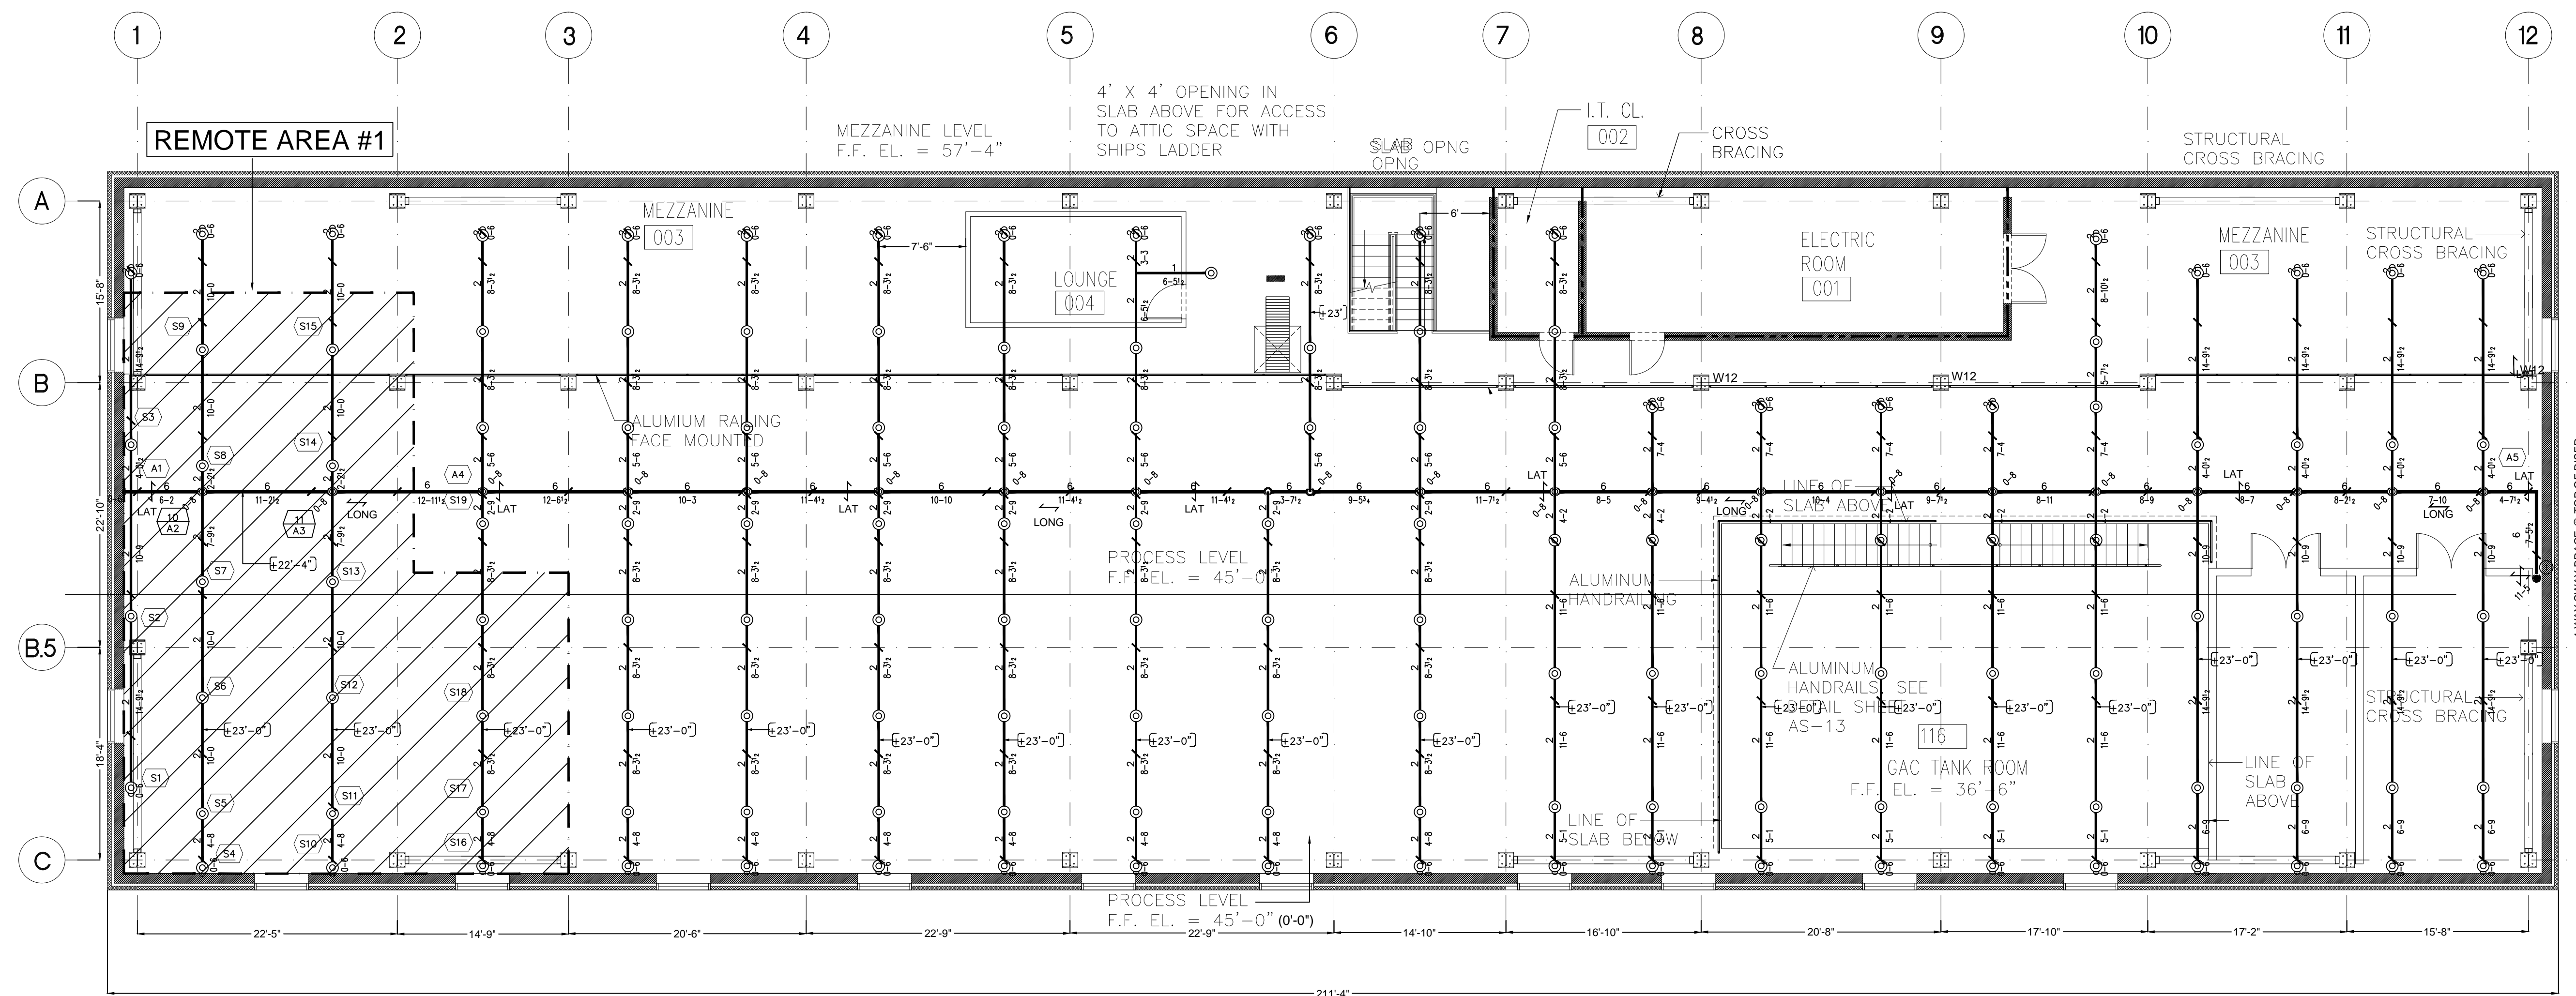

FIRE SPRINKLER @ ROOF LEVEL
SCALE: 1/8" = 1'-0"

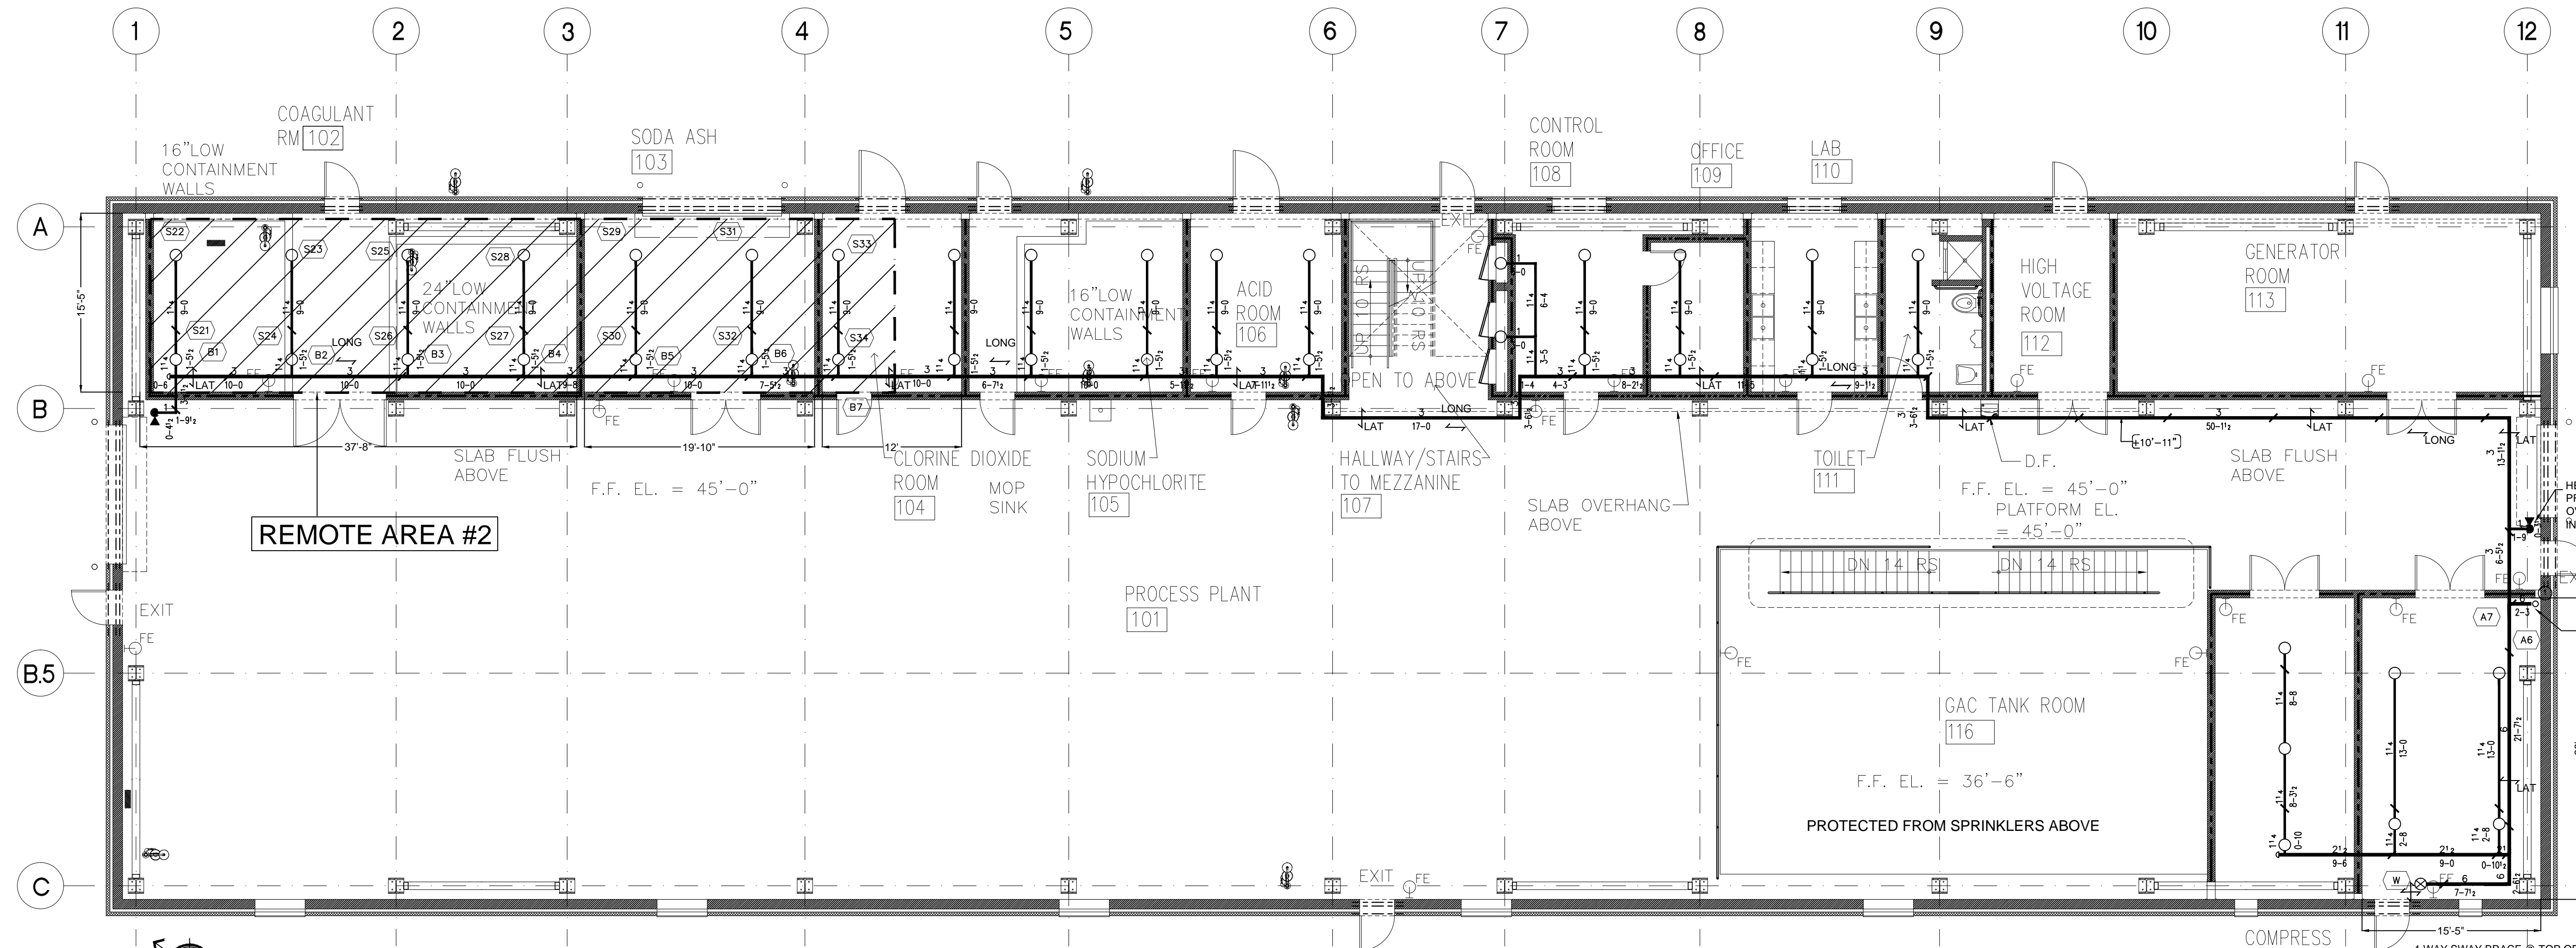


FIRE SPRINKLER @ FLOOR LEVEL
SCALE: 1/8" = 1'-0"

Fully Sprinklered	
Additions:	Date:
Revisions:	

DCS Infrastructure, LLC

3249 route 112, building 4 suite 1B
Medford, N.Y. 11763

631-320-1706

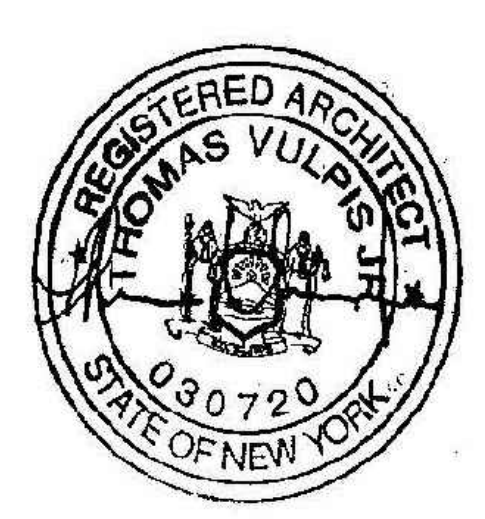

Approved:	Approved: Chief, Facilities and Engineering:
	Approved: Associate Chief for Maintenance And Operations, Perry Point:
	Approved: Engineering Projects Supervisor
	Approved: Infection Control Officer

Drawing Title:
FIRE SPRINKLER PLAN

Approved: Associate Director for Operations:

Approved: Director, Medical Center:

Project Title:
POTABLE WATER
SYSTEM IMPROVEMENTS - TIER 1
PERRY POINT MD
VAMC

Scale: 103

Building No: 103

Checked: DS

Drawn: SEAN

Location:
VAMC PERRY POINT, MD 21902

Date:
9/1/2015

Project No:
512A5-13-329

DRAWING NO:
FP-002

83A0F 124

