


three inches = one foot
one and one half inches = one foot
one inch = one foot
three quarters inch = one foot
one half inch = one foot
three eighths inch = one foot
one quarter inch = one foot
one eighth inch = one foot

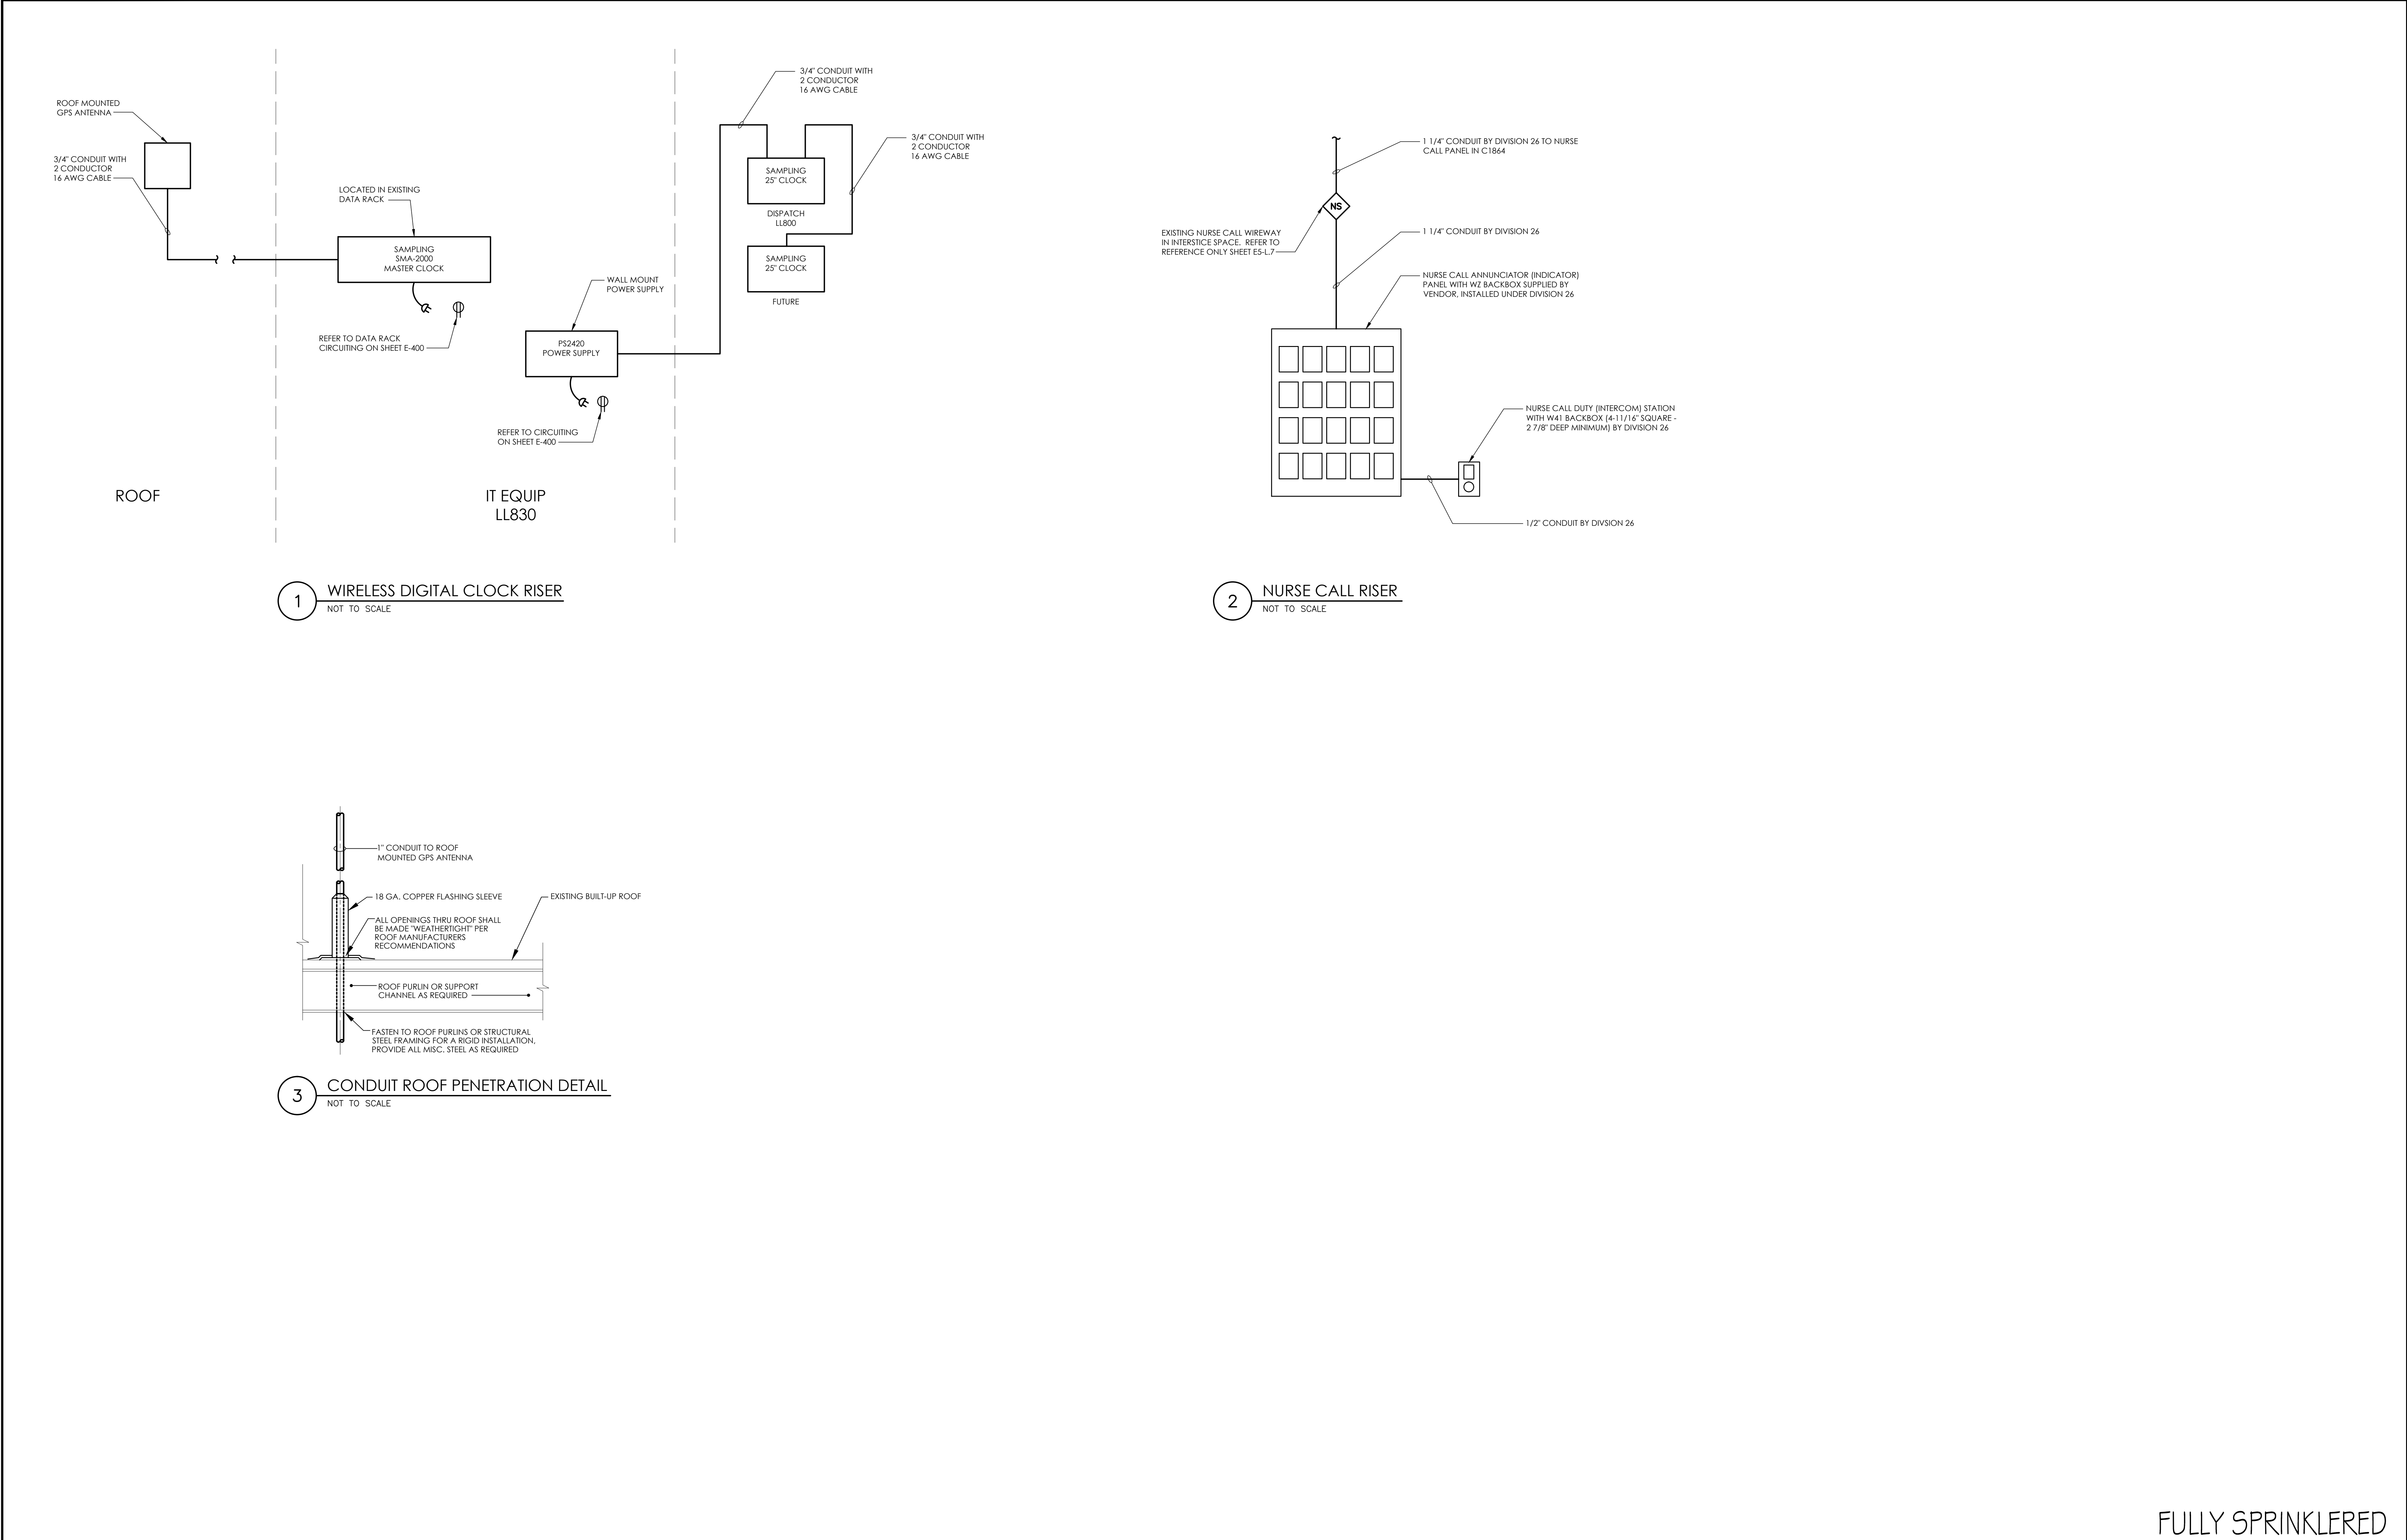

ISSUE 006 - CD BID	01.20.11
ISSUE 005 - CD OWNER REVIEW	12.17.10
ISSUE 004 - DESIGN DEVELOPMENT RECORD	11.12.10
ISSUE 003 - DESIGN DEVELOPMENT REVIEW	09.08.10
Revisions:	Date

KEY PLAN

US DEPARTMENT OF VETERANS AFFAIRS
JOHN D. DINGELL
VA MEDICAL CENTER
4646 JOHN R. STREET
DETROIT, MI 48202

ARCHITECT/ENGINEERS:

Albert Kahn Associates, Inc.
Albert Kahn Building
7430 Second Ave.
Detroit, Michigan 48202-2798
Albert Kahn Associates, Inc. is a member of
the Albert Kahn Family of Companies. © 2007
ALBERT KAHN JOB # 03988-00.000

Drawing Title	
COMMUNICATION RISERS	
Approved Project Director	

Project Title	
POLICE SERVICES RELOCATION	
Location	
DETROIT, MICHIGAN	
Date	Checked
01-20-2011	-
Drawn	Drawn
-	-

Project Number
553-11-108
Building Number
100
Drawing Number
EY-500
Dwg. 50 of 50

Office of Construction and Facilities Management

FULLY SPRINKLERED