

A
B
C
D
E
F

three inches = one foot

one and one half inches = one foot

one inch = one foot

three quarters inch = one foot

one half inch = one foot



three eighths inch = one foot

one quarter inch = one foot

one eighth inch = one foot


GENERAL NOTES

- REFER TO SYMBOLS AND ABBREVIATIONS LISTS ON SHEET NO. E-001.
- REFER TO MOUNTING HEIGHTS AND ELECTRICAL NOTES ON SHEET NO. E-001.
- REFER TO SPECIFICATIONS FOR ADDITIONAL ELECTRICAL REQUIREMENTS.

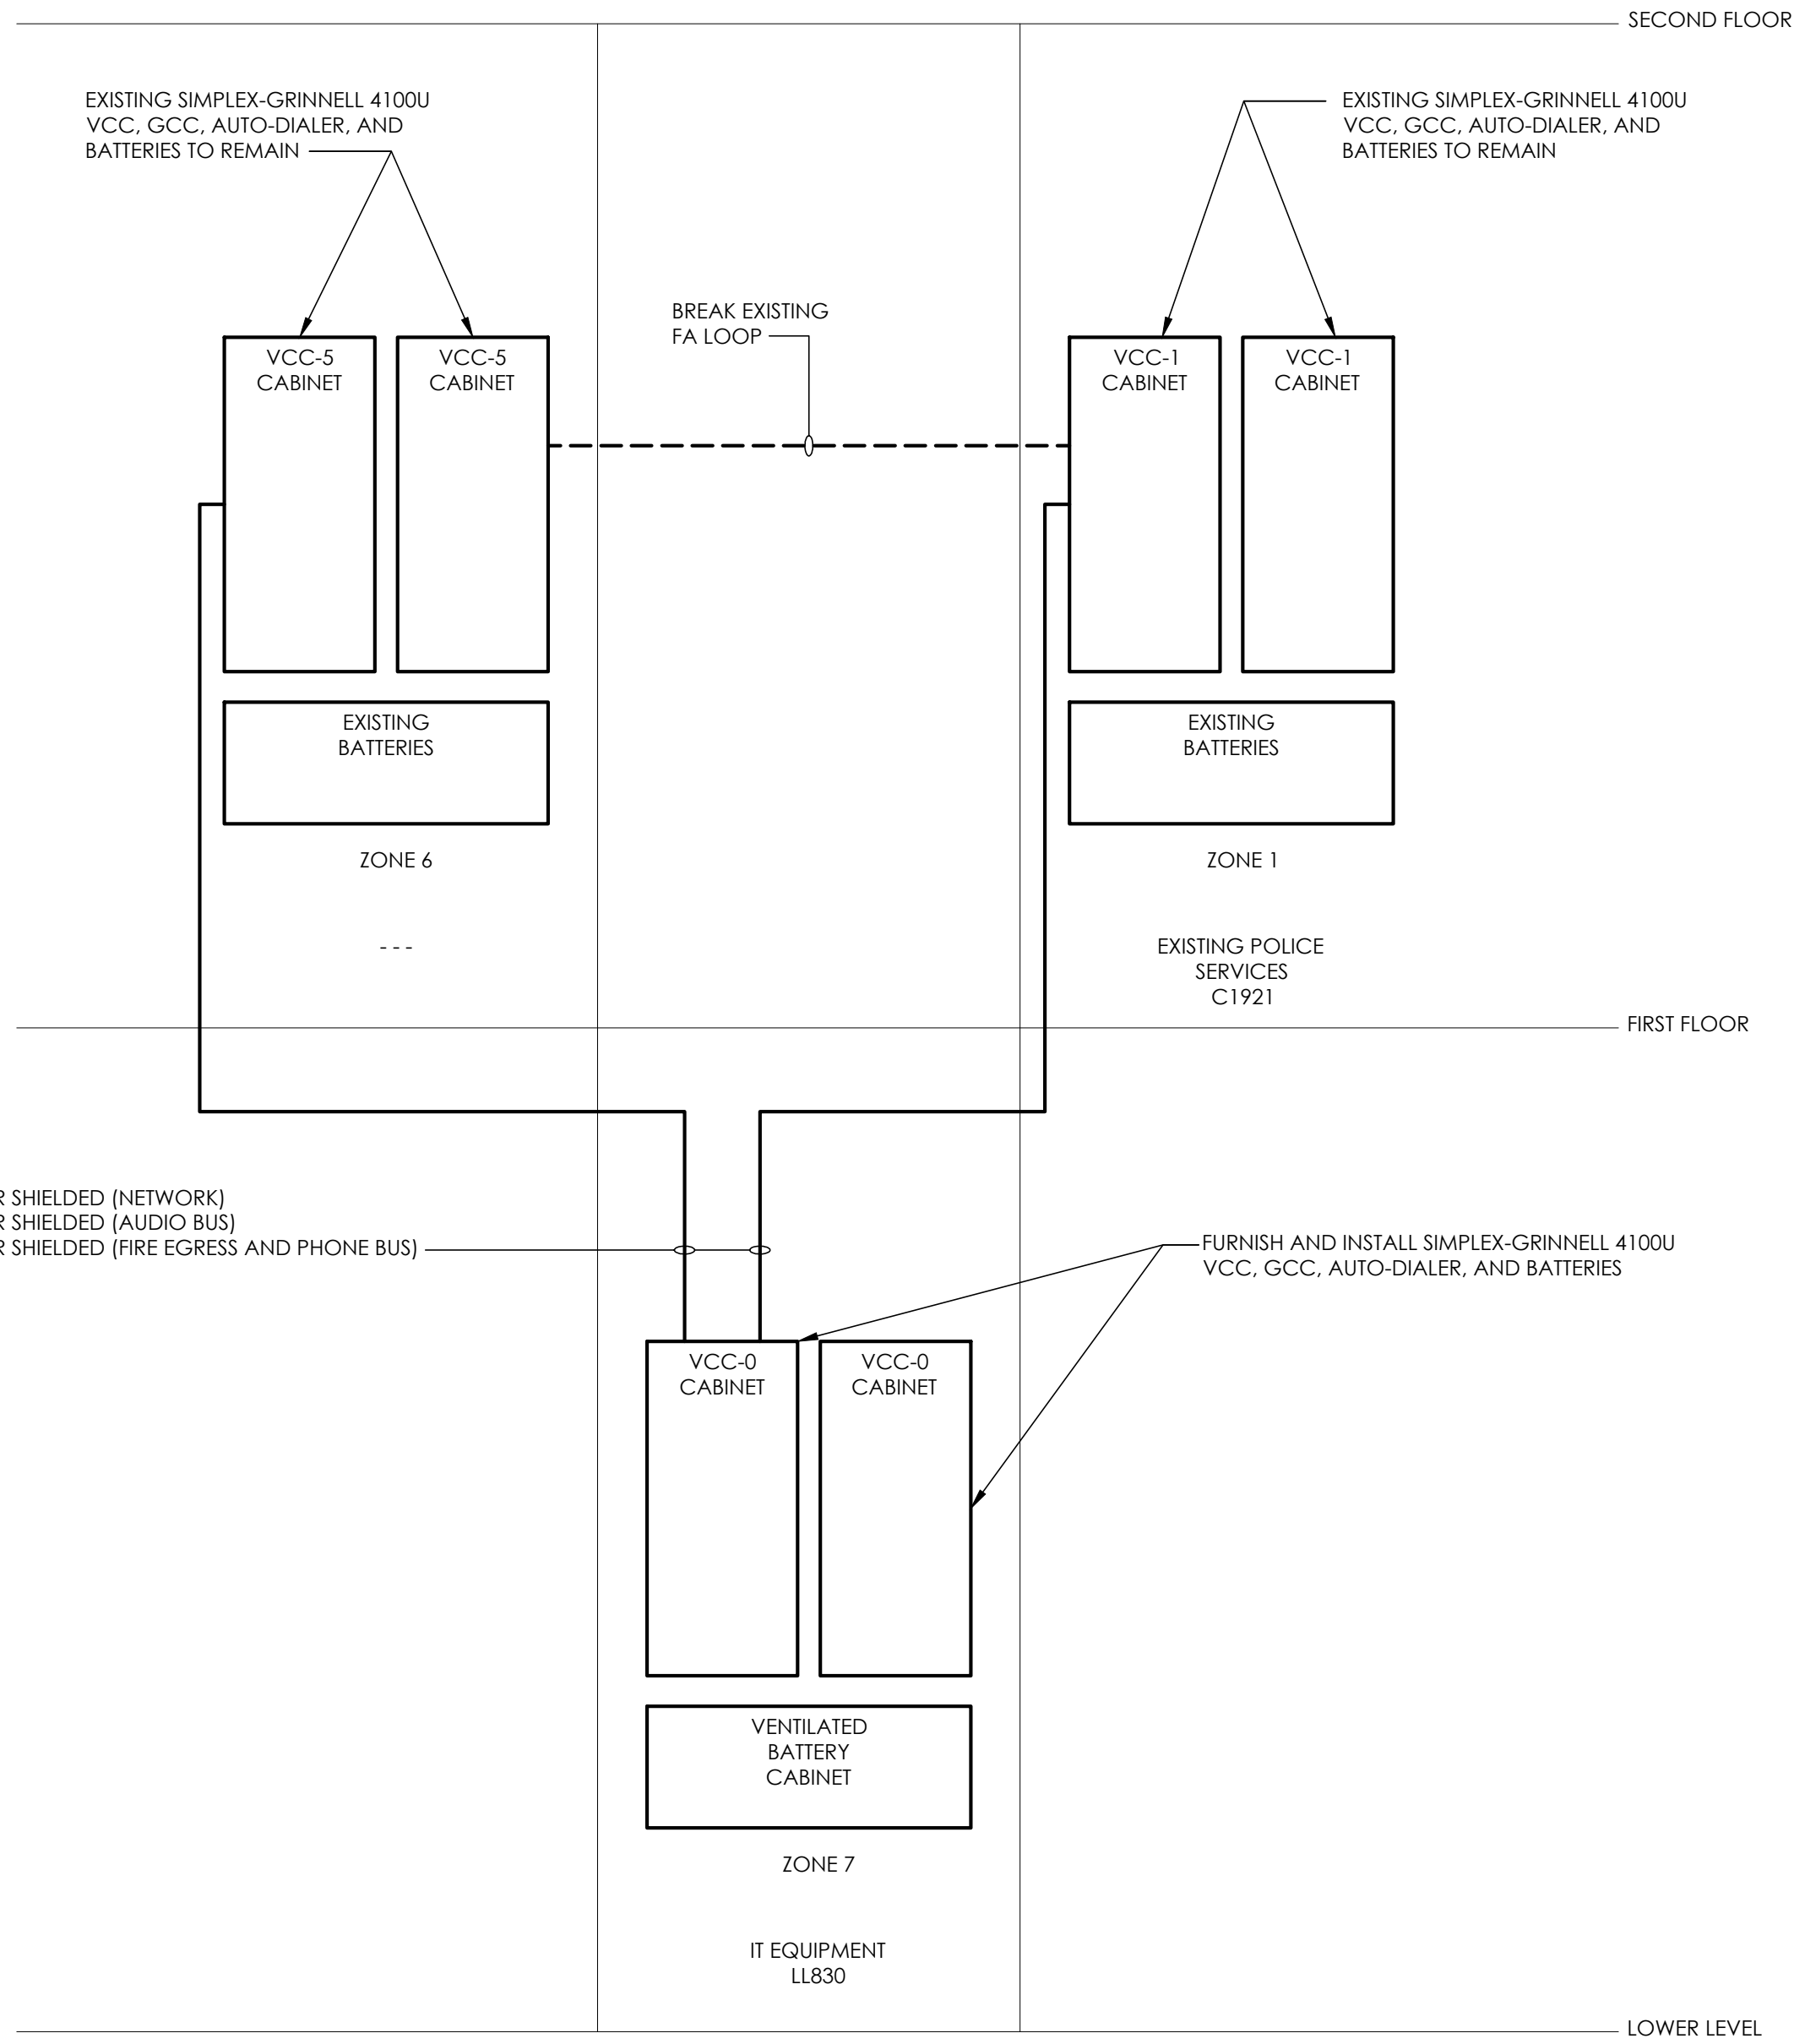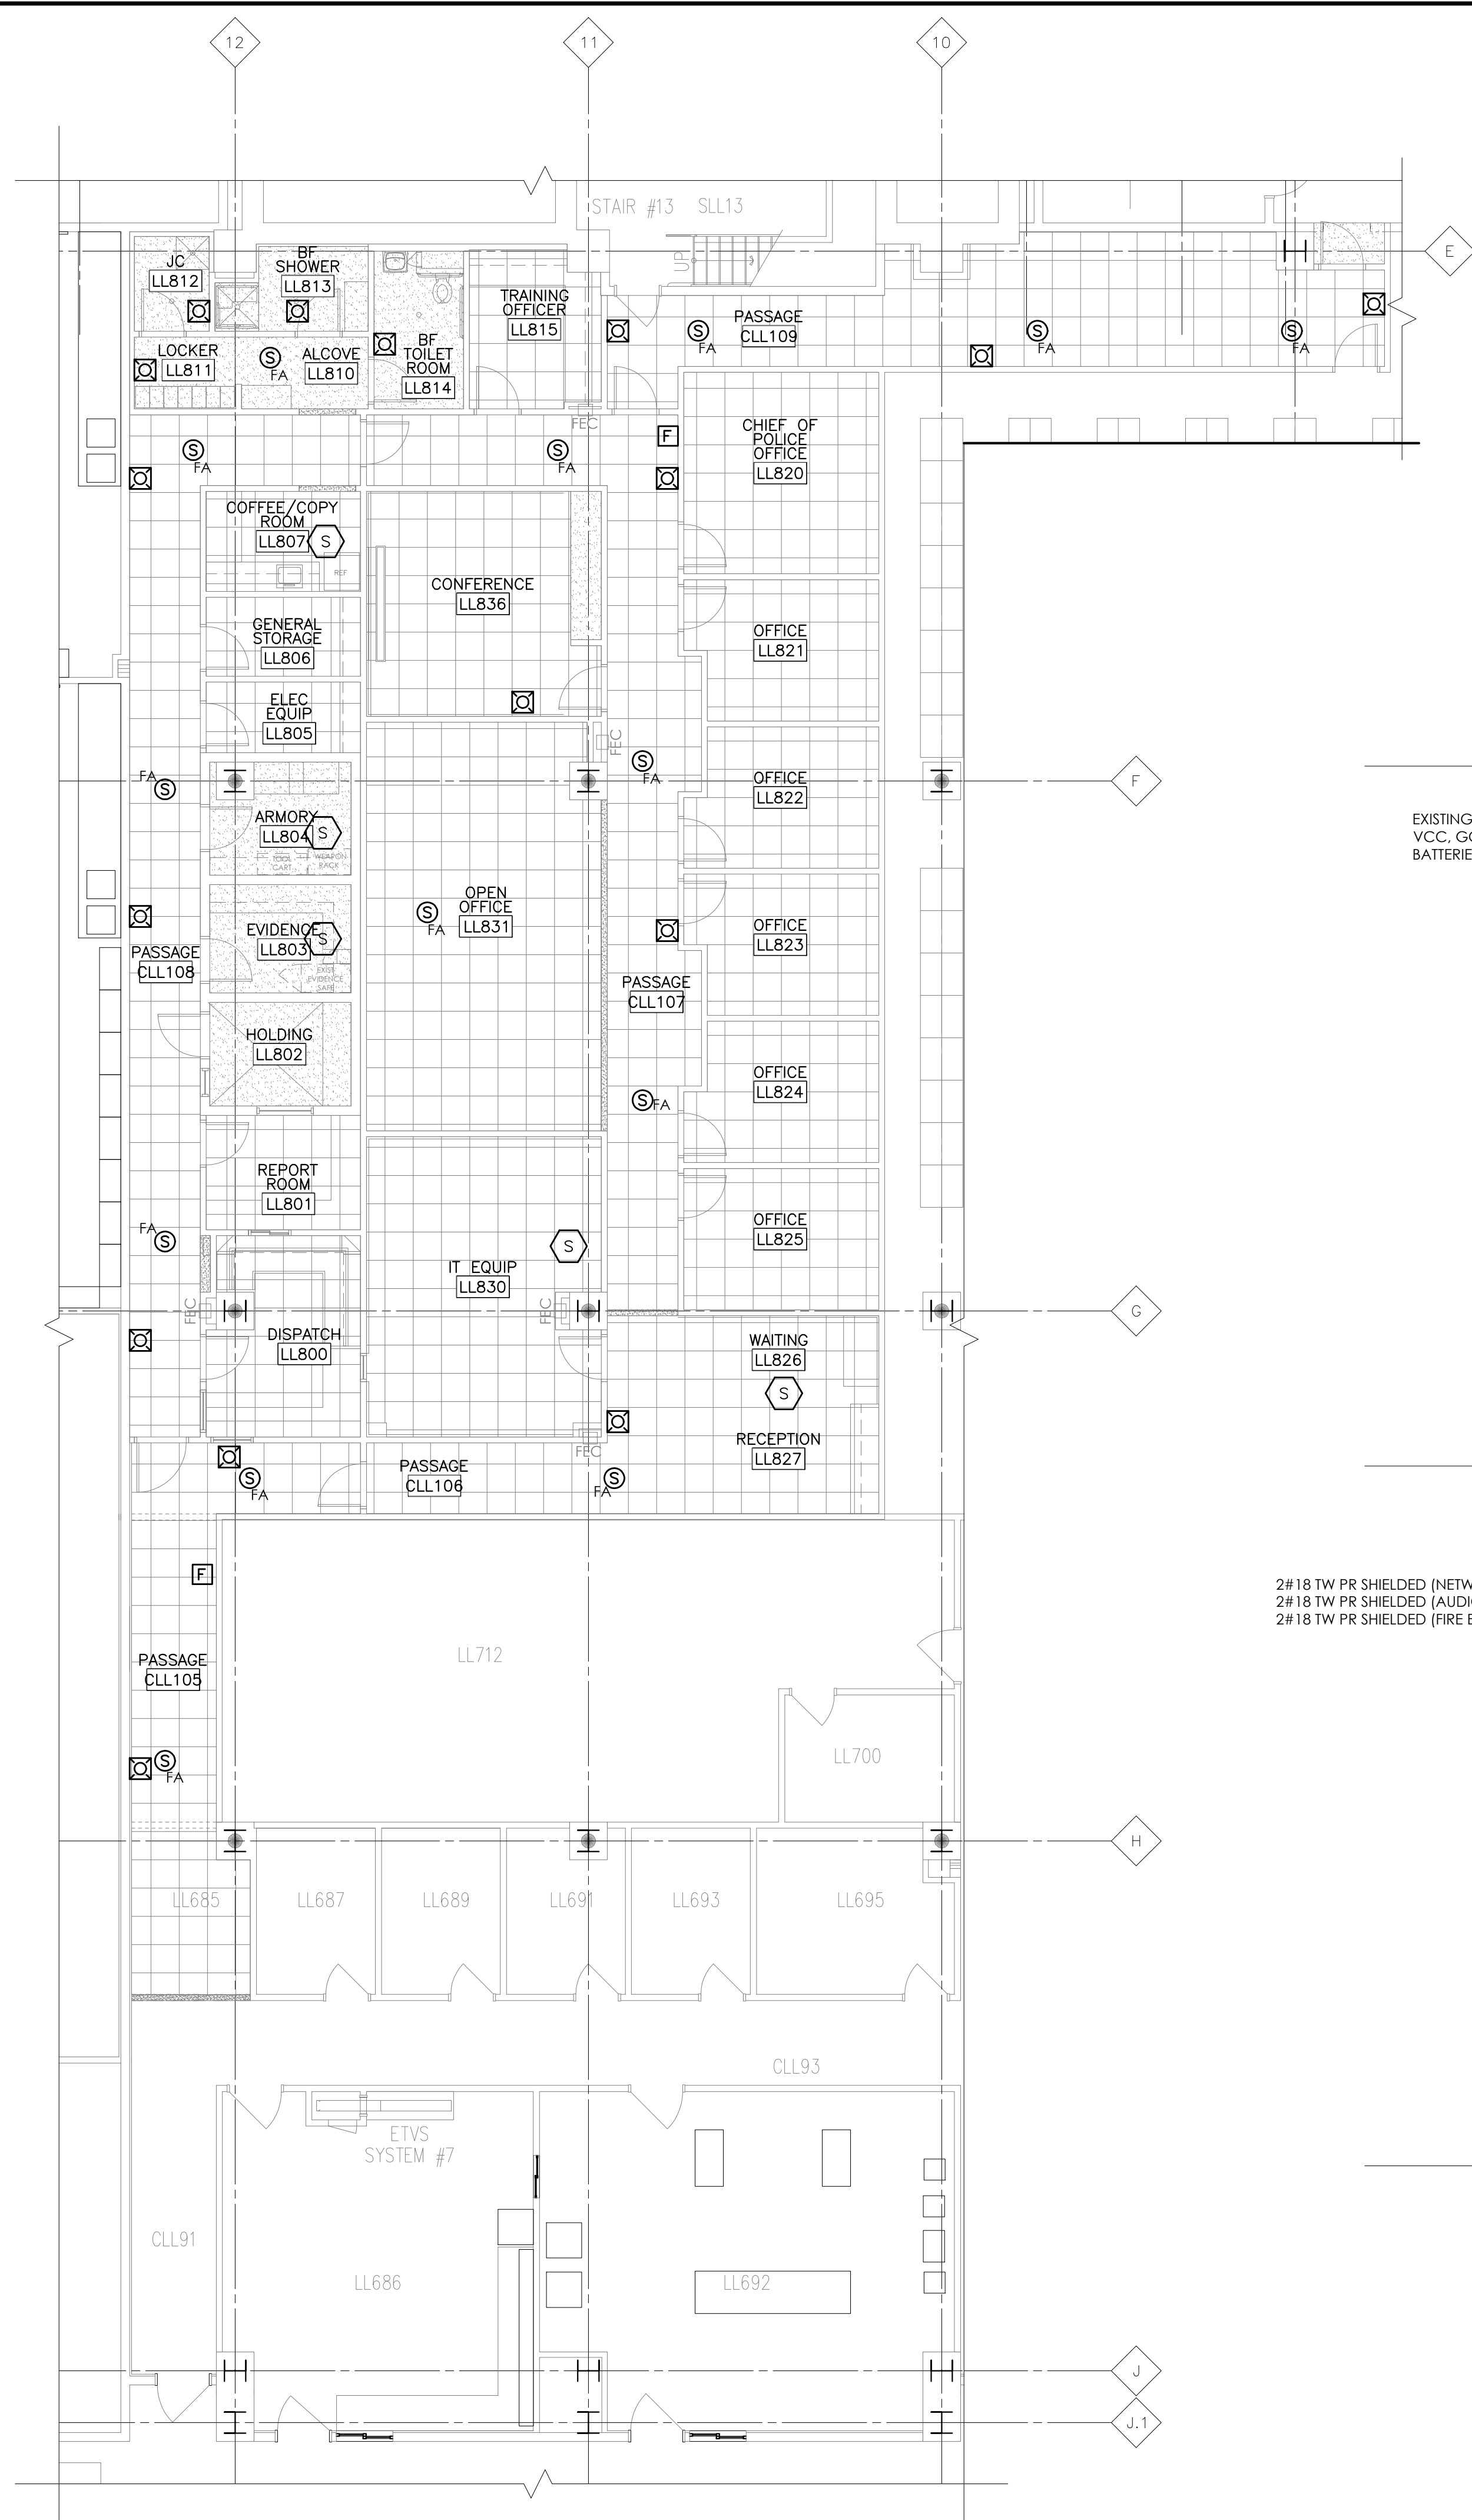


FIRE ALARM RISER
1/8" = 1'-0"

POLICE SERVICES – FIRE ALARM PLAN
1/8" = 1'-0"

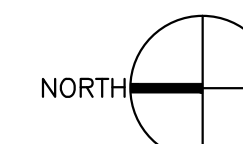

ISSUE 006 - CD BID	01.20.11
ISSUE 005 - CD OWNER REVIEW	12.17.10
ISSUE 004 - DESIGN DEVELOPMENT RECORD	11.12.10
ISSUE 003 - DESIGN DEVELOPMENT REVIEW	09.08.10
Revisions	Date

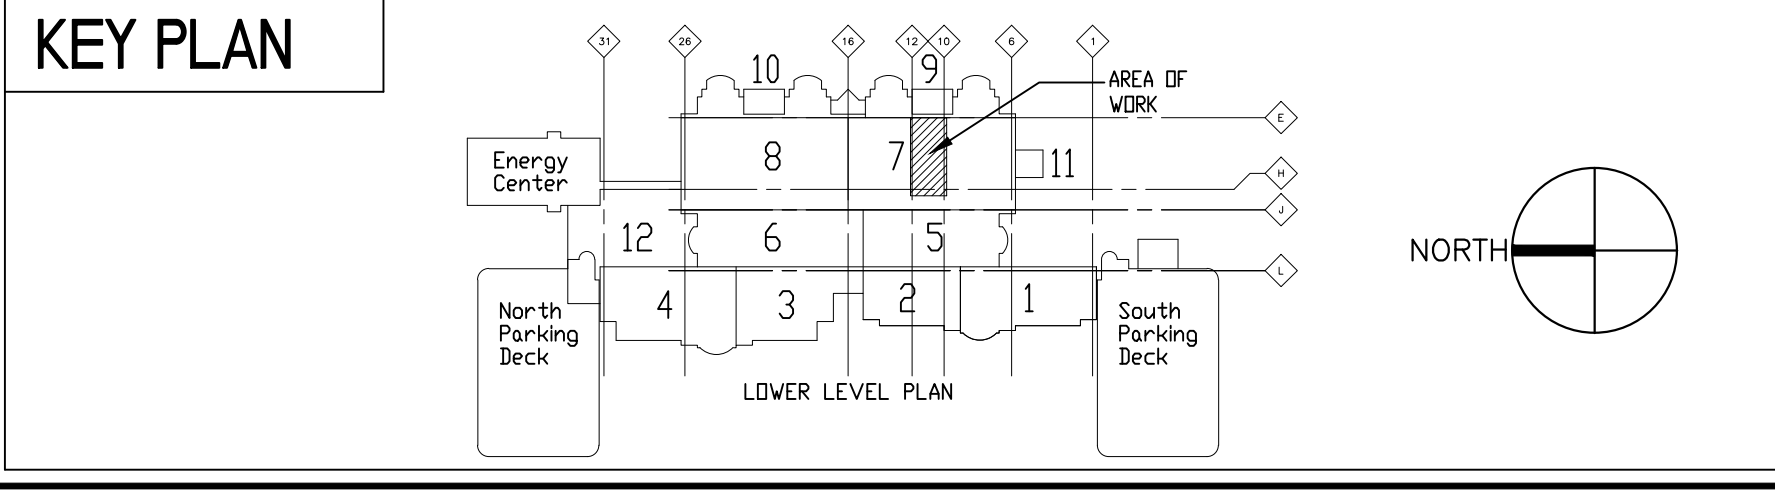

US DEPARTMENT OF
VETERANS AFFAIRS
JOHN D. DINGELL
VA MEDICAL CENTER
4646 JOHN R. STREET
DETROIT, MI 48202

ARCHITECT/ENGINEERS:

Kahn

Albert Kahn Associates, Inc.
Albert Kahn Building
7430 Second Ave.
Detroit, Michigan 48202-2798
Albert Kahn Associates, Inc. is a member of
the Albert Kahn Family of Companies. © 2007
ALBERT KAHN JOB # 0398-00.000

Drawing Title ENLARGED LOWER LEVEL FIRE ALARM PLAN
Approved Project Director

Project Title		
POLICE SERVICES RELOCATION		
Location		
DETROIT, MICHIGAN		
Date	Checked	Drawn
01-20-2011	-	-

Project Number 553-11-108
Building Number 100
Drawing Number FA-400 Dwg. 21 of 50

Office of
Construction
and Facilities
Management

Department of
Veterans Affairs

FULLY SPRINKLERED