



A
B
C
D
E
F

three inches = one foot
one and one half inches = one foot
one inch = one foot
three quarters inch = one foot
one half inch = one foot
three eighths inch = one foot
one quarter inch = one foot
one eighth inch = one foot

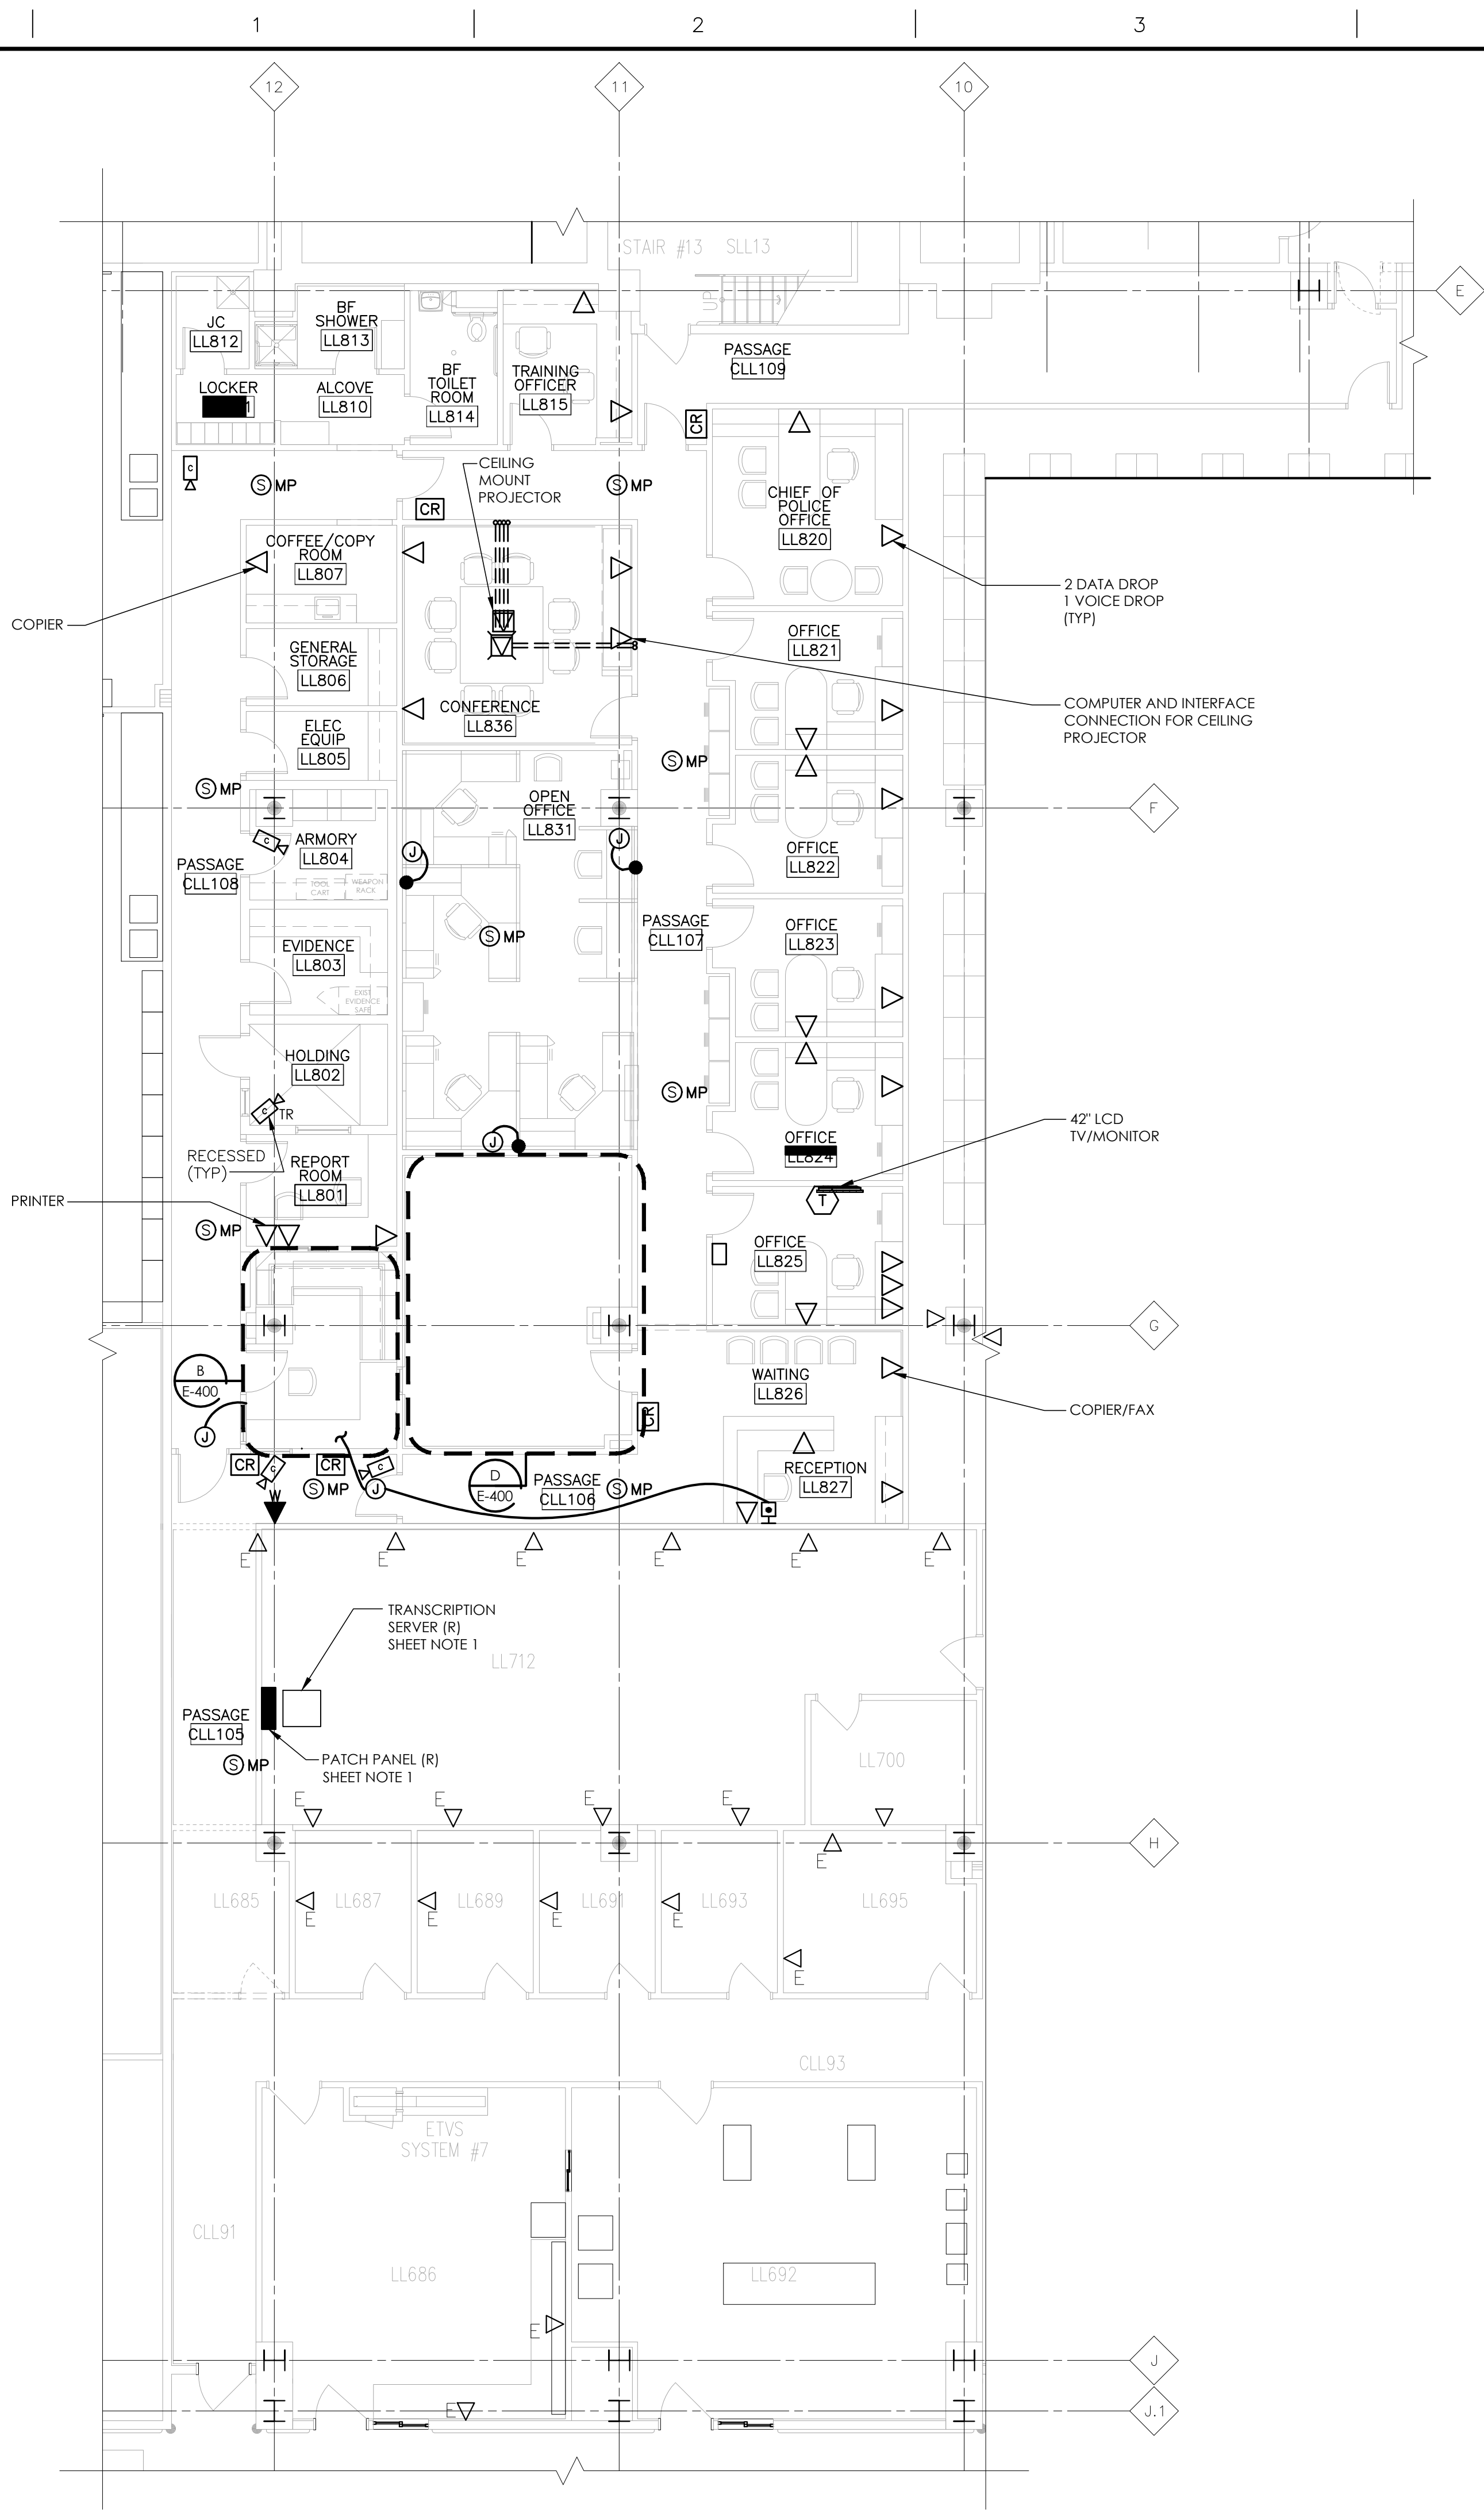

NORTH
POLICE SERVICES – COMMUNICATION PLAN
1/8" = 1'-0"

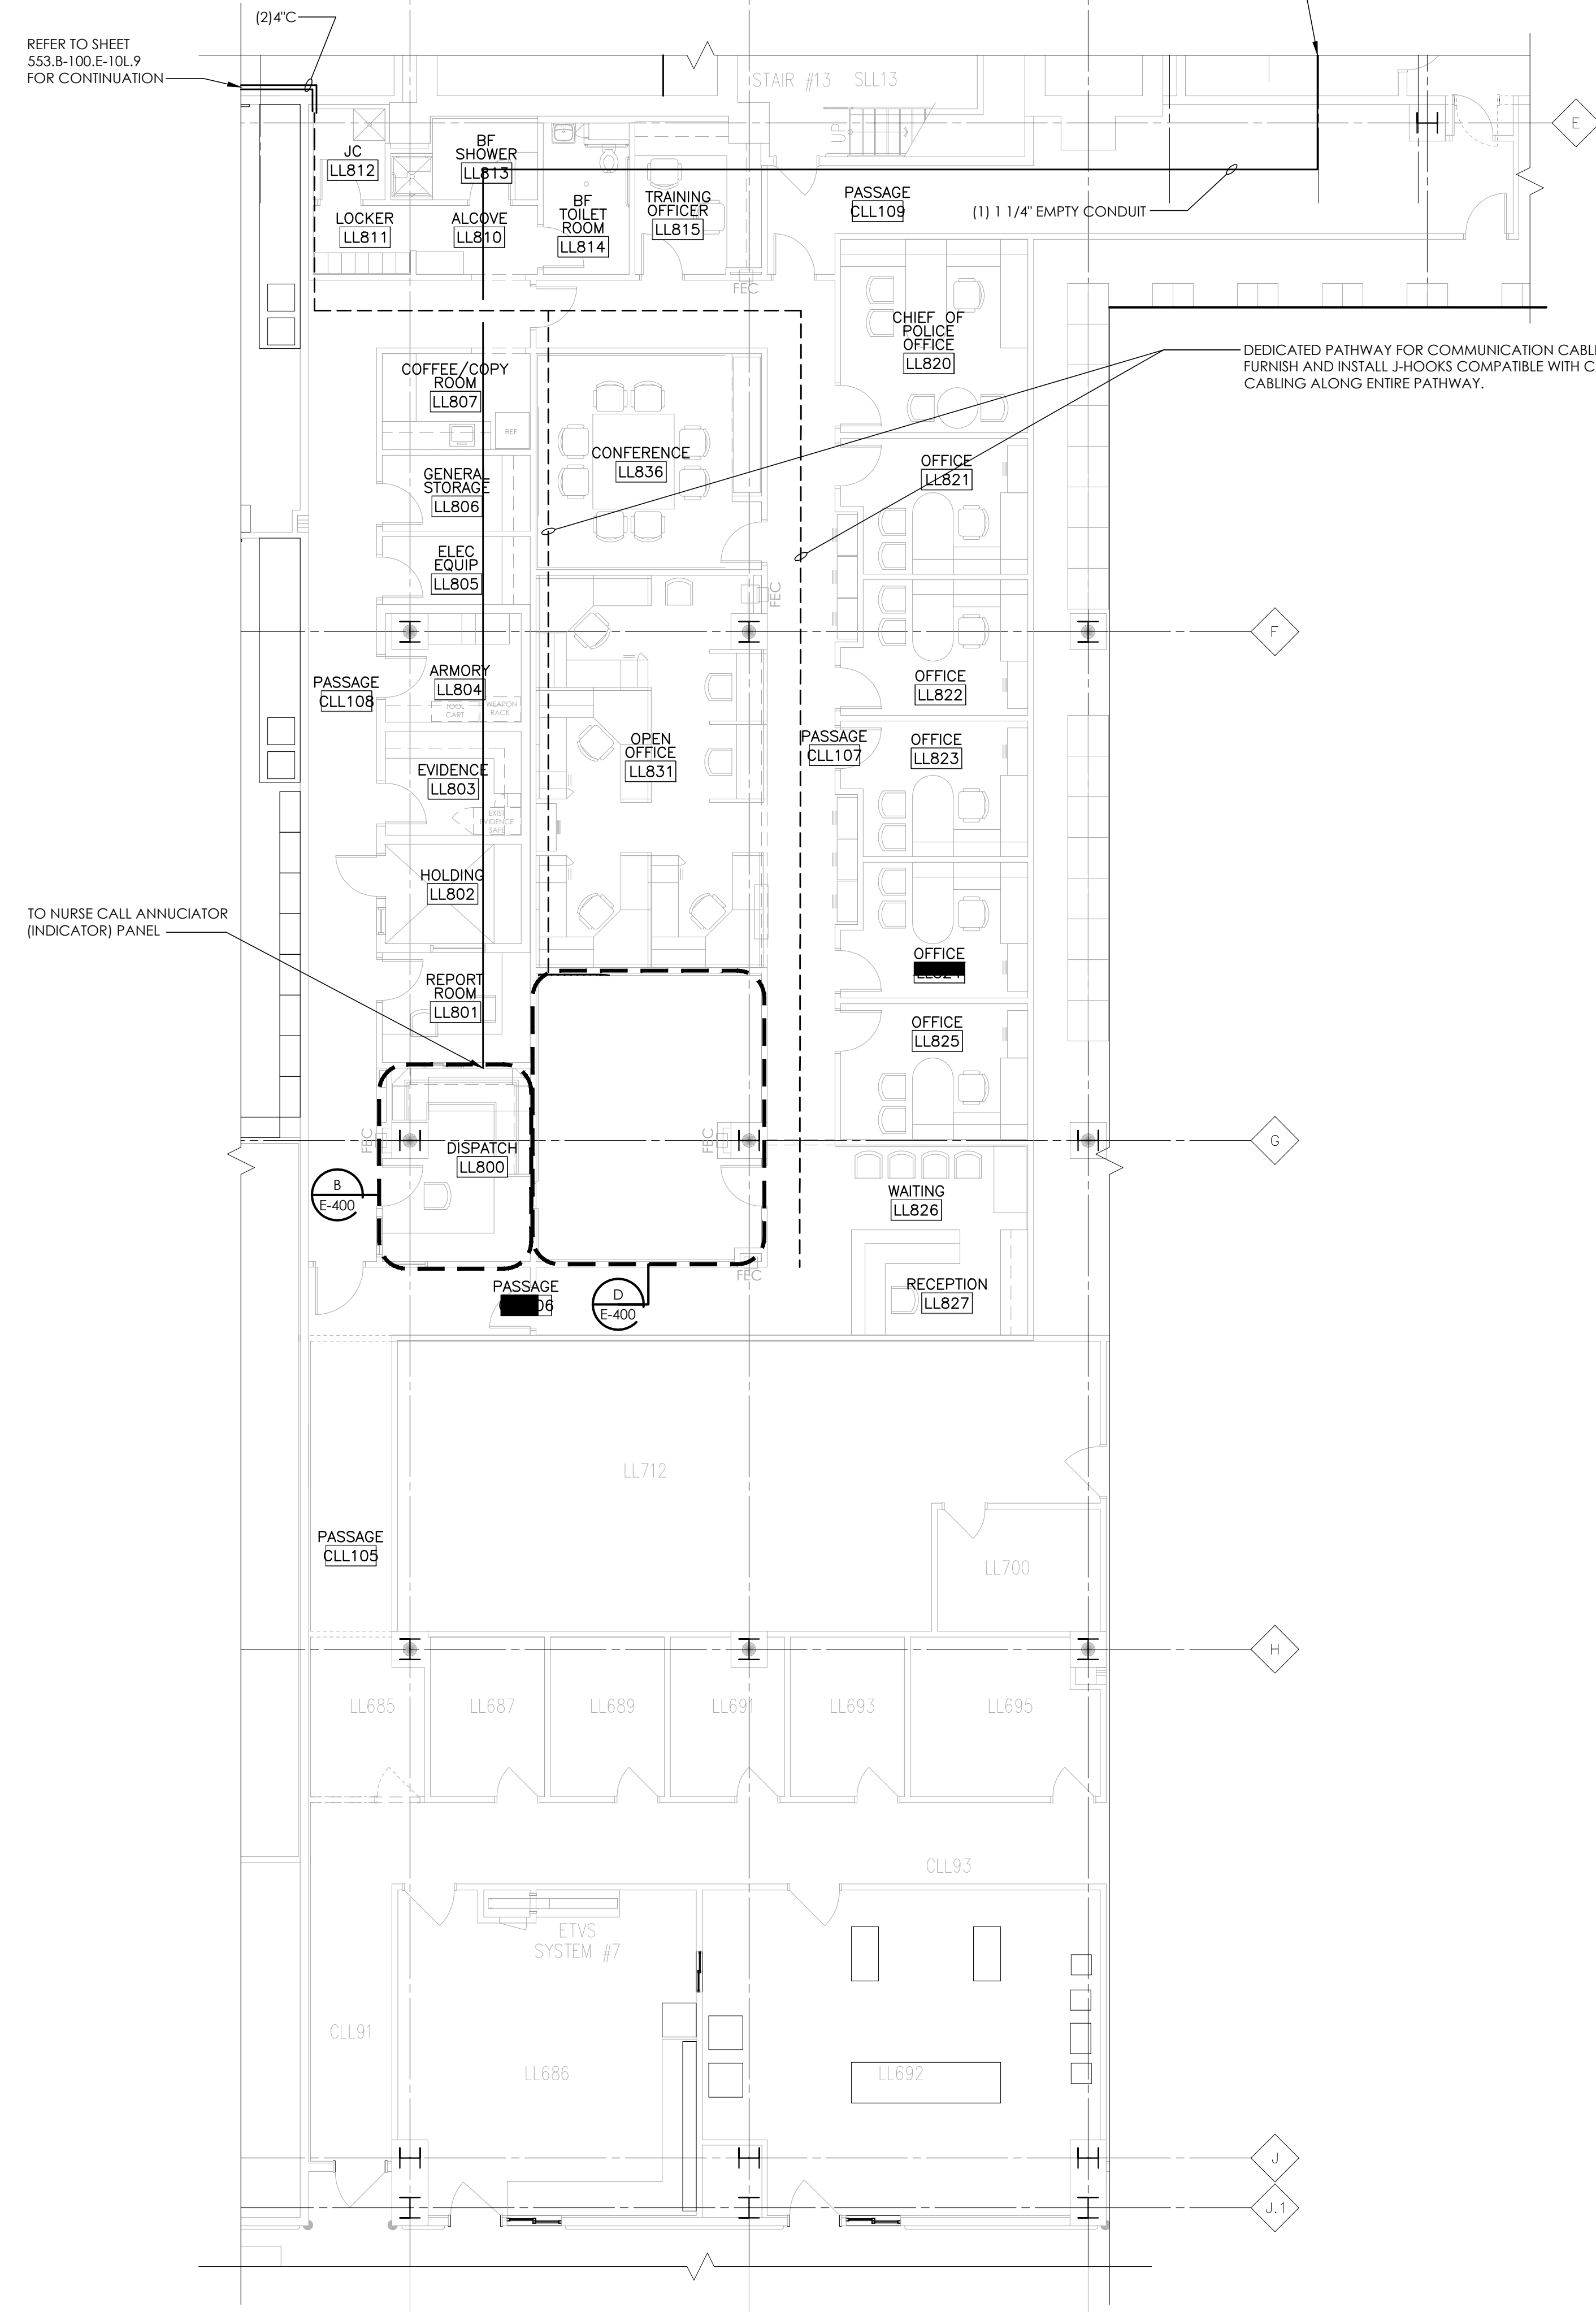

NORTH
POLICE SERVICES – COMMUNICATION PLAN
1/8" = 1'-0"

- GENERAL NOTES**
- REFER TO SYMBOLS AND ABBREVIATIONS LISTS ON SHEET NO. E-001.
 - REFER TO MOUNTING HEIGHTS AND ELECTRICAL NOTES ON SHEET NO. E-001.
 - REFER TO SPECIFICATIONS FOR ADDITIONAL ELECTRICAL REQUIREMENTS.
- SHEET NOTES**
- REFER TO SPECIFICATION SECTION 01 00 00 FOR CUT OVER INSTRUCTIONS FOR THE TRANSCRIPTION SERVER AND ASSOCIATED EQUIPMENT.

<p>ISSUE 005 - CD OWNER REVIEW 12.17.10</p> <p>ISSUE 004 - DESIGN DEVELOPMENT RECORD 11.12.10</p> <p>ISSUE 003 - DESIGN DEVELOPMENT REVIEW 09.08.10</p> <p>Revisions: _____</p>	<p>KEY PLAN</p> <p>LOWER LEVEL PLAN</p>	<p>US DEPARTMENT OF VETERANS AFFAIRS</p> <p>JOHN D. DINGELL</p> <p>VA MEDICAL CENTER</p> <p>4646 JOHN R. STREET</p> <p>DETROIT, MI 48202</p>	<p>ARCHITECT/ENGINEERS:</p> <p>Kahn</p> <p>Albert Kahn Associates, Inc.</p> <p>Albert Kahn Building</p> <p>7430 Second Ave.</p> <p>Detroit, Michigan 48202-2798</p> <p>Albert Kahn Associates, Inc. is a member of the Albert Kahn Family of Companies. © 2007</p> <p>ALBERT KAHN JOB # 0398-00.000</p>	<p>Drawing Title</p> <p>ENLARGED LOWER LEVEL COMMUNICATIONS PLAN</p> <p>Approved Project Director</p>	<p>Project Title</p> <p>POLICE SERVICES RELOCATION</p>	<p>Project Number</p> <p>553-11-108</p>	<p>Office of Construction and Facilities Management</p> <p>Department of Veterans Affairs</p>	
					<p>Location</p> <p>DETROIT, MICHIGAN</p>	<p>Building Number</p> <p>100</p>		
					<p>Date</p> <p>01-20-2011</p>	<p>Checked</p> <p>-</p>		<p>Drawn</p> <p>-</p>
					<p>Dwg. 48 of 50</p>			