


KEYED NOTES


- 1 REMOTE MEDICAL GAS AND VACUUM ALARM SENSORS.
- 2 MICROPROCESSOR DIGITAL MEDICAL GAS AND VACUUM ALARM PANEL WITH ALARMS FOR (2) ZONES, AS SHOWN. MOUNT PANELS AT NURSES STATION, REFER TO FLOOR PLAN FOR EXACT LOCATIONS.
- 3 PROVIDE NEW SERVICE SHUTOFF VALVES AT EXISTING MEDICAL GAS & VACUUM RISER.
- 4 WATER TREATMENT SYSTEM ALARM PANEL ON WALL AT NURSES STATION. COORDINATE ELECTRICALROUGH IN WITH GOV'T WATER TREATMENT SYSTEM INSTALLER THROUGH COR.
- 5 REFER TO DETAIL 9F ON SHEET PP501 FOR INSTALLATION OF DW2.
- 6 REFER TO DETAIL 5F ON SHEET PP501 FOR INSTALLATION OF DW1.
- 7 WATER TREATMENT SYSTEM ALARM PANEL ON WALL AT WATER TREATMENT ROOM. COORDINATE ELECTRICAL ROUGH IN WITH GOV'T WATER TREATMENT SYSTEM INSTALLER THROUGH COR.
- 8 3/4" VACUUM, 1/2" OXYGEN & 1/2" MEDICAL AIR TO GAS HEADER LOCATED INSIDE HEADWALL SYSTEM.
- 9 3/4" VACUUM, 1/2" OXYGEN & 1/2" MEDICAL AIR TO GAS HEADER LOCATED IN WALL WITH PORT OUTLETS.

GROUND FLOOR

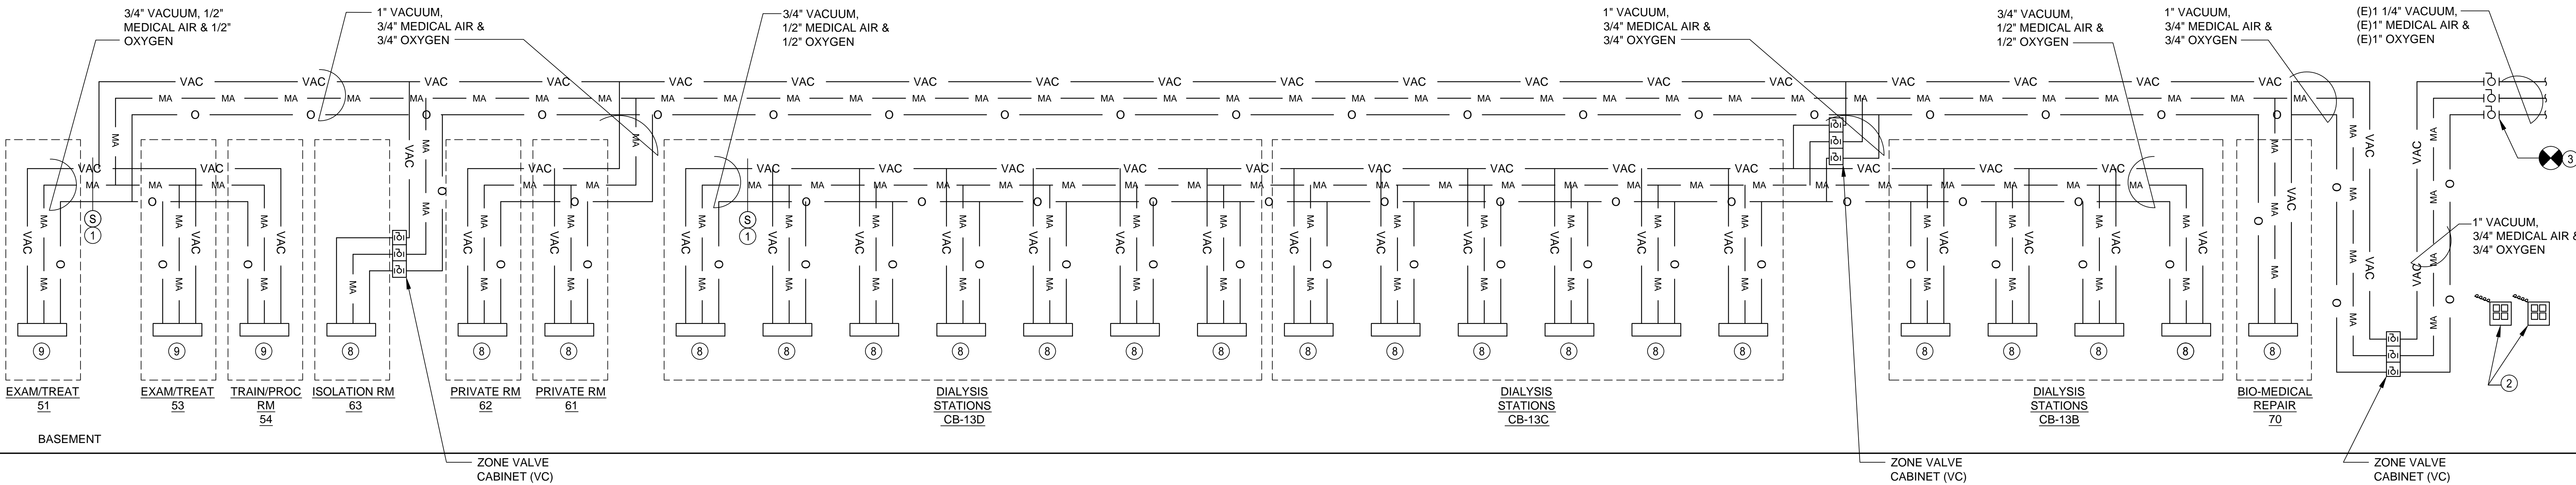


6C MEDICAL GAS AND VACUUM RISER DIAGRAM
NTS

GROUND FLOOR

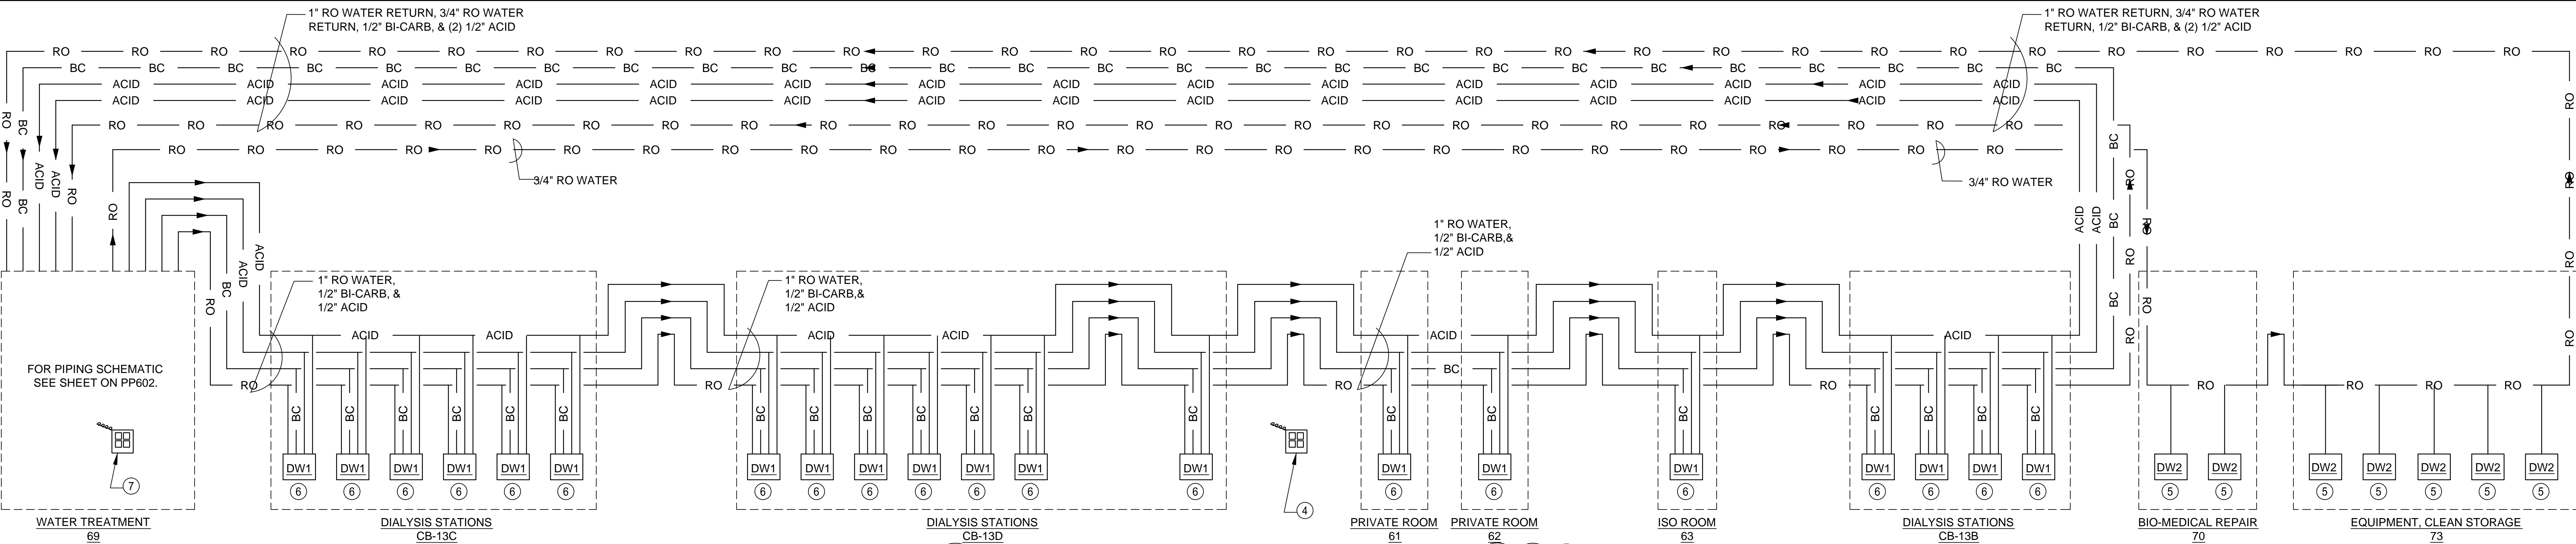

6E DIALYSIS PIPING RISER DIAGRAM (FOR COORDINATION PURPOSES ONLY)
NTS

CONSTRUCTION DOCUMENTS
FULLY SPRINKLERED

4 ADDENDUM #4	5/16/16	<div><div>Corporate Office: 766 Middle St. Fairhope, AL 36532 Phone: 251.990.5778 Fax: 251.990.3716</div></div>	Approved: Patient Safety Nurse			Approved: Energy Engineer			Approved: Safety Manager			Approved: Service Chief			Drawing Title PLUMBING RISER DIAGRAM			Project Title RELOCATE AND EXPAND RENAL DIALYSIS			Date 2016.01.22		Veterans Affairs			
						Approved: Chief of Police			Approved: Infection Control Officer			Approved: Chief of Staff			Approved: Chief of Facility Management Svc.			Building Number 2		Checked WB		Drawn AH		Project No. 658-315		
						Approved: Chief of Mental Health Service			Approved: GEMS Coordinator			Approved: Associate Director			Approved: Medical Center Director			Location SALEM VA MEDICAL CENTER			Drawing No. PP505			Sheet 101 of 144		
			Revisions:			Date																				