



# CONSTRUCT INPATIENT BEHAVIORAL HEALTH BUILDING B59 PROJECT NO. #589A7-COI-401

03/25/2016 - BID DOCUMENTS

DEPARTMENT OF VETERANS AFFAIRS ROBERT J. DOLE  
MEDICAL and REGIONAL OFFICE CENTER  
5500 E. KELLOGG  
WICHITA, KANSAS

## STANDARD SYMBOLS LIST


DRAWING TITLES:	1 TITLE
WALL, CASEWORK, SECTIONS:	DETAIL #
ELEVATIONS:	SHEET #
DOOR NOTATION:	DOOR #
WINDOW NOTATION:	WINDOW #
EQUIPMENT NOTES:	
ELEVATION MARK:	
ROOM NOTATION:	
CONSTRUCTION NOTE:	
DEMOLITION NOTE:	
REVISION:	
WALL TYPES:	PARTITION TYPE

## STANDARD DETAIL SYMBOLS

ACOUSTICAL	METAL
BRICK	TILE
CONCRETE	SAND
CONC. MASONRY UNIT	WOOD FINISH
GRAVEL	WOOD, FRAMING (CONTINUOUS)
EARTH	WOOD, FRAMING (INTERRUPTED)
GYPSUM BOARD	PLYWOOD
BATT INSULATION	RIGID INSULATION

## ABBREVIATIONS

AB anchor bolt	DM dimension	JNT joint	PVC polyvinyl chloride
ABV above	DN down	KIT kitchen	RAC return air (grill)
A/C air conditioning	DO door	L long/length	REG register
ACM asbestos containing material	DR door	LAV lavatory	REQ required
ADJ adjustable/adjacent	DS downspout	LF linear foot	REV revised/revision/
AFT above finish floor	DTL detail	LH long leg horizontal	reverse
ALUM aluminum	DWG drawing	LVL long leg vertical	RM room
ALT alternate	EB expansion bolt	LW long leg vertical	RO rough opening
ANCH anchor	EC electrical contractor	MAX maximum	RSG rough room (cedar)
APPROX approximate	EJ expansion joint	MC mechanical contractor	SEC section
ARCH architectural	EL elevation	MECH mechanical	SM similar
AS board	ELEC electric(al)	MFR manufacture(r)	SQ square
BDO building	ENT entrance	MIN minimum	STD standard
BLW below	EQ equal	MISC miscellaneous	STL steel
BM beam/bench mark	EQIP equipment	MO masonry opening	STO storage
BTT bottom	EXIST existing	ND not in contract	SY square yard
BUR built-up roofing	EXT exterior	NO number	SYM symmetrical
CAB cabinet	F fire	NOM nominal	T&G tongue and groove
C/C center to center	FA fresh air/fire alarm	NTS not to scale	TYP typical
CF cubic feet	FDW foundation	OC on center(s)	VERT vertical
CU construction joint	FLR floor	OD outside diameter	VEST vestibule
CL center line	FT (T) foot	OP opening	W wide/width
CLS ceiling	FTG footing	PL plate/property line	W/ with
CLO closet	GA gage/gauge	P LM plastic laminate	W/O without
CLR clear	GC general contractor	PB plumbing	WT weight
CMU conc masonry unit	OPP opposite	PND plywood	WWF welded wire fabric
CO clean out/clean opening	HBD hard board	PNT panel(ing)	YD yard
COL column	OPP opposite	PSI pounds per sq ft	
CONC concrete	HDP high-density prefinished	PSF pounds per sq in.	
COND condition/condenser	HDM hardware		
CONT continue/continuous	HND hardwood		
CONTR contract(or)	HM hollow metal		
CTR counter/center	HOB hollow metal		
CU cubic	HOT high (height)		
D deep/depth	ID inside diameter		
DF drinking fountain	IN (T) inch		
DIA diameter	INSUL insulation		
	INT interior		

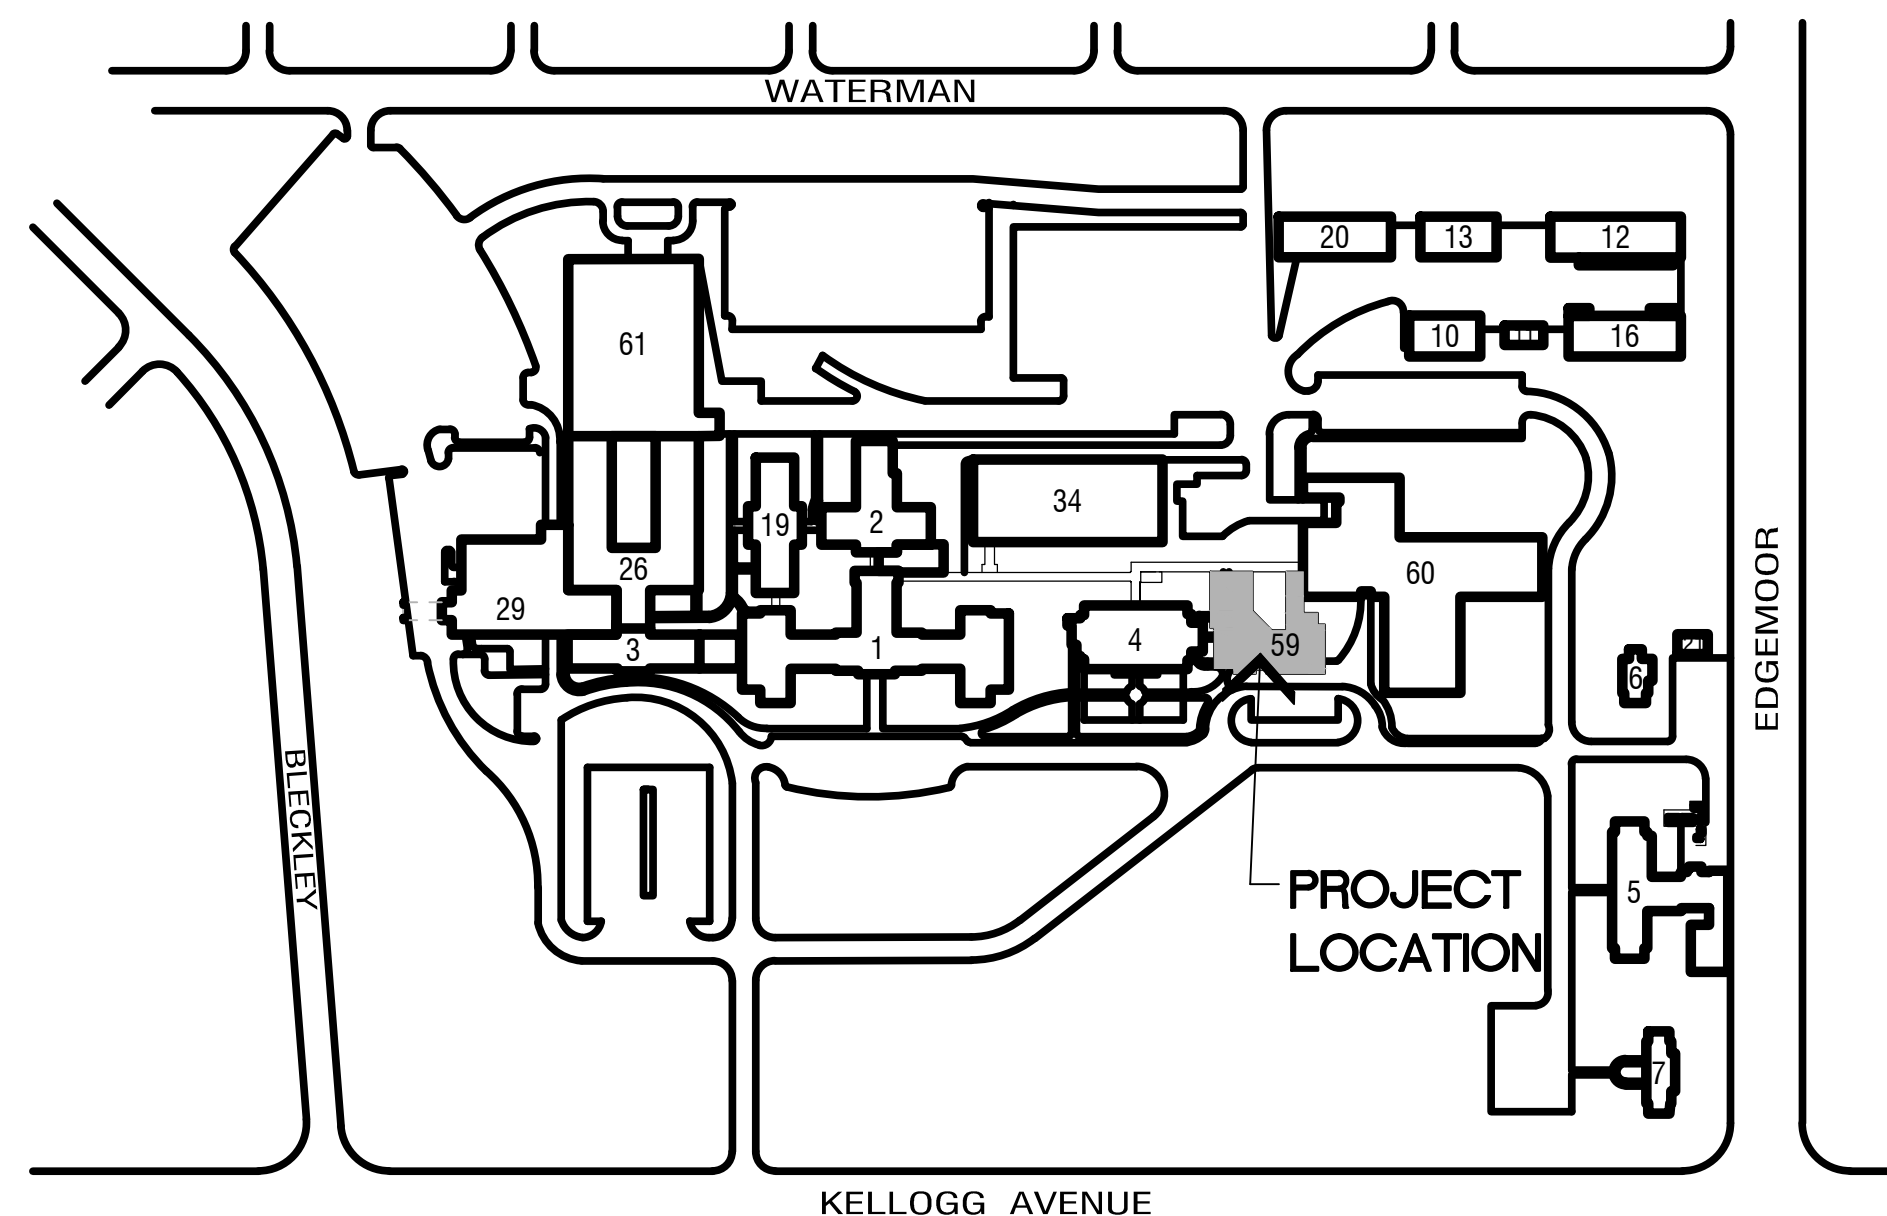

AREA MAP  
NOT TO SCALE

## SHEET INDEX

59-G-101	COVER SHEET AND INDEX	STRUCTURAL	ELECTRICAL
CIVIL		59-S-101	FOUNDATION PLAN
59-V-101	SITE SURVEY (FOR REFERENCE ONLY)	59-S-102	SECOND FLOOR FRAMING PLAN
59-GS 101	SITE DEMOLITION AND DIMENSION PLAN	59-S-103	ROOF FRAMING PLANS
59-GS 102	SITE GRADING PLAN, EROSION CONTROL PLAN	59-S-104	FOUNDATION + FRAMING PLAN BID ITEM #5
59-GS 103	SITE UTILITY PLAN	59-S-201	GENERAL STRUCTURAL NOTES AND FOUNDATION SCHEDULES
59-GS-104	SITE LANDSCAPE PLAN	59-S-202	FRAMING SCHEDULES
		59-S-203	FRAMING SCHEDULES
		59-S-301	FOUNDATION SECTIONS
		59-S-401	FRAMING SECTIONS
		59-S-402	FRAMING SECTIONS
ARCHITECTURAL		MECHANICAL	
59-AC-101	FIRST FLOOR CODE REVIEW PLAN	59-M-101	FIRST FLOOR HVAC PLAN + PARTIAL FIRST FLOOR HVAC PLAN FOR BID ITEM #5
59-AC-102	SECOND FLOOR CODE REVIEW PLAN	59-M-102	SECOND FLOOR HVAC PLAN
59-A-101	FIRST FLOOR PLAN	59-M-201	FIRST FLOOR ENLARGED HVAC PLAN AND SECTIONS
59-A-102	SECOND FLOOR PLAN	59-M-301	FIRST AND SECOND FLOOR GRILLES AND DIFFUSERS PLANS
59-A-103	ROOF PLAN	59-M-401	FIRST FLOOR HVAC PIPING PLAN
59-A-104	FIRST FLOOR EQUIPMENT PLAN	59-M-402	SECOND FLOOR HVAC PIPING PLAN
59-A-105	SECOND FLOOR EQUIPMENT PLAN	59-M-403	SECOND FLOOR BUILDING 60 PIPING PLAN
59-A-106	FIRST FLOOR REFLECTED CEILING PLAN	59-M-501	HVAC DETAILS
59-A-107	SECOND FLOOR REFLECTED CEILING PLAN	59-M-502	HVAC DETAILS
59-A-108	FIRST FLOOR SIGNAGE PLAN	59-M-601	TEMPERATURE CONTROLS
59-A-109	SECOND FLOOR SIGNAGE PLAN	59-M-701	SCHEDULES
59-A-110	FIRST FLOOR FINISH PLAN	PLUMBING	
59-A-111	SECOND FLOOR FINISH PLAN	59-P-101	FIRST FLOOR DWV PIPING PLAN
59-A-112	FIRST FLOOR PLAN - BID ITEM #5	59-P-102	SECOND FLOOR DWV PIPING PLAN
59-A-113	ROOF PLAN - BID ITEM #6	59-P-103	ROOF DRAIN PIPING, BID ITEMS #1 + #6
59-A-114	ATTIC FLOOR PLAN	59-P-104	BID ITEM #5 DWV PIPING PLAN
59-A-201	BUILDING ELEVATIONS - SOUTH and EAST	59-P-201	FIRST FLOOR WATER PIPING PLAN
59-A-202	BUILDING ELEVATIONS - NORTH and WEST	59-P-202	SECOND FLOOR WATER PIPING PLAN
59-A-203	BUILDING ELEVATIONS - BID ITEM #6	59-P-203	B60 FIRST + SECOND FLOOR WATER PIPING PLANS
59-A-301	BUILDING SECTIONS	59-P-301	FIRE PROTECTION PLAN
59-A-302	BUILDING SECTIONS		
59-A-401	WALL SECTIONS		
59-A-402	WALL SECTIONS AND DETAILS		
59-A-403	ENLARGED STAIR/ELEVATOR PLANS, STAIR/ELEVATOR SECTIONS		
59-A-404	ENLARGED STAIR PLANS, STAIR SECTIONS		
59-A-405	ENLARGED FLOOR PLANS, INTERIOR ELEVATIONS		
59-A-406	INTERIOR ELEVATIONS		
59-A-501	EXTERIOR DETAILS		
59-A-502	EXTERIOR DETAILS		
59-A-503	INTERIOR DETAILS		
59-A-504	INTERIOR DETAILS		
59-A-505	SIGNAGE DETAILS		
59-A-601	DOOR SCHEDULE, PARTITION SCHEDULE, WINDOW ELEVATIONS, DOOR ELEVATIONS		
59-A-602	ROOM FINISH SCHEDULE		

Revisions		Date		HOWARD+HELMER architecture www.howardandhelmer.com		Francisco Vazquez, MBA Medical Center Director		Norm Forbes Nurse Executive		John Hoerner Physical Therapy		Project Title CONSTRUCT INPATIENT BEHAVIORAL HEALTH BUILDING B59		Project Number 589A7-COI-401		Office of Construction and Facilities Management Department of Veterans Affairs	
						Vicki G. Boudie, ACIE, MBA Associate Medical Center Director		Don Allen Safety Officer		Tony Sines FOIO		Location 5500 E. KELLOGG WICHITA, KANSAS		Building Number 59			
						Syed Raffi, MD Chief of Staff		Jenni L. Harshbarger ACOS, Behavioral Health		Bruce Baugh Facilities Management Services		Date MARCH 25, 2016		Drawing Number 59-G1-101			
												Checked CNT		Drawn THR		Dwg. 1 of 82	