

L:\2008-Jobs\108302-VA Ft. Myers Outpatient Clinic\CAD-MEP\Sheets EY103-A.dwg 12/11/2012 1:56:40 PM leighon.vogel

three inches = one foot

one and one half inches = one foot

one inch = one foot


three quarters inch = one foot

one half inch = one foot

three eighths inch = one foot

one quarter inch = one foot


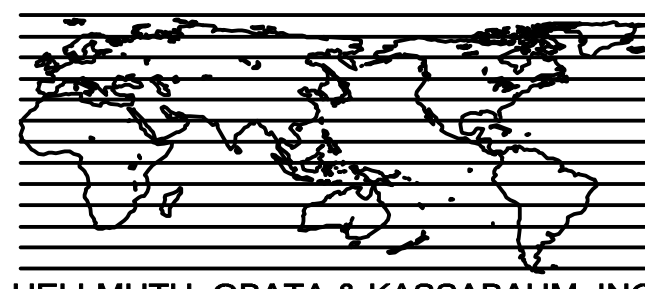
one eighth inch = one foot

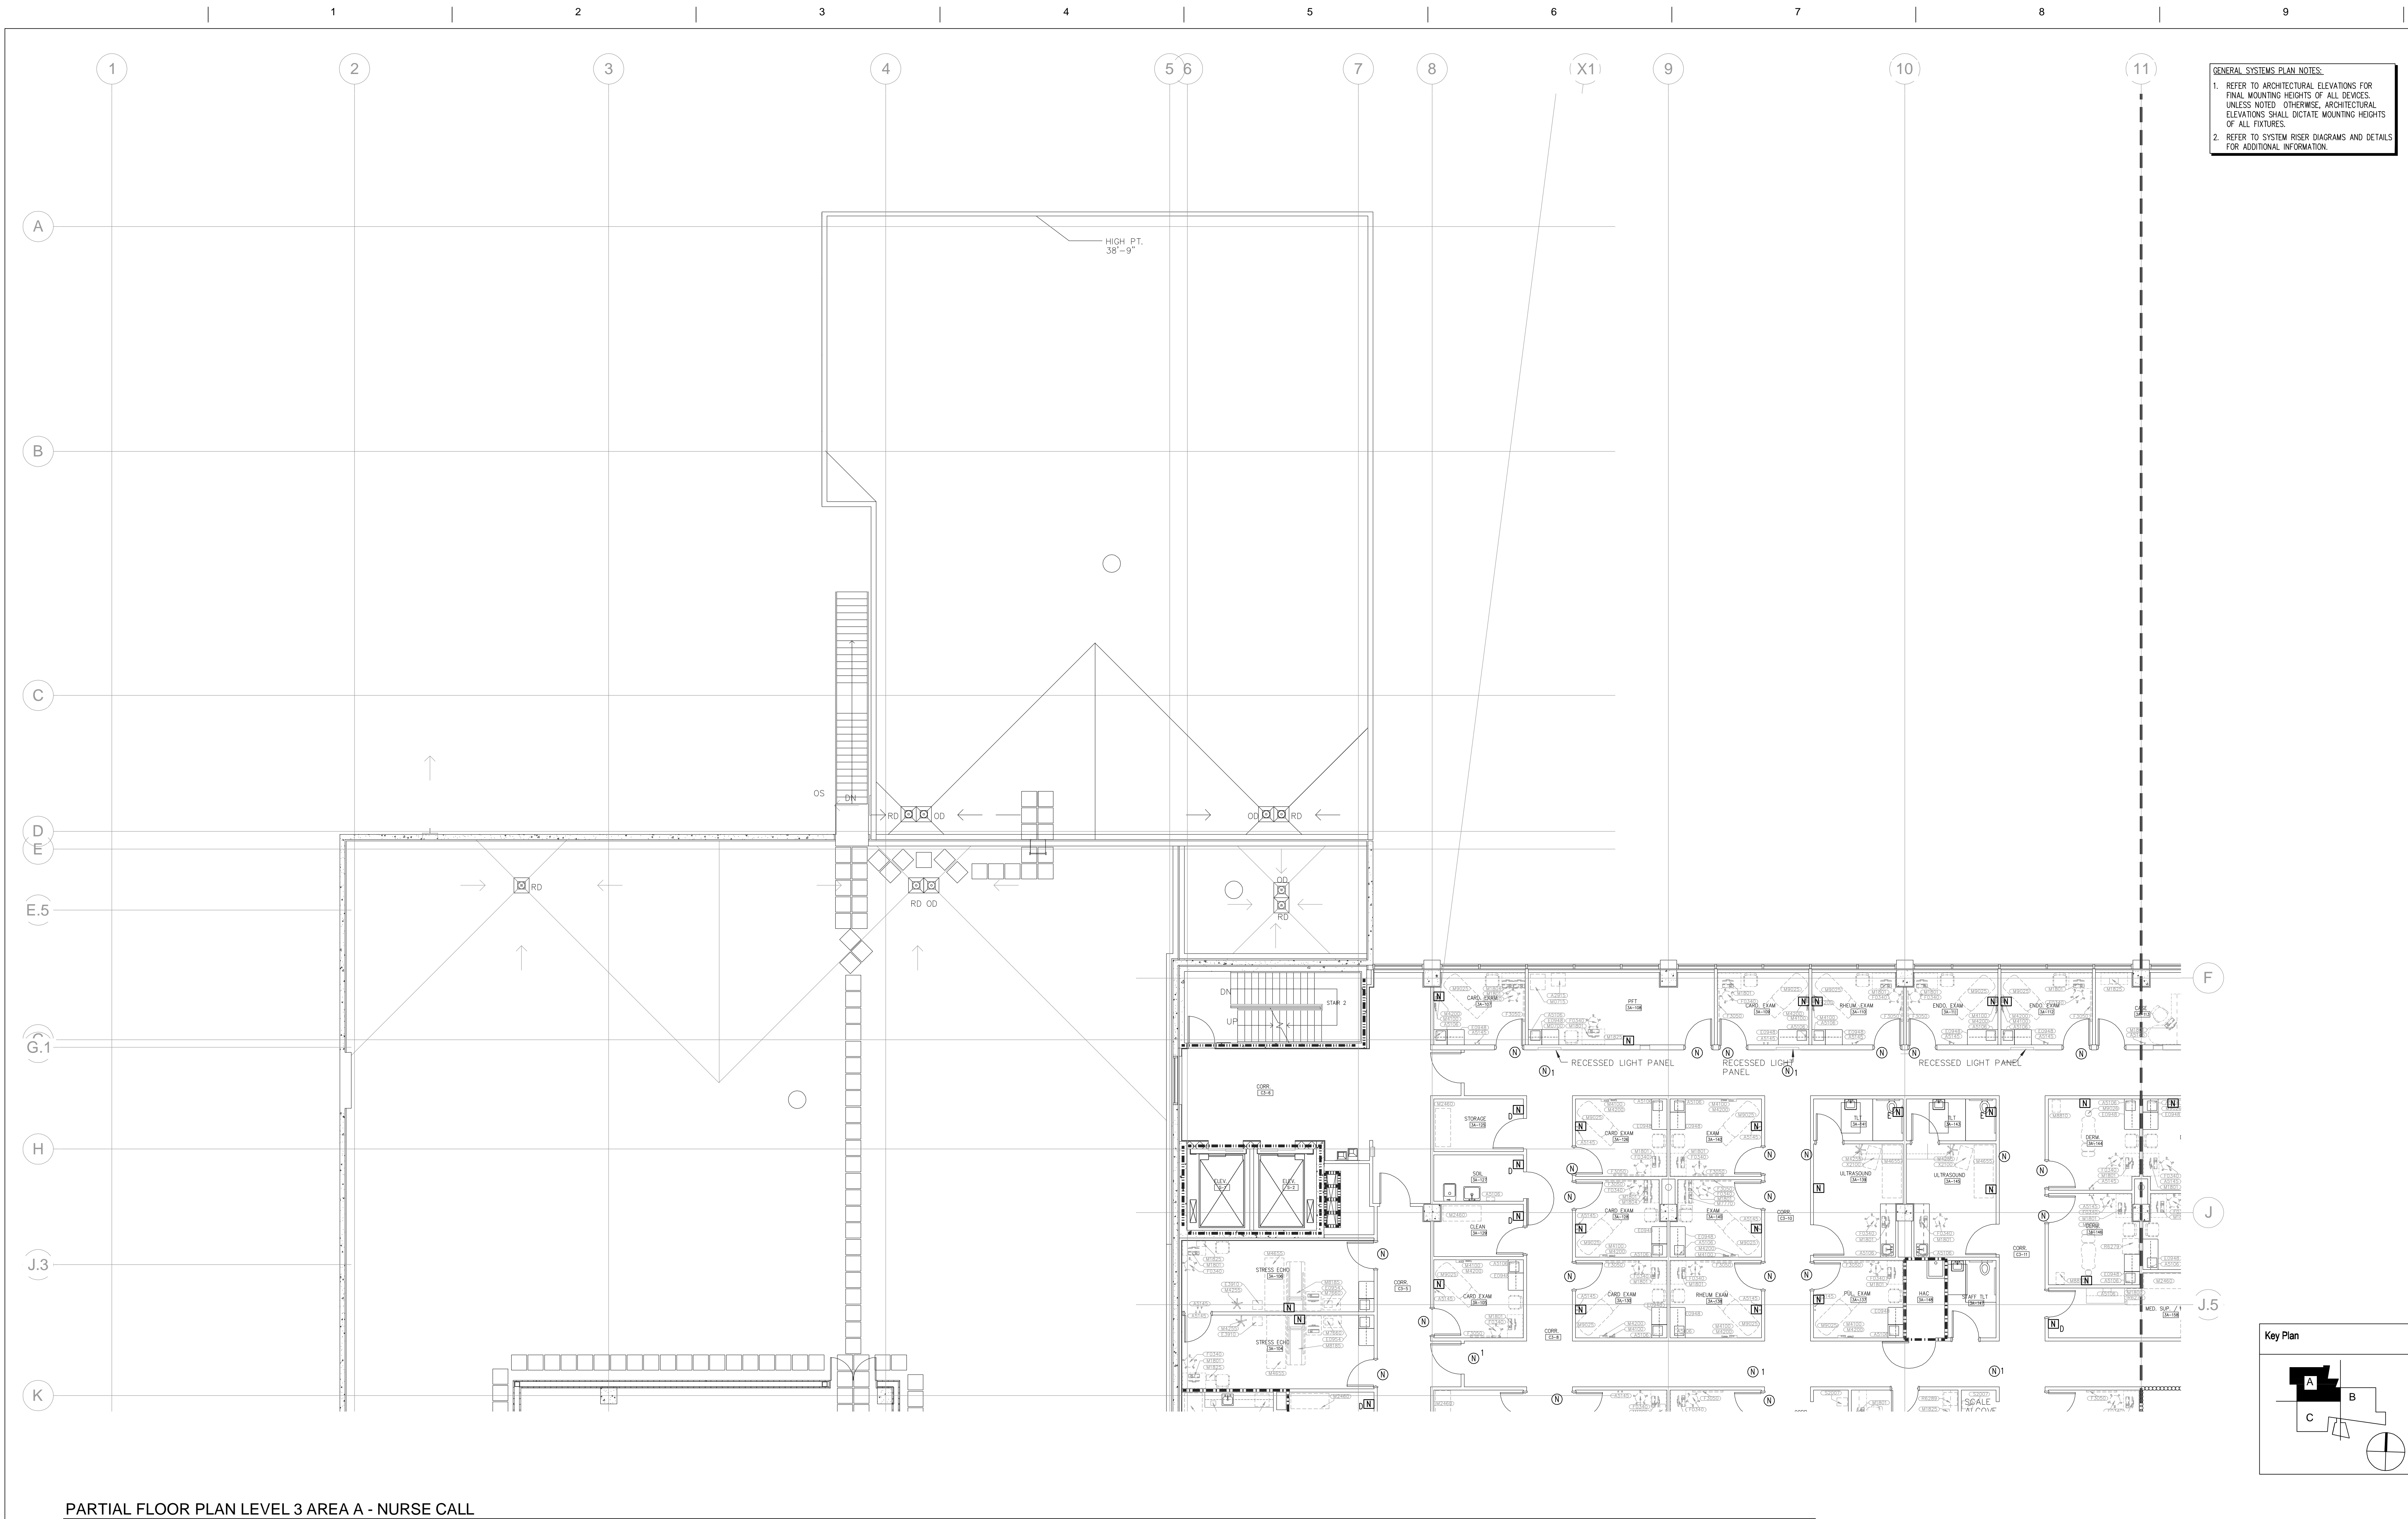

- GENERAL SYSTEMS PLAN NOTES:
1. REFER TO ARCHITECTURAL ELEVATIONS FOR FINAL MOUNTING HEIGHTS OF ALL DEVICES. UNLESS NOTED OTHERWISE, ARCHITECTURAL ELEVATIONS SHALL DICTATE MOUNTING HEIGHTS OF ALL FIXTURES.
  2. REFER TO SYSTEM RISER DIAGRAMS AND DETAILS FOR ADDITIONAL INFORMATION.

PARTIAL FLOOR PLAN LEVEL 3 AREA A - NURSE CALL

1/8" = 1'-0"

		<b>CONSULTANTS</b>		Leigh Ann Vogel, P.E. Florida License #56037		<b>ARCHITECT/ ENGINEERS:</b>		Drawing Title: <b>PARTIAL FLOOR PLAN LEVEL 3 AREA A - NURSE CALL</b>		Project Title Lee County Outpatient Clinic		Project Number 516CA2400		Office of Construction and Facilities Management	
		 255 S. Orange Avenue Suite 1800 Orlando, Florida 32801 Phone: 407-841-9050 Fax: 407-843-5445 www.tlc-engineers.com © Copyright 2008 TLC Engineering for Architecture, Inc. EB #0000015 TLC NO:108302		 HELLMUTH, OBATA & KASSABAUM, INC. ARCHITECTURE, ENGINEERING, PLANNING, INTERIORS, GRAPHICS, CONSULTING One Tampa City Center, Suite 1800, Tampa, FL 33602 Voice: (813) 229-0300 Fax: (813) 223-7110 Internet: http://www.hok.com FL Reg. AAC001139 All reproduction & intellectual property rights reserved © 2008 Contract No.: 6CA2400		Approved: <b>Checker</b>		Client Location Cape Coral, Florida		Drawing Number: <b>EY103-A</b>					
Revisions		Date		Seal				Date 12/07/12		Checked: LAV		Drawn CQS		