



KEY #	AIR VOLUME	AIR DEVICE TYPE	AIR DEVICE SIZE	KEY #	AIR VOLUME	AIR DEVICE TYPE	AIR DEVICE SIZE	KEY #	AIR VOLUME	AIR DEVICE TYPE	AIR DEVICE SIZE
1	400	SL	15" X 15"	17	815	SL	18" X 18"	33	140	R2	10" X 10"
2	140	SL	9" X 9"	18	415	SL	15" X 15"	34	160	R2	12" X 8"
3	100	SL	9" X 9"	19	340	SL	15" X 15"	35	320	R2	12" X 12"
4	220	SL	12" X 12"	20	360	SL	15" X 15"	36	300	R2	12" X 12"
5	180	SL	9" X 9"	21	420	SL	15" X 15"	37	140	R2	10" X 10"
6	320	SL	12" X 12"	22	120	SL	9" X 9"	38	190	R2	10" X 10"
7	300	SL	12" X 12"	23	540	SL	12" X 12"	39	200	R2	10" X 10"
8	160	SL	9" X 9"	24	1000	S3	60" W/5 SL0T	40	540	R3	18" X 12"
9	170	SL	9" X 9"	25	120	R2	12" X 6"	41	100	R3	10" X 10"
10	140	SL	9" X 9"	26	1540	R2	22" X 22"	42	340	SL	18" X 12"
11	190	SL	9" X 9"	27	800	R2	24" X 12"	43	680	R2	24" X 18"
12	110	SL	9" X 9"	28	790	R2	24" X 12"	44	160	E2	10" X 10"
13	80	SL	9" X 9"	29	780	R2	18" X 12"	45	1000	S2	60" W/5 SL0T
14	70	SL	9" X 9"	30	260	R2	12" X 12"	46	70	R3	8" X 6"
15	130	SL	9" X 9"	31	720	R2	22" X 10"	47	475	SL	15" X 15"
16	810	SL	18" X 18"	32	440	R3	22" X 10"	48	360	SL	12" X 12"

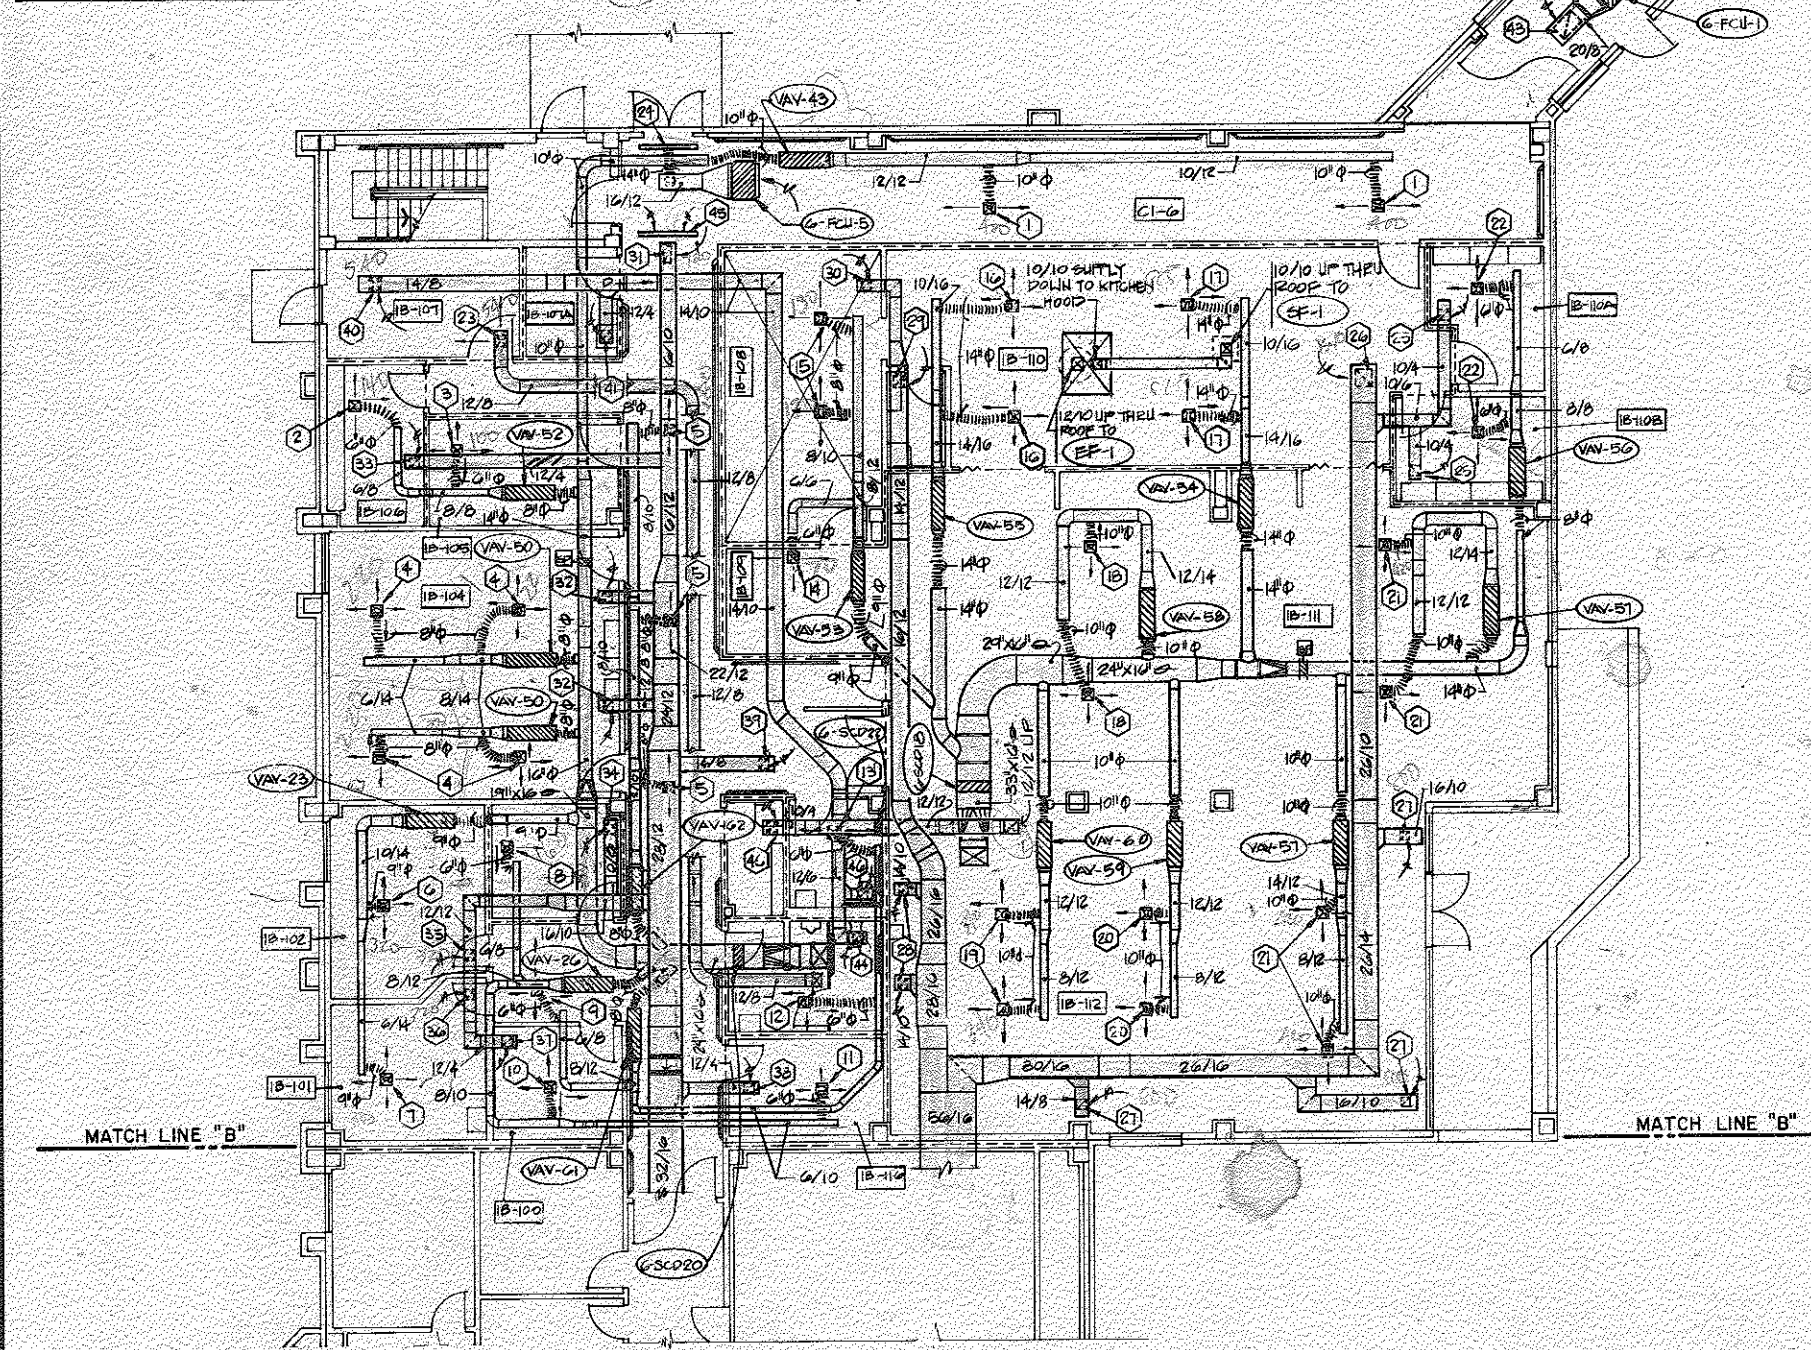

1 FIRST FLOOR PLAN-UNIT B-MECHANICAL
SCALE: 1/8" = 1'-0"

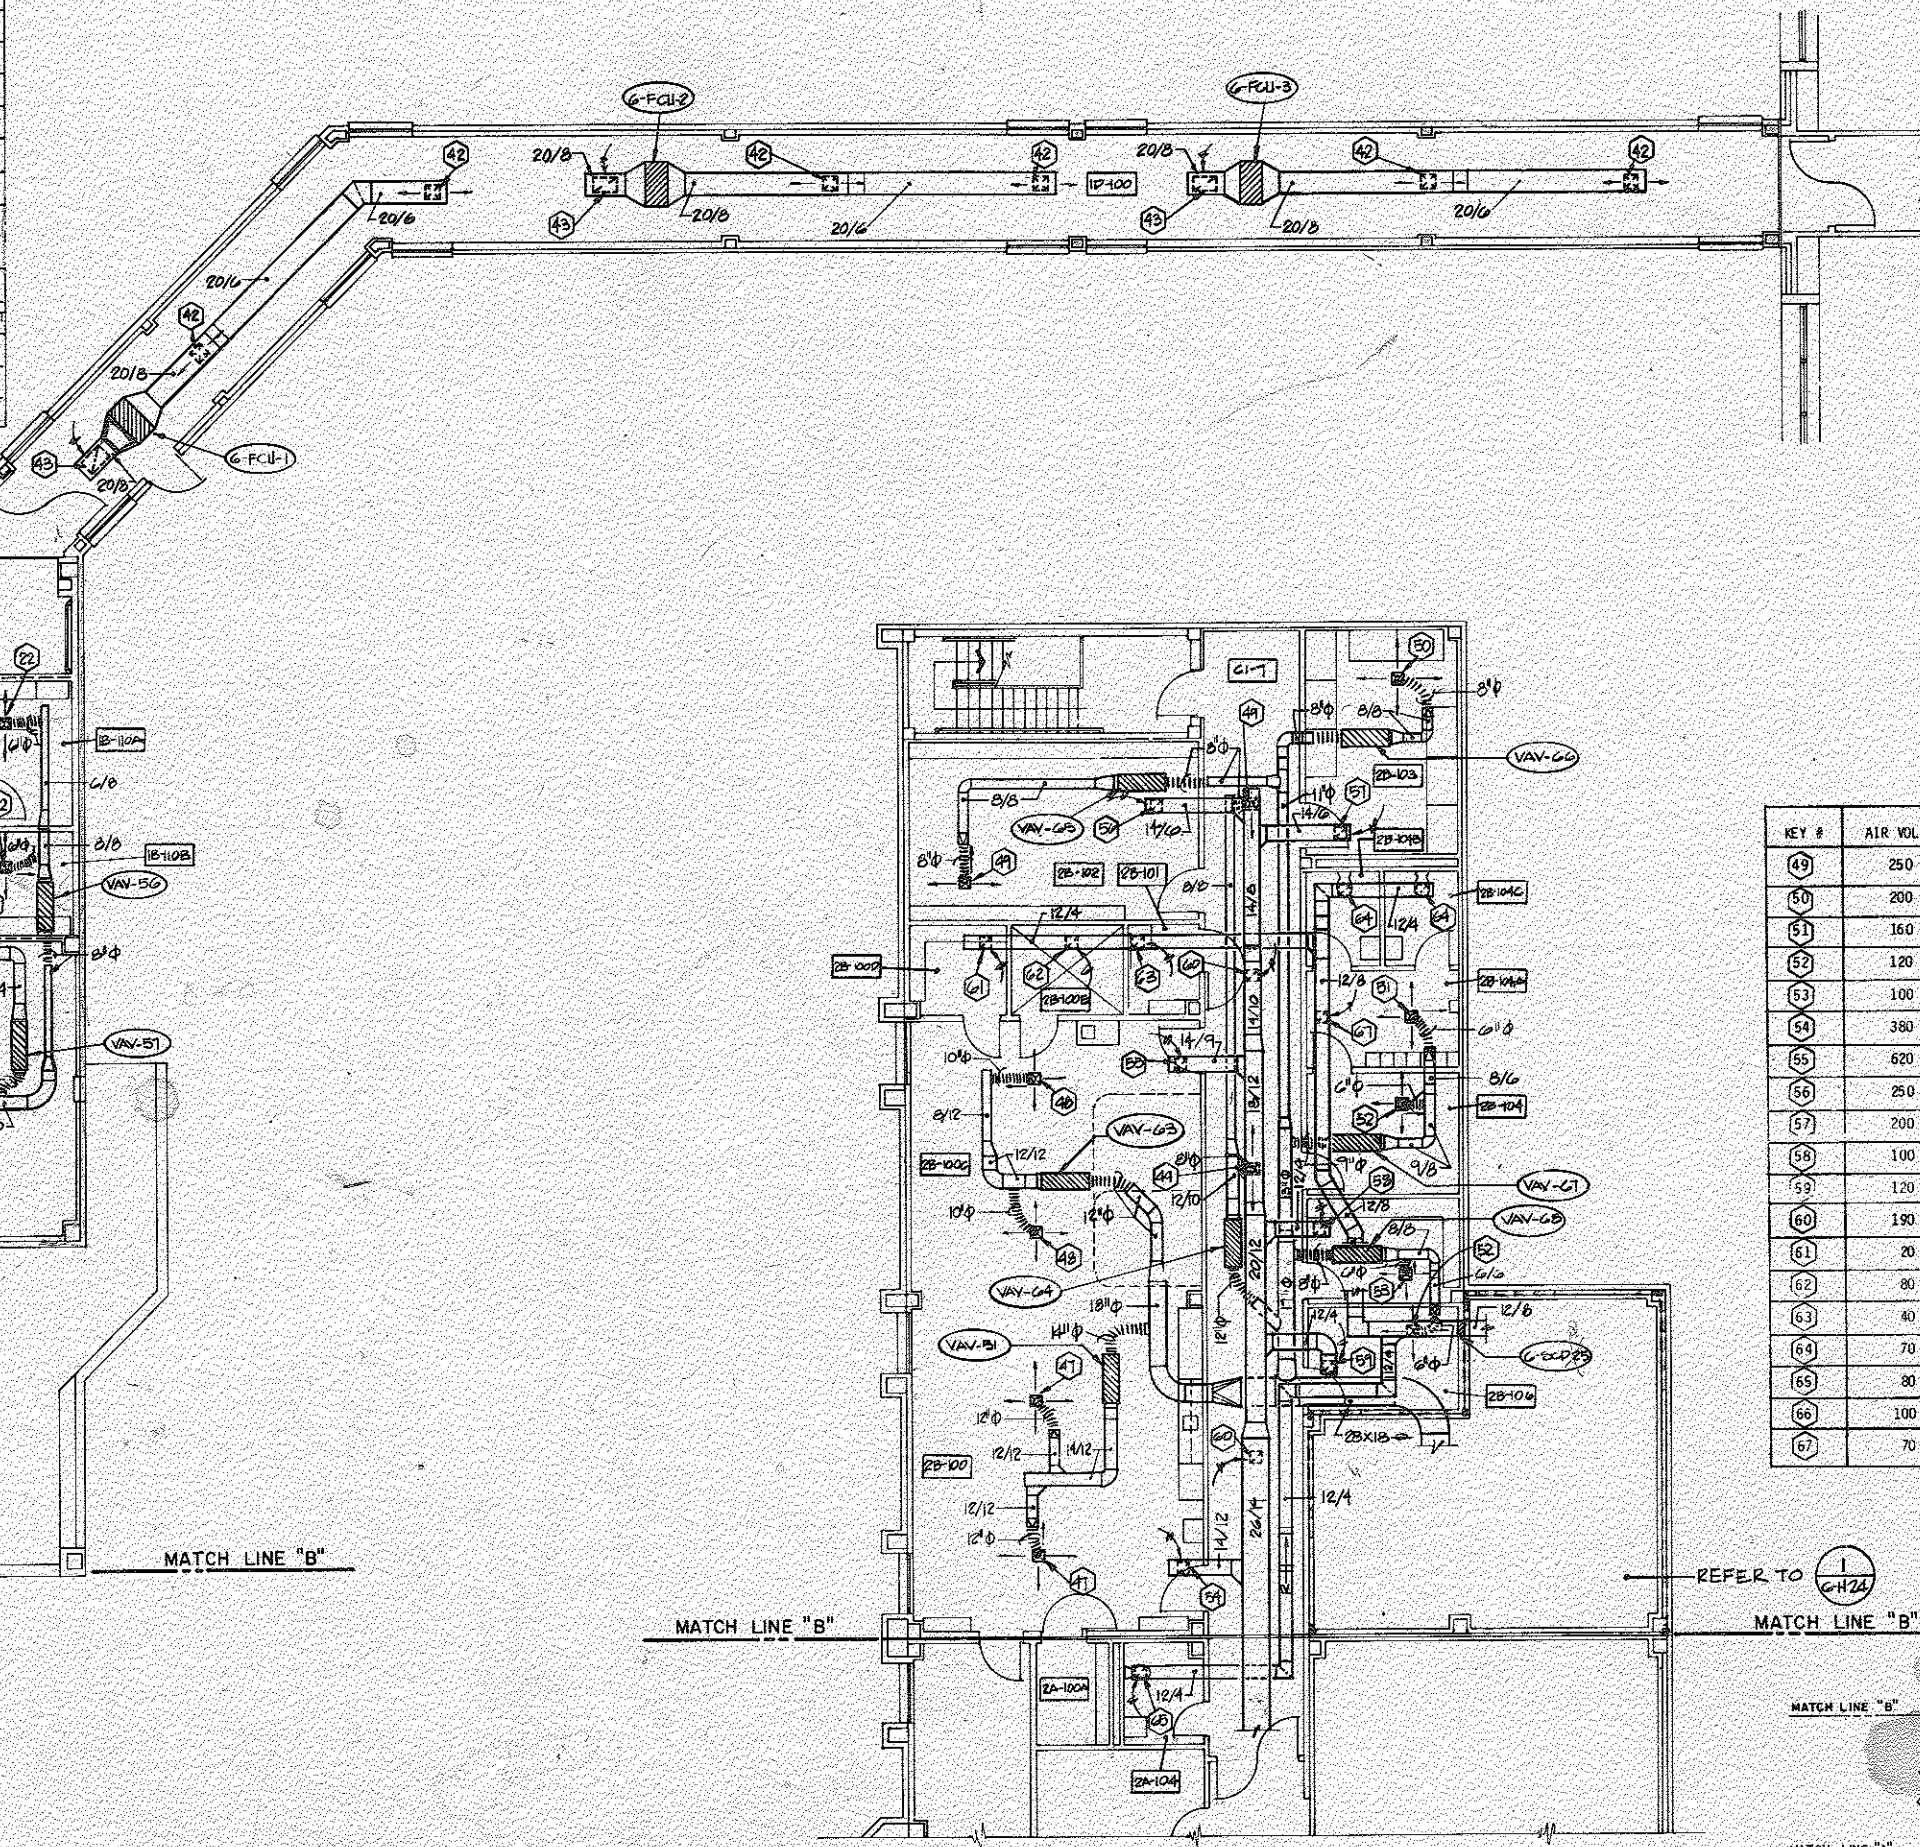

2 SECOND FLOOR PLAN-UNIT B-MECHANICAL
SCALE: 1/8" = 1'-0"

KEY #	AIR VOLUME	AIR DEVICE TYPE	AIR DEVICE SIZE
49	250	SL	12" X 12"
50	200	SL	12" X 12"
51	160	SL	10" X 10"
52	120	SL	10" X 10"
53	100	SL	9" X 9"
54	380	R2	24" X 12"
55	620	R2	24" X 12"
56	250	R2	12" X 12"
57	200	R2	10" X 10"
58	100	R2	10" X 10"
59	120	R2	10" X 10"
60	190	R2	10" X 10"
61	20	R2	10" X 10"
62	80	R2	10" X 10"
63	40	R2	10" X 10"
64	70	R2	10" X 10"
65	80	E2	10" X 10"
66	100	E2	8" X 6"
67	70	R2	10" X 10"

NUMBER	NAME
18-100	SOCIAL WORK
18-101	EXAM
18-102	PHARMACY PREP.
18-103	STAFF CONSULT.
18-104	CONFERENCE/CLASSROOM
18-105	SOILED LINEN
18-106	BLOG. RMNT. STOR.
18-107	SWITCHGEAR
18-107A	TRASH
18-108	DISHWASH
18-109	CART STORAGE
18-110	SERVING UNIT
18-110A	FOOD STORAGE
18-110B	NON-FOOD STORAGE
18-110C	HAC
18-111	DINING
18-112	RECREATION
18-113	WOMEN'S TOILET
18-114	HAC
18-115	MEN'S TOILET
18-116	DIETITIAN
C1-5	CORRIDOR
C1-6	CORRIDOR
28-100	OCCUPATIONAL THERAPY
28-100C	PHYSICAL ACTIVITIES
28-100D	STORAGE
28-100E	HYDRO
28-101	HAC
28-102	GENERAL STORAGE
28-103	CLOTHING STORAGE
28-104	STAFF LOUNGE
28-104A	STAFF LOCKERS
28-104B	STAFF TOILET
28-104C	STAFF TOILET
28-105	BLOG. MGT. STORE
28-106	STAFF CONSULT.
C2-7	CORRIDOR

KEY PLAN

Revisions 1. 6-11-14 2. 6-11-14		PHELPS & SIMMONS & GARZA ARCHITECTS 5545 Fredricksburg Road Suite 100 San Antonio, Texas 78229 GOETTING & ASSOCIATES, INC. MECHANICAL/ELECTRICAL ENGINEERS 535 GPM South 530 Antonio, Texas 78216 REYNOLDS SCHLATTNER CHETTER & ASSOC., INC. STRUCTURAL ENGINEERS Congress Tower, 1000 12th St. N. MAIN San Antonio, Texas 78212		Drawing Title FIRST & SECOND FLOOR PLANS UNIT "B" - MECHANICAL	Project Title 120 BED NURSING HOME CARE UNIT	Date APR. 16, 1984
				Approved Project Director 	Building Number 6	Checked Drawn
				Location VAMC SAN ANTONIO, TEXAS	Drawing No. 6-H14	Veterans Administration