


0 6 1 0 2 0 6 0 2 0 6 0 4 0 8 0 4 0 12 24

three inches = one foot
one and one-half inches = one foot
one inch = one foot
three-quarters inch = one foot
one-half inch = one foot
three-eighths inch = one foot
one-quarter inch = one foot
one-eighth inch = one foot




Computer Filenames:

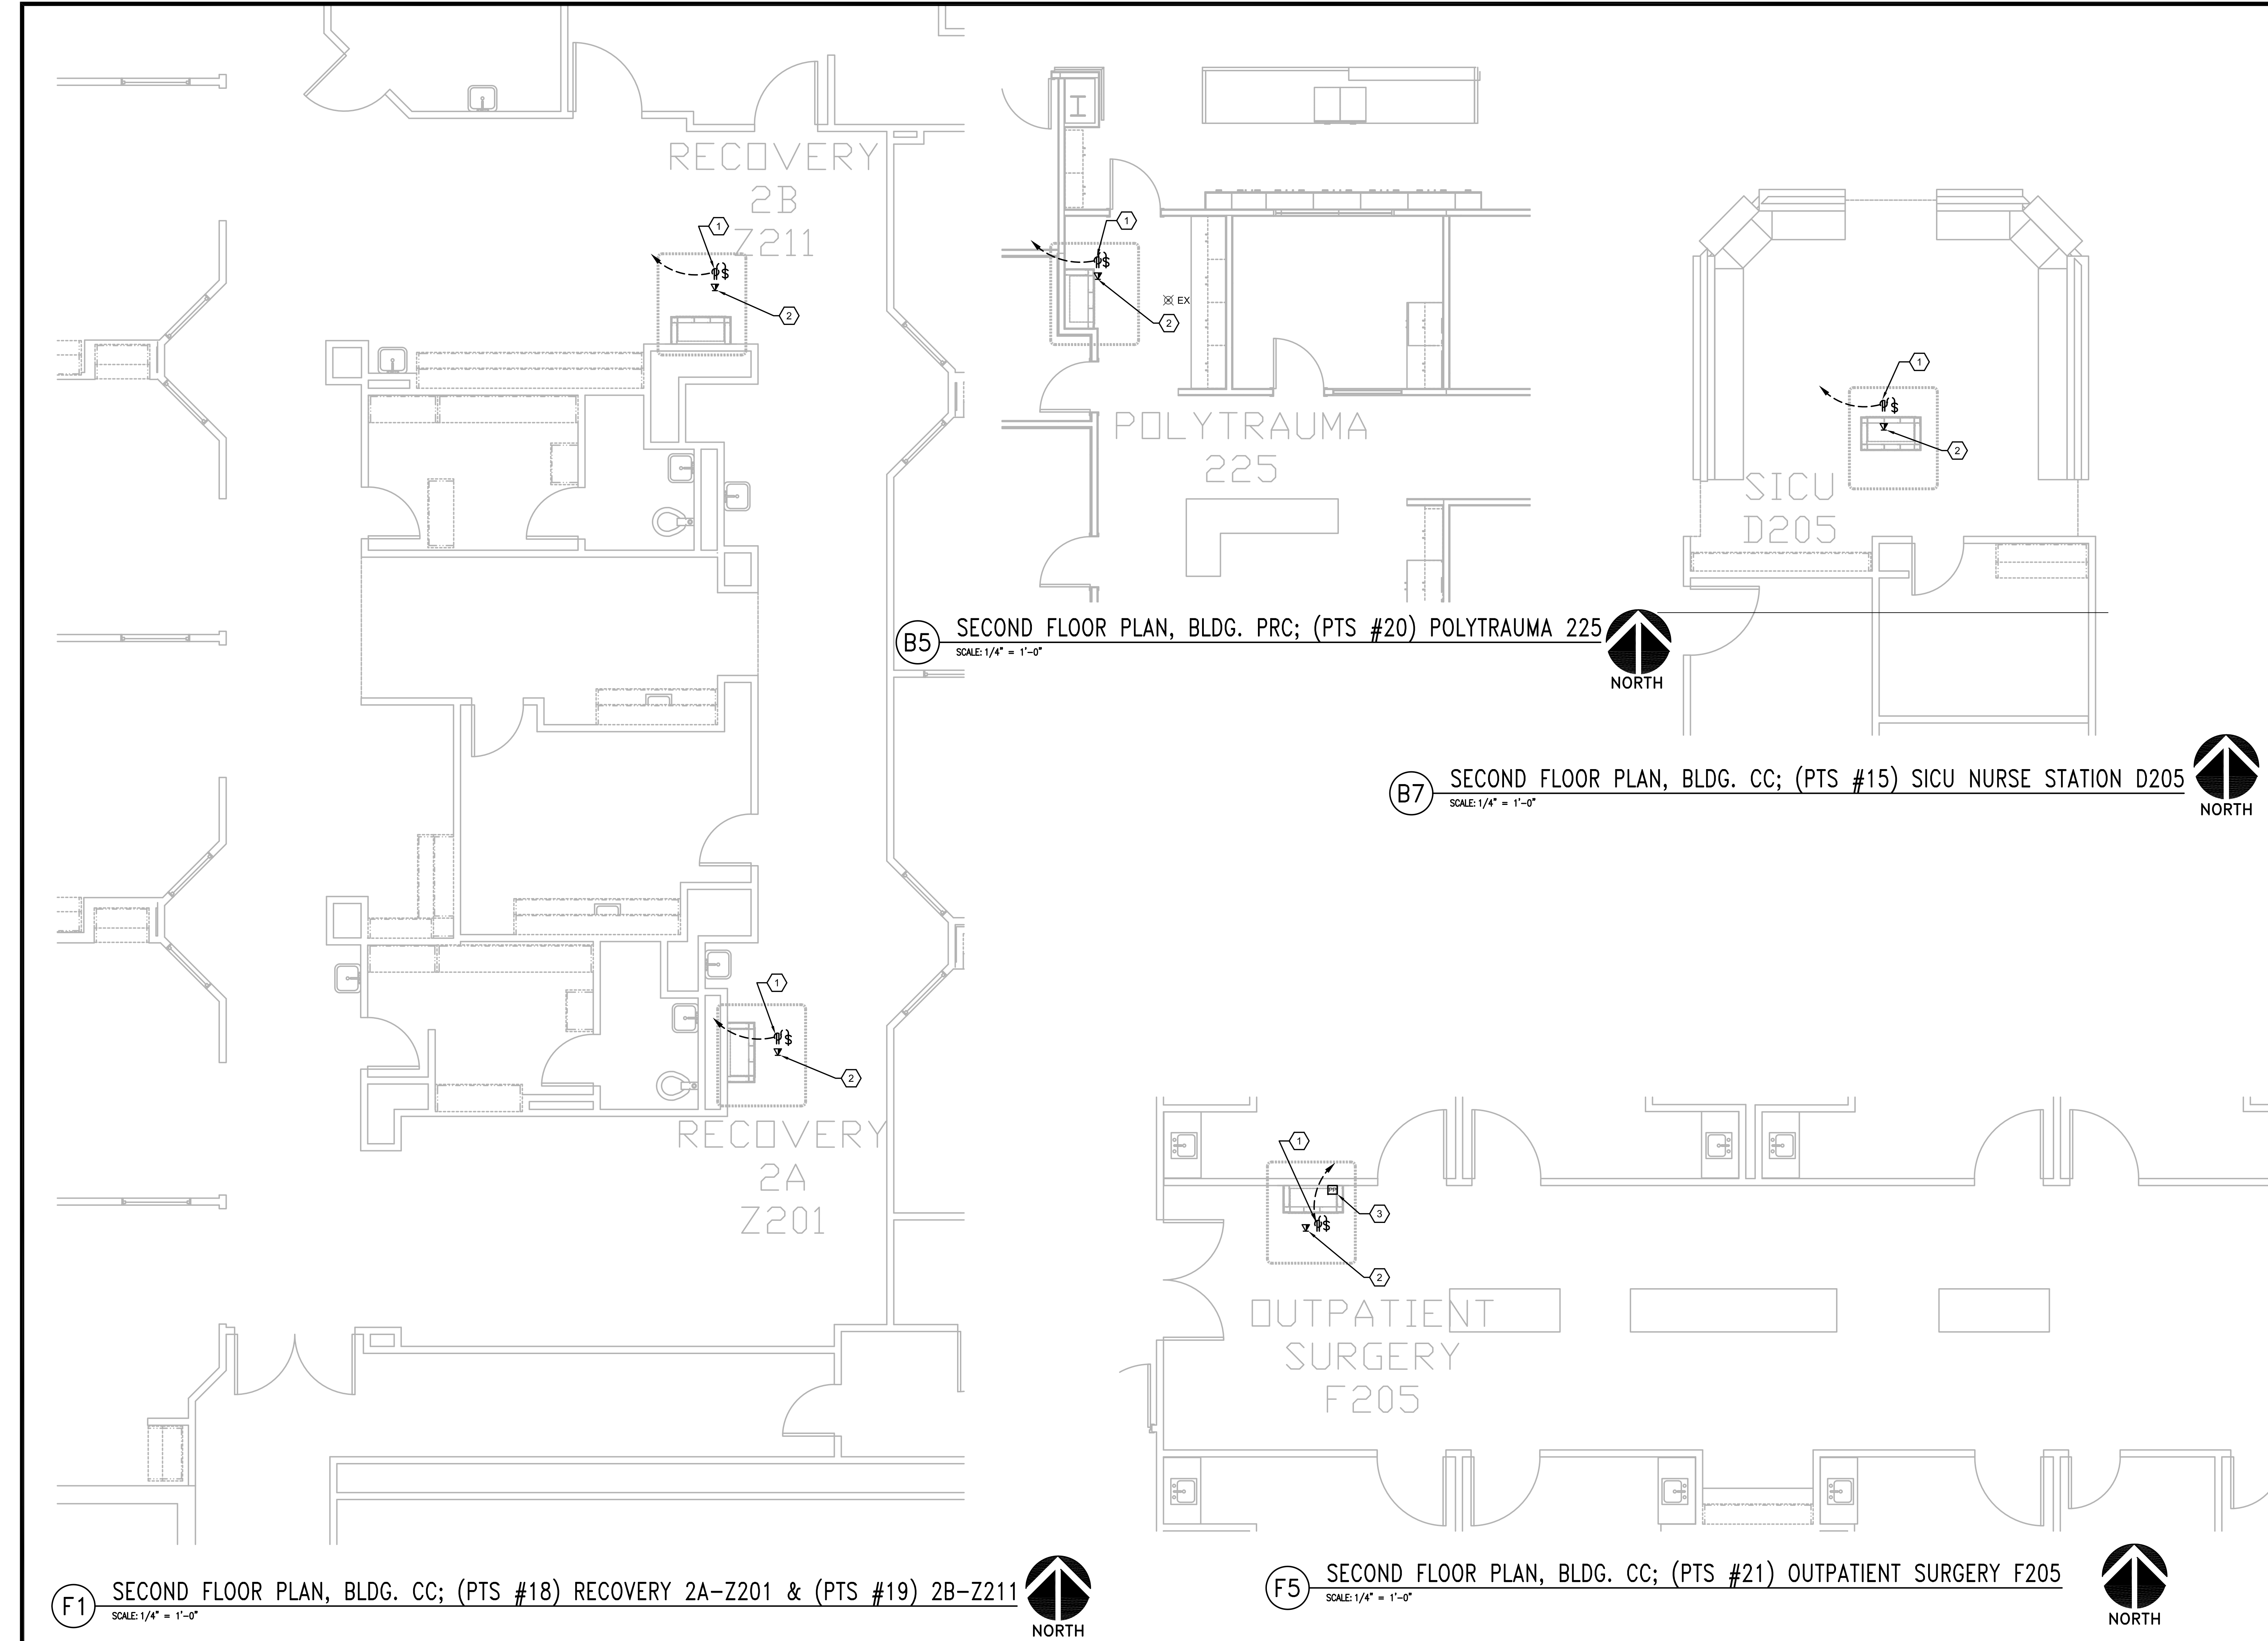

- GENERAL NOTES:**
- REFER TO MEP000 FOR ADDITIONAL NOTES.
 - THE PNEUMATIC TUBE SYSTEM INFRASTRUCTURE DESIGN HEREIN BASED ON SWISSLOG HEALTHCARE SOLUTIONS EQUIPMENT. THE VA RESERVES THE RIGHT FOR APPROVAL OF ALTERNATE PNEUMATIC TUBE SYSTEMS MANUFACTURER.
 - CONTRACTOR SHALL RE-ROUTE ANY DUCTWORK, MECHANICAL OR PLUMBING PIPING, DAMPERS OR TERMINAL BOXES LOCATED IN THE CEILING PLENUM AS REQUIRED TO ACCOMMODATE NEW PNEUMATIC OR ASSOCIATED EQUIPMENT.
 - REFER E109 THRU E111 FOR PANELBOARD LOCATIONS AND ADDITIONAL INFORMATION.
- NOTES BY SYMBOL: '⬡'**
- PROVIDE 120V, 20A, DUPLEX RECEPTION WITH TOGGLE SWITCH BEHIND CABINET OF THE PNEUMATIC TUBE SYSTEM STATION.
 - PROVIDE TELEPHONE/DATA OUTLET WITH ETHERNET, CAT5 OUTLET CAPABILITY BEHIND PNEUMATIC TUBE SYSTEM STATION.
 - REMOVE AND RETAIN EXISTING AUTOMATIC PUSH BUTTON, ASSOCIATED BRANCH CIRCUIT AND WIRING TO BE RELOCATED DOWN WALL AS REQUIRED TO ALLOW FOR INSTALLATION OF PNEUMATIC TUBE CABINET. REINSTALL AS CLOSE AS POSSIBLE TO THE ORIGINAL LOCATION.

F1 SECOND FLOOR PLAN, BLDG. CC; (PTS #18) RECOVERY 2A-Z201 & (PTS #19) 2B-Z211
SCALE: 1/4" = 1'-0"

F5 SECOND FLOOR PLAN, BLDG. CC; (PTS #21) OUTPATIENT SURGERY F205
SCALE: 1/4" = 1'-0"

<div>Revisions</div> <div>Date</div>		<div><div>2201 N Collins, Suite 295 Arlington, Texas 76011-2659 (817) 461-0333 Fax: (817) 461-1025 E: info@fei-engineering.com FBI PROJECT # 13069</div><div>FEI Project No.: 13069</div></div>	<div><div>Architecture ■ Planning ■ Interior Design 4949 Addison Circle ■ Addison, Texas 75001</div><div>MPI Project No.: 8130707</div></div>	<div>Seal</div>	<div>Seal</div>	<div><div>BUILDINGS CC & CLC SECOND FLOOR PLAN PTS STATION LOCATIONS - ELECTRICAL</div><div>Approved: Area Project Manager</div></div>	<div><div>Project Title AUDIE L. MURPHY VA HOSPITAL PNEUMATIC TUBING SYSTEM</div><div><div>Building Number CC, CLC</div><div>Checked SLT</div><div>Drawn AOP</div></div><div><div>Location 7400 Merton Minter San Antonio, TX 78229</div></div></div>	<div><div>Date 04/24/15</div><div>Project No. 671-13-104</div><div>Drawing No. E404</div><div>Dwg. of</div></div>	<div><div>STVHCS San Antonio, Texas</div></div>
--------------------------------------	--	---	--	-----------------	-----------------	--	---	---	--