

GENERAL NOTES

THE EXISTING AREAS SHOWN ARE FULLY SPRINKLERED.

SPRINKLER SYSTEM SHALL BE DESIGNED IN ACCORDANCE WITH NFPA 13 (2010), THE INTERNATIONAL BUILDING CODE (2006) AND CONTRACT DOCUMENTS. PROVIDE SHOP DRAWINGS AND EQUIPMENT SUBMITTALS FOR REVIEW BY ENGINEER, AHJ AND OWNER.



IN RENOVATED AREAS THAT ARE PRESENTLY SPRINKLERED, RELOCATE OR REPLACE EXISTING SPRINKLERS/PIPING AS NECESSARY TO CONFORM TO NEW WALL, DUCTWORK, CEILING AND LIGHTING CONFIGURATIONS.

FIELD VERIFY EXISTING PIPING SIZES AND LOCATIONS.


NOT ALL EXISTING WORK IS SHOWN AND THAT SHOWN IS IN ITS APPROXIMATE LOCATION AND ARRANGEMENT. EXACT LOCATION, ARRANGEMENT AND SIZES SHALL BE VERIFIED ON THE JOB BEFORE PROCEEDING WITH ANY NEW WORK.

EXACT LOCATIONS AND ROUGHING REQUIREMENTS FOR PIPING AND EQUIPMENT SHALL BE DETERMINED FROM ARCHITECTURAL DRAWINGS, LARGE SCALE DETAILS AND APPROVED MANUFACTURER'S SHOP DRAWINGS. PARTICULAR ATTENTION SHALL BE DIRECTED TO EQUIPMENT AND FIXTURES FURNISHED UNDER OTHER DIVISIONS.

IN FIRE WALLS, PACK ANNULAR SPACE BETWEEN PIPE AND WALL WITH FIRESTOP COMPOUND IN ACCORDANCE WITH ITS U.L. LISTING.

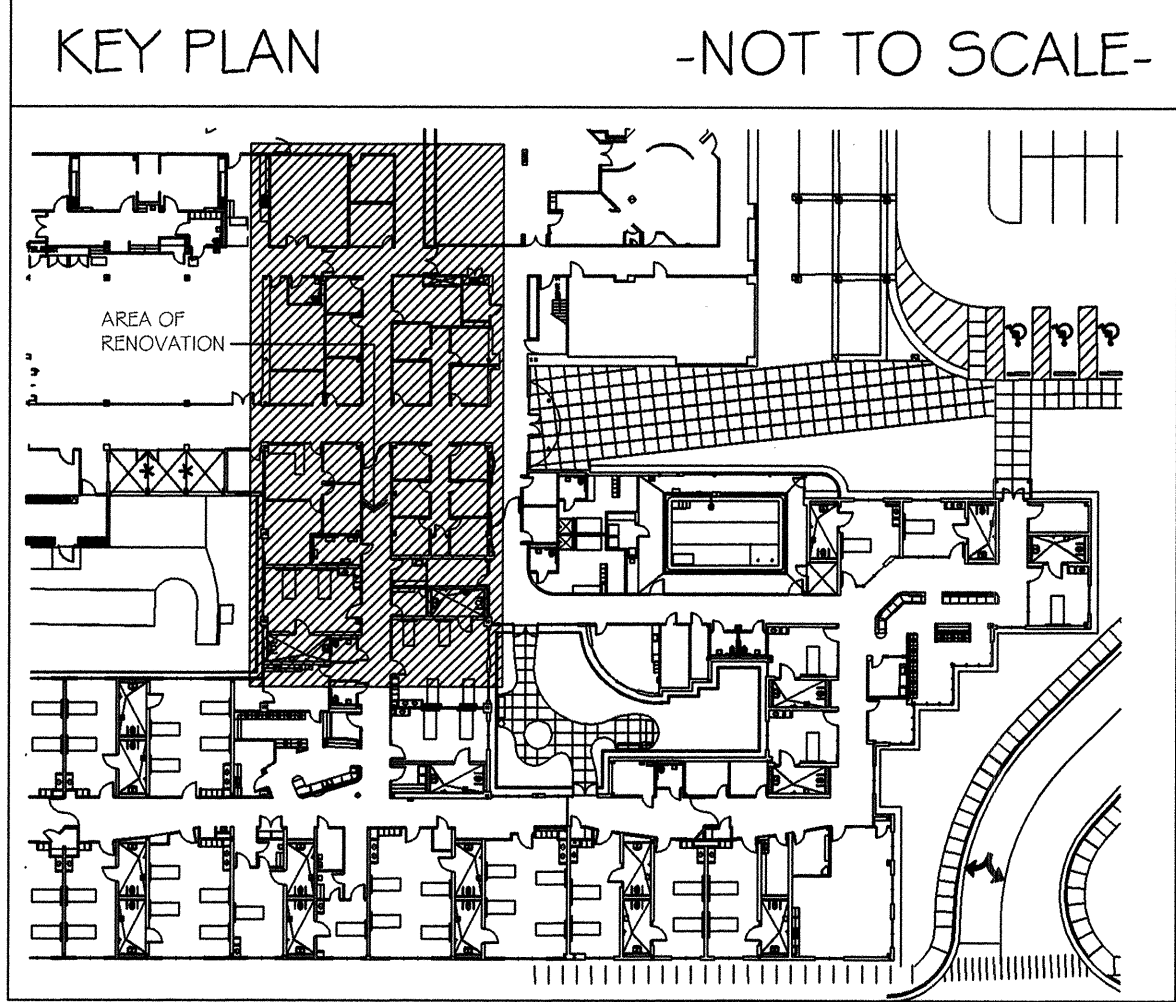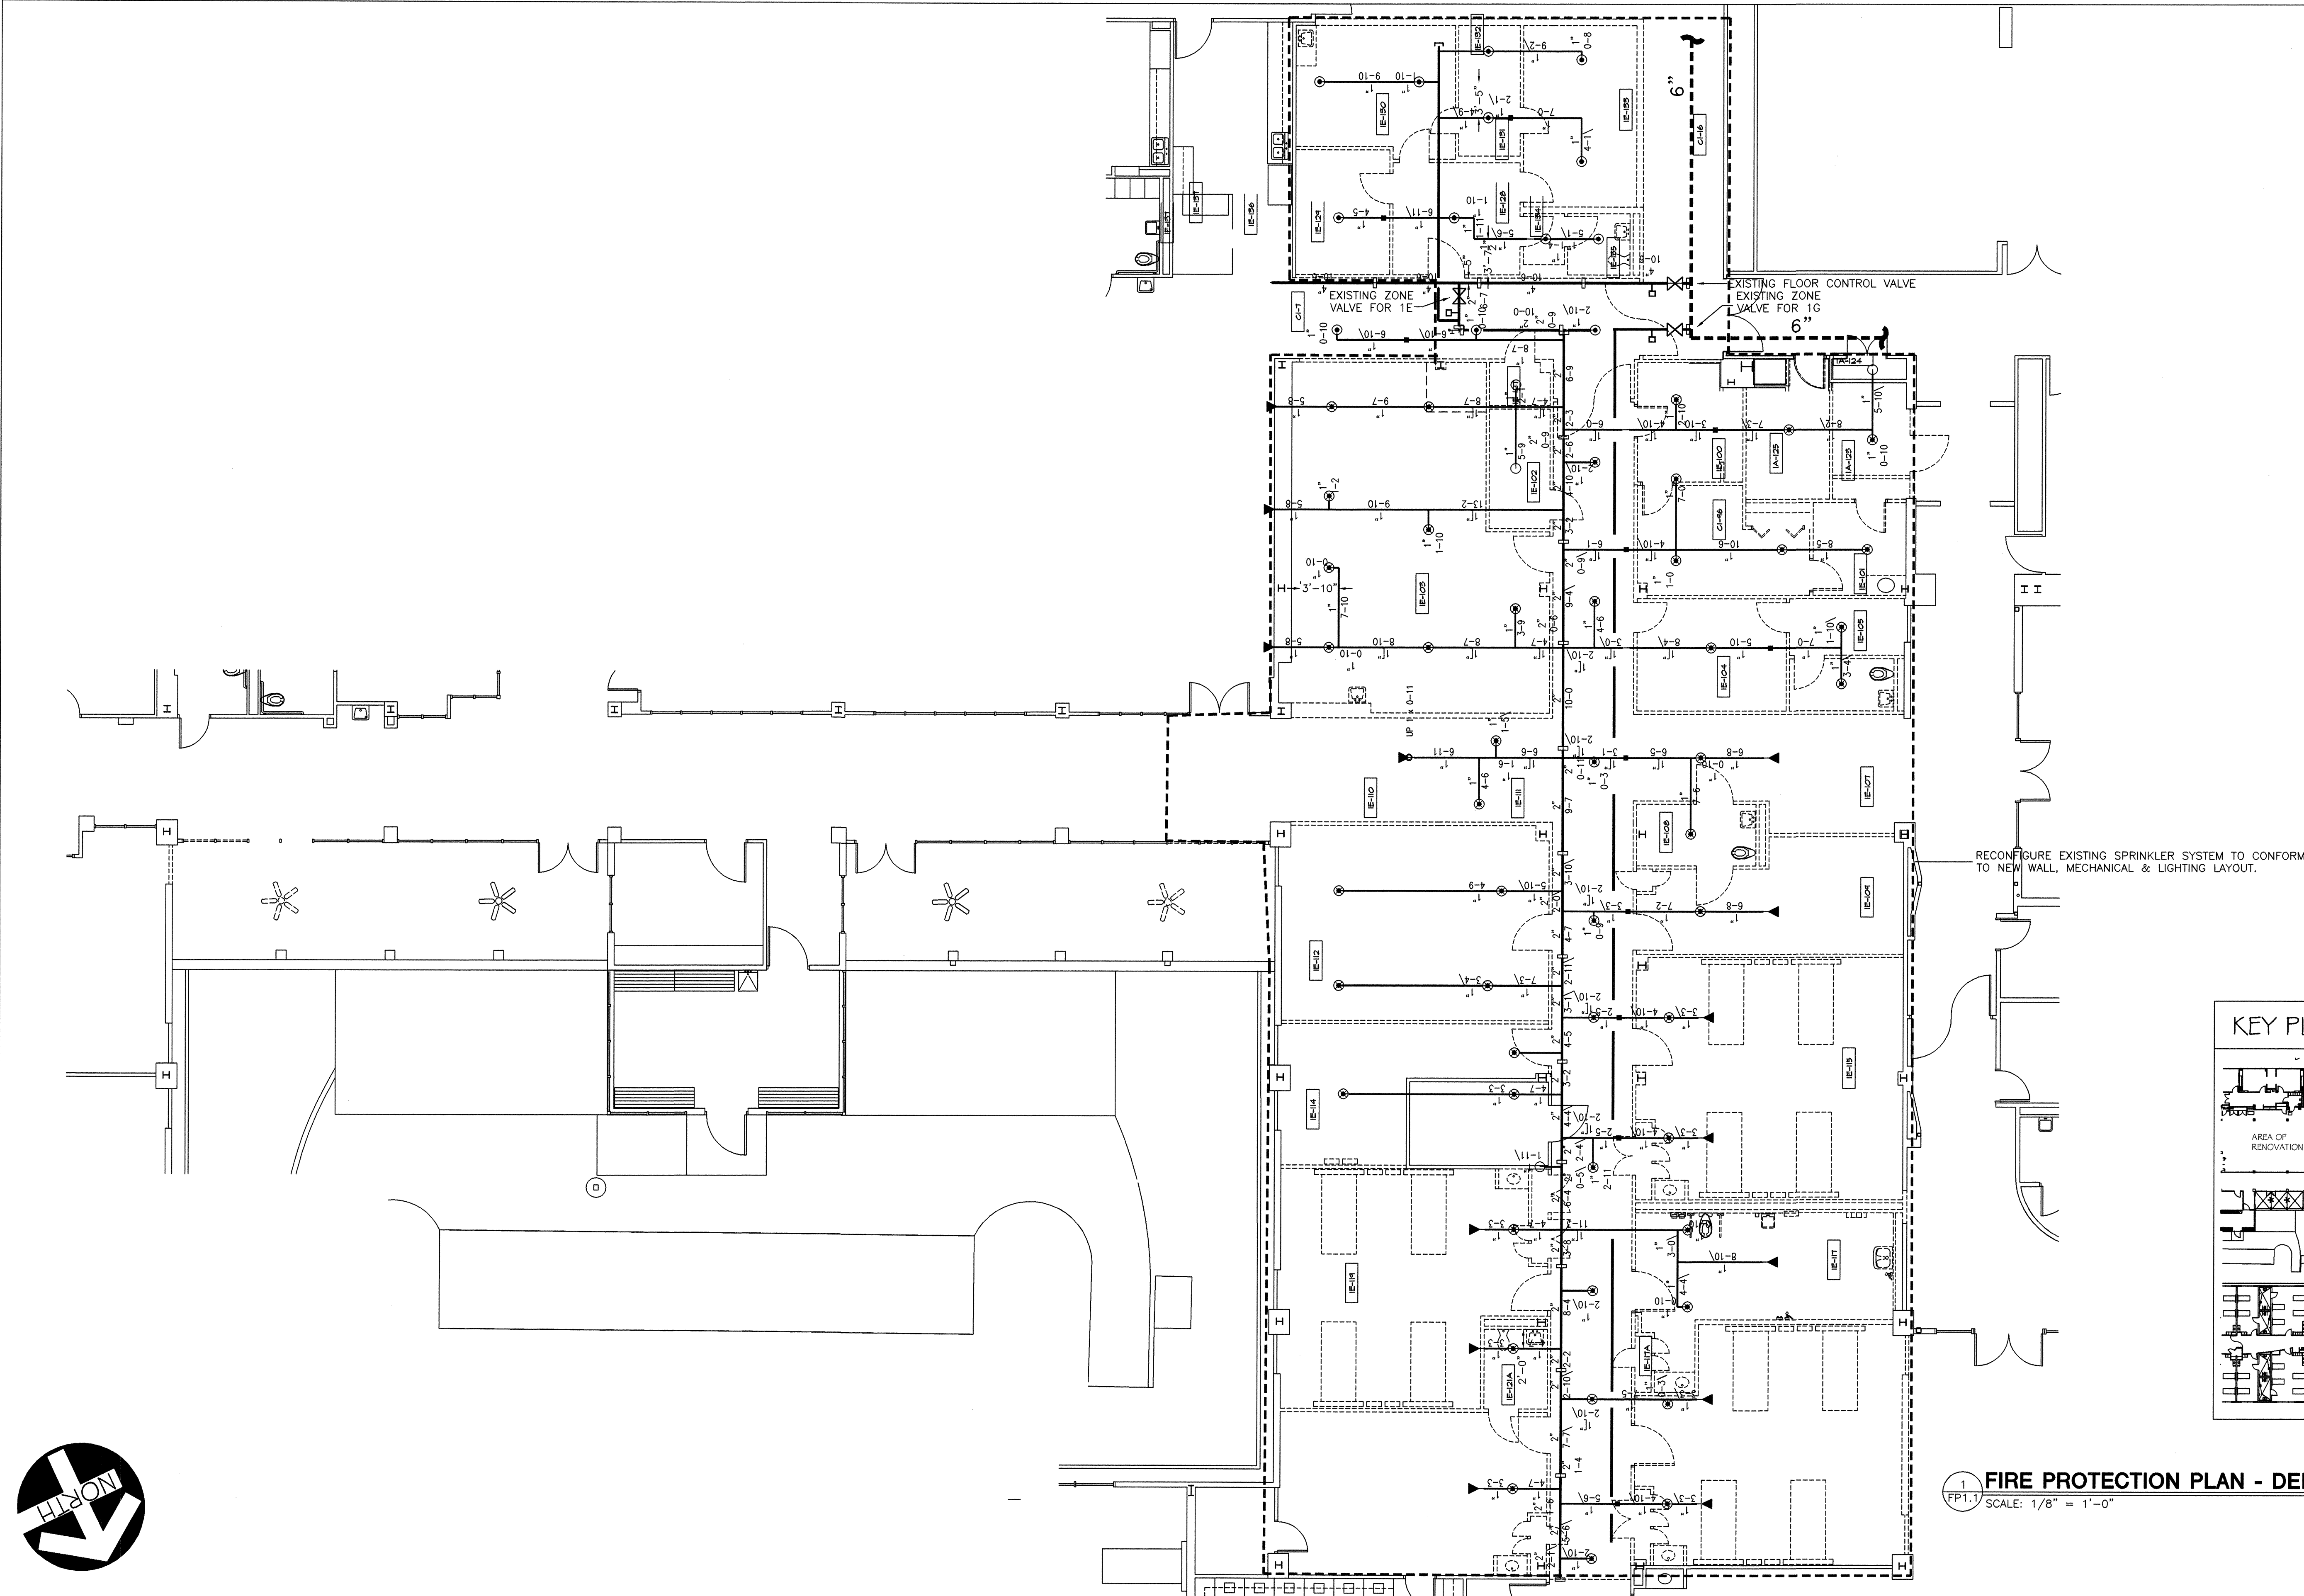

 
1 FIRE PROTECTION PLAN - DEMOLITION
SCALE: 1/8" = 1'-0"



PLOT DATE: 04/27/11
FILENAME: 08101M1
BASESHT: 08101BDR.BSA,KY1
PLOT SCALE: 1 = 96
PFA

COPYRIGHT © 2008
PRIETT, FORD & ASSOCIATES, INC.
AUGUSTA, GA 30601 (706) 722-9969



REVISIONS:	DATE:	DRAWN BY:
		JCP
		CHECKED BY:
		JMF
		
ARCHITECTS PROJECT NO. : 2812		



VIRGO GAMBILL
ARCHITECTS
2531 CENTER WEST PARKWAY,
SUITE 200
AUGUSTA, GEORGIA 30909
(706) 736-3661

MEMBERS OF THE
AMERICAN INSTITUTE
OF ARCHITECTS

THIS DOCUMENT IS PROPERTY OF VIRGO GAMBILL ARCHITECTS. THE UNAUTHORIZED REPRODUCTION, COPYING, OR OTHERWISE USE OF THIS DOCUMENT IS STRICTLY PROHIBITED AND ANY INFRINGEMENT THEREUPON IS SUBJECT TO LEGAL ACTION. © VIRGO GAMBILL ARCHITECTS

APPROVED BY:
MEDICAL CENTER DIRECTOR

APPROVED BY:
FACILITY MANAGEMENT SERV LINE EXEC

PROJECT TITLE:
RENOVATE "E" WING
BUILDING 801, DOWNTOWN DIVISION
AUGUSTA, GEORGIA

DRAWING TITLE:
FIRE PROTECTION PLAN - DEMOLITION

DATE:
APRIL 29, 2011

VA PROJECT NO.
509-318E

DRAWING NO.
801-FP1.1
DWG. 23 of 44



Department of Veterans Affairs
VAMC Augusta, Georgia
Engineering Department (138)