


- NOTES:**
- 1 FOR MICROWAVE, MOUNT AT 66" A.F.F.
 - 2 MOUNT RECEPTACLE UNDER COMMON COVER PLATE WITH SWITCH. PROVIDE DIVIDER PLATE
 - 3 EMERGENCY JUNCTION BOX FOR HEAD WALL UNIT. CONNECT ONE EMERGENCY CIRCUIT TO DEDICATED EMERGENCY RECEPTACLE IN HEAD WALL UNIT AND CONNECT OTHER EMERGENCY CIRCUIT TO REMAINING EMERGENCY RECEPTABLES IN HEAD WALL UNIT AND BED LOCATOR
 - 4 EMERGENCY JUNCTION BOX FOR BED LOCATOR UNIT
 - 5 NORMAL JUNCTION BOX FOR HEAD WALL UNIT. CONNECT NORMAL CIRCUIT TO NORMAL RECEPTACLE IN HEAD WALL UNIT AND BED LOCATOR UNIT
 - 6 NORMAL JUNCTION BOX FOR BED LOCATOR UNIT. PROVIDE CONNECTION BETWEEN BED RECEPTACLE AND LIGHT SHUT OFF SWITCH
 - 7 OVER BED LIGHT. PROVIDE CONNECTION BETWEEN OVER BED LIGHT AND LOW VOLTAGE SWITCH IN HEAD WALL UNIT
 - 8 TO SOARE 201 CIRCUIT BREAKER, REVISE DIRECRORY
 - 9 MOUNT TO BACK BOARD
 - 10 EACH HOT SHALL HAVE A DEDICATED NEUTRAL
 - 11 MOUNT ABOVE CEILING FOR PATIENT LIFT, COORDINATE LOCATION PRIOR TO INSTALLATION.
 - 12 CONNECT TO EMERGENCY RECEPTACLE CIRCUIT SERVING PATIENT HEAD WALL UNIT
 - 13 FOR DOOR PUSH BUTTON
 - 14 MAKE FINAL CONNECTION TO DOOR CONTROLLER




1 POWER PLAN
801-E2.0 SCALE: 1/8"=1'-0"

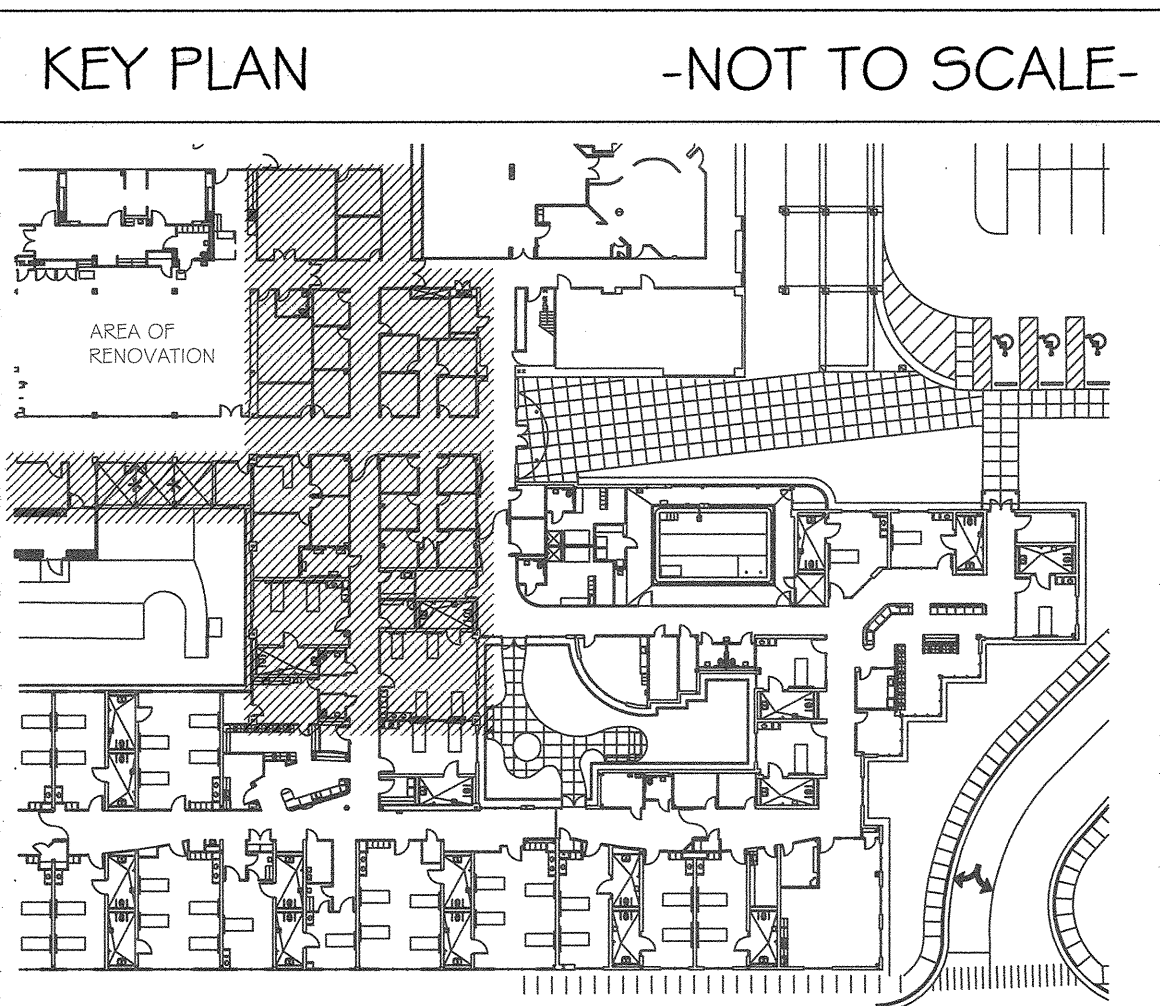

EDC ELECTRICAL ENGINEERS
1201 BROAD ST., SUITE 1-A
AUGUSTA, GA 30901
PH: (706) 724-3551
FAX: (706) 724-8807
CONSULTANTS IN: EDC PROJECT #: 11033

REVISIONS:	DATE:

DRAWN BY:	S. THOMAS
CHECKED BY:	M. MONGRUE

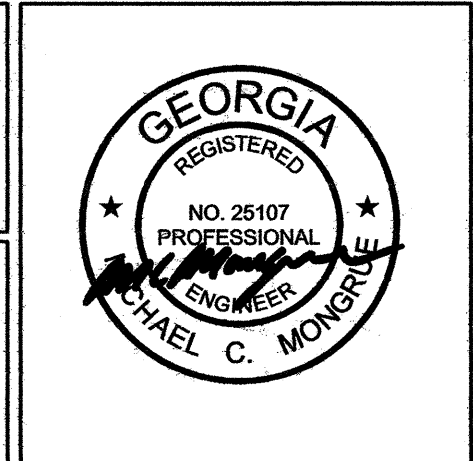

VIRGO GAMBILL
ARCHITECTS
2531 CENTER WEST PARKWAY,
SUITE 200
AUGUSTA, GEORGIA 30909
(706) 736-3661

MEMBERS OF THE
AMERICAN INSTITUTE
OF ARCHITECTS

THIS DOCUMENT IS PROPERTY OF VIRGO GAMBILL ARCHITECTS. THE UNAUTHORIZED REPRODUCTION, COPYING, OR OTHERWISE USE OF THIS DOCUMENT IS STRICTLY PROHIBITED AND ANY INFRINGEMENT THEREUPON IS SUBJECT TO LEGAL ACTION. 2007 © VIRGO GAMBILL ARCHITECTS

APPROVED BY:	MEDICAL CENTER DIRECTOR
APPROVED BY:	FACILITY MANAGEMENT SERV LINE EXEC

PROJECT TITLE:	RENOVATE "E" WING BUILDING 801, DOWNTOWN DIVISION AUGUSTA, GEORGIA
DRAWING TITLE:	POWER/FIRE ALARM PLAN

DATE:	APRIL 29, 2011
VA PROJECT NO.	509-318E
DRAWING NO.	801-E2.0
DWG.	39 of 44

