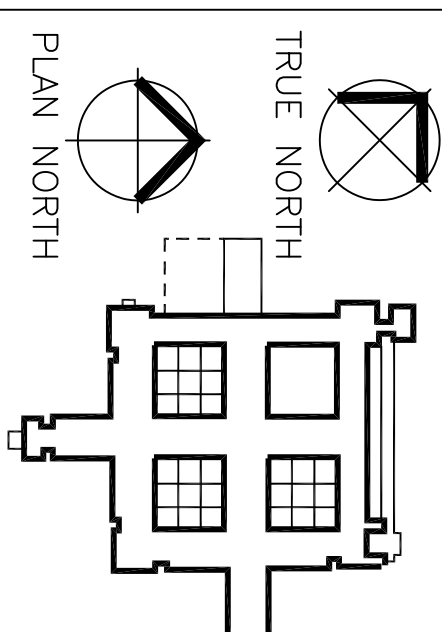


Rm. # Changes 11/15/00	MAA	
ADDED 32 INCH ROOM NUMBERS	MAA	09 /29/ 99
REVISIONS		DATE

GENERAL
NOTES:

[illegible]

I HEREBY CERTIFY THAT THIS PLY SPECIFICATION FOR REPORT WAS PREPARED BY ME OR UNDER MY SUPERVISION AND THAT I AM A DULY REGISTERED
THE LAWS OF THE STATE OF MINNESOTA
UNDEFEED
REGISTRATION NUMBER:

Drawing Scale
 $1/32" = 1'-0"$

Plot Scale
 $1/2" = 1'-0"$

Drawing Title

SECOND FLOOR
COMPOSITE PLAN

REPLACEMENT
MEDICAL CENTER

Project No.	
Building Number	70
DRAWING NO.	2FL-32
Dwg. 00 of 137	