


three inches = one foot
one and one half inches = one foot
one inch = one foot
three quarters inch = one foot
one half inch = one foot
three eighths inch = one foot
one quarter inch = one foot
one eighth inch = one foot

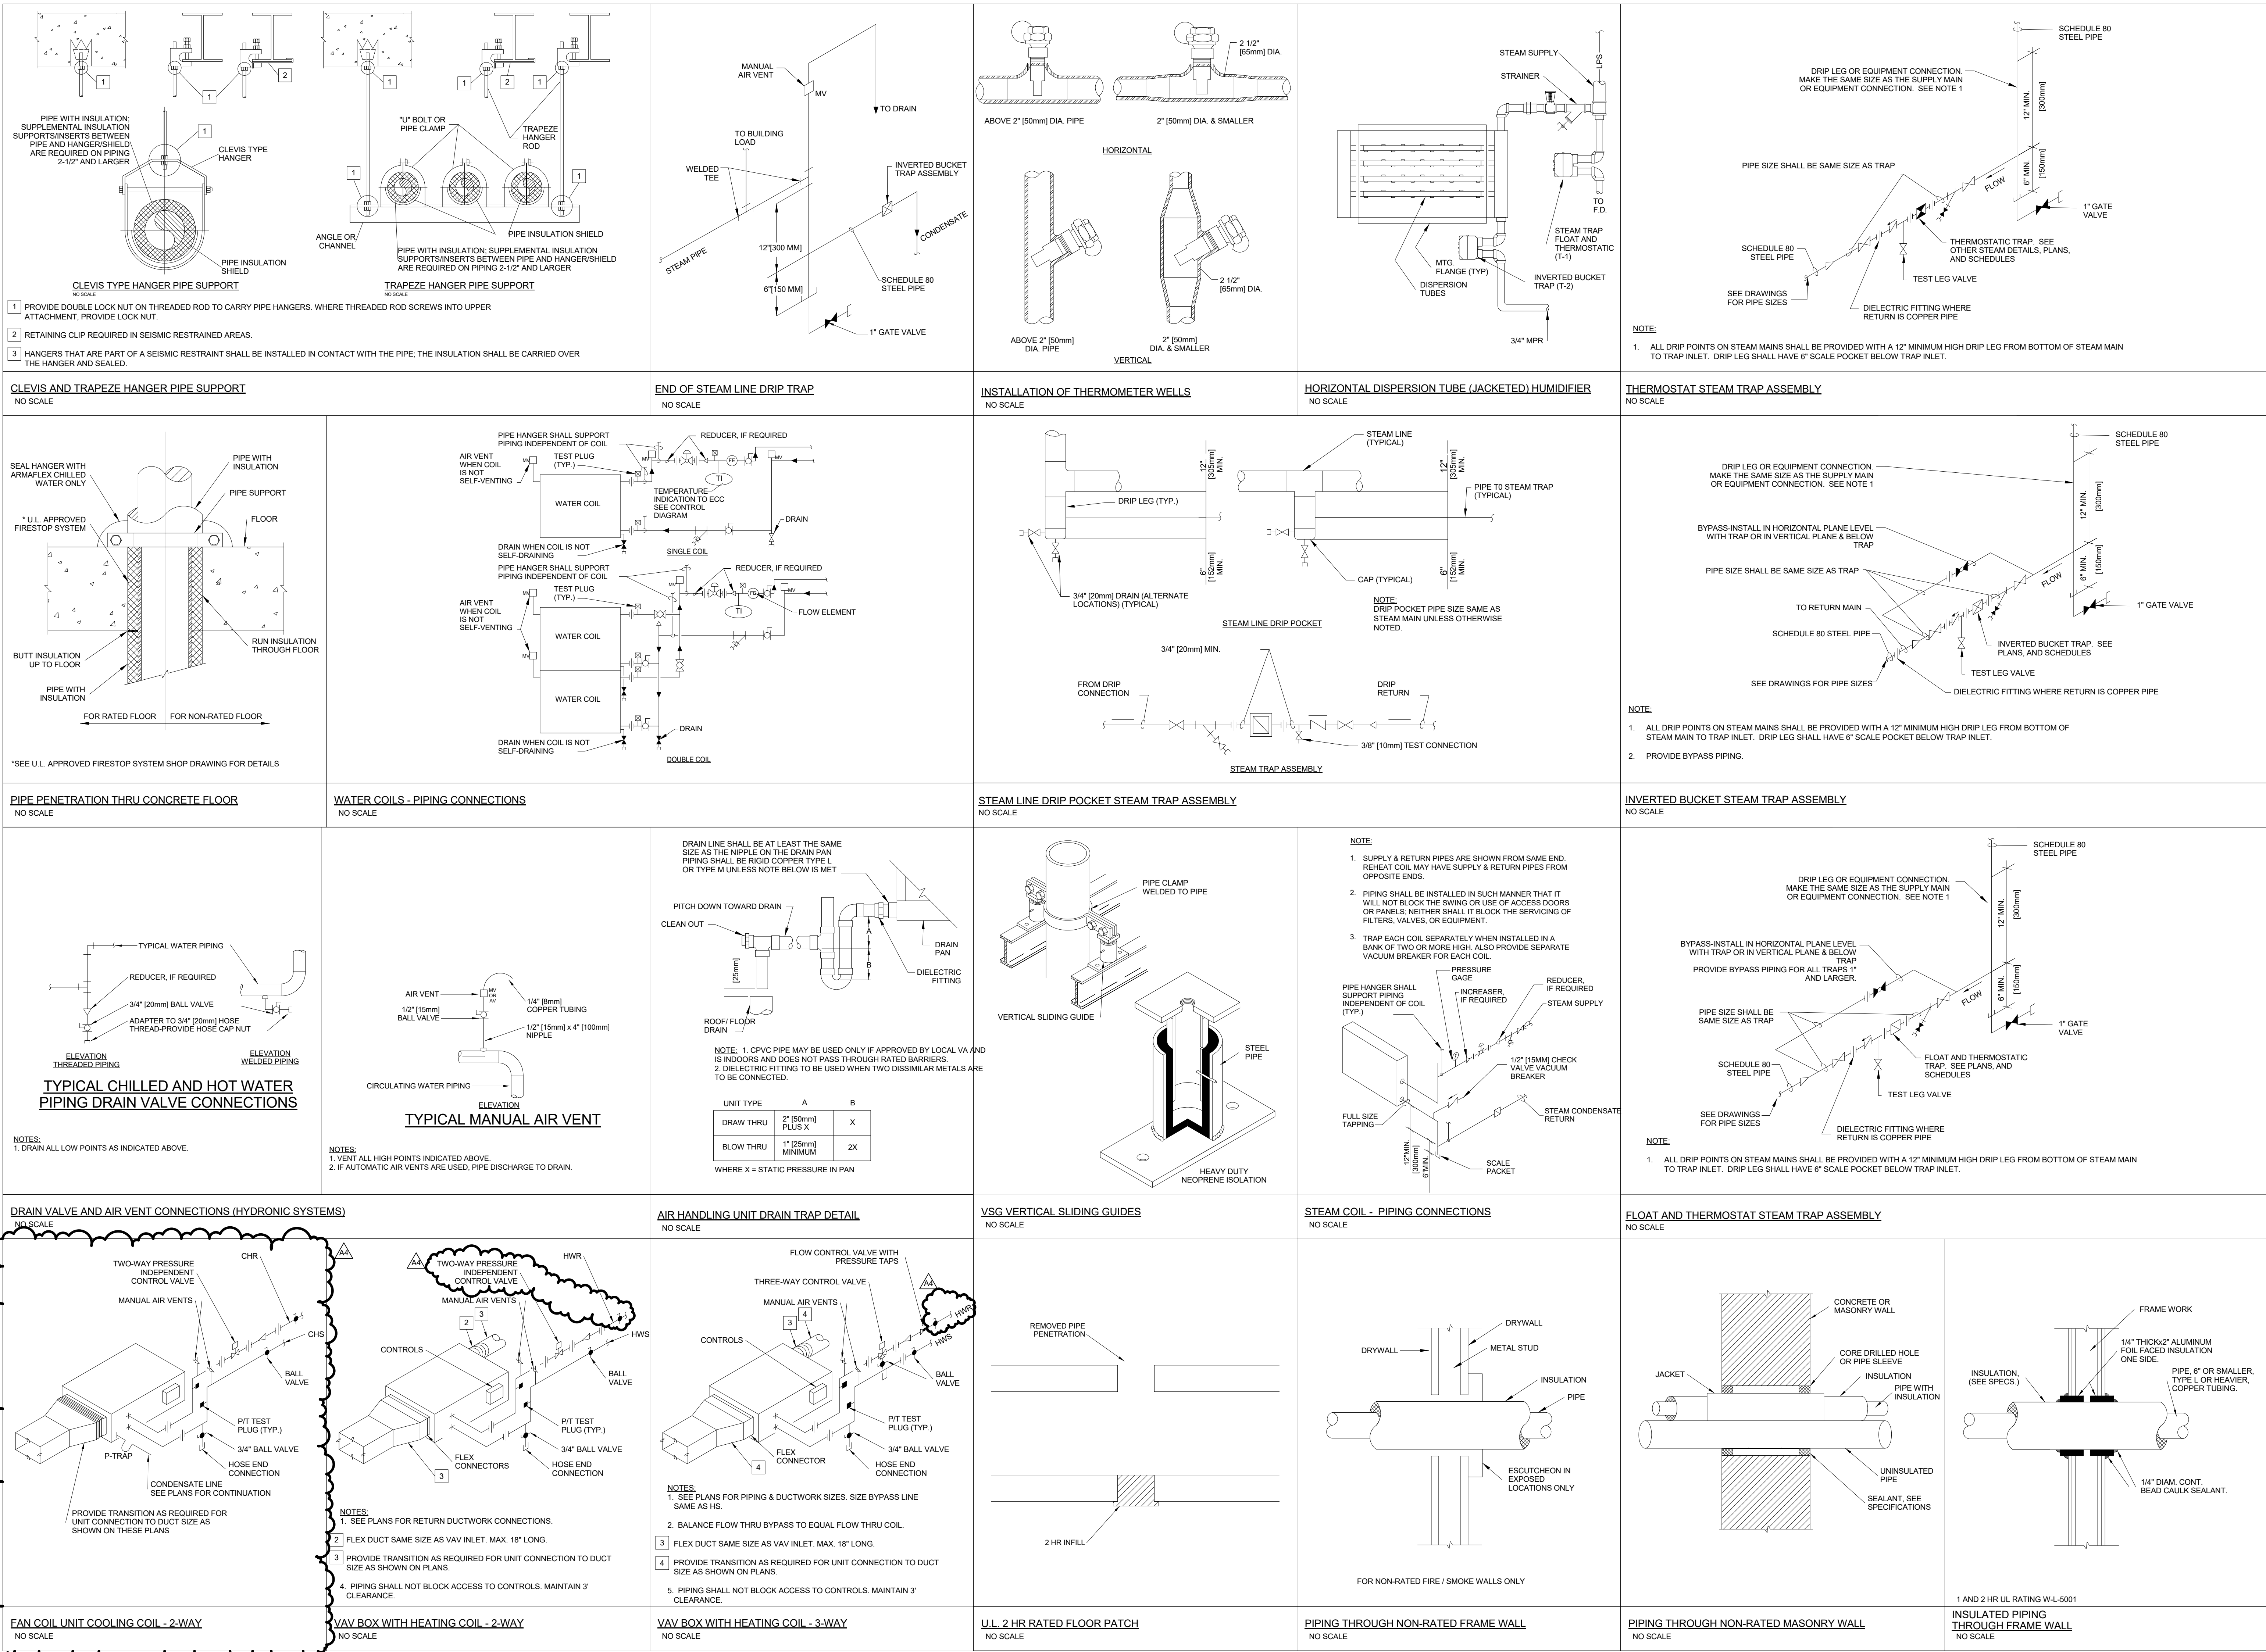

Revisions:	Date
AMENDMENT A00004	06/06/16

CONSULTANTS:

ARCHITECT/ENGINEERS:

FoxArchitects

One Memorial Drive
Suite 1800
Saint Louis, MO 63102

Tel 314.621.4343
Fax 314.621.0261



SSC

Swim, Schuchat, & Cornett
Engineering, Inc.

18201 Collins Industrial
Chesterfield, Missouri 63025
Phone 636.336.7775 Fax 636.336.7877
Missouri Certificate of Authority #NC 001244

Drawing Title
MECHANICAL DETAILS

Approved: Associate Director	Approved: Chief Engineer
Approved: Chief of Staff	Approved: Safety Officer
Approved: Infection Control	Approved: Chief, Police & Security

Project Title
Phase 3: Renovation of
Operating Rooms, ER & Triage

Location
V.A.M.C. ST. LOUIS, MO
JOHN COCHRAN DIVISION

Date
02/24/16

Checked
SSC

Drawn
Author

Project Number
657-13-300JC

Building Number
01

Drawing Number
1-3-M-502

Veterans
Health
Administration



BID DOCUMENTS