

A

1

2

3

4

5

6

7

8

 
NOTES:

(THIS SHEET ONLY)

- ① COPPER DRAIN LINE SUPPORTS OFF ROOF WITH PT SLEEPER PADS.  
RUN TO ROOF DRAIN. SEE SHEET M503 FOR SLEEPER DETAIL.


B

one inch = one foot




C

 three-quarters inch = one foot




D

 one-half inch = one foot




E

 three-eighths inch = one foot





F

 one-quarter inch = one foot





F

 one-eighth inch = one foot

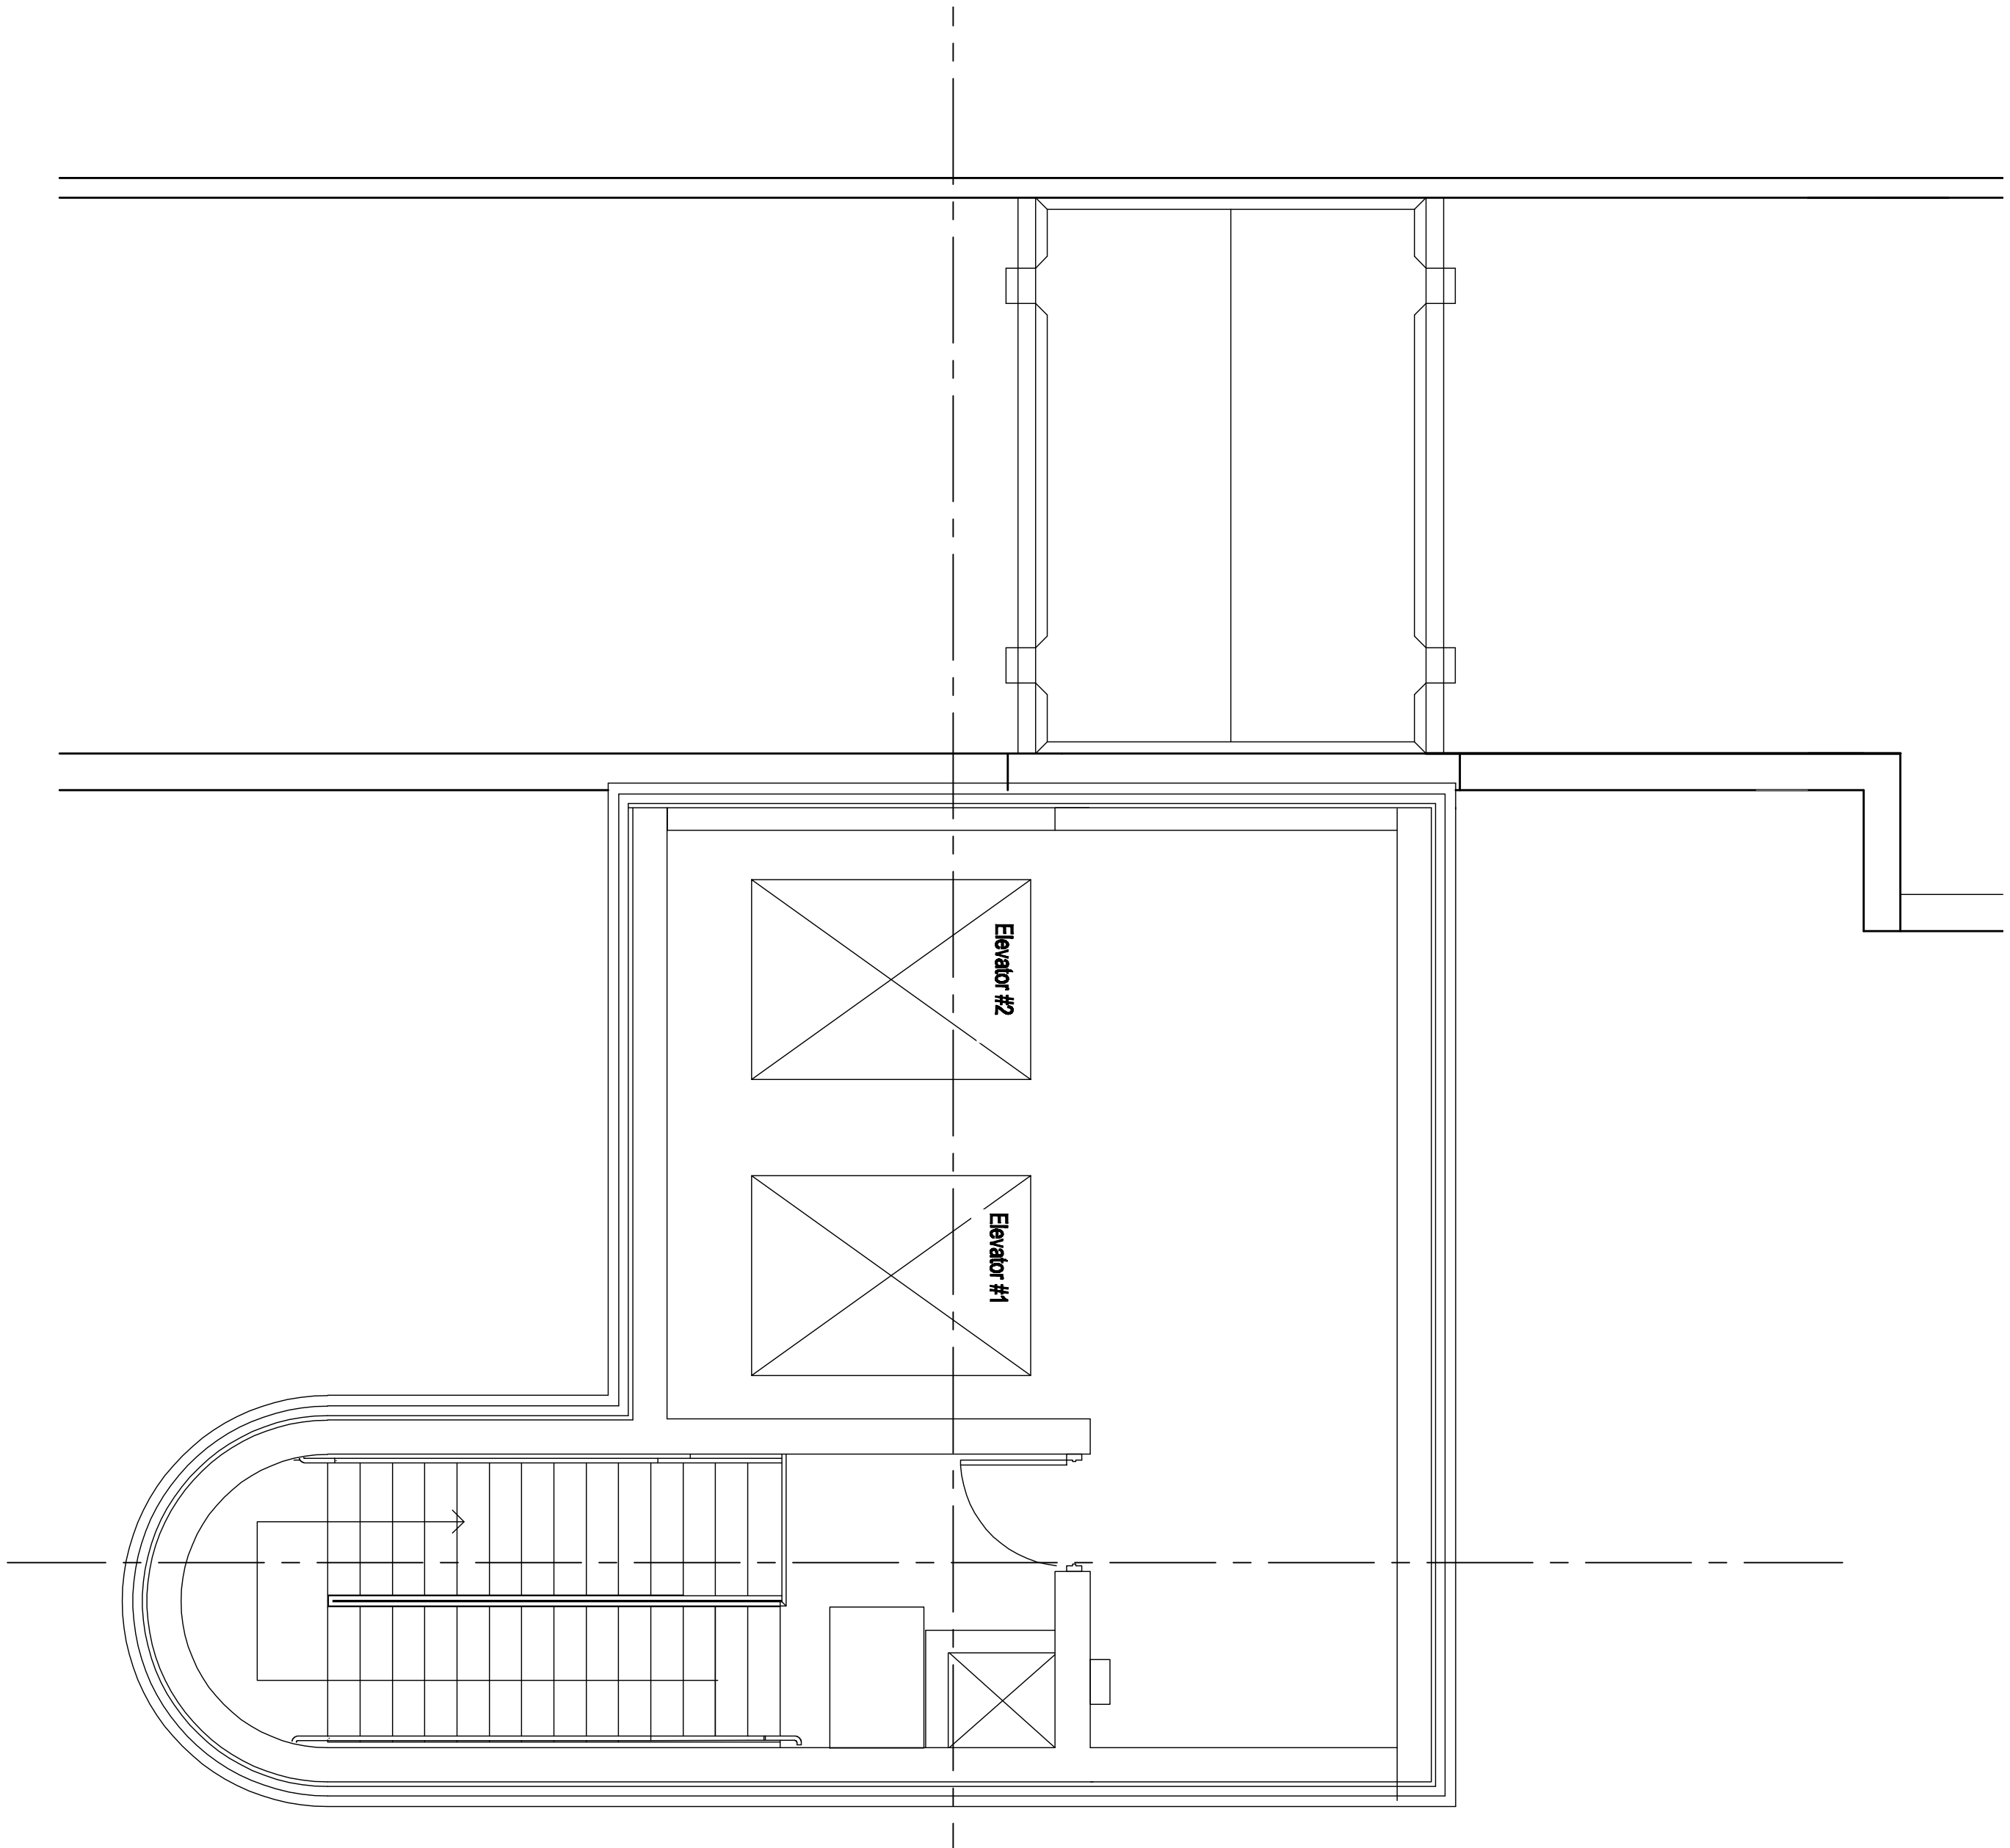


ENLARGED FLOOR PLAN  
10th FLOOR STAIRS – MECHANICAL

 SCALE: 1/4" = 1'-0"

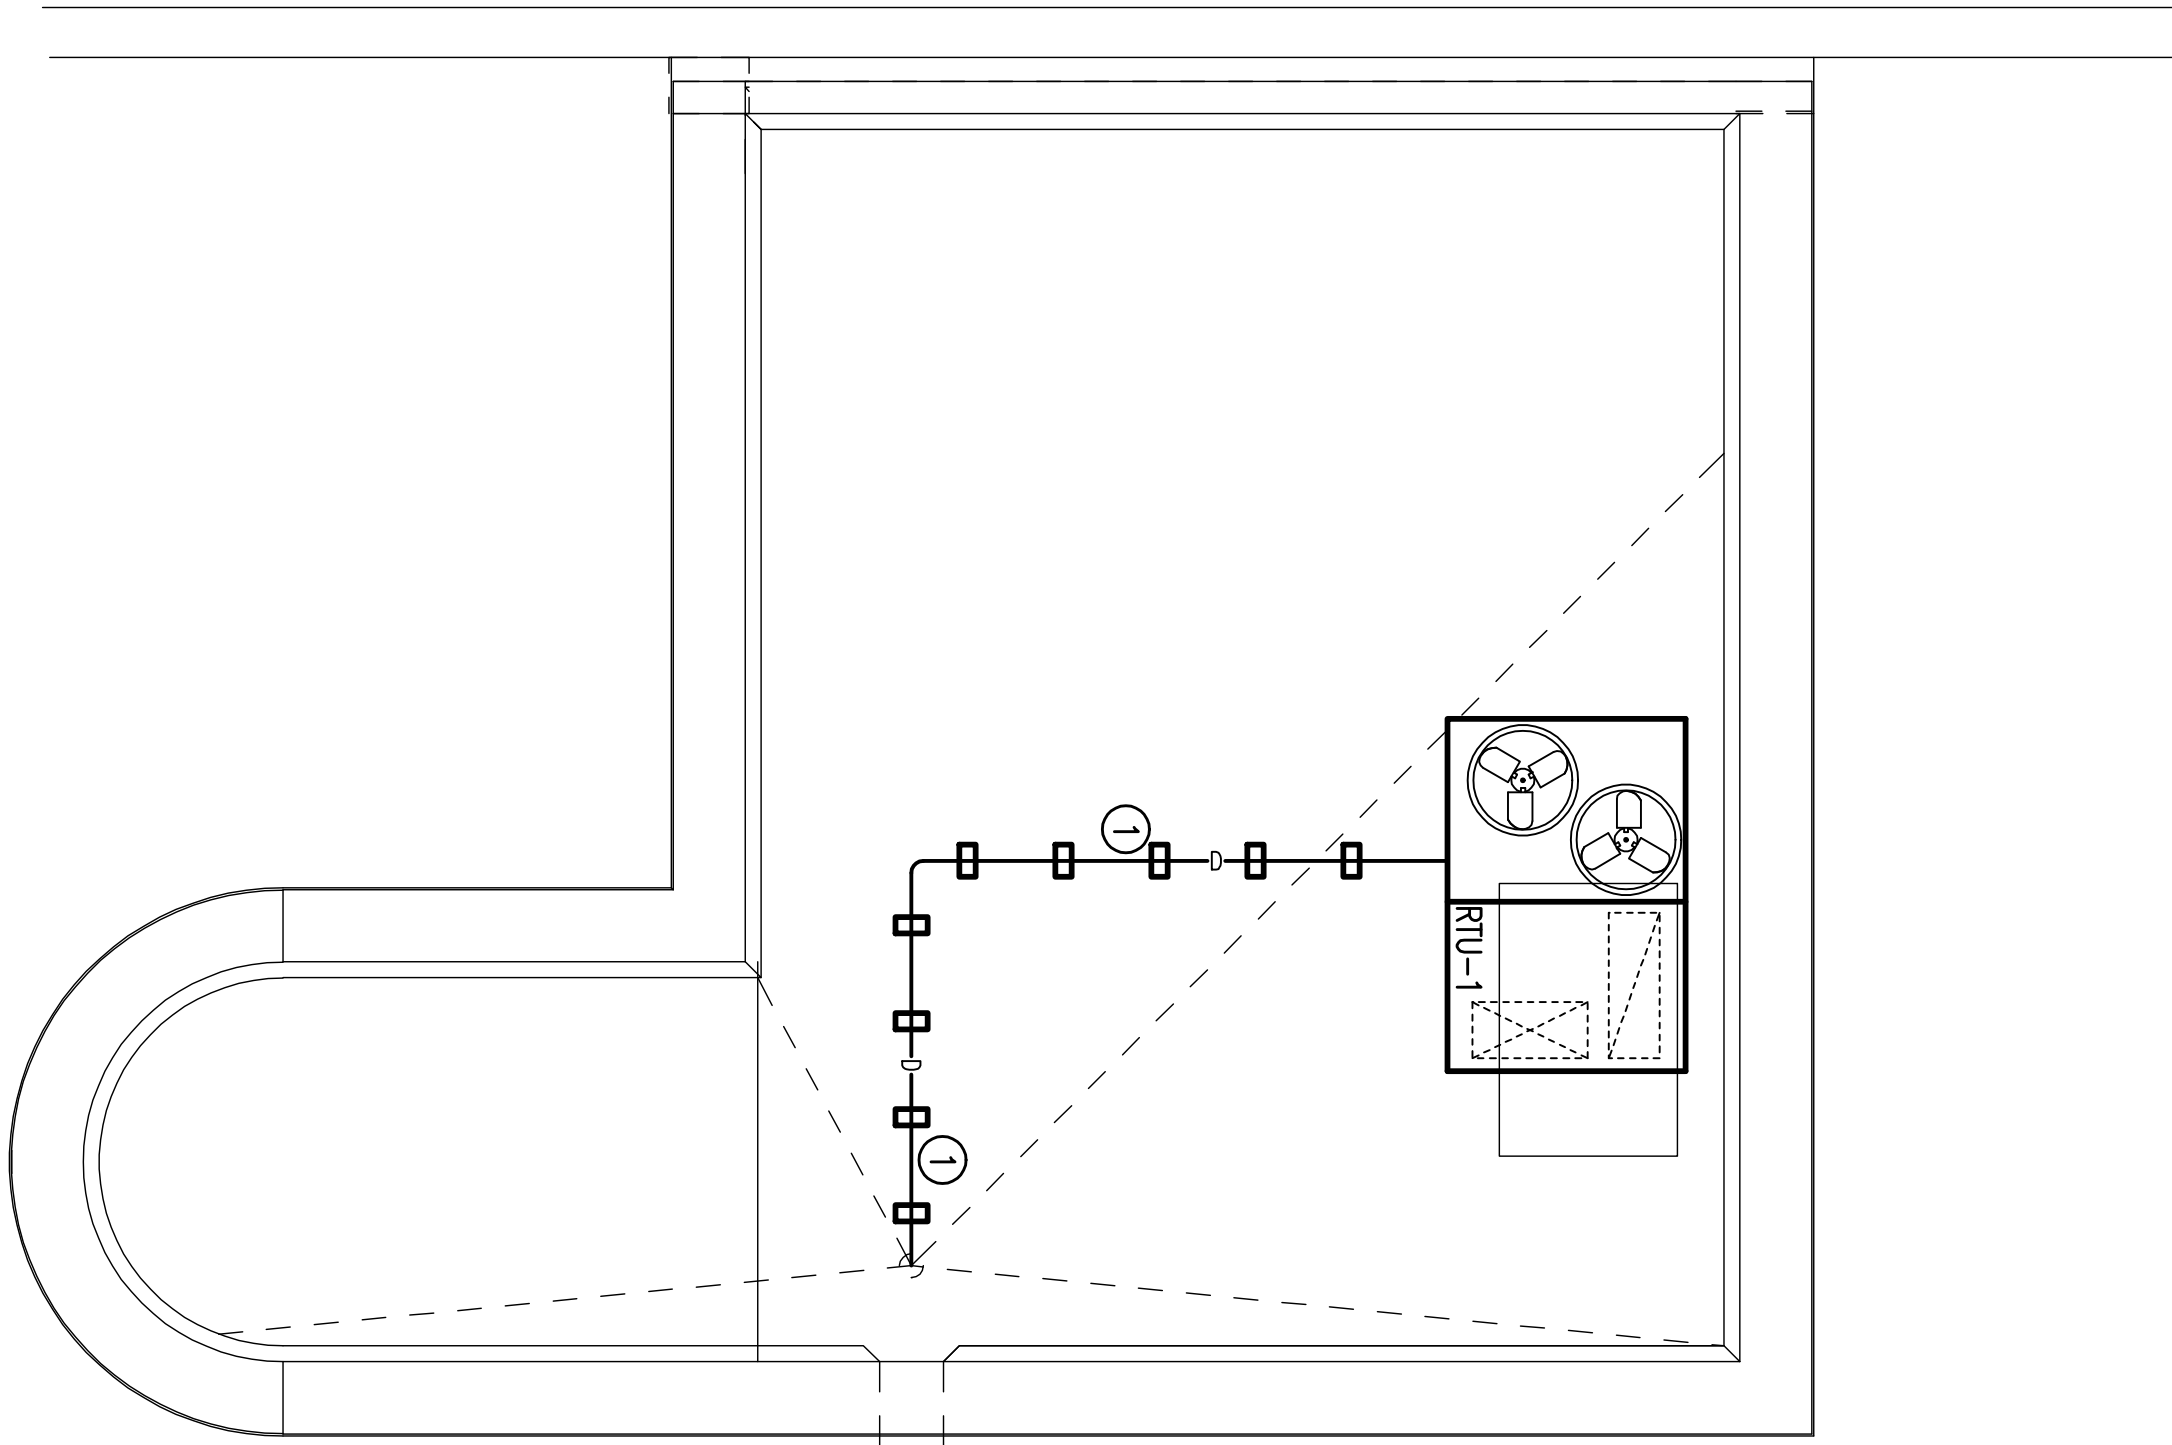


ENLARGED FLOOR PLAN  
ROOF FLOOR STAIRS – MECHANICAL

 SCALE: 1/4" = 1'-0"



Revisions	Date

**Toland ♦ Mizell ♦ Molnar, LLC**  
590 MEANS STREET NW,  
SUITE 200  
ATLANTA, GA, 30318  
404-214-9774

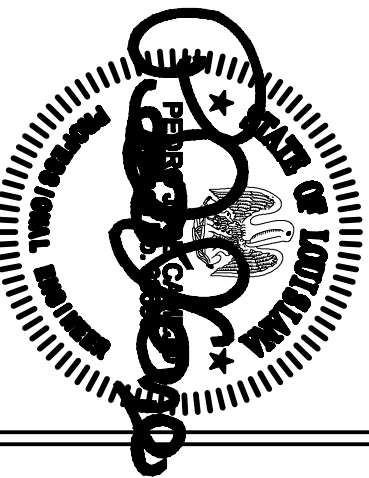

Drawing Title	ENLARGED STAIR PIPING NEW WORK FLOOR PLANS—MECHANICAL
Approved Project Engineer	

Project Title	2ND FLOOR OUTPATIENT MENTAL HEALTH
Building Number	BLDG 1 SOUTH WING
Location	VA MEDICAL CENTER SHREVEPORT, LOUISIANA
Checked	PJC
Drawn	JSW

Date	05-25-2011
Project No.	VA256-C-1047
DRAWING NO.	M108
Dwg. Of	

**Veterans  
Administration**

**100% REVIEW  
SUBMITTAL**

