


Revisions	Date

Toland ♦ Mizell ♦ Molnar, LLC
590 MEANS STREET NW,
SUITE 200
ATLANTA, GA, 30318
404-214-9774

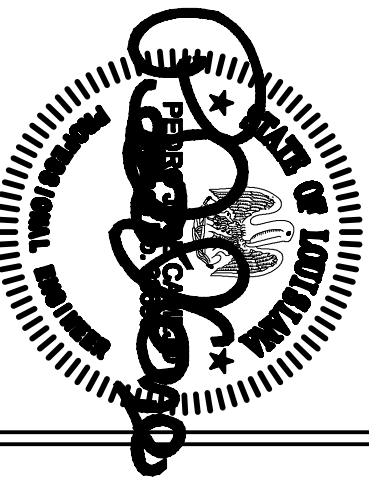

Drawing Title
**ENLARGED STAIR
DUCTWORK NEW WORK
FLOOR PLANS—MECHANICAL**

Approved Project Engineer

Project Title
**2ND FLOOR OUTPATIENT
MENTAL HEALTH**

Building Number
BLDG 1 SOUTH WING

Location
**VA MEDICAL CENTER
SHREVEPORT, LOUISIANA**

Date
05-25-2011

Project No.
VA256-C-1047



DRAWING NO.
M110

Dwg. Of

**Veterans
Administration**

**ENLARGED FLOOR PLAN
5TH FLOOR STAIRS – MECHANICAL**
SCALE: 1/4" = 1'-0"

**ENLARGED FLOOR PLAN
6TH FLOOR STAIRS – MECHANICAL**
SCALE: 1/4" = 1'-0"

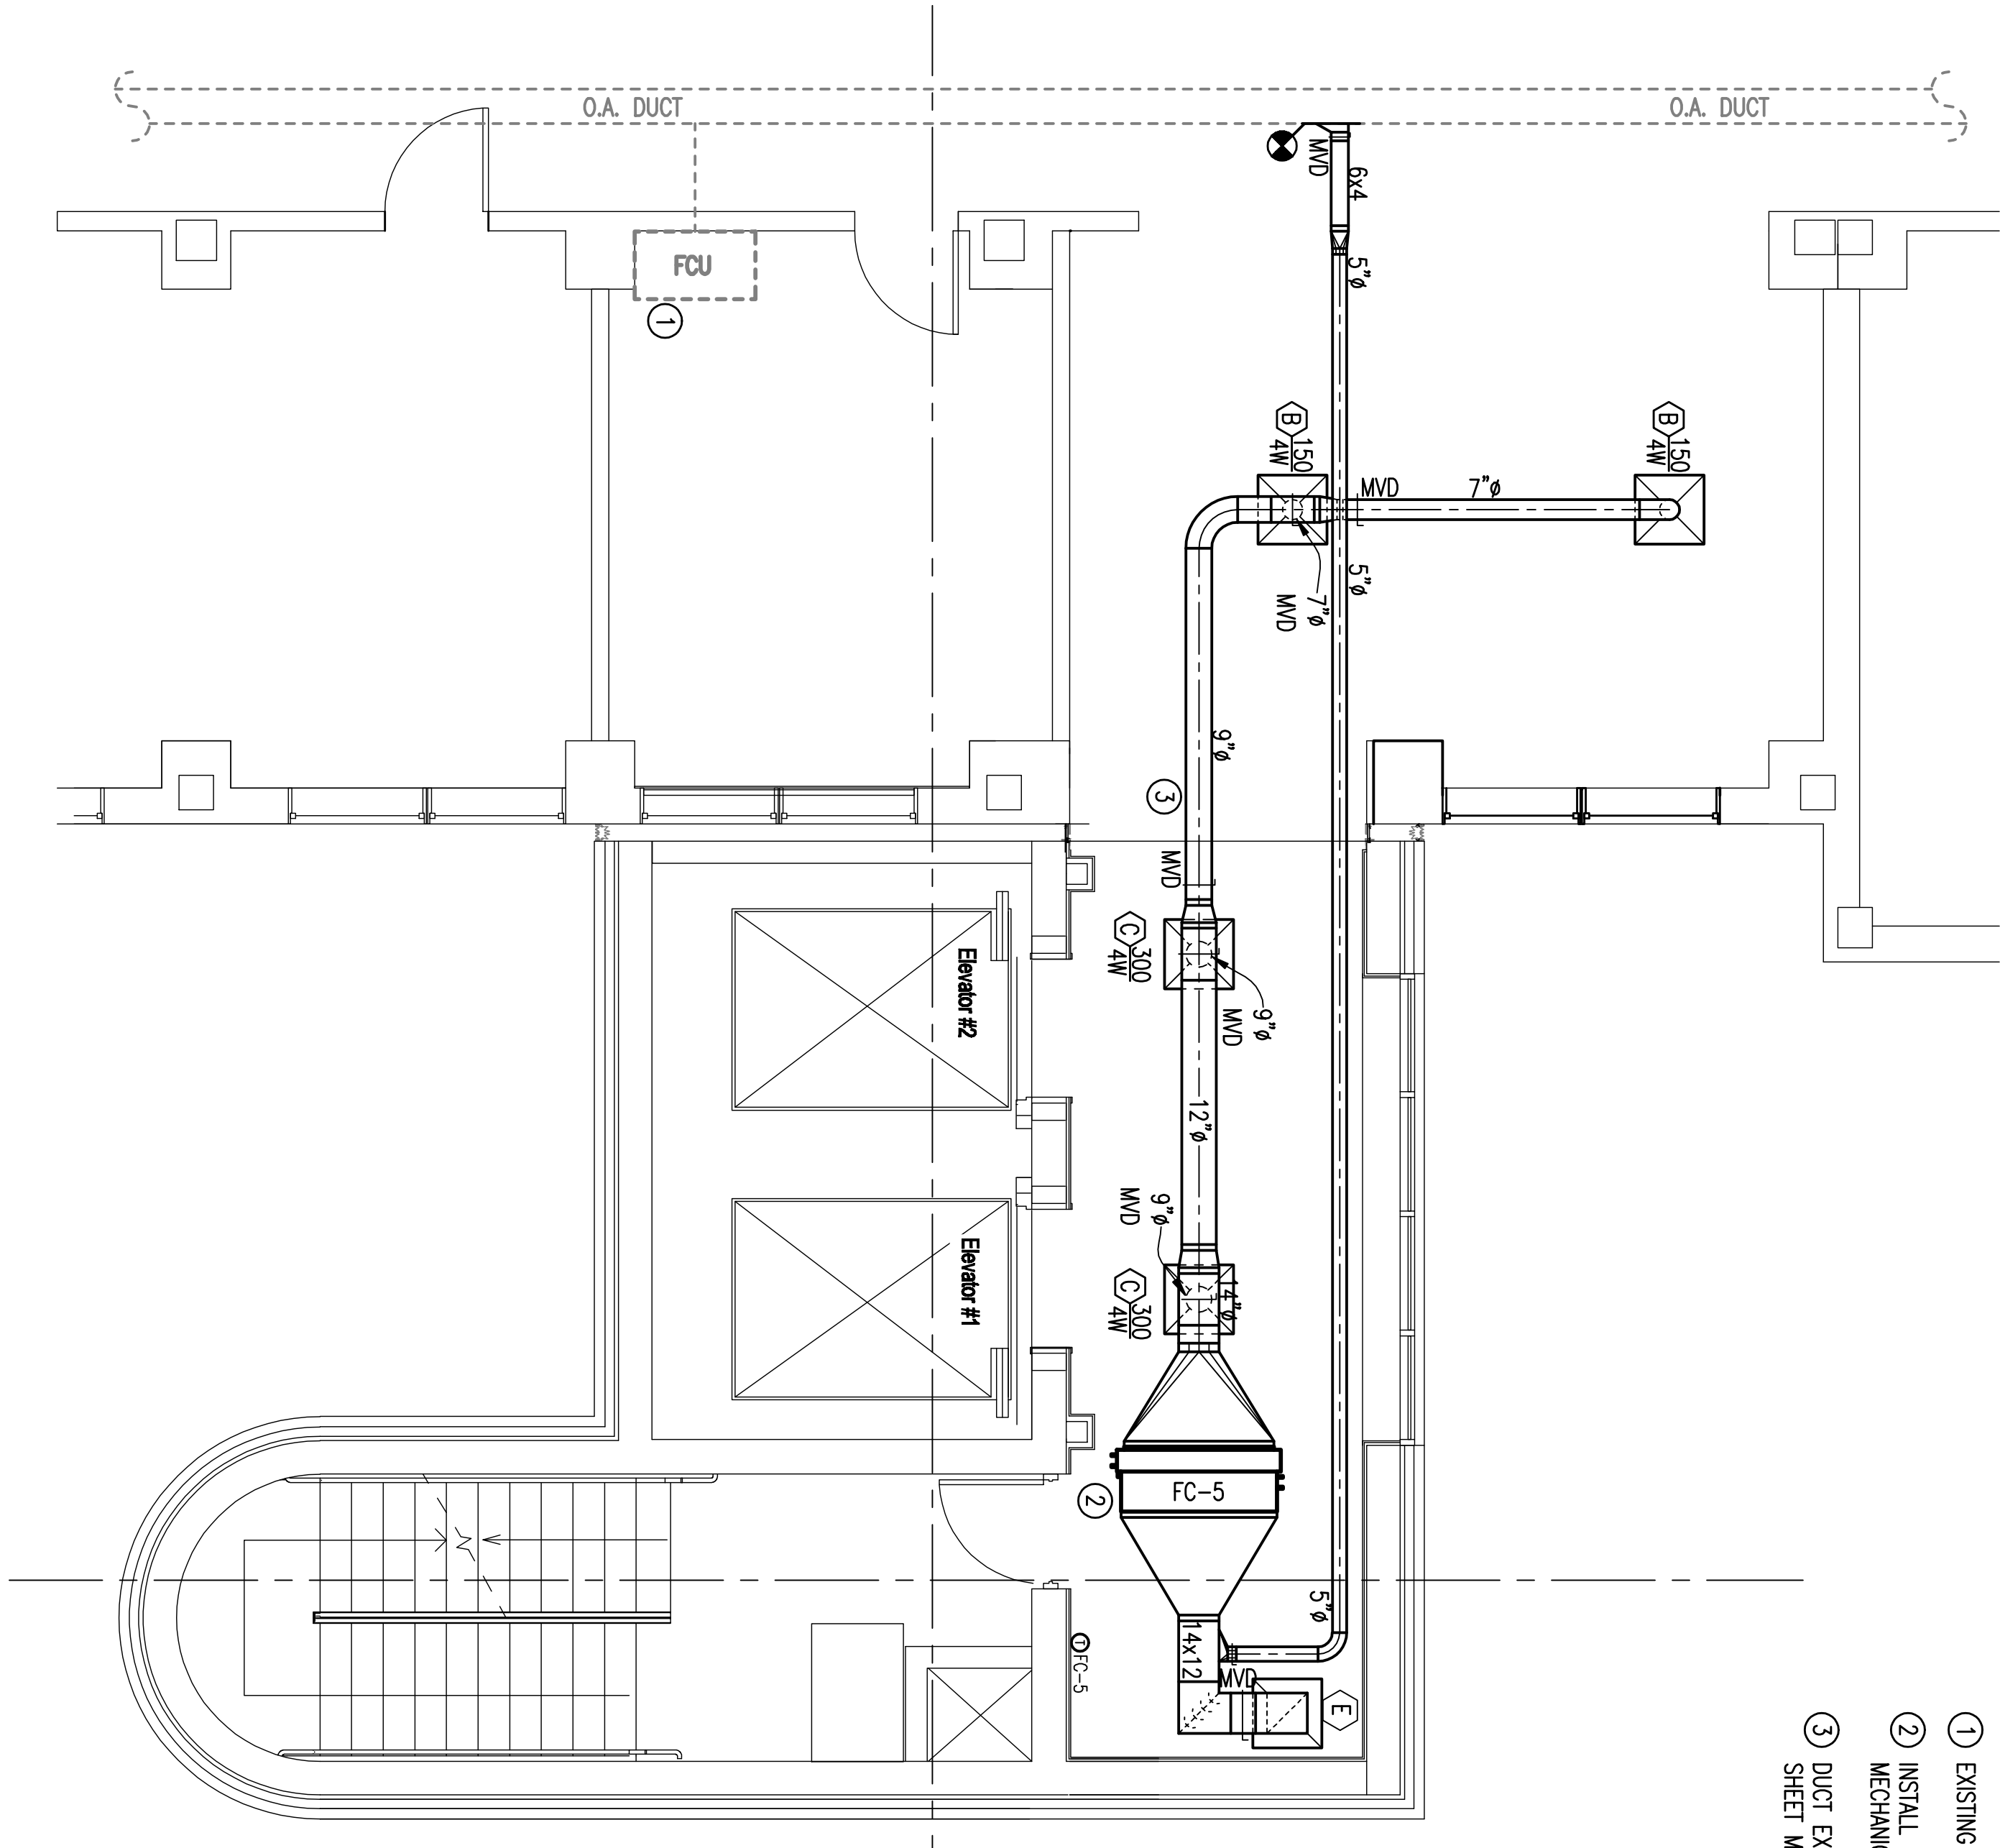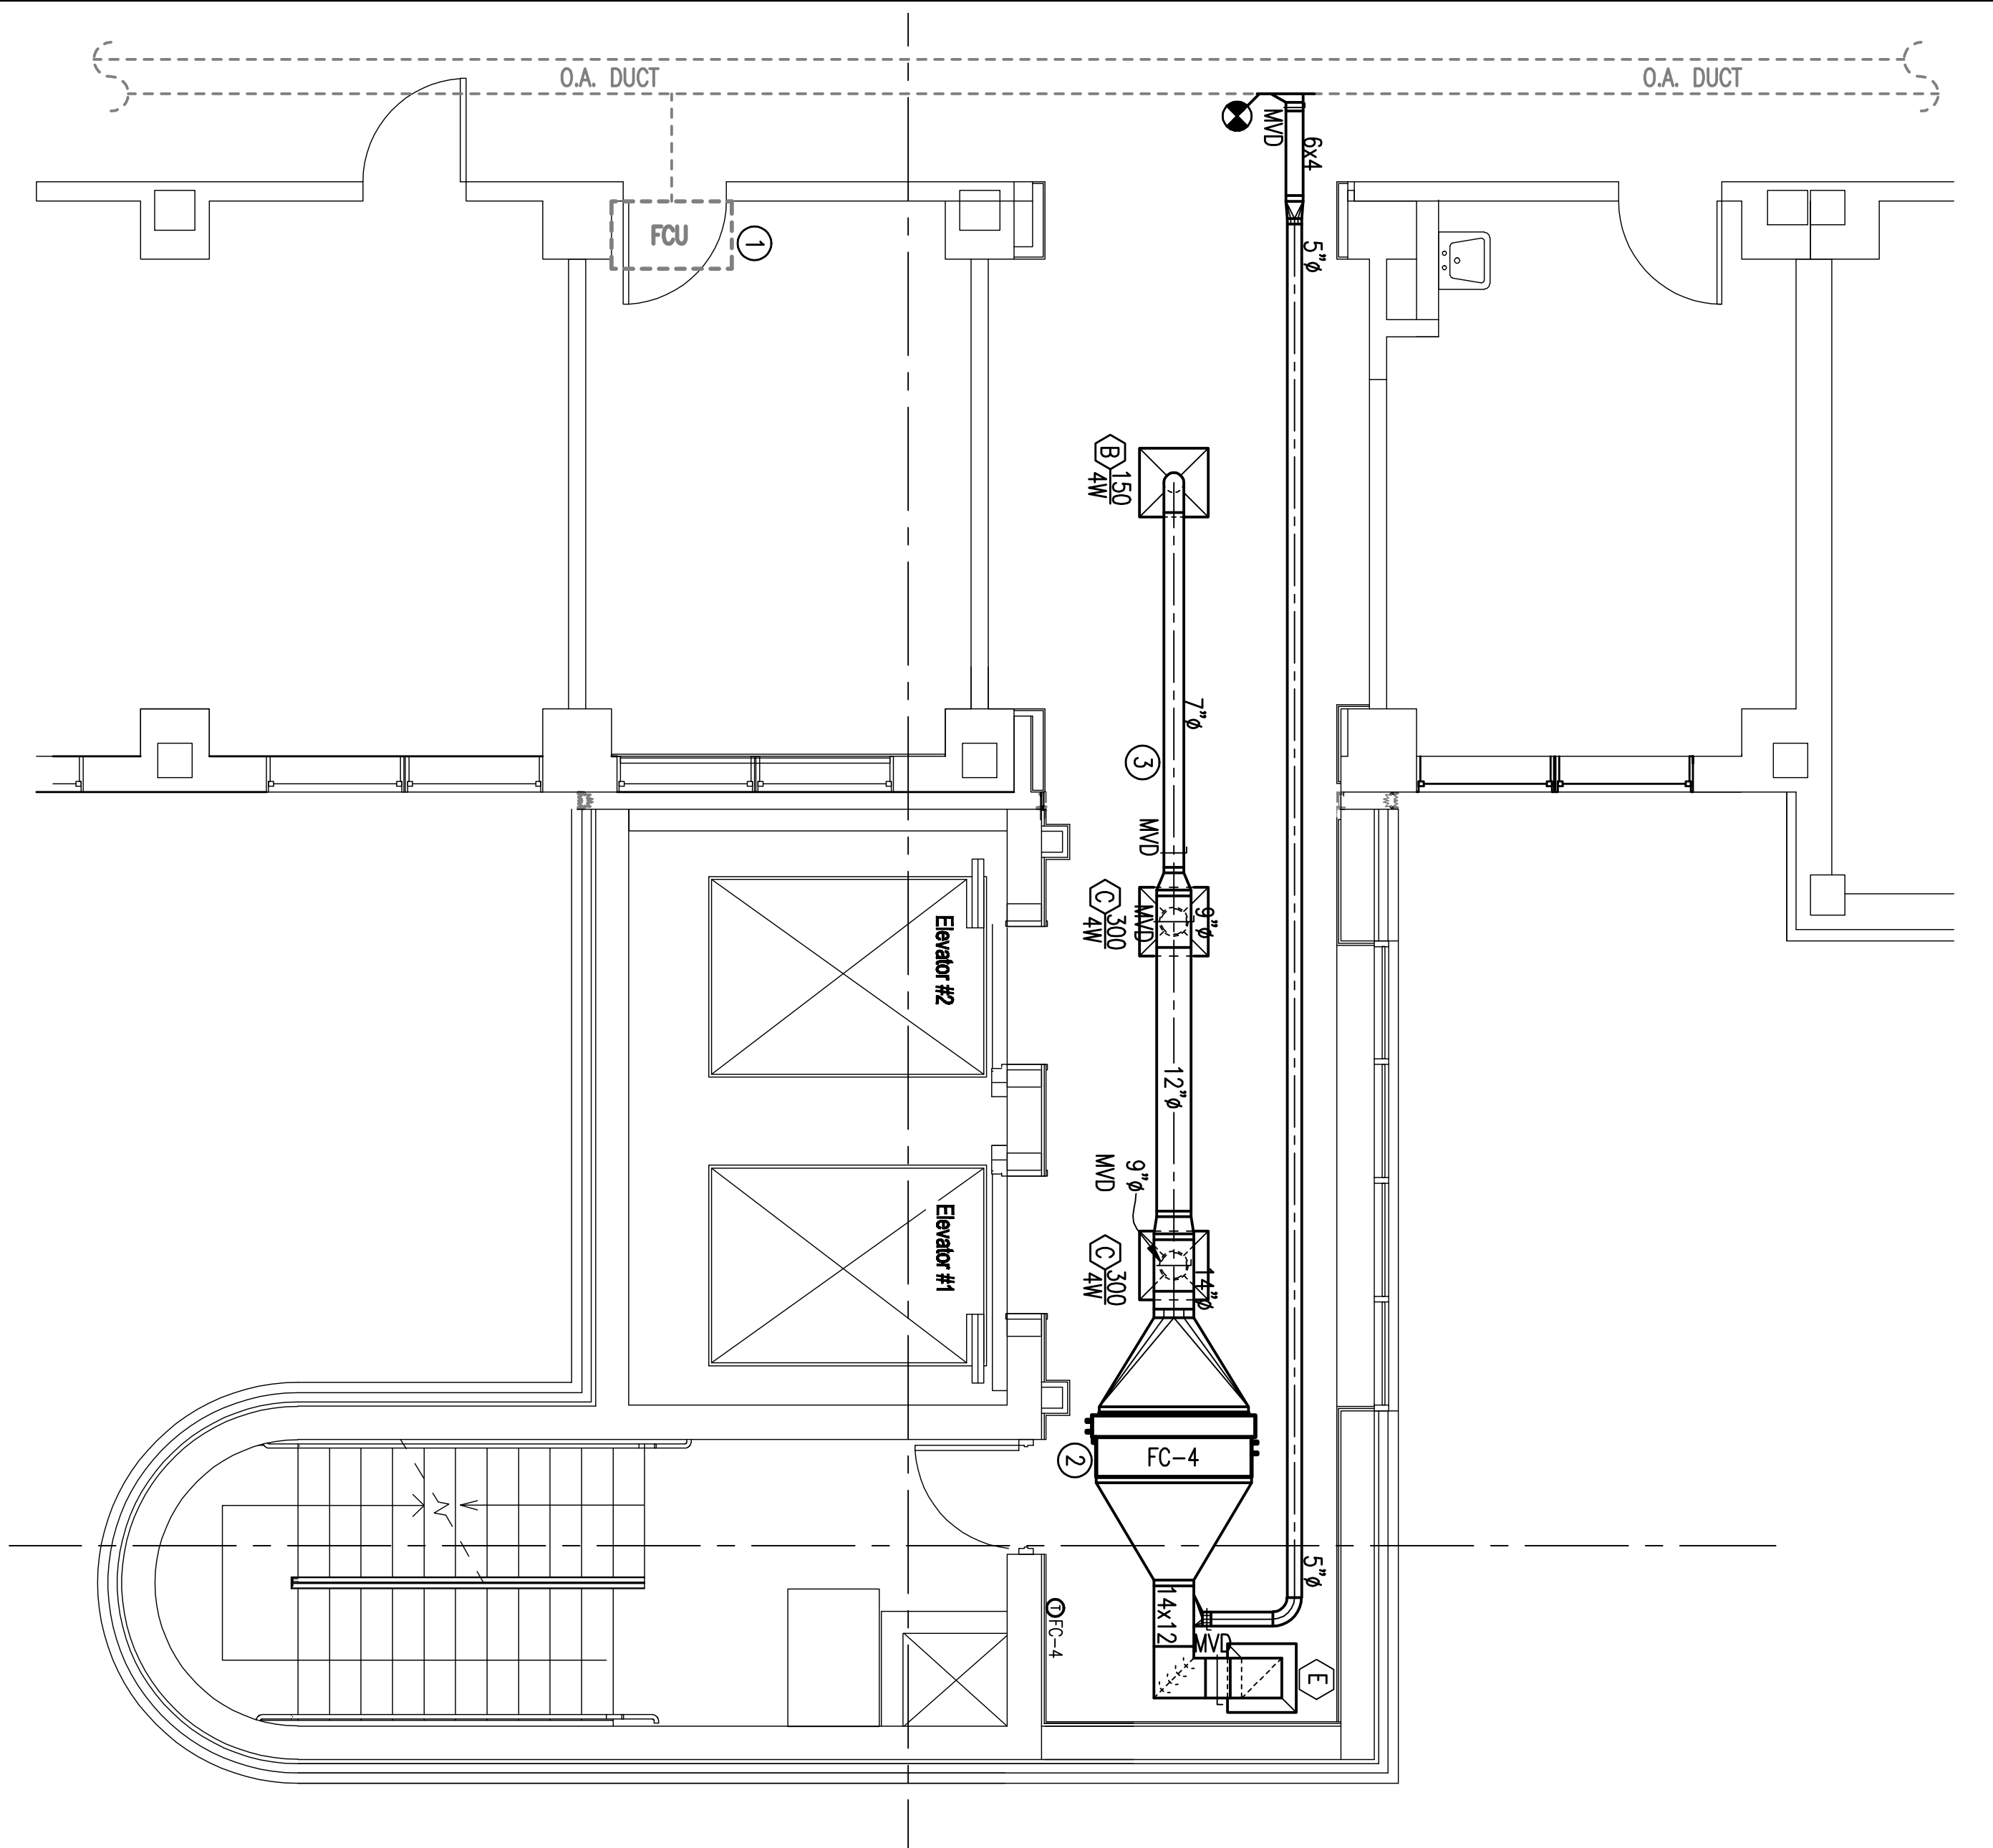

- NOTES:**
(THIS SHEET ONLY)
- ① EXISTING TO REMAIN FAN COIL UNIT.
 - ② INSTALL NEW FAN COIL UNITS PER MANUFACTURERS INSTRUCTIONS. SEE MECHANICAL DETAILS.
 - ③ DUCT EXPANSION JOINT. SEE DETAIL HORIZONTAL DUCT ISOLATION ON SHEET M503.

**100% REVIEW
SUBMITTAL**



NORTH

U.S. GOVERNMENT PRINTING OFFICE: 1984-440-467