




Revisions	
Date	

**Toland ♦ Mizell ♦ Molnar, LLC**  
590 MEANS STREET NW,  
SUITE 200  
ATLANTA, GA, 30318  
404-214-9774

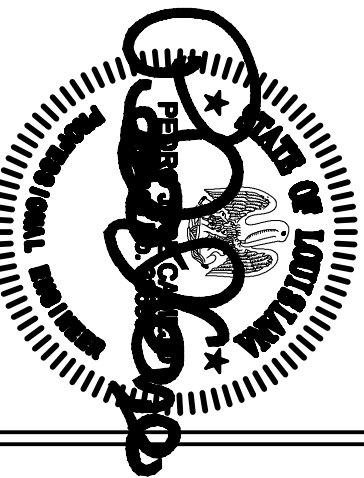

ENLARGED FLOOR PLAN  
8TH FLOOR STAIRS – MECHANICAL  
SCALE: 1/4" = 1'-0"

ENLARGED FLOOR PLAN  
9TH FLOOR STAIRS – MECHANICAL  
SCALE: 1/4" = 1'-0"

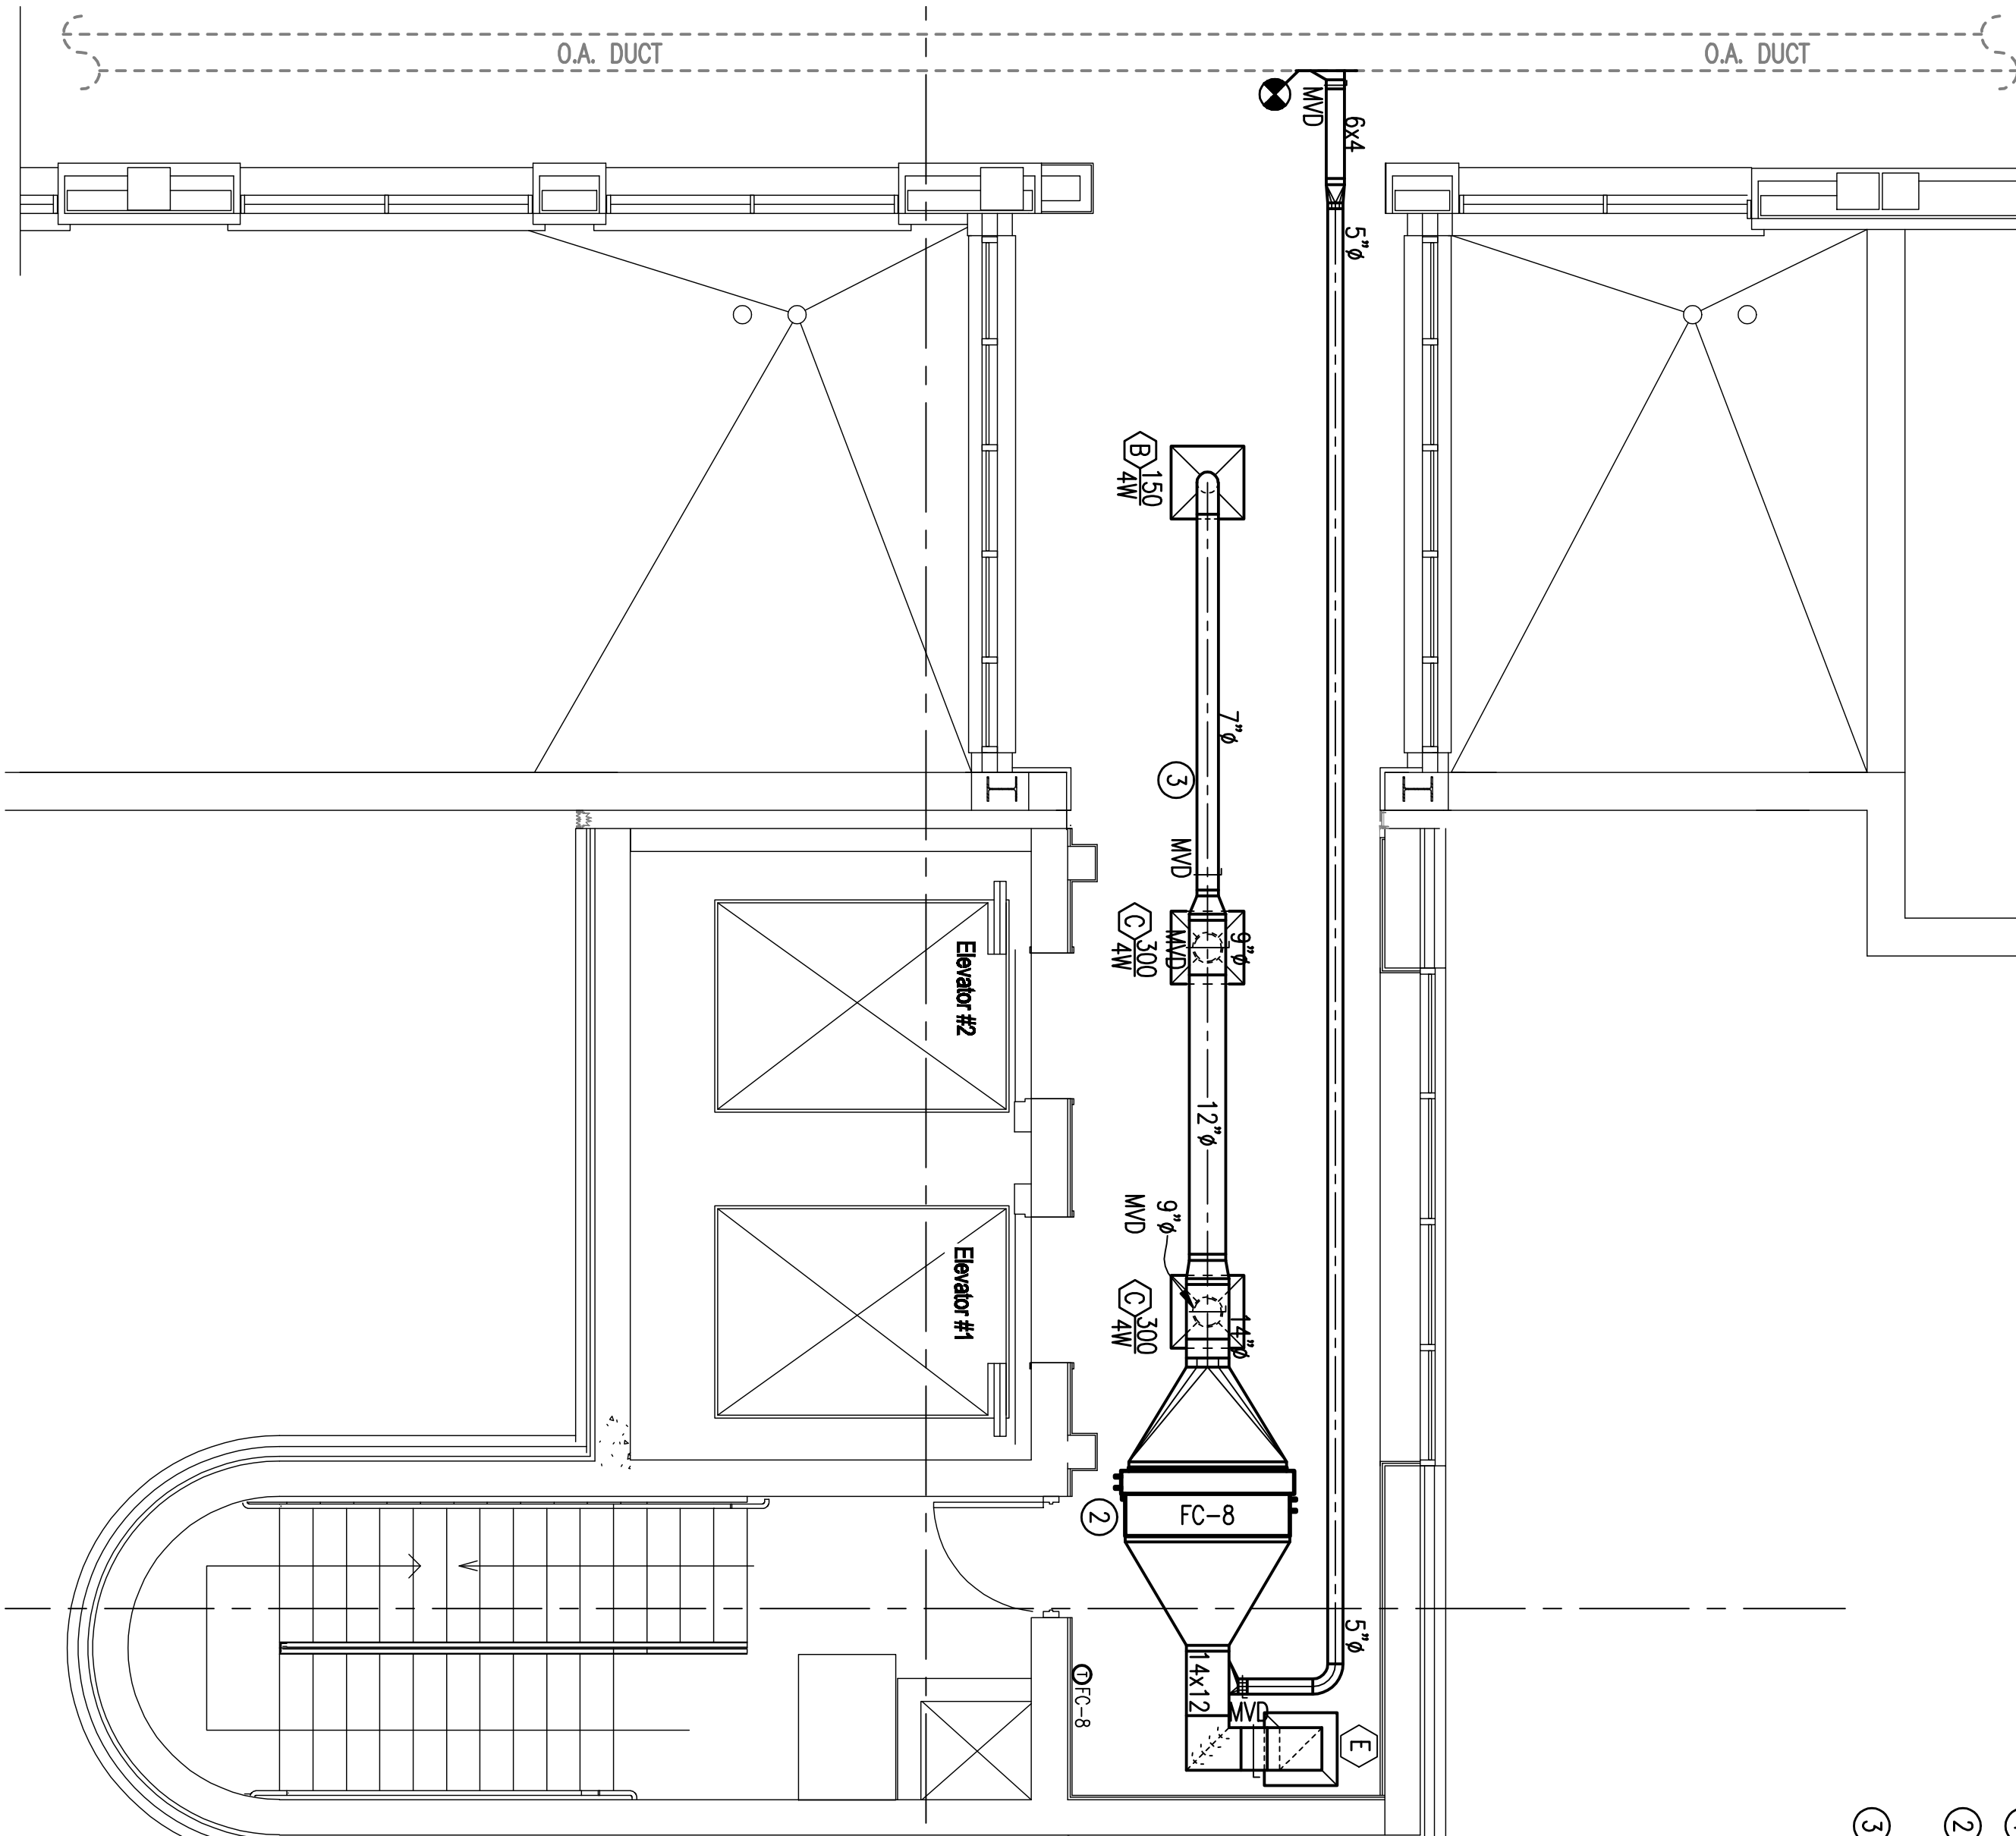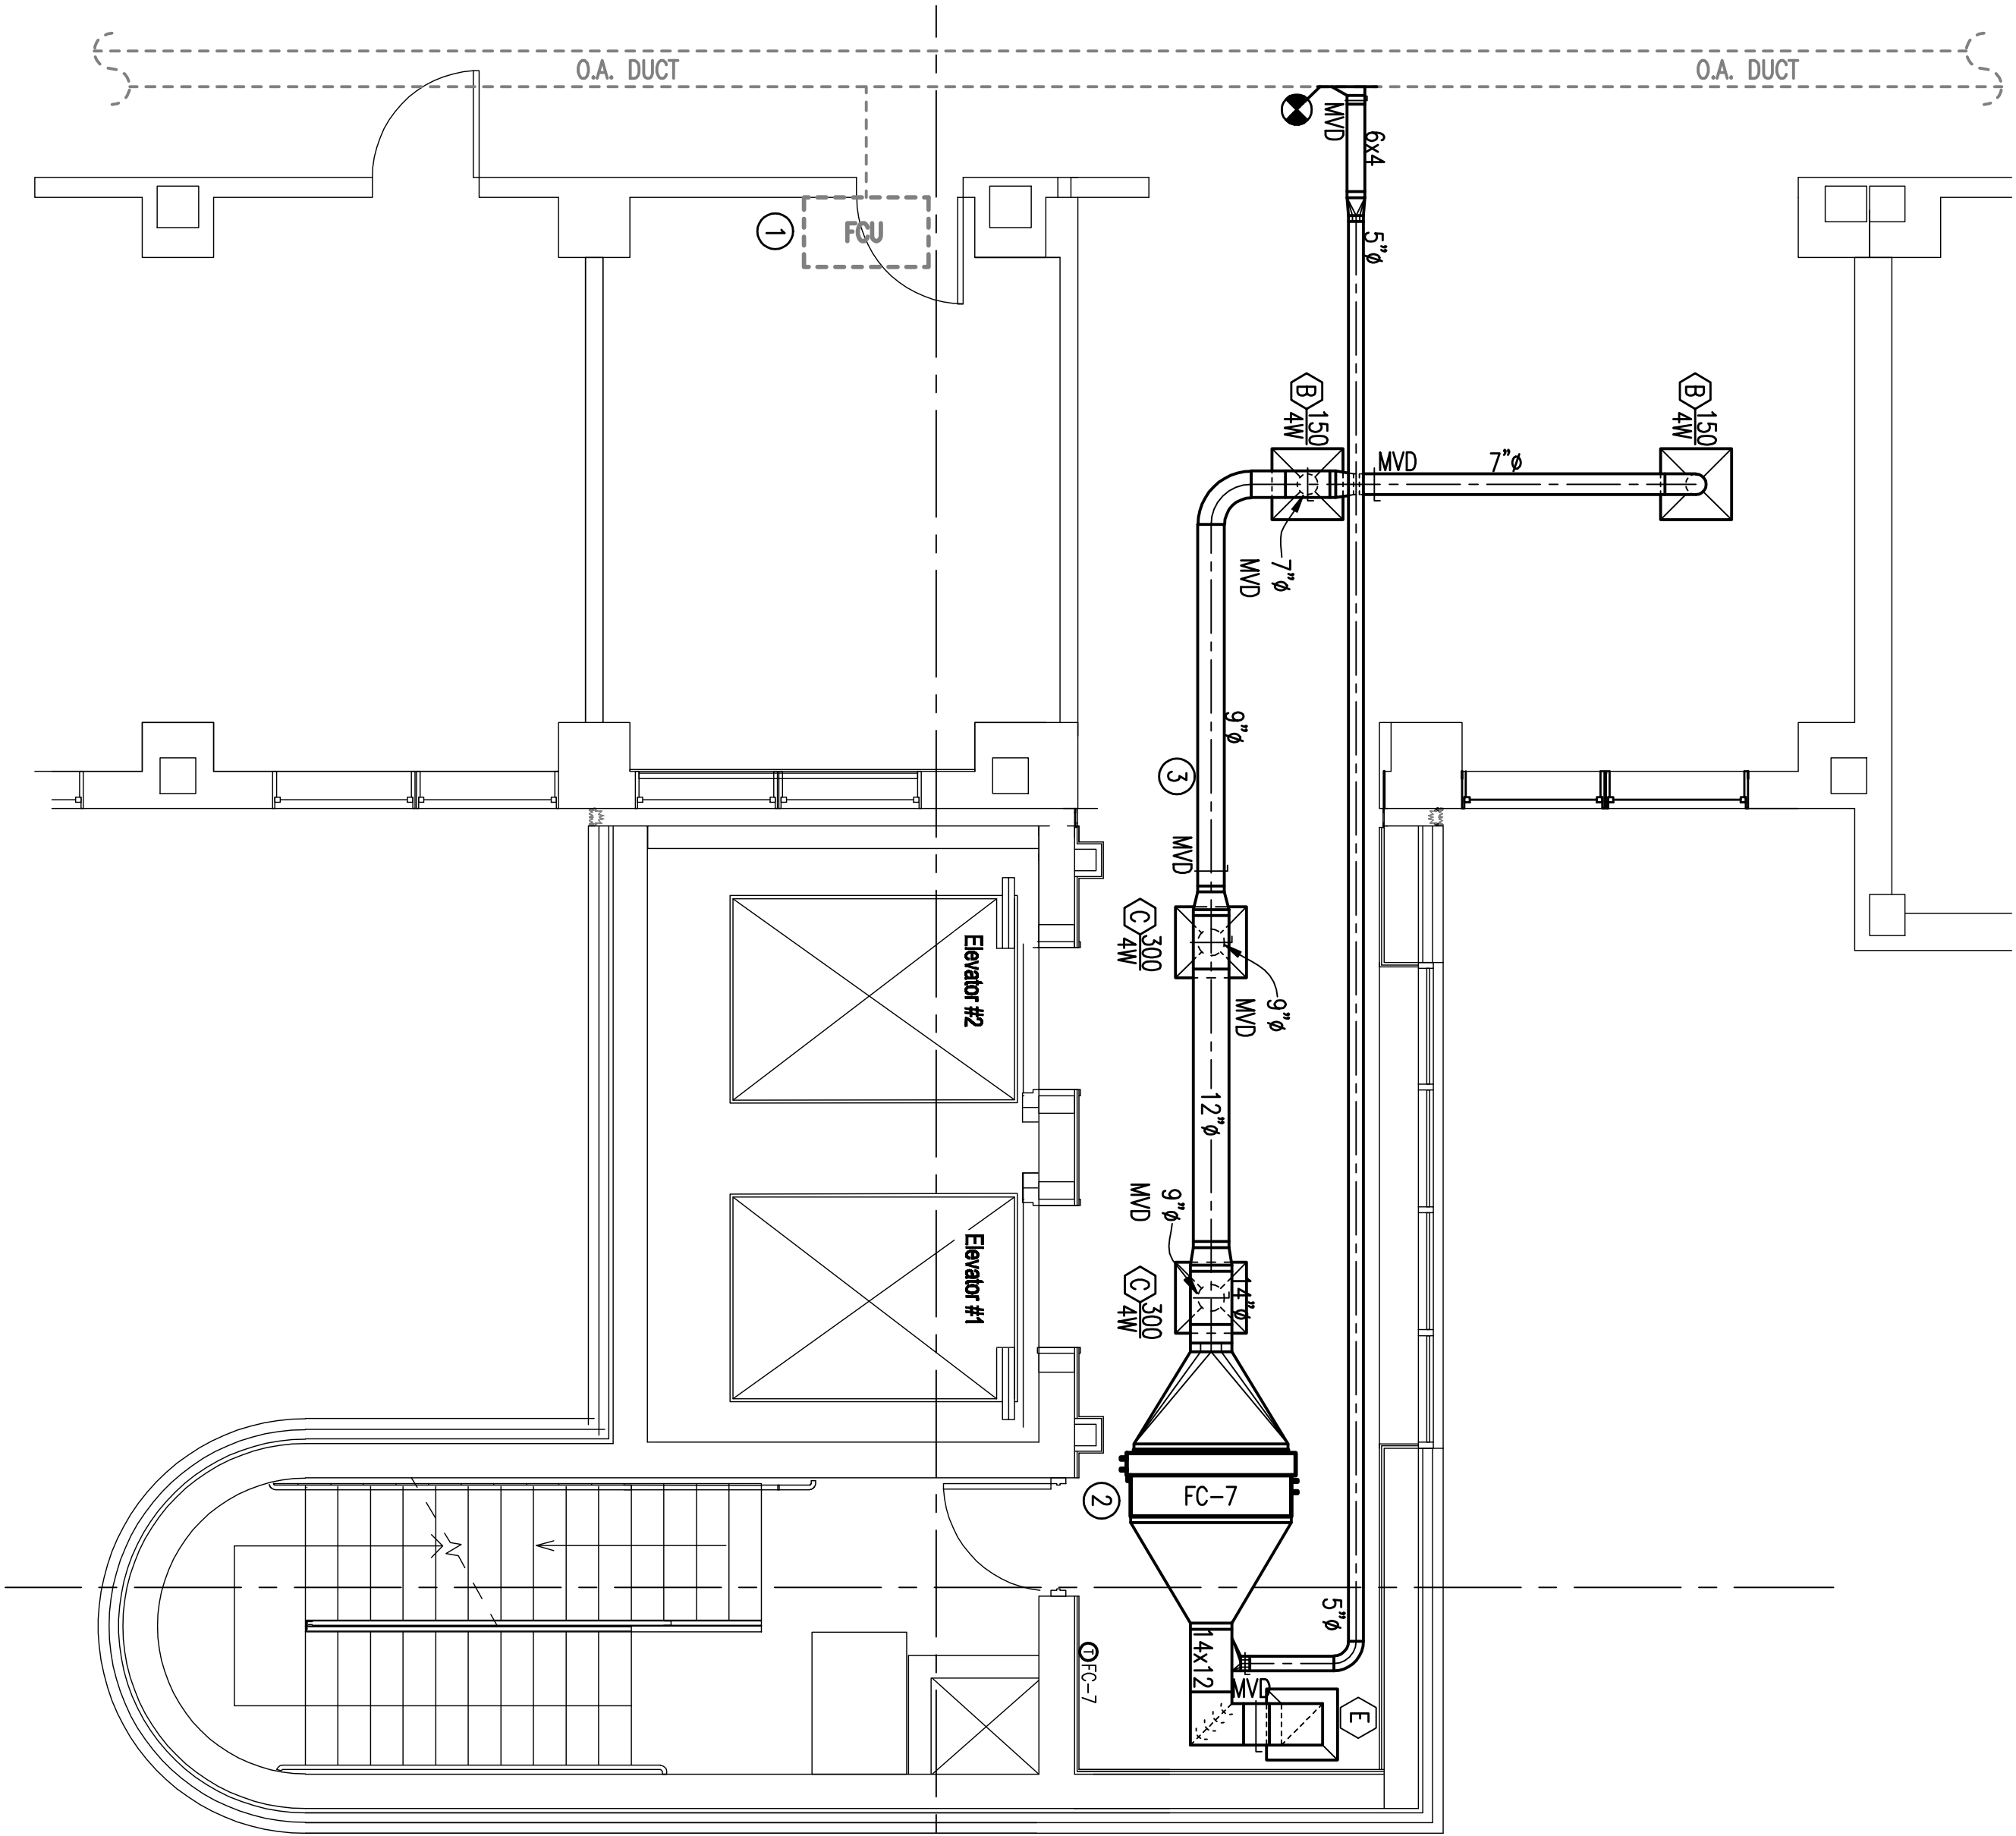

- NOTES:**  
(THIS SHEET ONLY)
- ① EXISTING TO REMAIN FAN COIL UNIT.
  - ② INSTALL NEW FAN COIL UNITS PER MANUFACTURERS INSTRUCTIONS. SEE MECHANICAL DETAILS.
  - ③ DUCT EXPANSION JOINT. SEE DETAIL HORIZONTAL DUCT ISOLATION ON SHEET M503.

Drawing Title  
**ENLARGED STAIR  
DUCTWORK NEW WORK  
FLOOR PLANS—MECHANICAL**

Project Title  
**2ND FLOOR OUTPATIENT  
MENTAL HEALTH**

Building Number  
**BLDG 1 SOUTH WING**

Location  
**VA MEDICAL CENTER  
SHREVEPORT, LOUISIANA**

Date  
**05-25-2011**

Project No.  
**VA256-C-1047**

DRAWING NO.  
**M 112**

Dwg. Of

**100% REVIEW  
SUBMITTAL**

**Veterans  
Administration**