

A

1

2

3

4

5

6

7

8

DEMOLITION WORK KEYED NOTES:

(THIS DRAWING ONLY)

- EXISTING SANITARY SEWER RISER TO REMAIN.
- EXISTING SANITARY VENT RISER TO REMAIN.
- EXISTING DOMESTIC HOT WATER SUPPLY/RETURN RISER TO REMAIN.
- EXISTING CONDENSATE RISER TO REMAIN.
- EXISTING PLUMBING PIPING TO REMAIN.
- EXISTING PLUMBING FIXTURE, PIPING, AND ALL ACCESSORIES TO REMAIN
- REMOVE AND DISCARD EXISTING FLOOR MOUNTED WATER CLOSET, FLUSH VALVE, FLOOR FLANGE, AND ALL ASSOCIATED PIPING.
- REMOVE AND DISCARD EXISTING WALL HUNG LAVATORY, FAUCET, P-TRAP, SUPPLEES, STOPS, WALL CARRIER, AND ALL ASSOCIATED PIPING.
- REMOVE EXISTING PLUMBING PIPING AS INDICATED. REFER TO PLUMBING DRAWING PB01 FOR PIPING DESIGNATIONS.
- CUT AND REMOVE EXISTING SANITARY SEWER PIPING ABOVE CEILING AT APPROXIMATE LOCATION INDICATED. PREPARE AND PROTECT PIPING FOR CONNECTION OF NEW WORK.
- CUT AND REMOVE EXISTING SANITARY VENT PIPING ABOVE CEILING AT APPROXIMATE LOCATION INDICATED. PREPARE AND PROTECT PIPING FOR CONNECTION OF NEW WORK.
- CUT AND REMOVE EXISTING DOMESTIC COLD WATER SUPPLY PIPING ABOVE CEILING AT APPROXIMATE LOCATION INDICATED. PREPARE AND PROTECT PIPING FOR CONNECTION OF NEW WORK.
- CUT AND REMOVE EXISTING DOMESTIC HOT WATER SUPPLY/RETURN PIPING ABOVE CEILING AT APPROXIMATE LOCATION INDICATED. PREPARE AND PROTECT PIPING FOR CONNECTION OF NEW WORK.
- CUT AND REMOVE EXISTING MEDICAL AIR PIPING ABOVE CEILING AT APPROXIMATE LOCATION INDICATED. PROVIDE 3-PIECE LOCKABLE BALL VALVE ABOVE CEILING LOCKED CLOSED.
- CUT AND REMOVE EXISTING OXYGEN PIPING ABOVE CEILING AT APPROXIMATE LOCATION INDICATED. PROVIDE 3-PIECE LOCKABLE BALL VALVE ABOVE CEILING LOCKED CLOSED.
- CUT AND REMOVE EXISTING MEDICAL VACUUM PIPING ABOVE CEILING AT APPROXIMATE LOCATION INDICATED. PROVIDE 3-PIECE LOCKABLE BALL VALVE ABOVE CEILING LOCKED CLOSED.
- CUT AND REMOVE EXISTING CONDENSATE DRAIN PIPING ABOVE CEILING AT APPROXIMATE LOCATION INDICATED. PREPARE AND PROTECT PIPING FOR CONNECTION OF NEW WORK.
- REMOVE EXISTING HEADWALL MOUNTED MEDICAL GAS OUTLET AND INLET STATIONS AND ALL ASSOCIATED PIPING. TURN HEADWALL, MEDICAL GAS OUTLET AND INLET STATIONS OVER TO GOVERNMENT.
- HVAC EQUIPMENT. REFER TO MECHANICAL DRAWINGS FOR LOCATION OF EQUIPMENT.

A

 
B

one inch = one foot




C

three-quarters inch = one foot




D

 one-half inch = one foot




E

 three-eighths inch = one foot





F

 one-quarter inch = one foot




F

 one-eighth inch = one foot

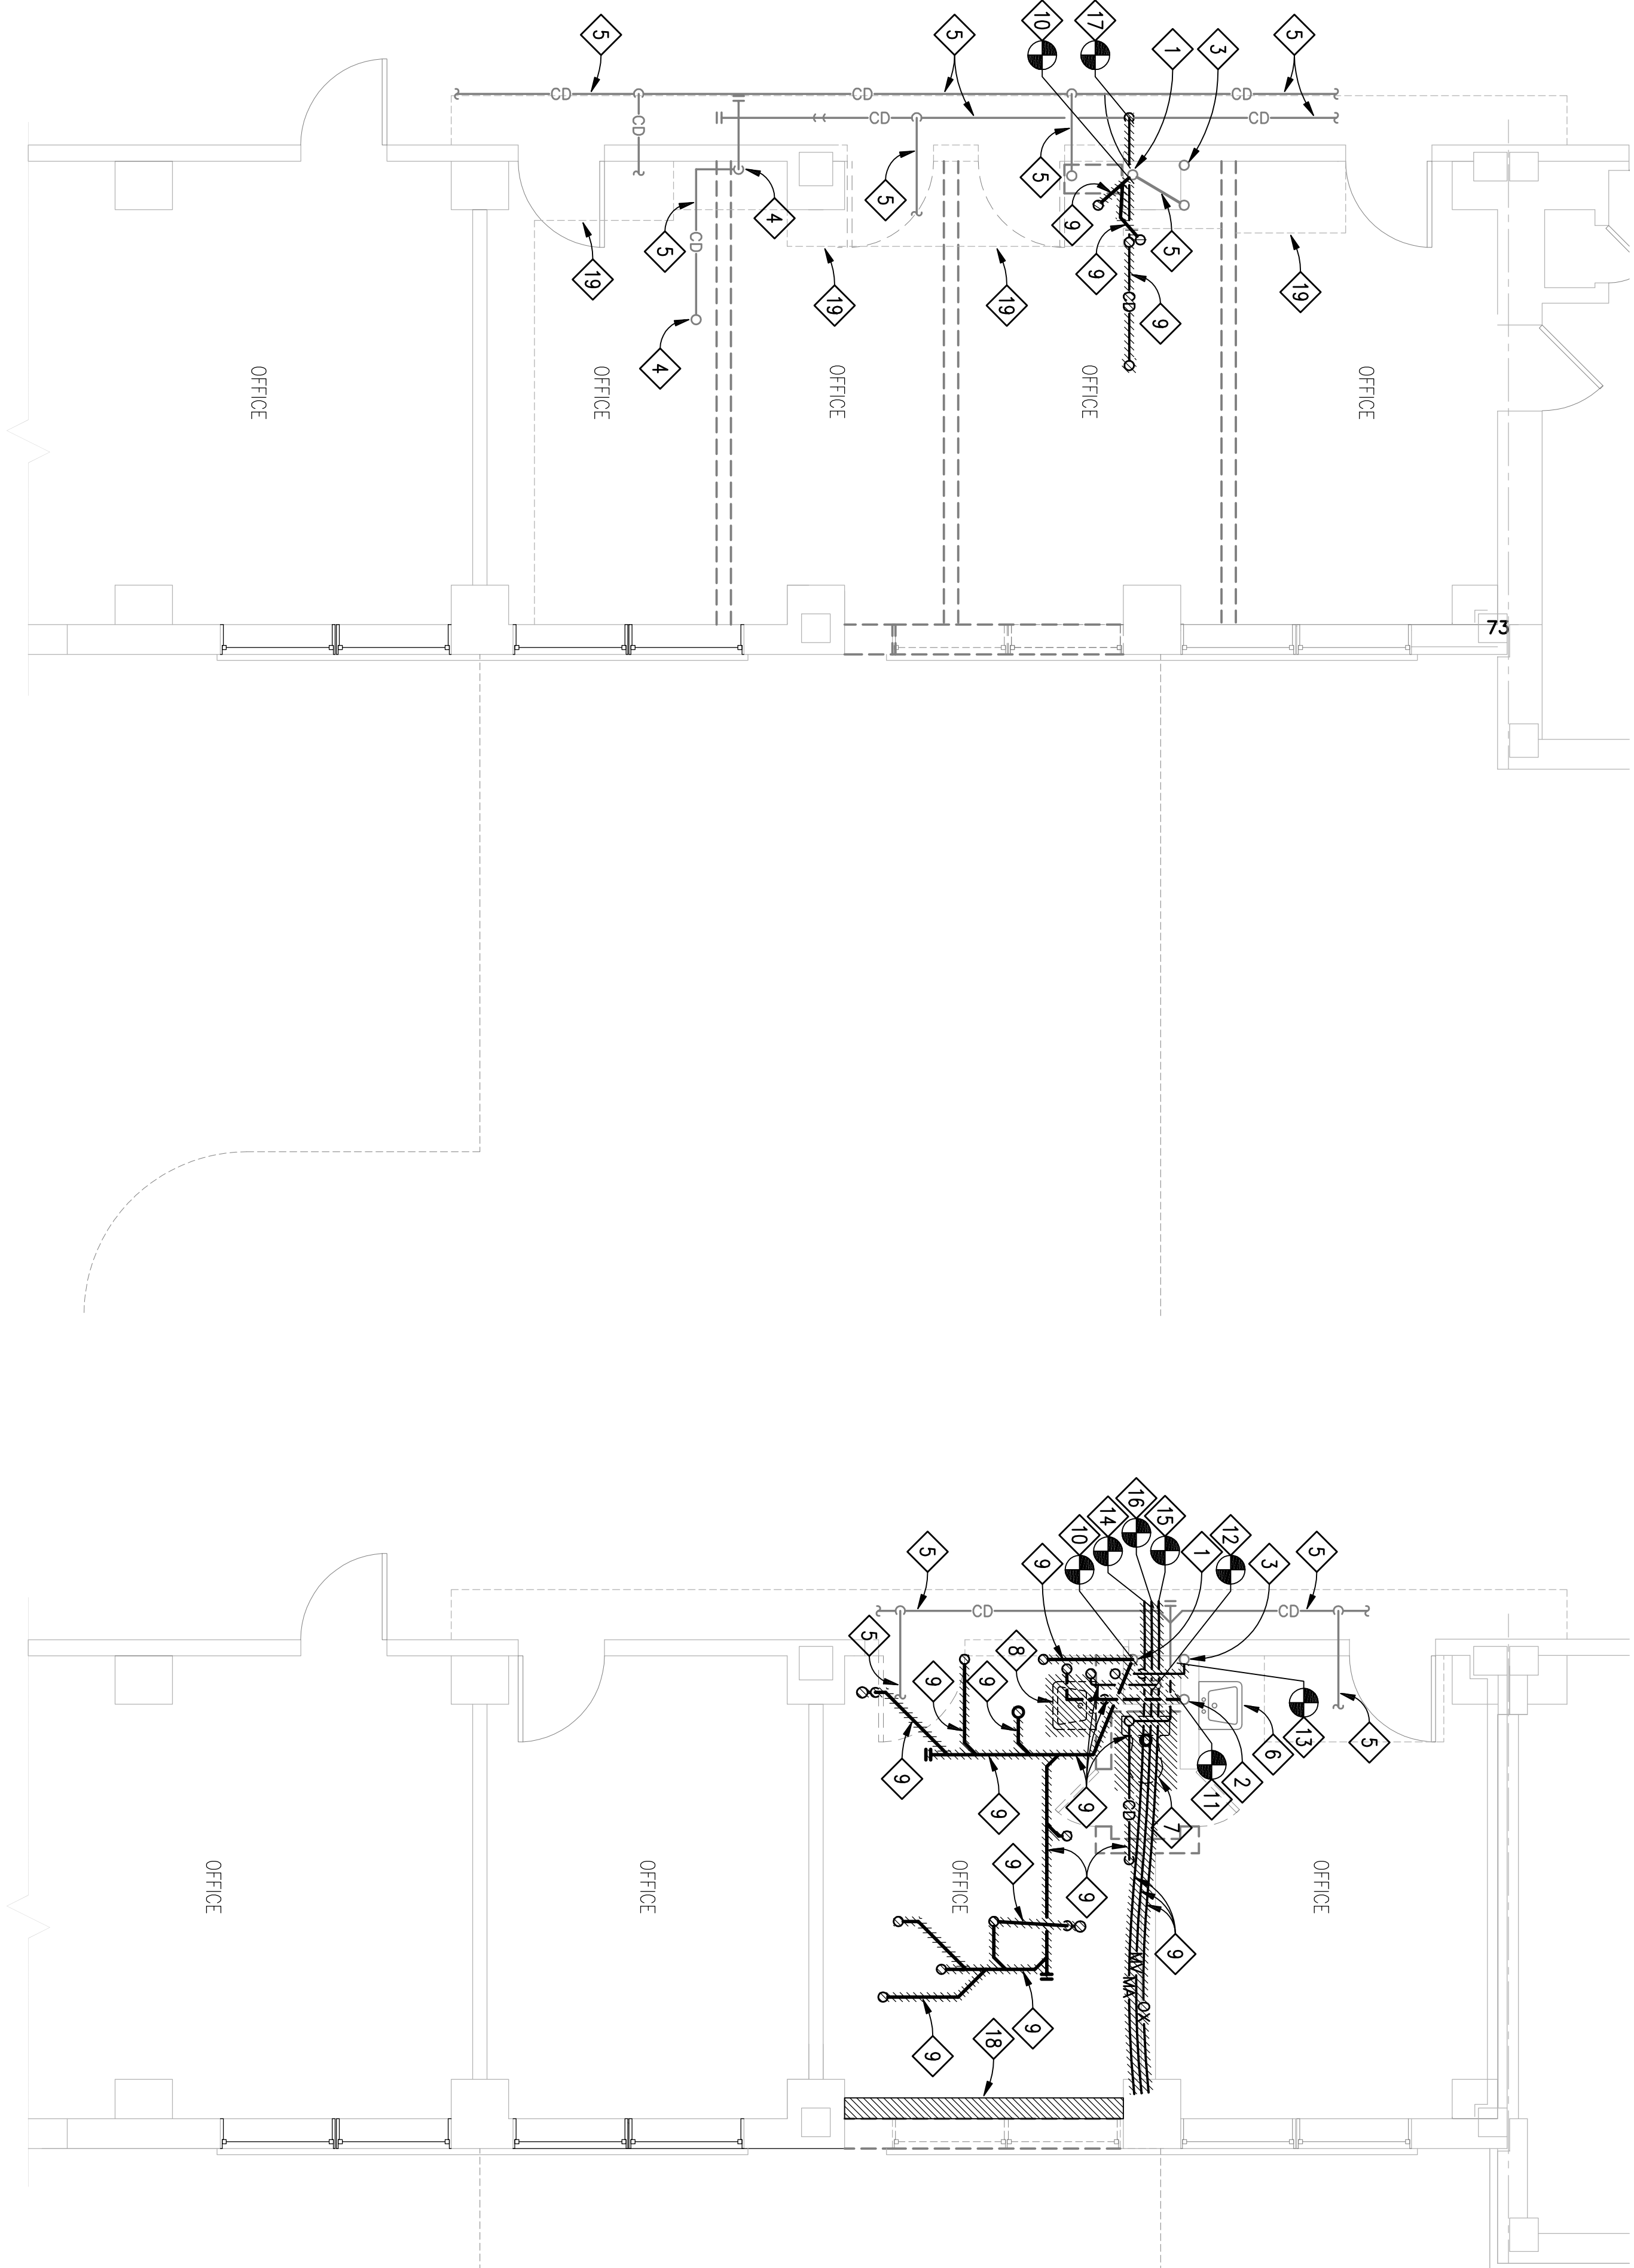

ENLARGED DEMOLITION FLOOR PLAN  
4TH FLOOR STAIRS – PLUMBING

 SCALE: 1/4" = 1'-0"



ENLARGED DEMOLITION FLOOR PLAN  
5TH FLOOR STAIRS – PLUMBING

SCALE: 1/4" = 1'-0"



Drawing Title  
**ENLARGED DEMO FLOOR  
PLANS 4TH AND 5TH FLOOR  
STAIRS – PLUMBING**

Approved Project Engineer

Project Title  
**2ND FLOOR OUTPATIENT  
MENTAL HEALTH**

Building Number

BLDG 1 SOUTH WING

Checked

RDT

Drawn

DLB

Date  
05-25-2011

Project No.  
VA256-C-1047

DRAWING NO.

PD402

Day - 01

**Veterans  
Administration**

**100% REVIEW  
SUBMITTAL**