

A

1

2

3

4

5

6

7

8

 
NEW WORK KEYED NOTES:

(THIS DRAWING ONLY)


- ① PROVIDE NEW 4" ROOF DRAIN. REFEEE TO DETAIL ON DRAWING P501.

B

one inch = one foot




three-quarters inch = one foot

 


C

 one-half inch = one foot




D

 three-eighths inch = one foot




E

 one-quarter inch = one foot




F

one-eighth inch = one foot

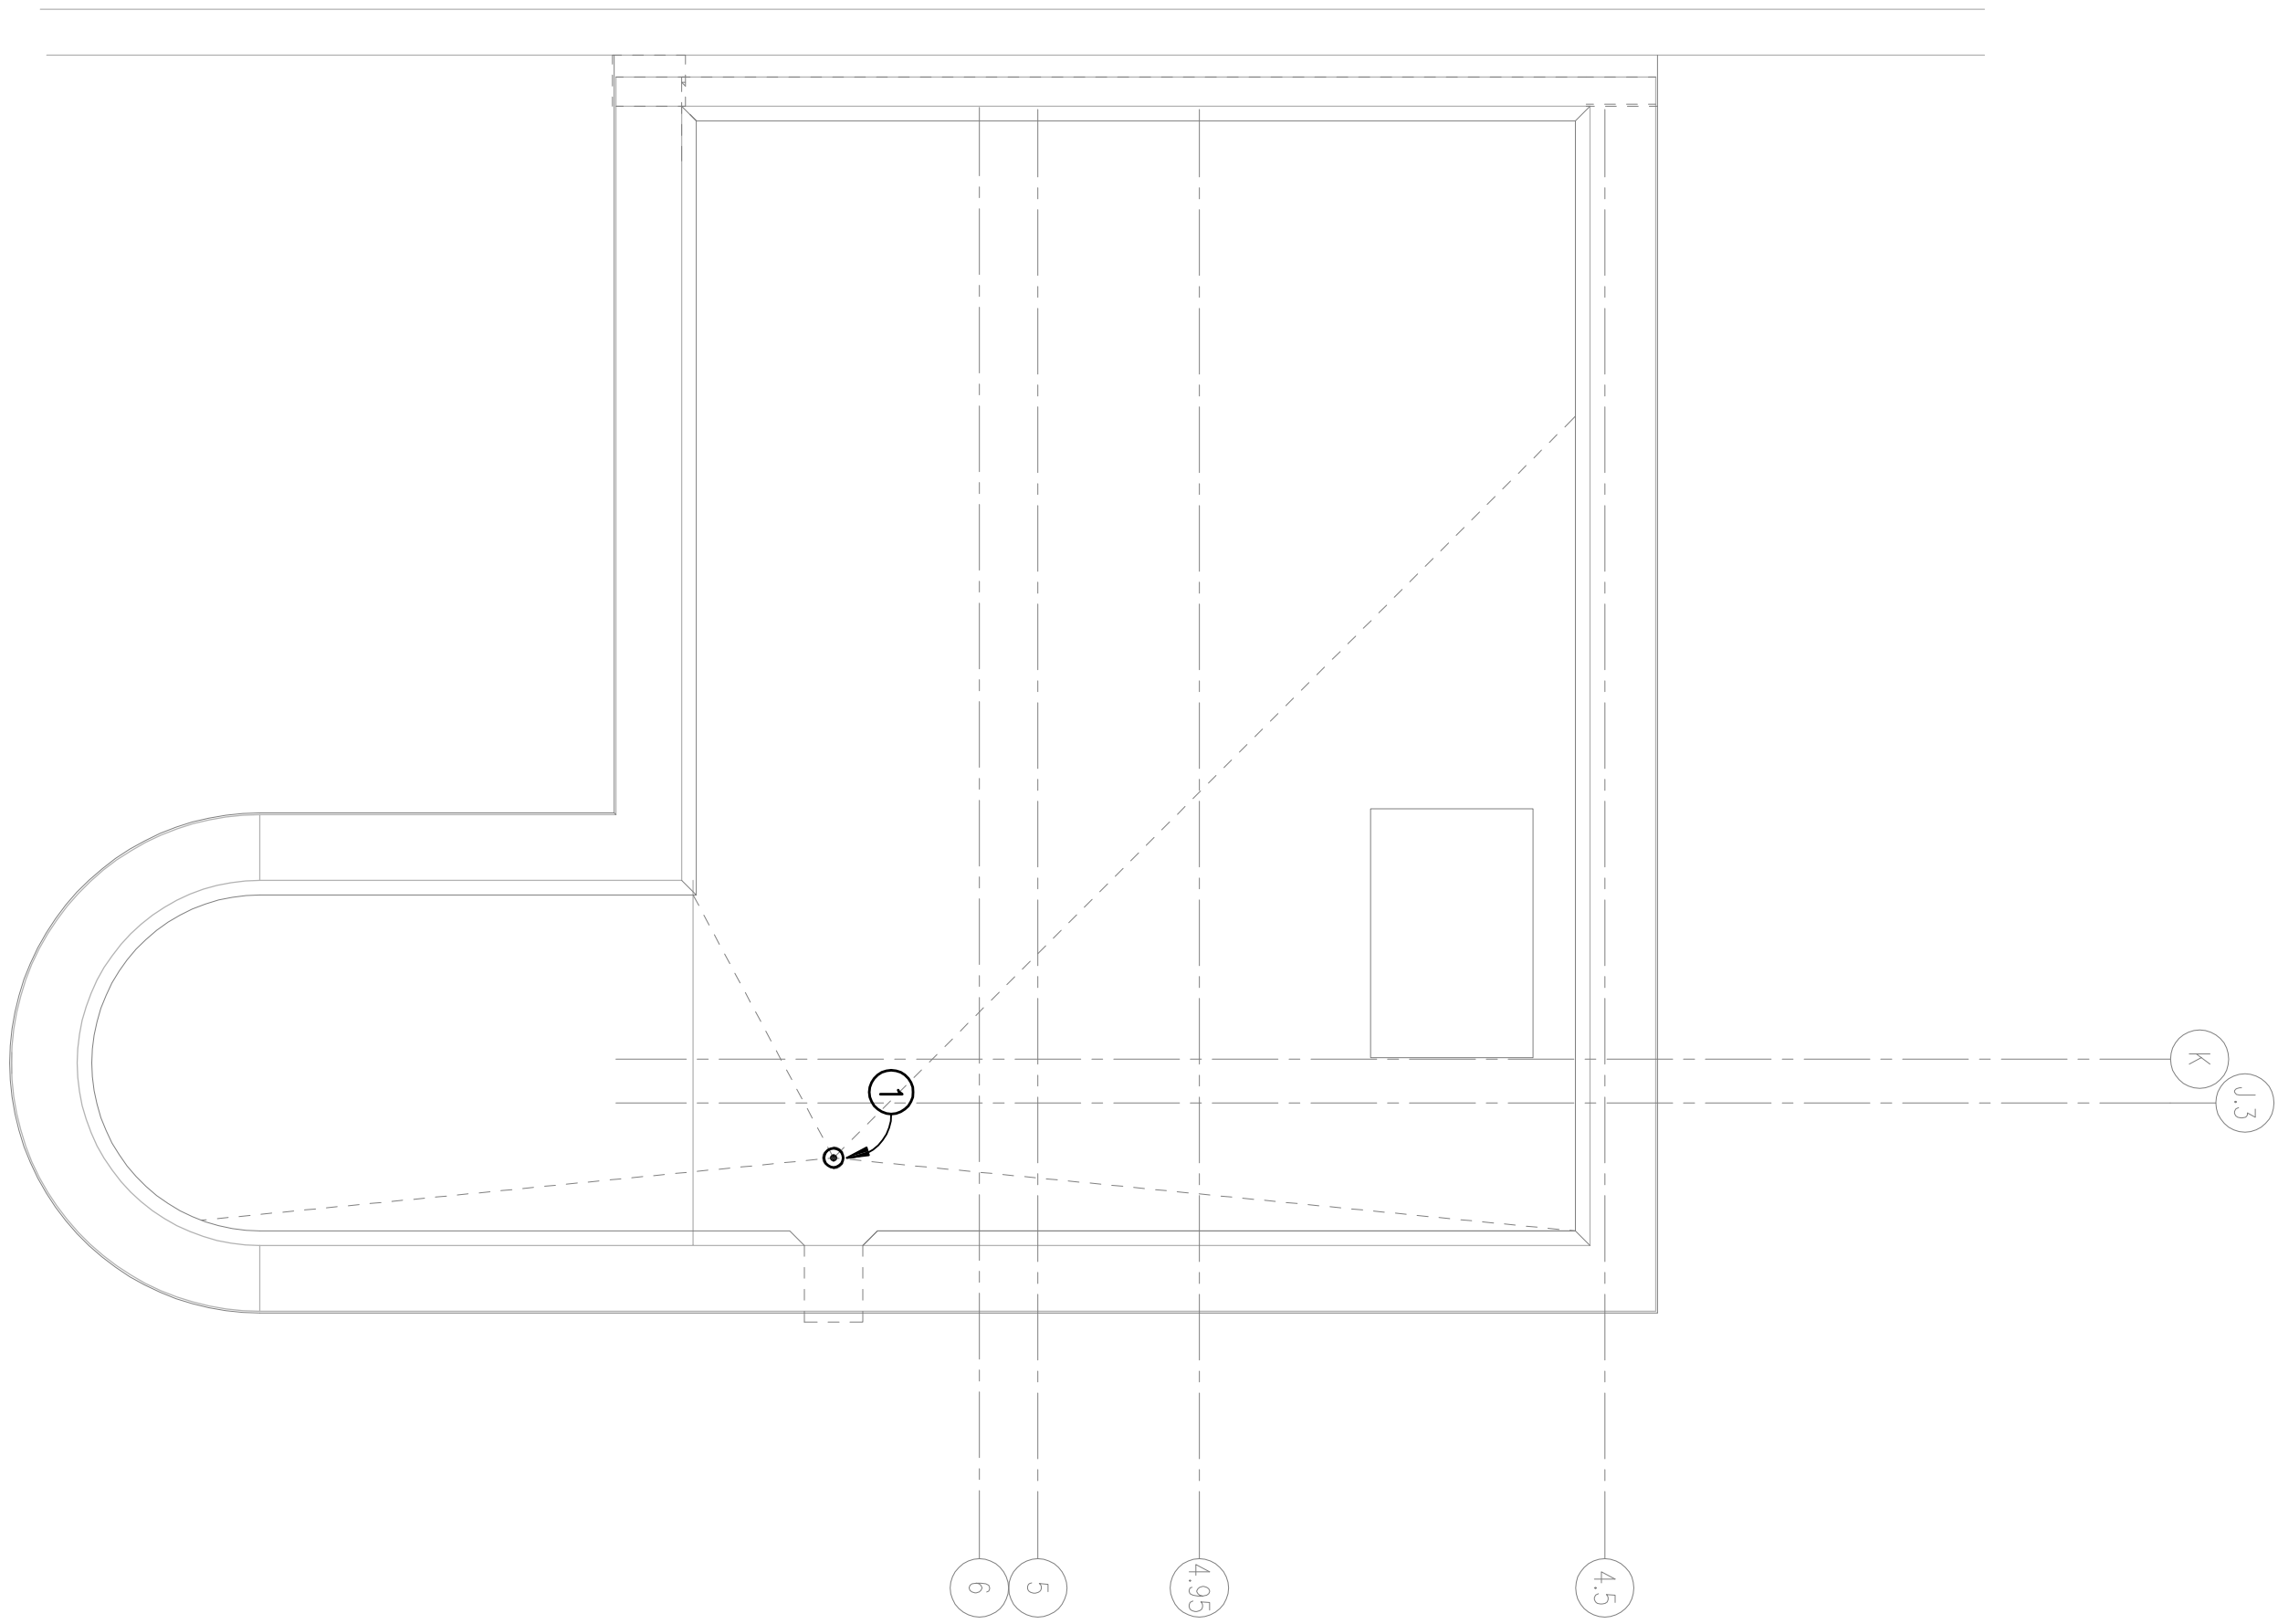


ENLARGED NEW WORK FLOOR PLAN
ROOF FLOOR STAIRS – PLUMBING

 SCALE: 1/4" = 1'-0"



Revisions	Date

Toland ♦ Mizell ♦ Molnar, LLC
590 MEANS STREET NW,
SUITE 200
ATLANTA, GA, 30318
404-214-9774

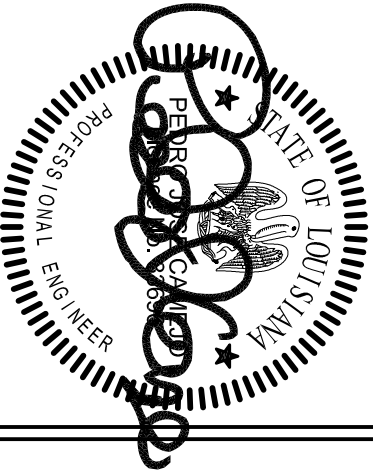

Drawing Title
ENLARGED NEW WORK FLOOR PLAN ROOF FLOOR STAIRS – PLUMBING
Approved Project Engineer

Project Title
2ND FLOOR OUTPATIENT MENTAL HEALTH
Building Number
BLDG 1 SOUTH WING
Location
VA MEDICAL CENTER SHREVEPORT, LOUISIANA

Date
05-25-2011
Project No.
VA256-C-1047
Drawing No.
P405
Dwg. - Of

Veterans
Administration

100% REVIEW
SUBMITTAL