



LIGHTNING PROTECTION SYSTEM ADHESIVE BASE DETAIL

SCALE: NONE

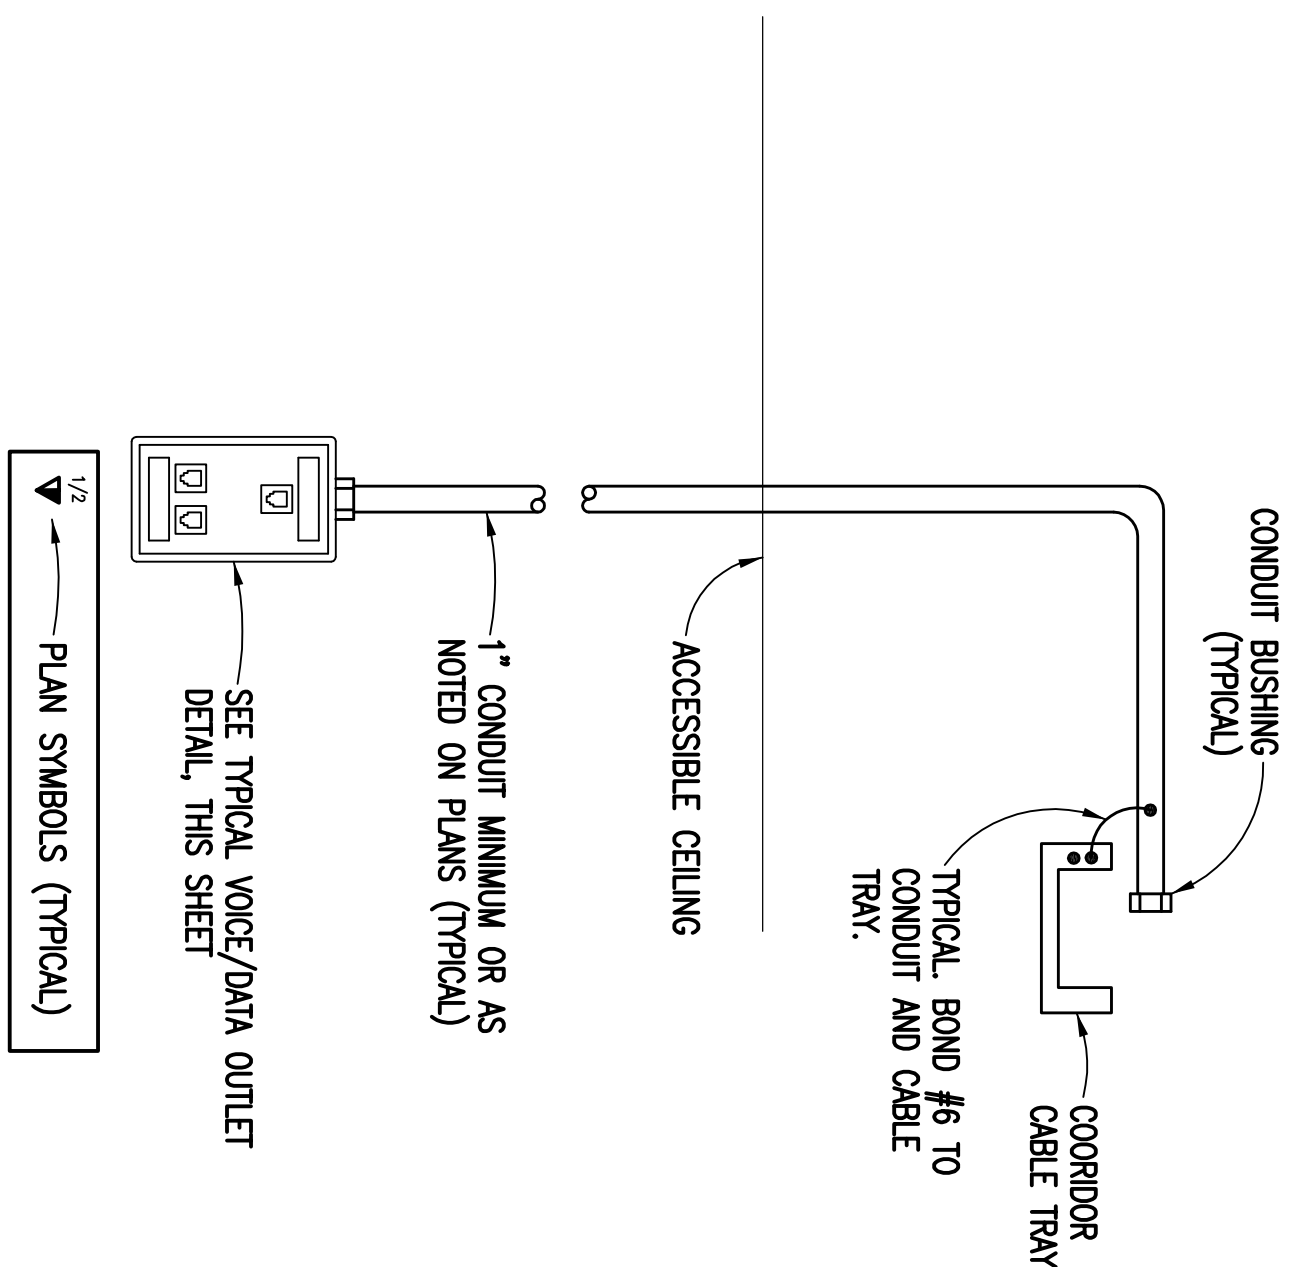

TELECOMMUNICATIONS OUTLETS


SCALE: NONE

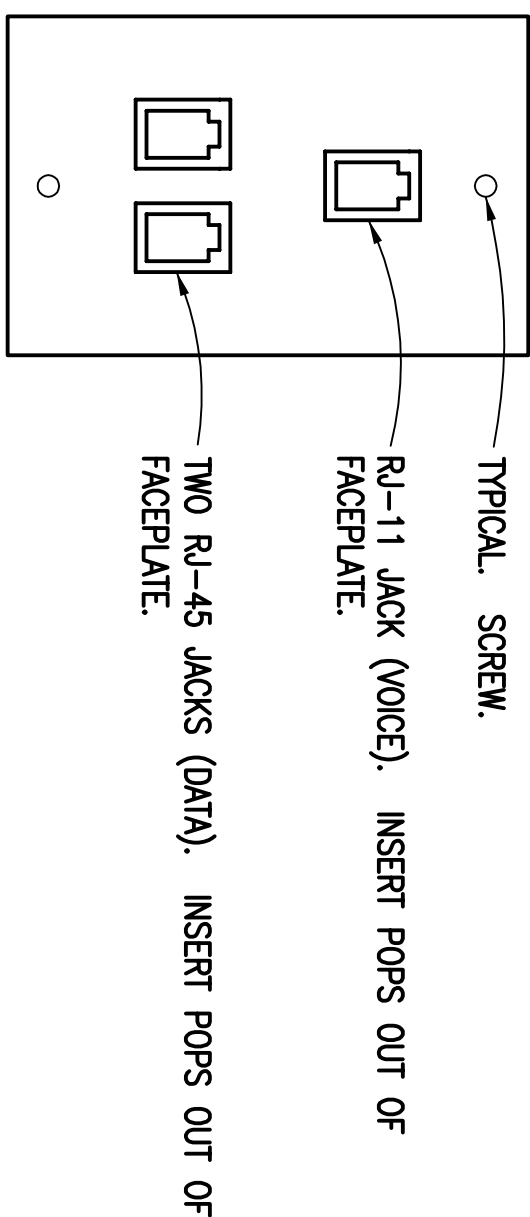

- NOTES:
1. PROVIDE SINGLE GANG FACEPLATE WITH REMOVABLE INSERTS.
 2. WALL PHONE OUTLETS SHALL BE STAINLESS STEEL WITH MODULAR RJ-11 JACKS AND FEATURE STUDS TO WALL MOUNT TELEPHONES.

TYPICAL VOICE/DATA OUTLET

SCALE: NONE

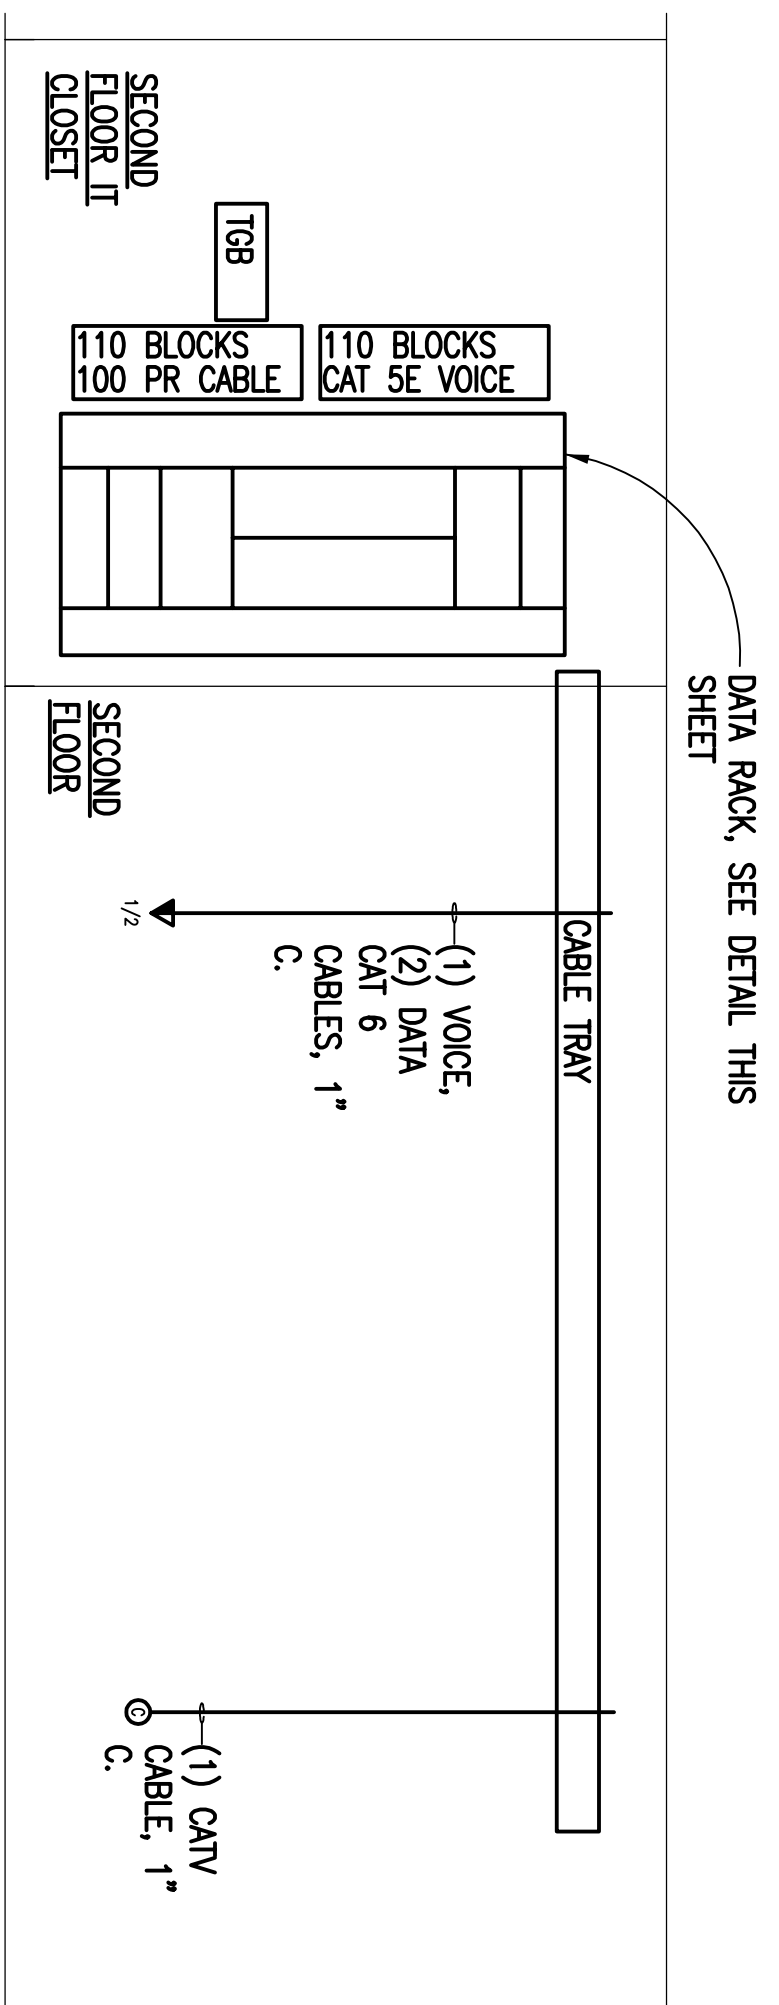

DATA RACK DETAIL

SCALE: NONE

1. ALL COMPONENTS AND TERMINATIONS BY THE CONTRACTOR EXCEPT OWNER EQUIPMENT, OWNER EQUIPMENT NOT IN CONTRACT.
2. CROSS-CONNECTS TO OWNER EQUIPMENT BY OWNER.
3. PROVIDE 48 PORT PATCH PANELS AS REQUIRED FOR DROPS SHOWN PLUS 50% FOR FUTURE.
4. PROVIDE FLOOR MOUNTED DATA RACK COMPLETE WITH WIRE MANAGEMENT AND POWER CORD STRIPS WITH 12 CORD MINIMUM.




PARTIAL ELECTRICAL

EXISTING HOSPITAL FIRST FLOOR PLAN

SCALE: 1/16" = 1'-0"

- ① PTZ CAMERA SYSTEM IN 1-W-26.
- ② FIRE ALARM PANEL IN 1-W-58.
- ③ APPROXIMATE LOCATION OF PANEL HD1 ON BASEMENT FLOOR.
- ④ TELEPHONE (VOICE SYSTEM) IN 1-N-2.
- ⑤ DATA/COMMUNICATIONS SYSTEM IN 1-E-97.

		100% REVIEW
NORTH		SUBMITTAL
DATE 05-25-2011		
PROJECT NO. VA256-C-1047		
DRAWING NO. E502		
DESIGNED BY		

DRAWING TITLE DETAILS ELECTRICAL		PROJECT TITLE 2ND FLOOR OUTPATIENT MENTAL HEALTH	
APPROVED PROJECT ENGINEER		BUILDING NUMBER BLDG 1 SOUTH WING	
		CHECKED RBP	
		DRAWN TWG	
LOCATION VA MEDICAL CENTER SHREVEPORT, LOUISIANA			

Veterans Administration	
-------------------------	--