



CHAIN LINK FENCE, GATE, HARDWARE, TRUSS ROD W/ TURNBUCKLE, TIE WIRES, TENSION WIRES AND ALL APPURTENANCES SHALL BE FURNISHED AND INSTALLED IN ACCORDANCE WITH THE MANUFACTURER'S SPECIFICATIONS

CHAIN LINK FENCE DETAIL
N.T.S.

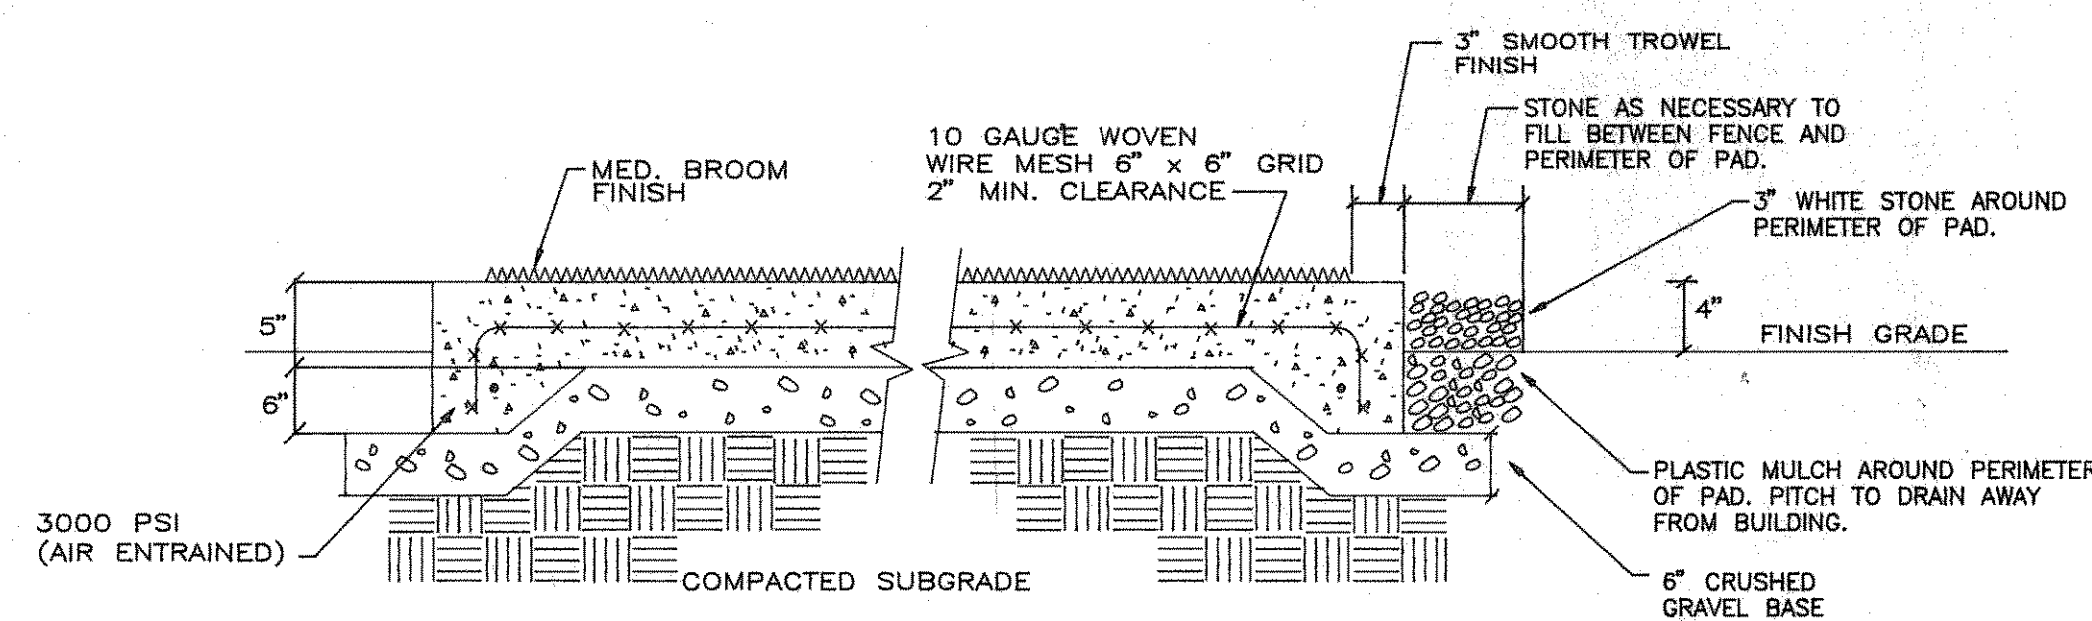


CONCRETE PAD DETAIL
N.T.S.

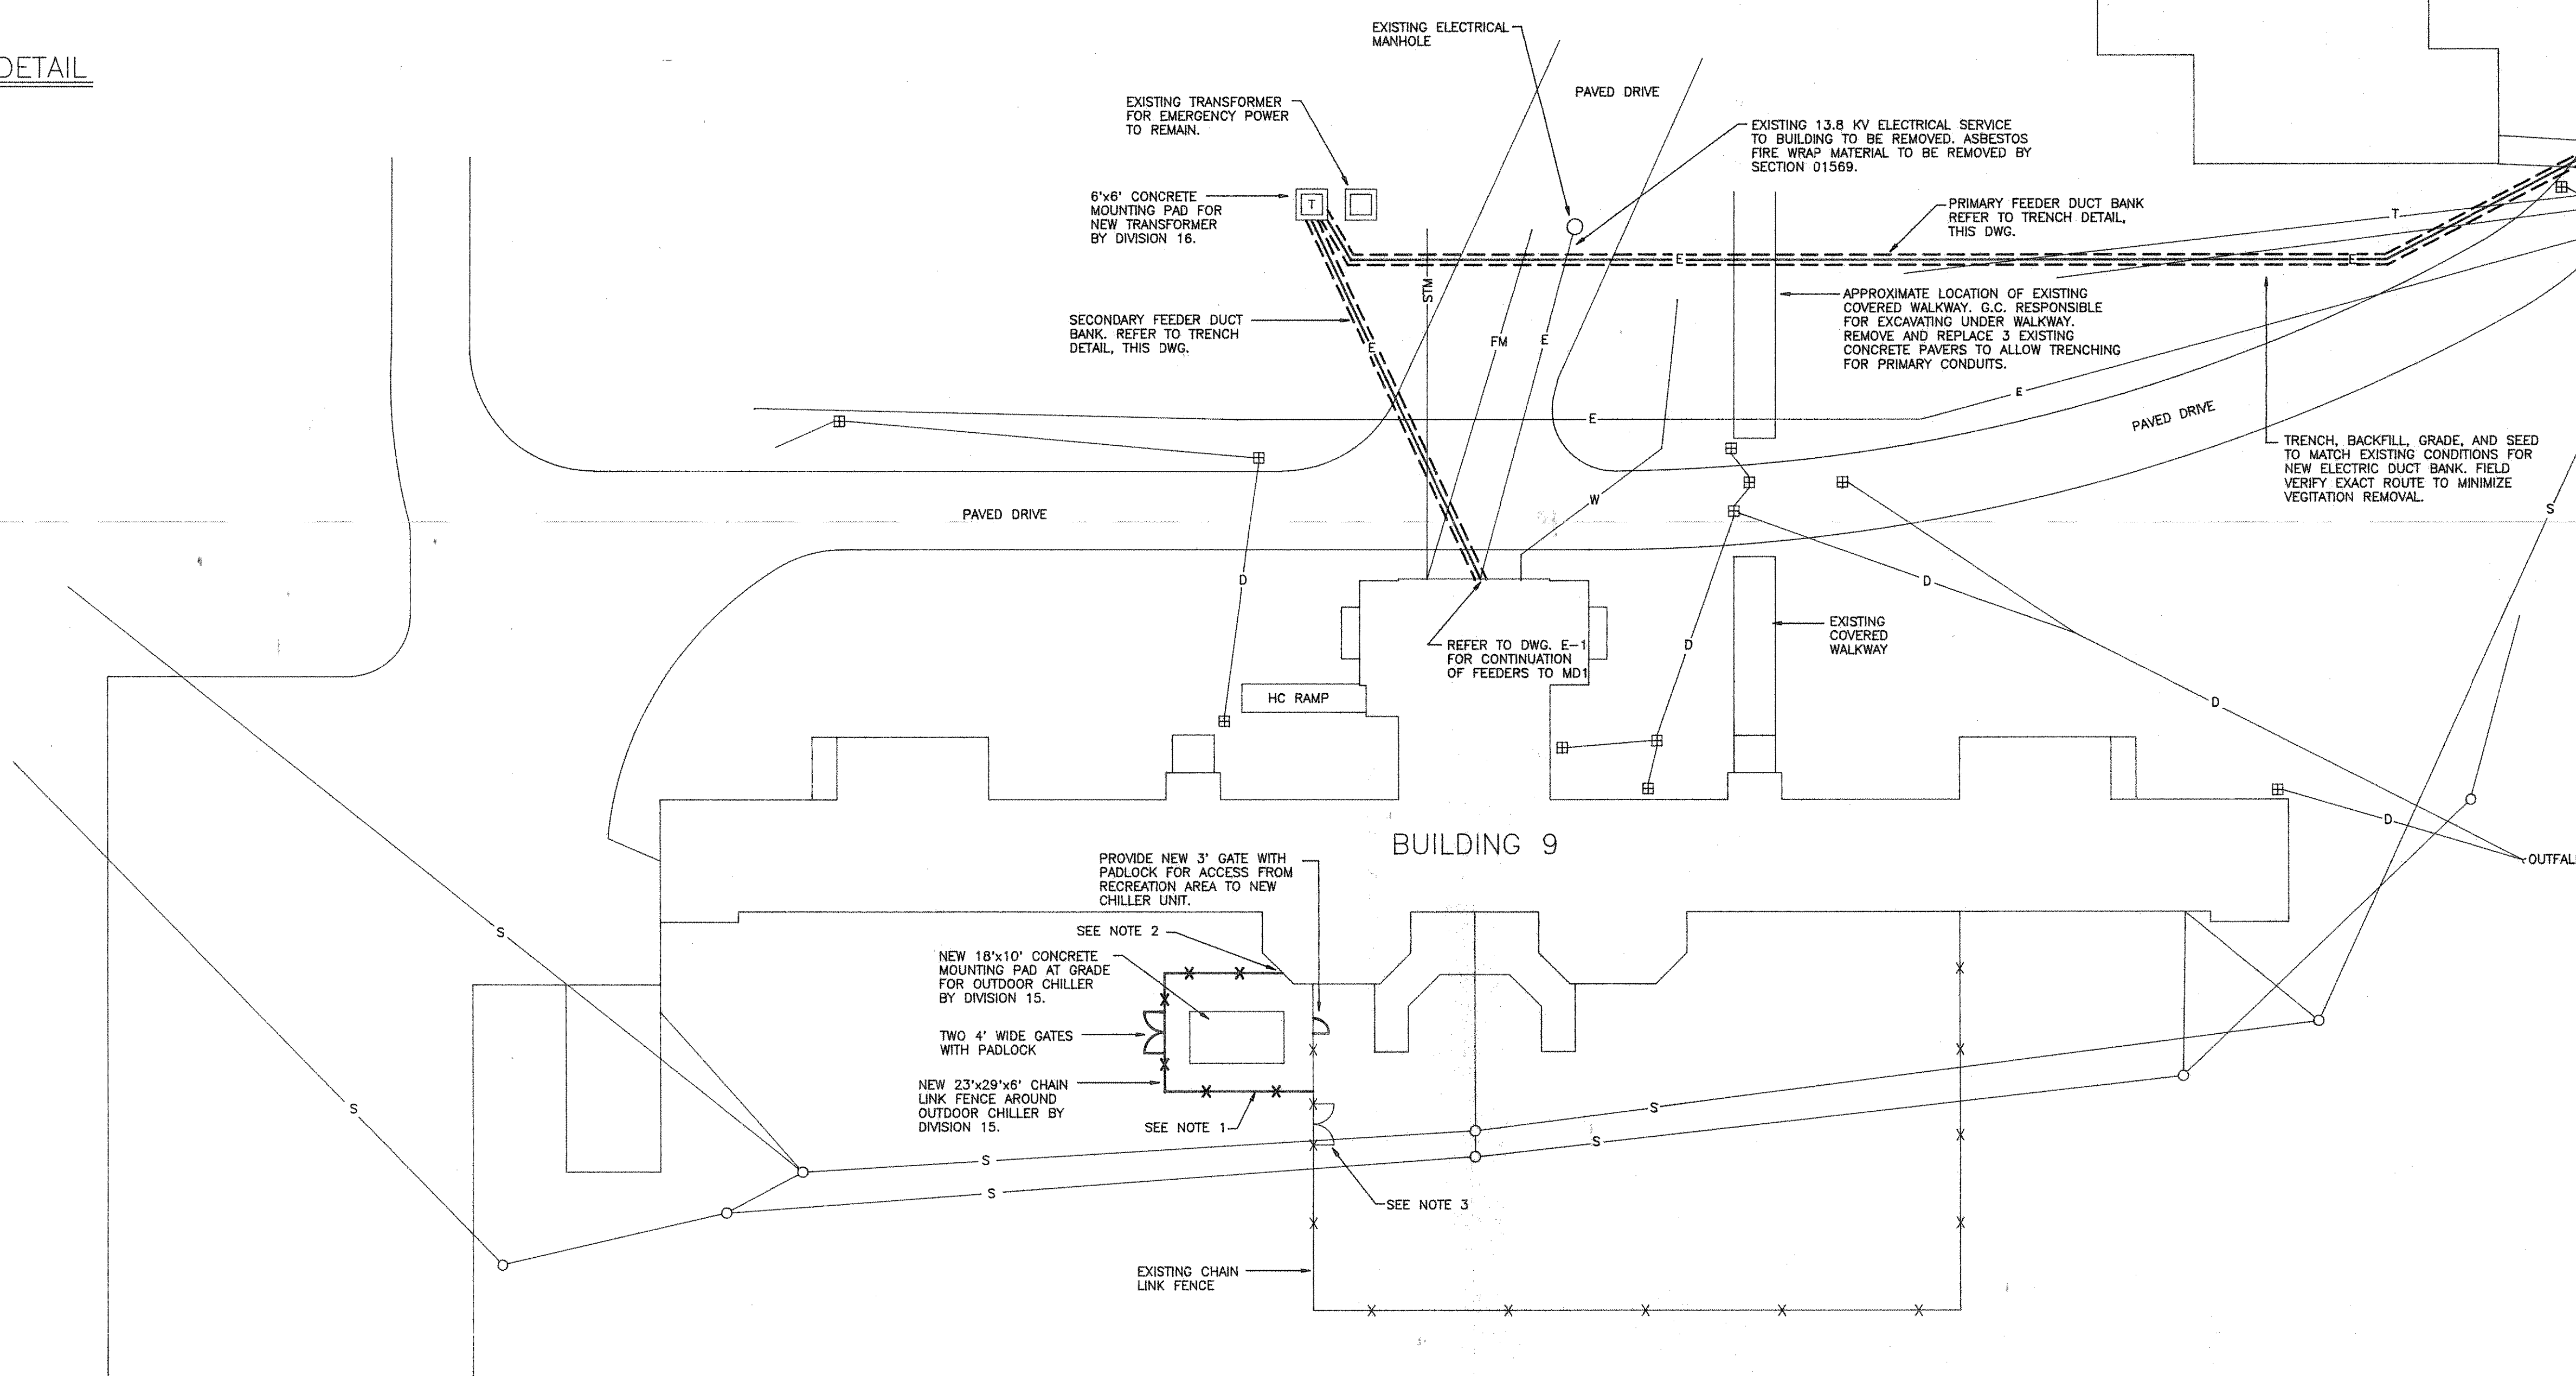


- NOTES:
1. PROVIDE GREEN PRIVACY SLATS FOR NEW CHAIN LINK FENCE.
 2. END FENCE AT BUILDING AND AT EXISTING FENCE WITH NEW POSTS. DO NOT ATTACH NEW FENCE TO BUILDING OR EXISTING FENCE.
 3. RELOCATE EXISTING RECREATION AREA GATE IF NECESSARY.
 4. ALL LIVING TREES MUST BE AVOIDED OR REPLACED.
 5. EXISTING UTILITIES HAVE RIGHT OF WAY OVER NEW UTILITIES.


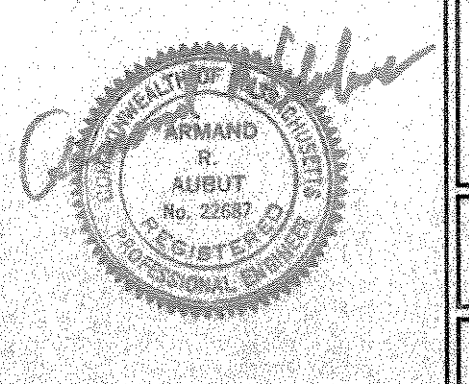
- LEGEND:
- S — EXISTING UNDERGROUND SANITARY PIPE
 - T — EXISTING UNDERGROUND TELEPHONE DUCTLINE
 - E — EXISTING UNDERGROUND ELECTRICAL DUCTLINE
 - E — NEW UNDERGROUND ELECTRICAL DUCTLINE
 - D — EXISTING UNDERGROUND STORM DRAIN
 - W — EXISTING UNDERGROUND WATER PIPE
 - STM — EXISTING UNDERGROUND STEAM PIPE
 - S — EXISTING PAD MOUNTED HIGH VOLTAGE SWITCH
 - T — PAD MOUNTED TRANSFORMER

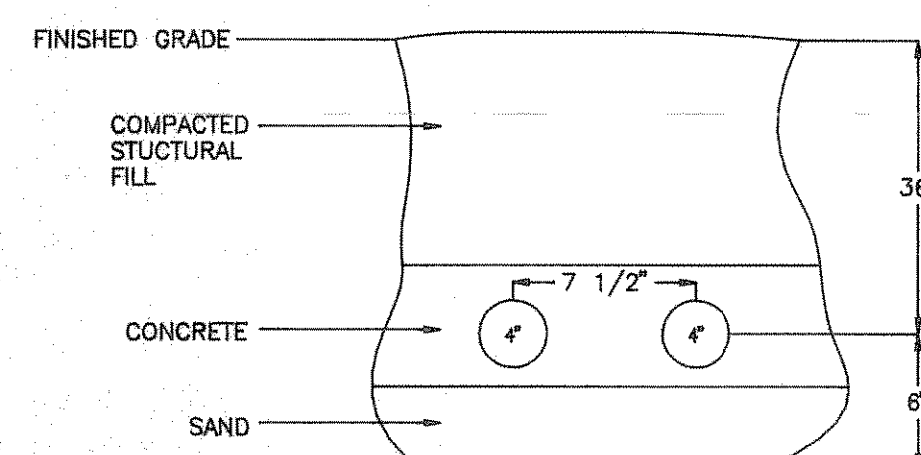

PRIMARY TRENCH DETAIL
N.T.S.

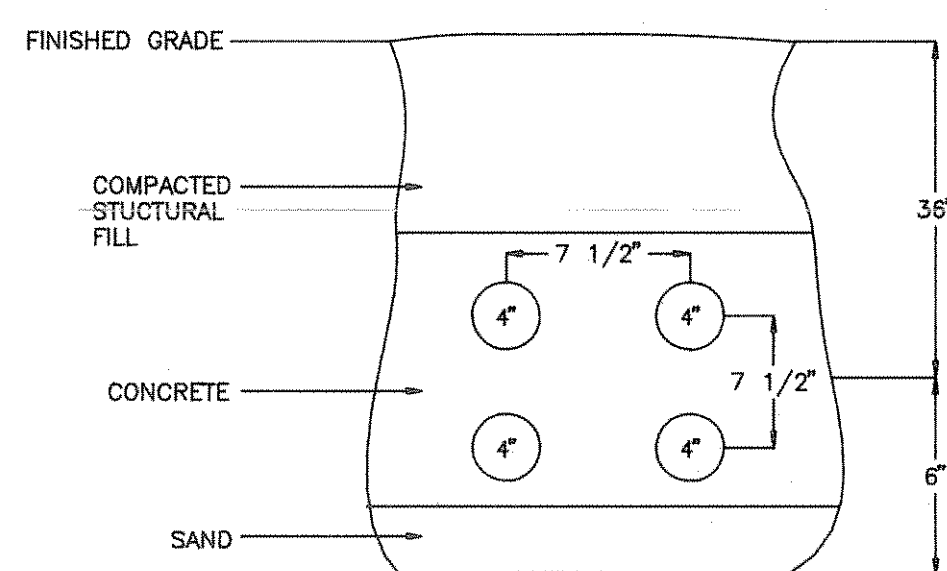

SECONDARY TRENCH DETAIL
N.T.S.

 <p>Department of Veterans Affairs Medical Center Northampton, MA 01060</p>	INDUSTRIAL HYGIENIST	ELECTRICAL ENGINEER	DESIGNER/MECHANICAL ENGINEER		Drawing Title	Project Title		Date	
	DENNISON ENVIRONMENTAL 800 West Cummings Park, Suite 8500 Woburn, Massachusetts 01453 (617) 832-8400	SHEPHERD ENGINEERING 1308 Grafton Street Worcester, Massachusetts 01503 (508) 787-7783	ARA ENGINEERING ASSOCIATES, INC. 171 Main Street, Suite 103 Amherst, Massachusetts 01721 (508) 881-7432		SITE PLAN	AIR QUALITY IMPROVEMENTS WARD 9		07-15-93	
					Approved: Division Chief	Building Number	Checked	Drawn	Project No.
					Approved: Service Director	9	ARA	TGB	631-91-105
					Location		DRAWING NO.		
					NORTHAMPTON, MASSACHUSETTS		59-24		
							C-1		
							Dwg. 2 of 12		

Veterans Administration