



FIRST FLOOR PLAN

1/8" = 1'-0"

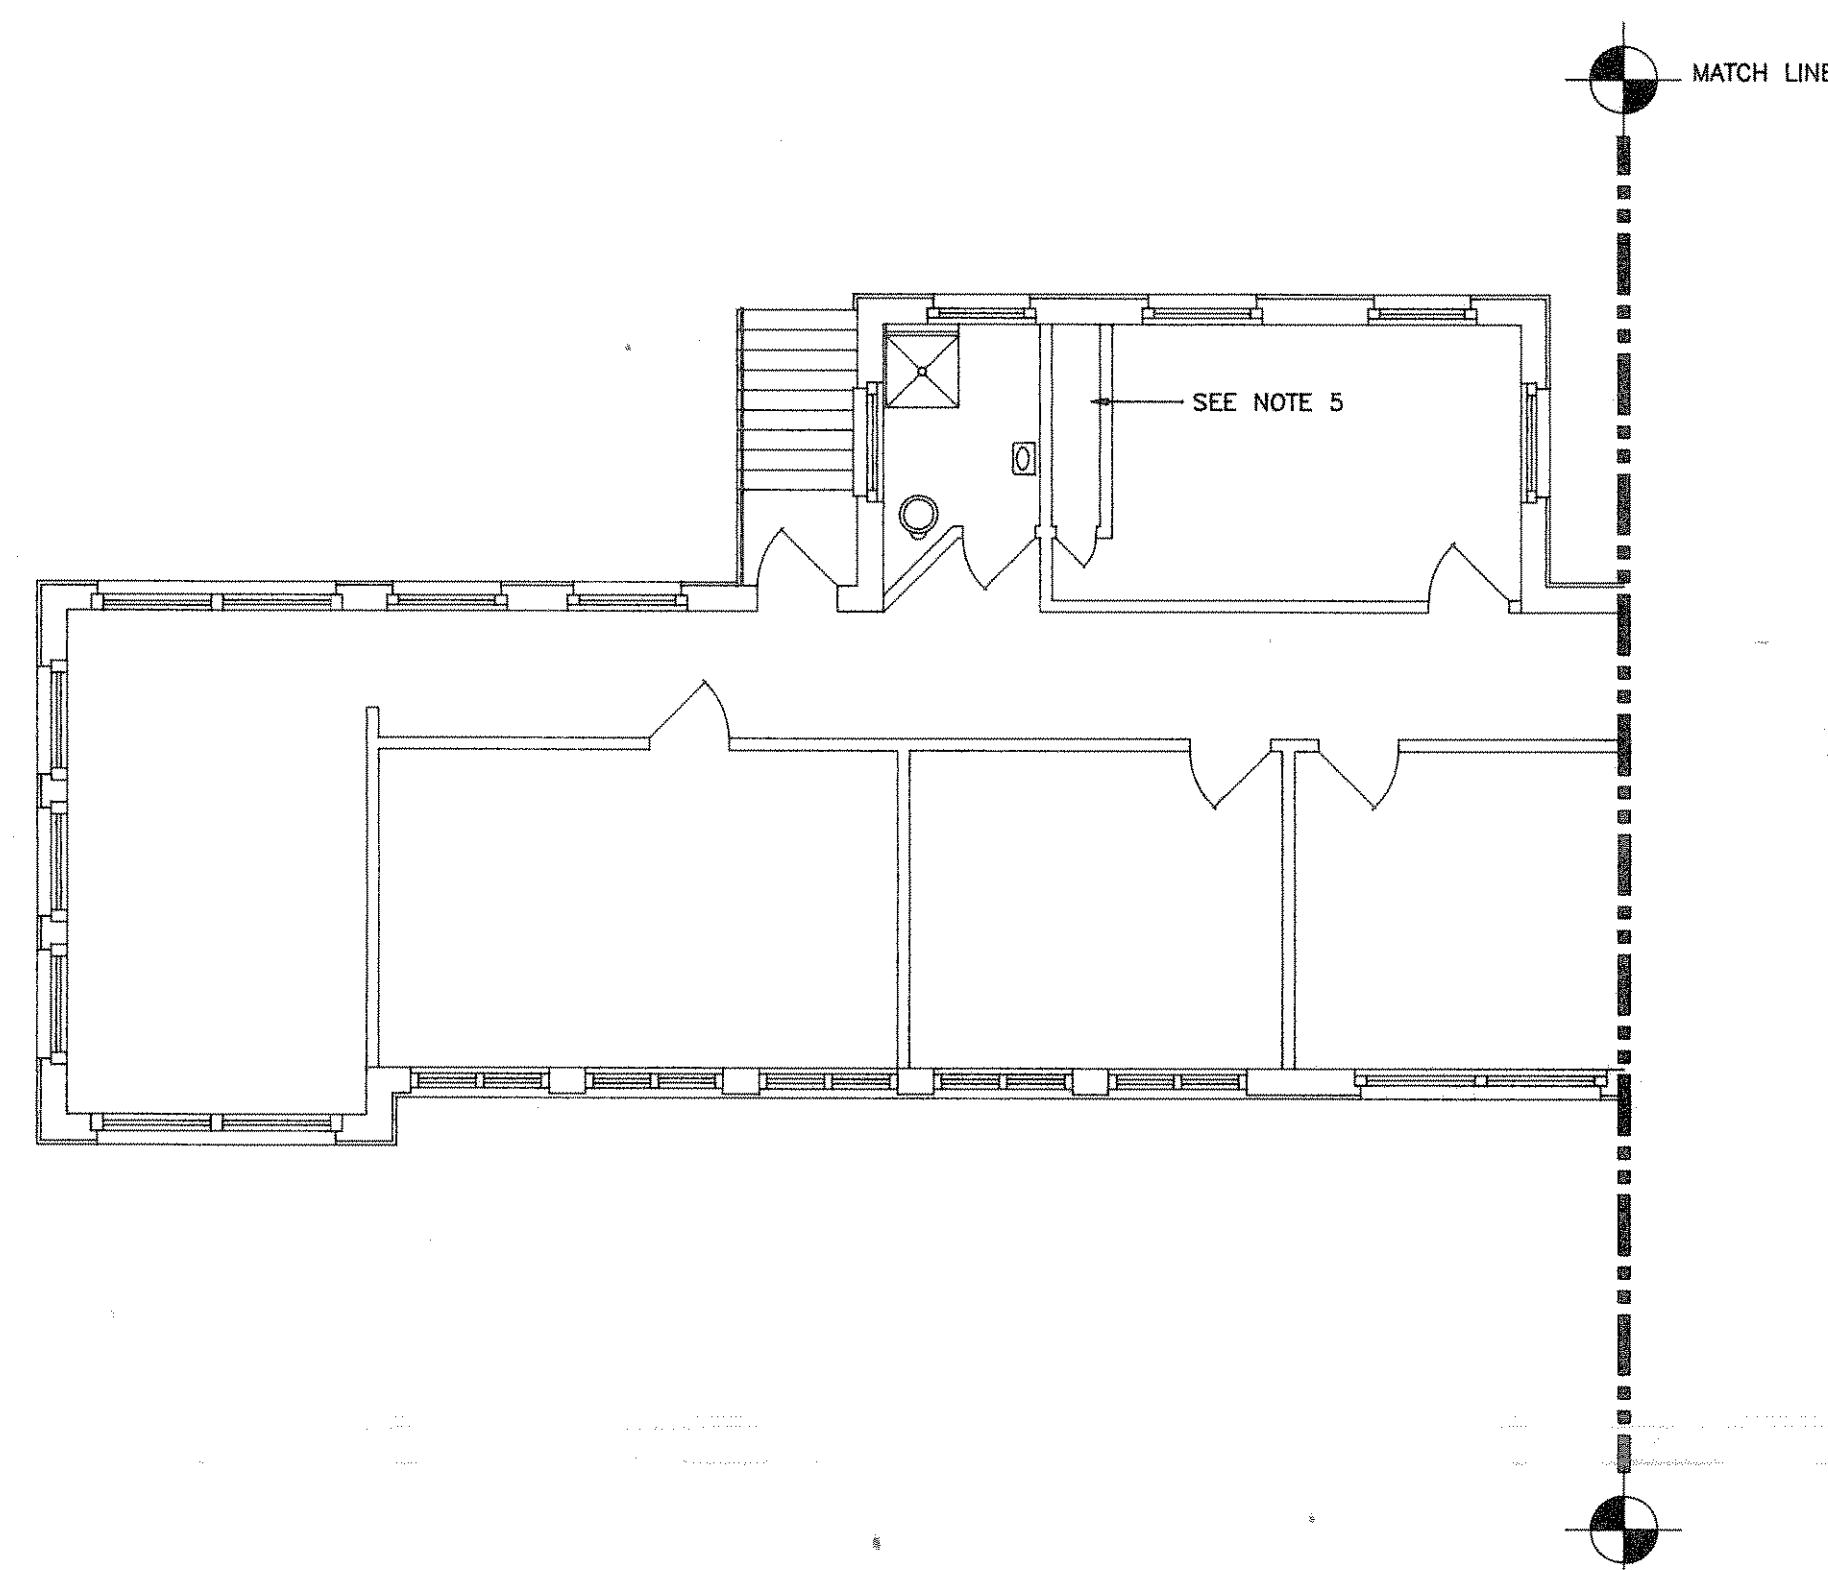


| DOOR SCHEDULE | | | | | | | |
|---------------|-----------|--------|-------|-----------|---------|-------|----------|
| NO. | LOCATION | SIZE | | | TYPE | FRAME | HARDWARE |
| | | HEIGHT | WIDTH | THICKNESS | | | |
| 1 | PUMP ROOM | 7'-0" | 3'-0" | 1 3/4" | C LABEL | METAL | LEVER |

1. SEE SPECIFICATION FOR HARDWARE TYPE.

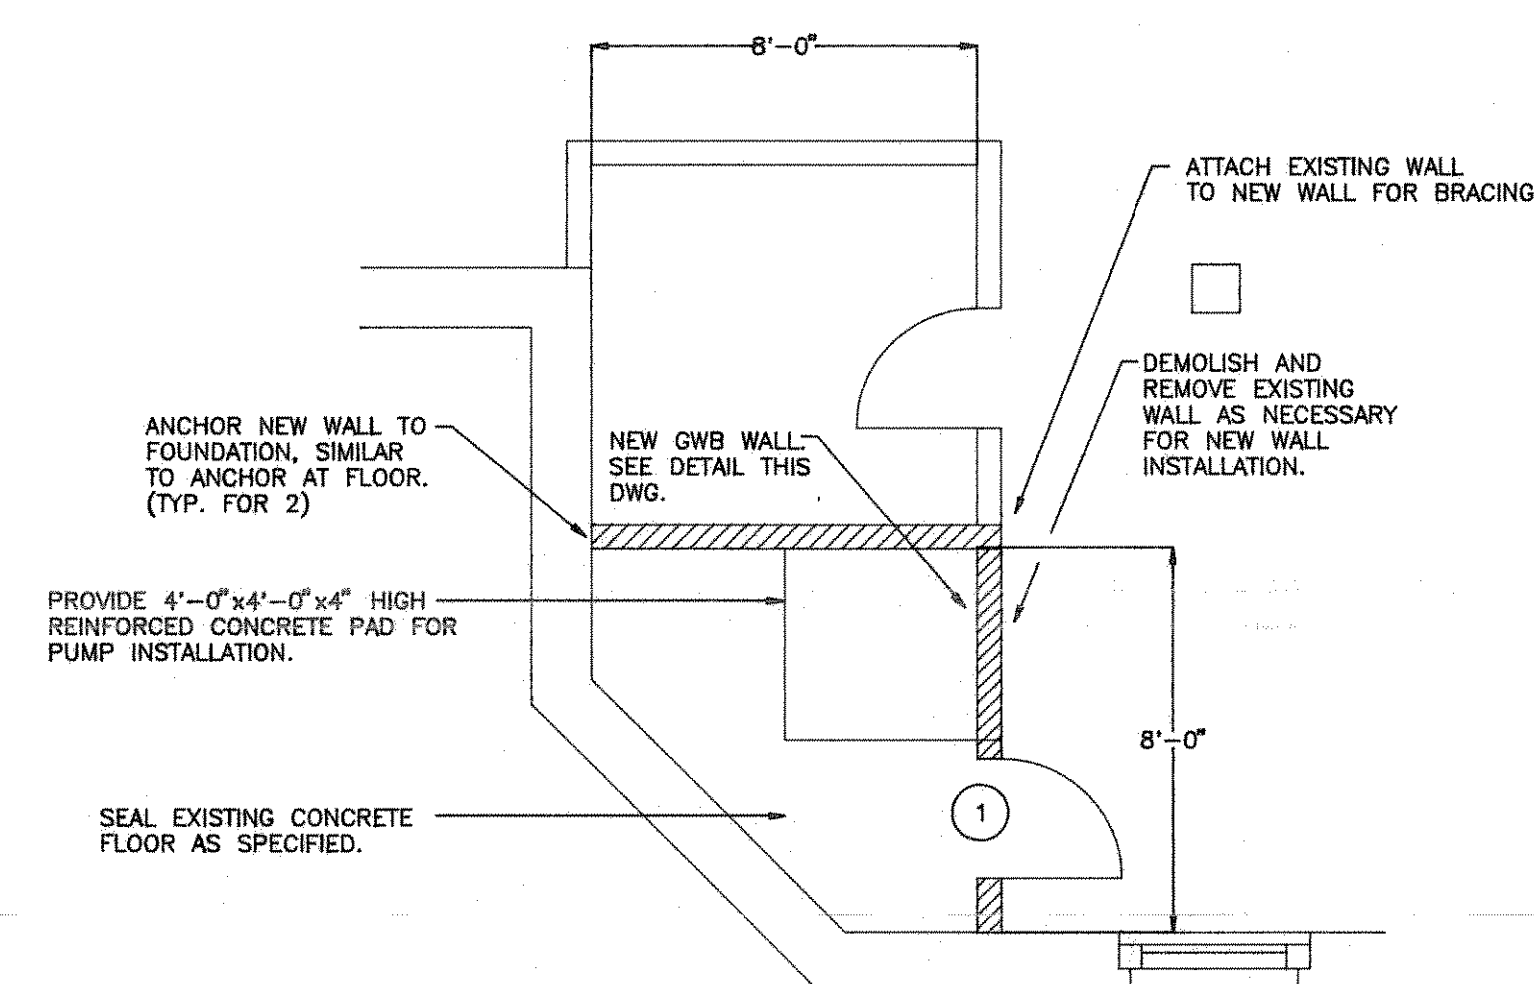

BASEMENT PUMP ROOM PART PLAN

1/4" = 1'-0"

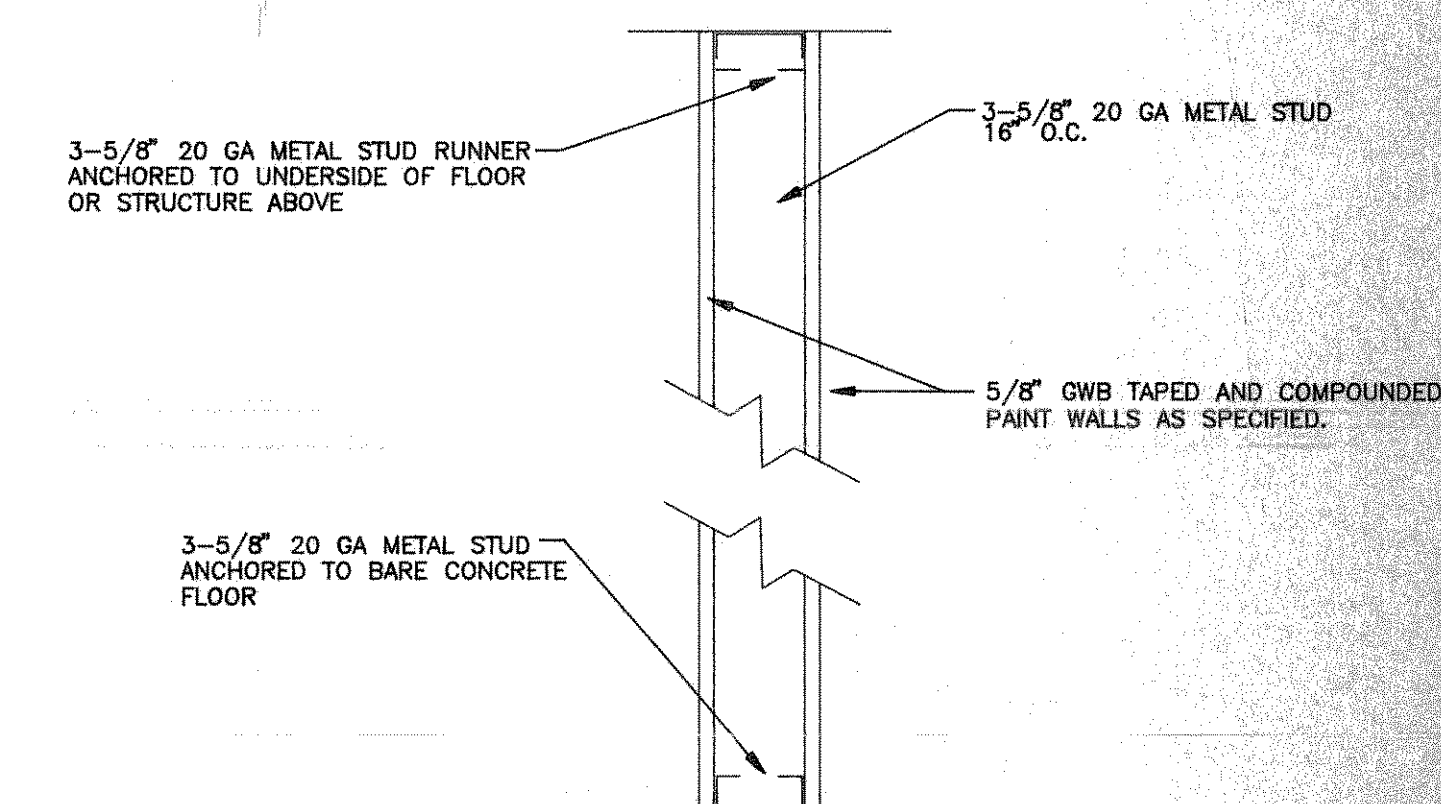

GWB WALL SECTION

1-1/2" = 1'-0"

NOTES:

1. REMOVE AND REINSTALL EXISTING SUSPENDED TILE CEILING SYSTEM WHERE NEW 2"x4" SUSPENDED CEILING IS NOT SHOWN AS NECESSARY TO INSTALL NEW SYSTEMS CEILING HEIGHT TO MATCH EXISTING HEIGHT.
2. MODIFY NEW CEILING AS NECESSARY TO ALLOW EXISTING SPRINKLER HEADS TO REMAIN IN PLACE.
3. GUT AND PATCH TO MATCH EXISTING CONDITIONS, ALL WALLS, FLOORS, AND NEW AND EXISTING CEILINGS AS NECESSARY TO INSTALL NEW SYSTEMS.
4. ALL AREAS SHOWN TO RECEIVE NEW CEILINGS HAVE EXISTING CEILING TO BE REMOVED BY SECTION 01569.
5. PROVIDE NEW 12"x12" VCT FLOORING AND ADHESIVE BY SECTION 09660 IN THIS ROOM TO REPLACE TILE REMOVED BY SECTION 01569. SUBMIT SAMPLES TO CONTRACT OFFICER FOR COLOR SELECTION.
6. REMOVE AND DISPOSE OF EXISTING SUSPENDED ACT CEILING FROM AREAS SHOWN TO HAVE NEW CEILING. EXISTING ASBESTOS CONTAINING CEILING ABOVE SUSPENDED CEILING TILES WILL BE ABATED BY SECTION 01569.



Department of Veterans Affairs
Medical Center
Northampton, MA 01060

INDUSTRIAL HYGIENIST


DENNISON ENVIRONMENTAL
600 West Cummings Park, Suite 8500
Woburn, Massachusetts 01453
(616) 932-9400

ELECTRICAL ENGINEER

SHEPHERD ENGINEERING
1308 Grafton Street
Worcester, Massachusetts 01503
(508) 757-7783

DESIGNER/MECHANICAL ENGINEER

ARA ENGINEERING ASSOCIATES, INC.
171 Main Street, Suite 103
Ashland, Massachusetts 01721
(508) 881-7432

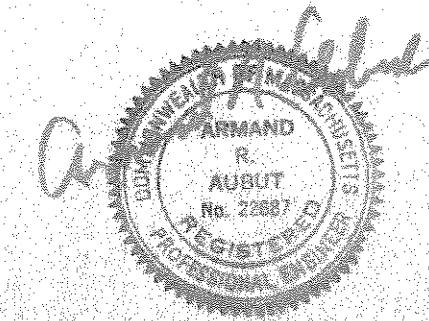

Drawing Title

FIRST FLOOR REFLECTED CEILING PLAN
& PART PLANS

Approved: Division Chief

Approved: Service Director

Project Title

AIR QUALITY IMPROVEMENTS
WARD 9

Building Number

9

Checked

ARA

Drawn

TGB

Location
NORTHAMPTON, MASSACHUSETTS

Date

07-15-93

Project No.

631-91-105

DRAWING NO.

54-24

A-1

Dwg. 5 of 12

Veterans
Administration