
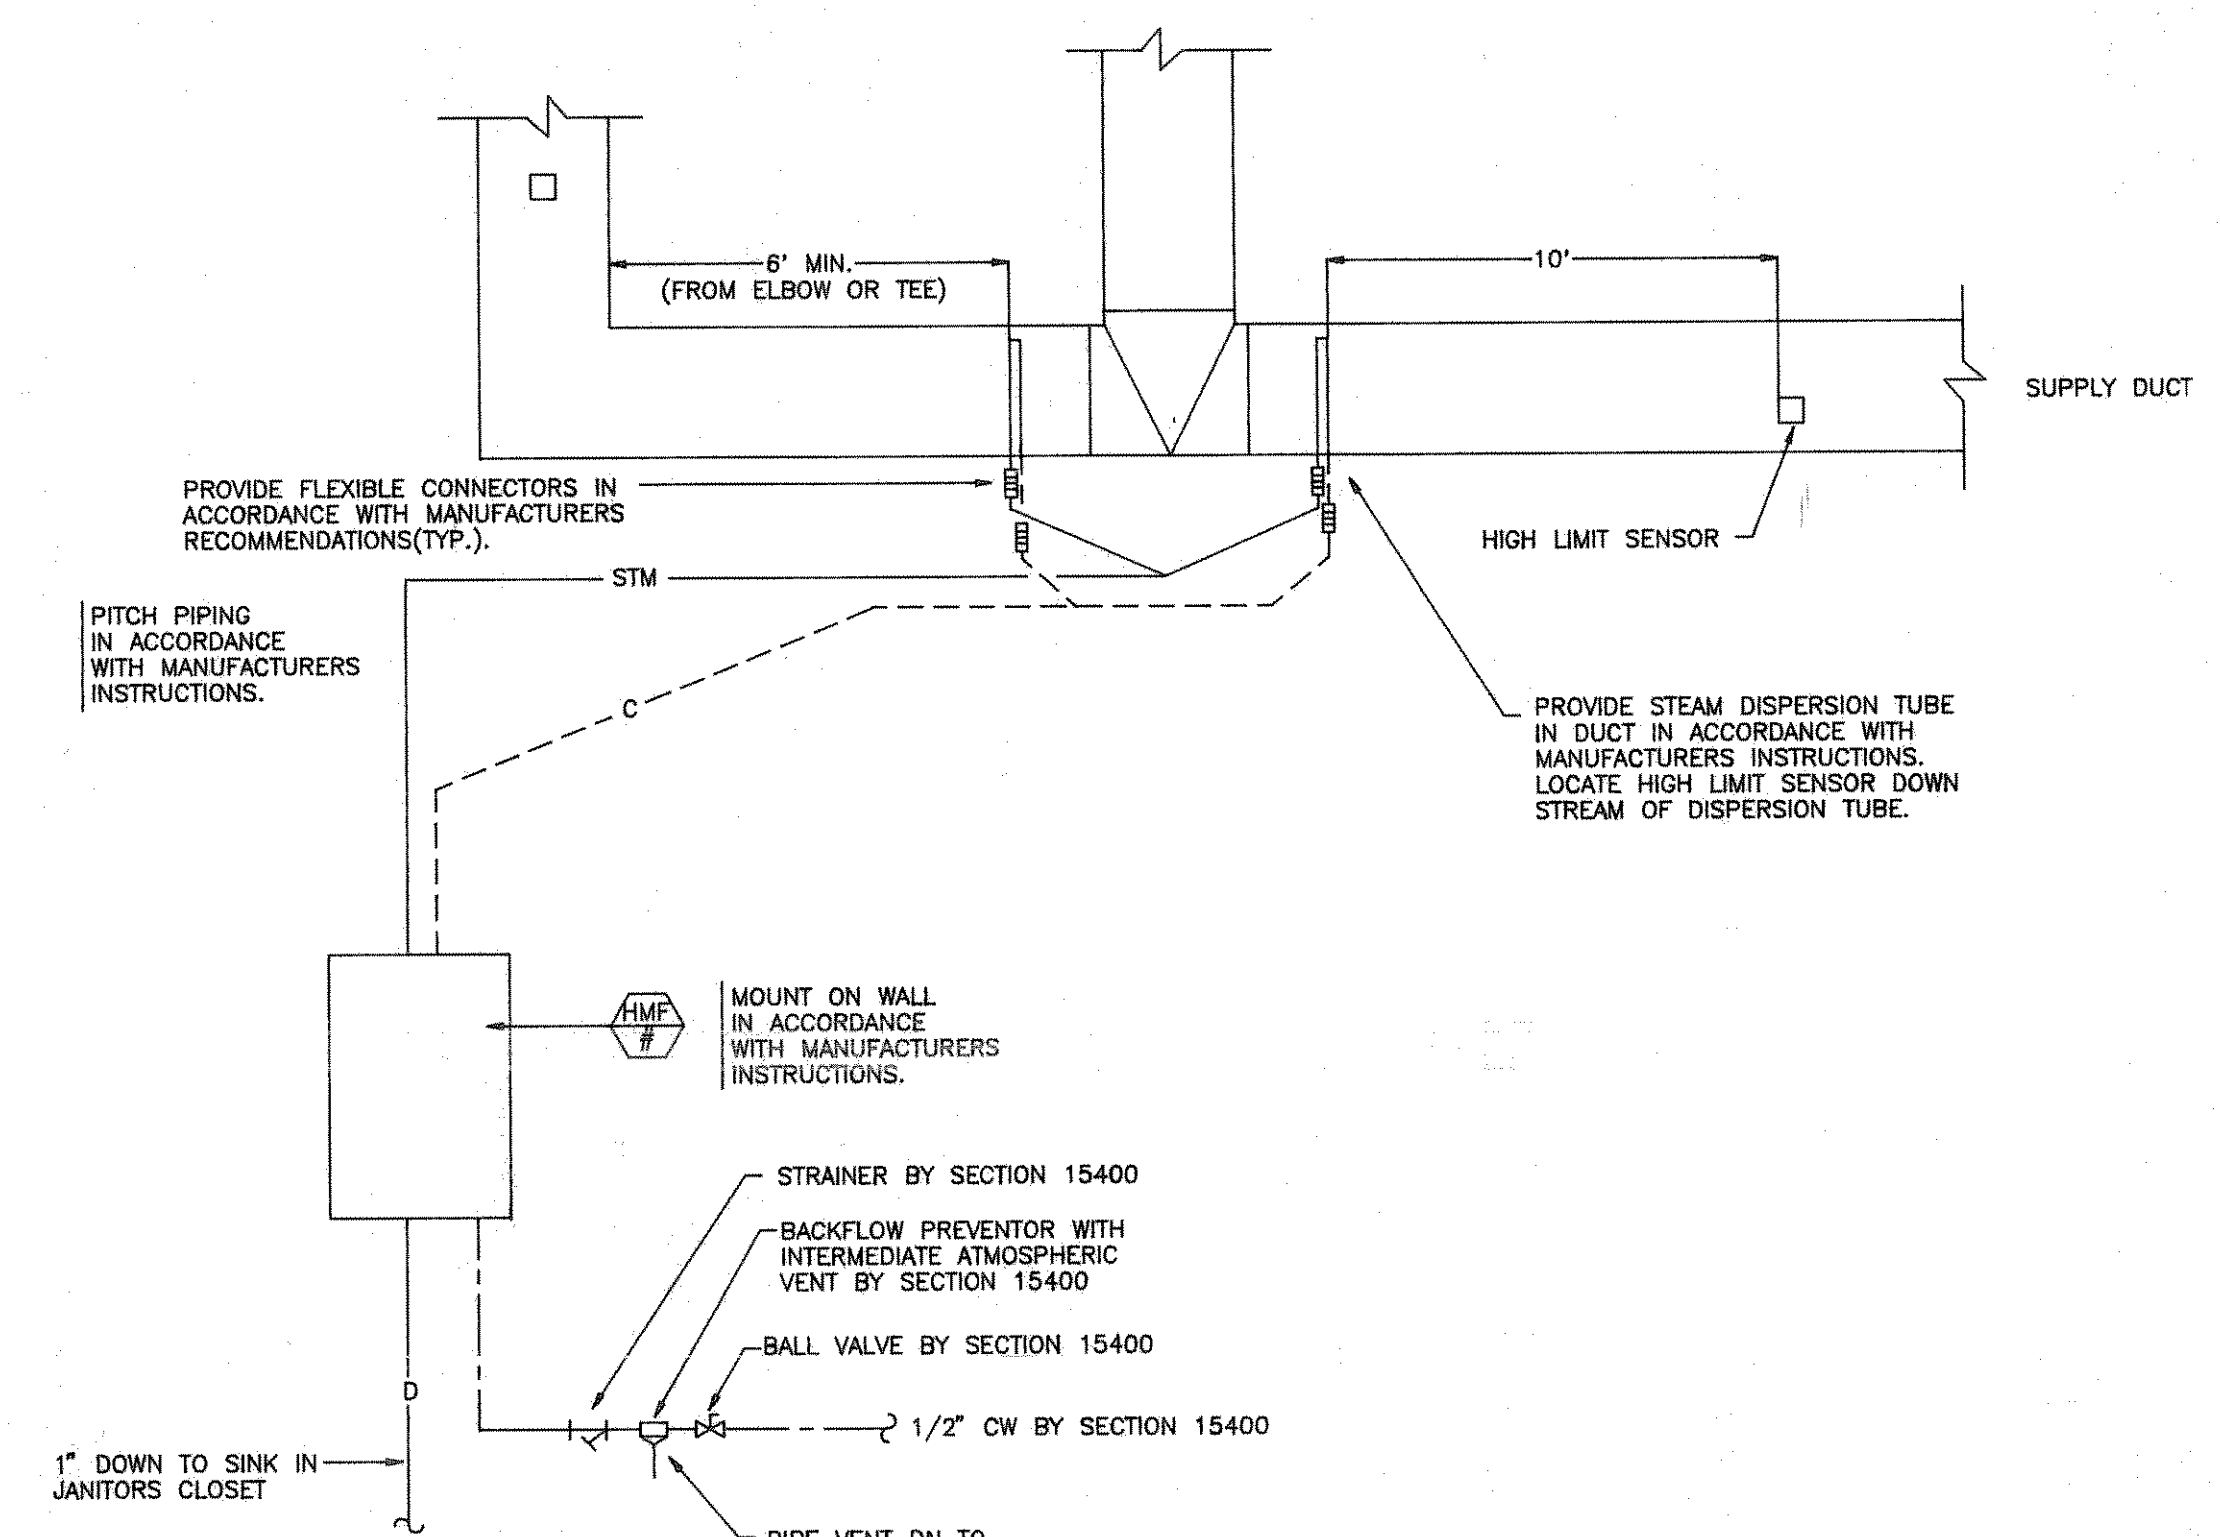



FIRST FLOOR PLAN

1/8" = 1'-0"

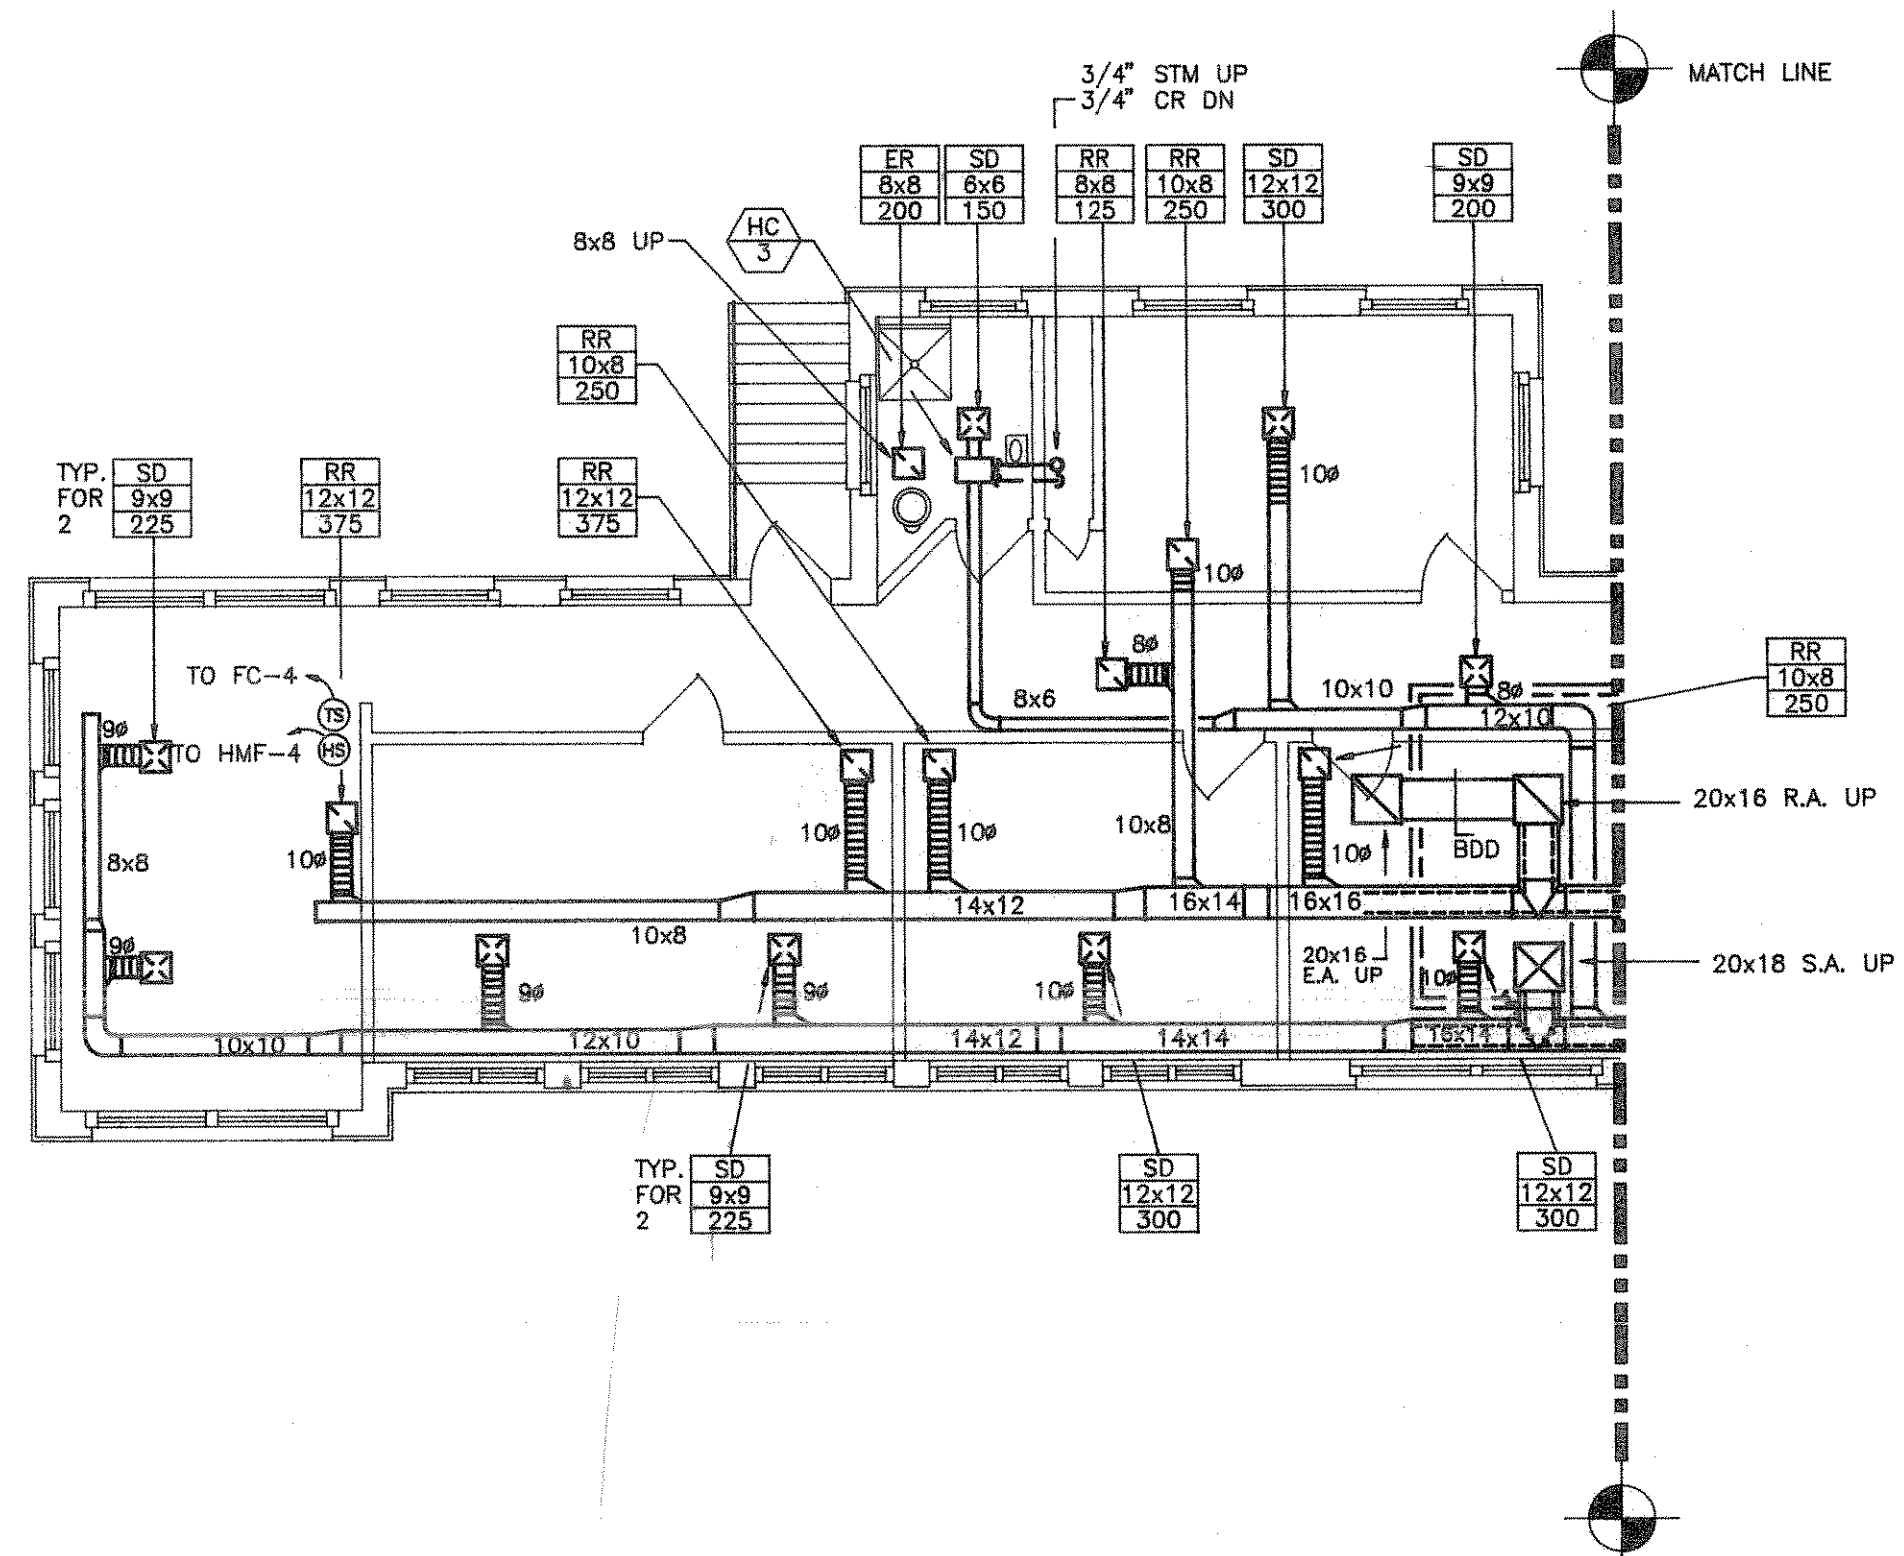

ELECTRIC STEAM HUMIDIFIER DETAIL

N.T.S.

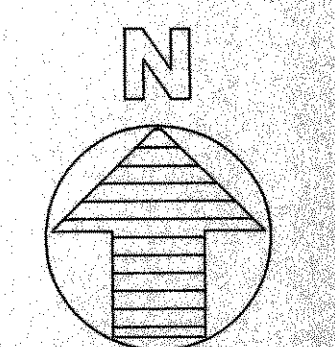

Department of Veterans Affairs
Medical Center
Northampton, MA 01060

INDUSTRIAL HYGIENIST


DENNISON ENVIRONMENTAL
600 West Cummings Park, Suite 6500
Woburn, Massachusetts 01453
(617) 932-9400

ELECTRICAL ENGINEER

SHEPHERD ENGINEERING
1308 Grafton Street
Worcester, Massachusetts 01603
(508) 757-7783

DESIGNER/MECHANICAL ENGINEER

ARA ENGINEERING ASSOCIATES, INC.
171 Main Street, Suite 103
Andover, Massachusetts 01721
(508) 951-7432

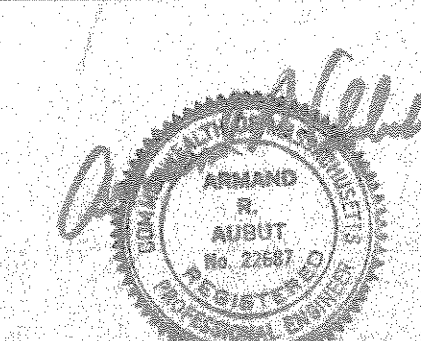

Drawing Title

FIRST FLOOR HVAC PLAN

Approved: Division Chief

Approved: Service Director

Project Title

AIR QUALITY IMPROVEMENTS
WARD 9

Building Number

9

Location

NORTHAMPTON, MASSACHUSETTS

Checked

ARA

Drawn

TGB

Date

07-15-93

Project No.

631-91-105

Drawing No.

59-24
H-2
Dwg. 7 of 12

Veterans
Administration

B9-SP-09

800 THE CORP. NORTH CO.

872 34