




DEPARTMENT OF VETERANS AFFAIRS

JEFFERSON BARRACKS NATIONAL CEMETERY ST. LOUIS, MISSOURI

SEWER RELOCATION Project Number 852-CM3-037



LOCATION MAP

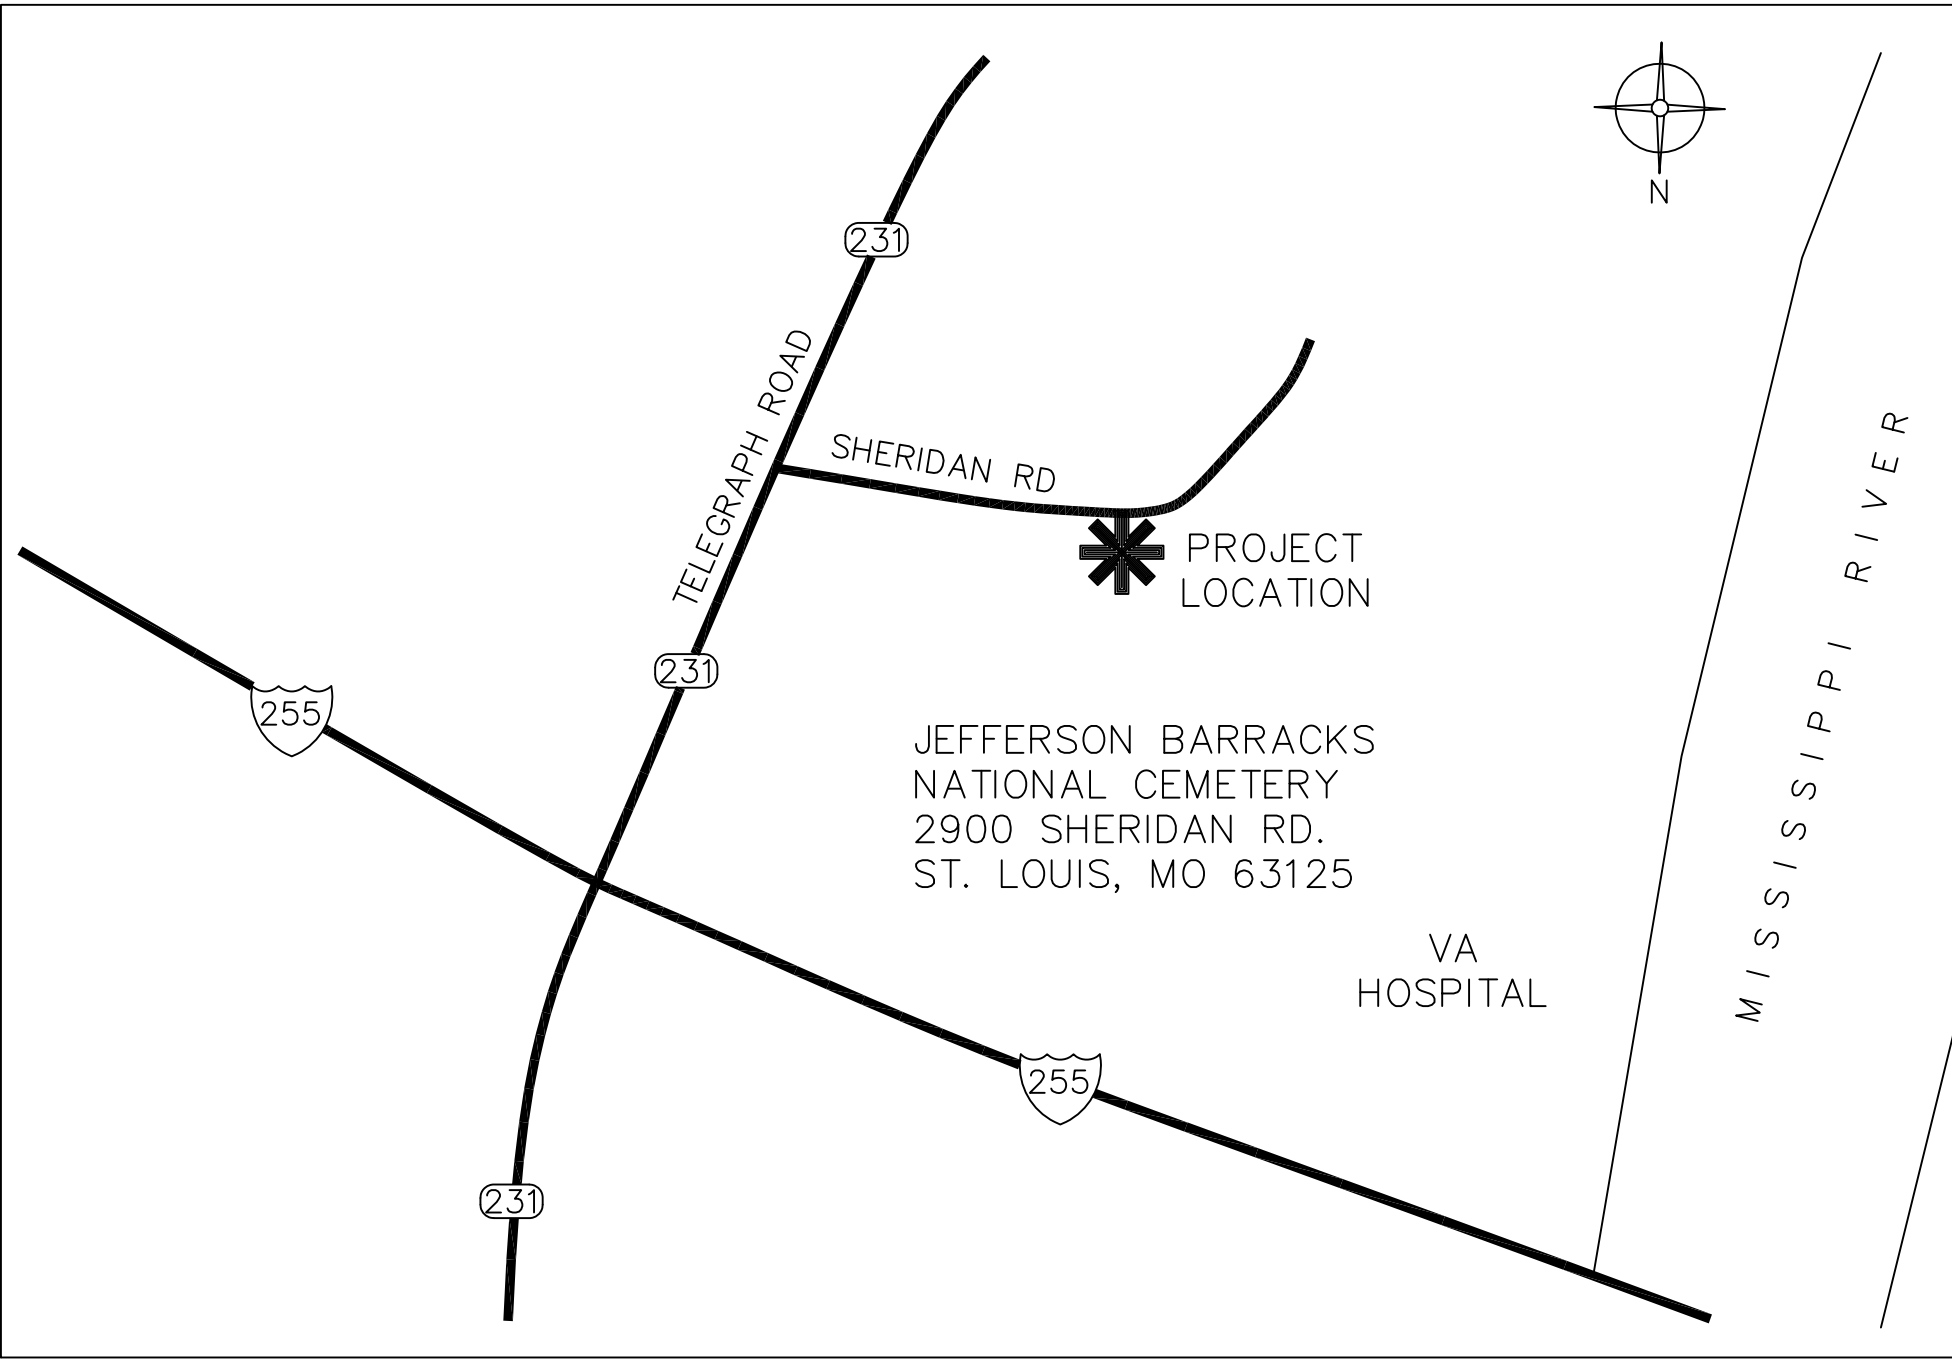

VICINITY MAP

DRAWING INDEX

DWG. NO.	TITLE
X-1	COVER SHEET AND DRAWING INDEX
B-1	EXISTING CONDITIONS
B-2	GEOTECHNICAL BORING LOGS
L-1	SITE PLAN
L-2	OVERALL CONSTRUCTION PHASING PLAN
L-3	CONSTRUCTION PHASING PLAN - PHASE 1
L-4	CONSTRUCTION PHASING PLAN - PHASE 2
L-5	CONSTRUCTION PHASING PLAN - PHASE 3
L-6	DEMOLITION PLAN
L-7	EROSION CONTROL PLAN
L-8	DETAILS
L-9	FENCE & COLUMN REPLACEMENT
L-10	LANDSCAPE PLAN
W-1	PUBLIC SANITARY SEWER PLAN AND PROFILE
W-2	PUBLIC SANITARY SEWER PLAN AND PROFILE
W-3	PRIVATE SANITARY SEWER PLAN AND PROFILE
W-4	SANITARY SEWER DETAILS

PROJECT UTILITY CONTACTS:

AT&T (FIBER OPTIC)

LINDA STAMPEHL
MANAGER - ENG (DES)
LS2082@ATT.COM
(636) 949-1328

LACLEDE GAS COMPANY (NAT. GAS)

JIM YOUNG
JYOUNG@LACLEDEGAS.COM
314-575-4620

ST. LOUIS COUNTY HIGHWAYS & TRAFFIC

JENNIFER E. KRAMER, P.E.
PLAN REVIEW SUPERVISOR
41 S. CENTRAL AVE, 5TH FLOOR
CLAYTON, MO 63105
(314) 615-8548
JEKRAMER@STLOUISCO.MO

METROPOLITAN ST. LOUIS SEWER DISTRICT (MSD)

JOHN ALEXANDER
SUPERVISOR OF ENGINEERING
2350 MARKET STREET
ST. LOUIS, MO 63103-2555
(314) 768-2707

CALL 48 HOURS BEFORE DIGGING
Utilities Underground Location Center
DIAL 811
811
Know what's below.
Call before you dig.

CONSULTANTS:		ARCHITECT/ENGINEERS:		Drawing Title		Project Title		Project Number		Office of Construction and Facilities Management		
		I HEREBY CERTIFY THAT THIS DESIGN, SPECIFICATION, OR REPORT WAS PREPARED BY ME OR UNDER MY DIRECT SUPERVISION AND THAT I AM A DULY LICENSED PROFESSIONAL ENGINEER UNDER THE LAWS OF THE STATE OF MISSOURI. PRINT NAME: GARY R. JOHNSON, P.E. SIGNATURE: [Signature] DATE: March 28, 2016 P.E. 2012005390		Anderson Engineering of Minnesota, LLC 13605 1st Avenue North Suite 100 Plymouth, MN 55441 763-412-4000 (o) 763-412-4090 (f) www.ae-mn.com		COVER SHEET AND DRAWING INDEX		SEWER RELOCATION		852CM3037		Department of Veterans Affairs
				Approved Project Director		Location ST. LOUIS, MO		Drawing Reference Number		Drawing Number		
						Date 3-28-16		Checked AMT		Drawn PSH		
Revisions:		Date								X-1 Dwg. 1 OF 17		