
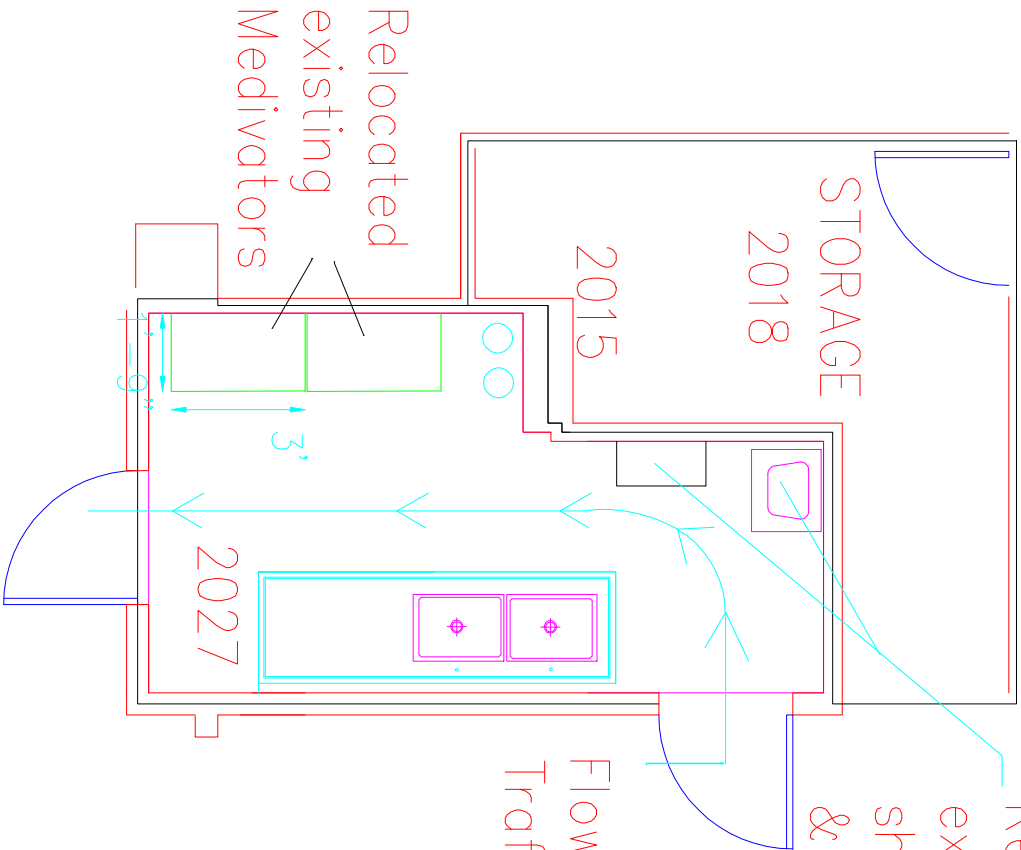


EXISTING

PROPOSED

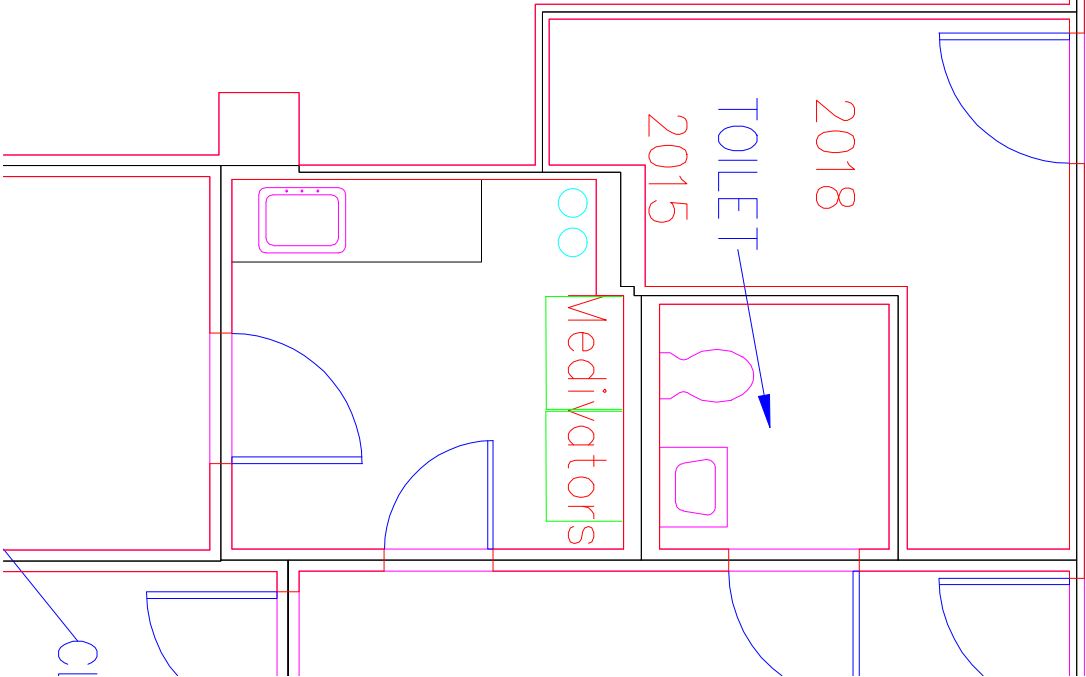

Scale
3/4"=1'-0"

Relocated
existing
shelves
& sink.

Flow of
Traffic

- LEGEND
- Stainless Steel Worktable w/ Stainless Tubular Legs with adjustable Leveling Feet
 - Sinks (see Scope Of Work for specs)
 - Mediators (2) are 46"H x 36"W x 21"D
 - Existing plumbing

Revisions	Date

--

Professional Seal

FACILITIES MANAGEMENT SERVICE

Drawing Title
SECOND FLOOR PLAN
ARCHITECTURAL
Approved:
Approved:

Project Title
RENOVATE ENDOSCOPY
CLEANING ROOM
Building Number
01
Checked
CJ
Drawn
Location
VAMC FAYETTEVILLE, NC

Date
Nov 4, 2011
Project No.
365-12-201
Drawing No.
1 of 1

