



VETERANS ADMINISTRATION

NORTH TEXAS HEALTH CARE SYSTEM

SAM RAYBURN MEDICAL CENTER


1201 EAST NINTH STREET, BONHAM, TEXAS 75418

Building 2 Electrical Upgrade

VANTHCS PROJECT NO.: 549A4-11-102
FEI Project Number: 11019.01
MPI Project Number: 6110402

100% CONSTRUCTION ISSUE

Issue Date: 10/27/14

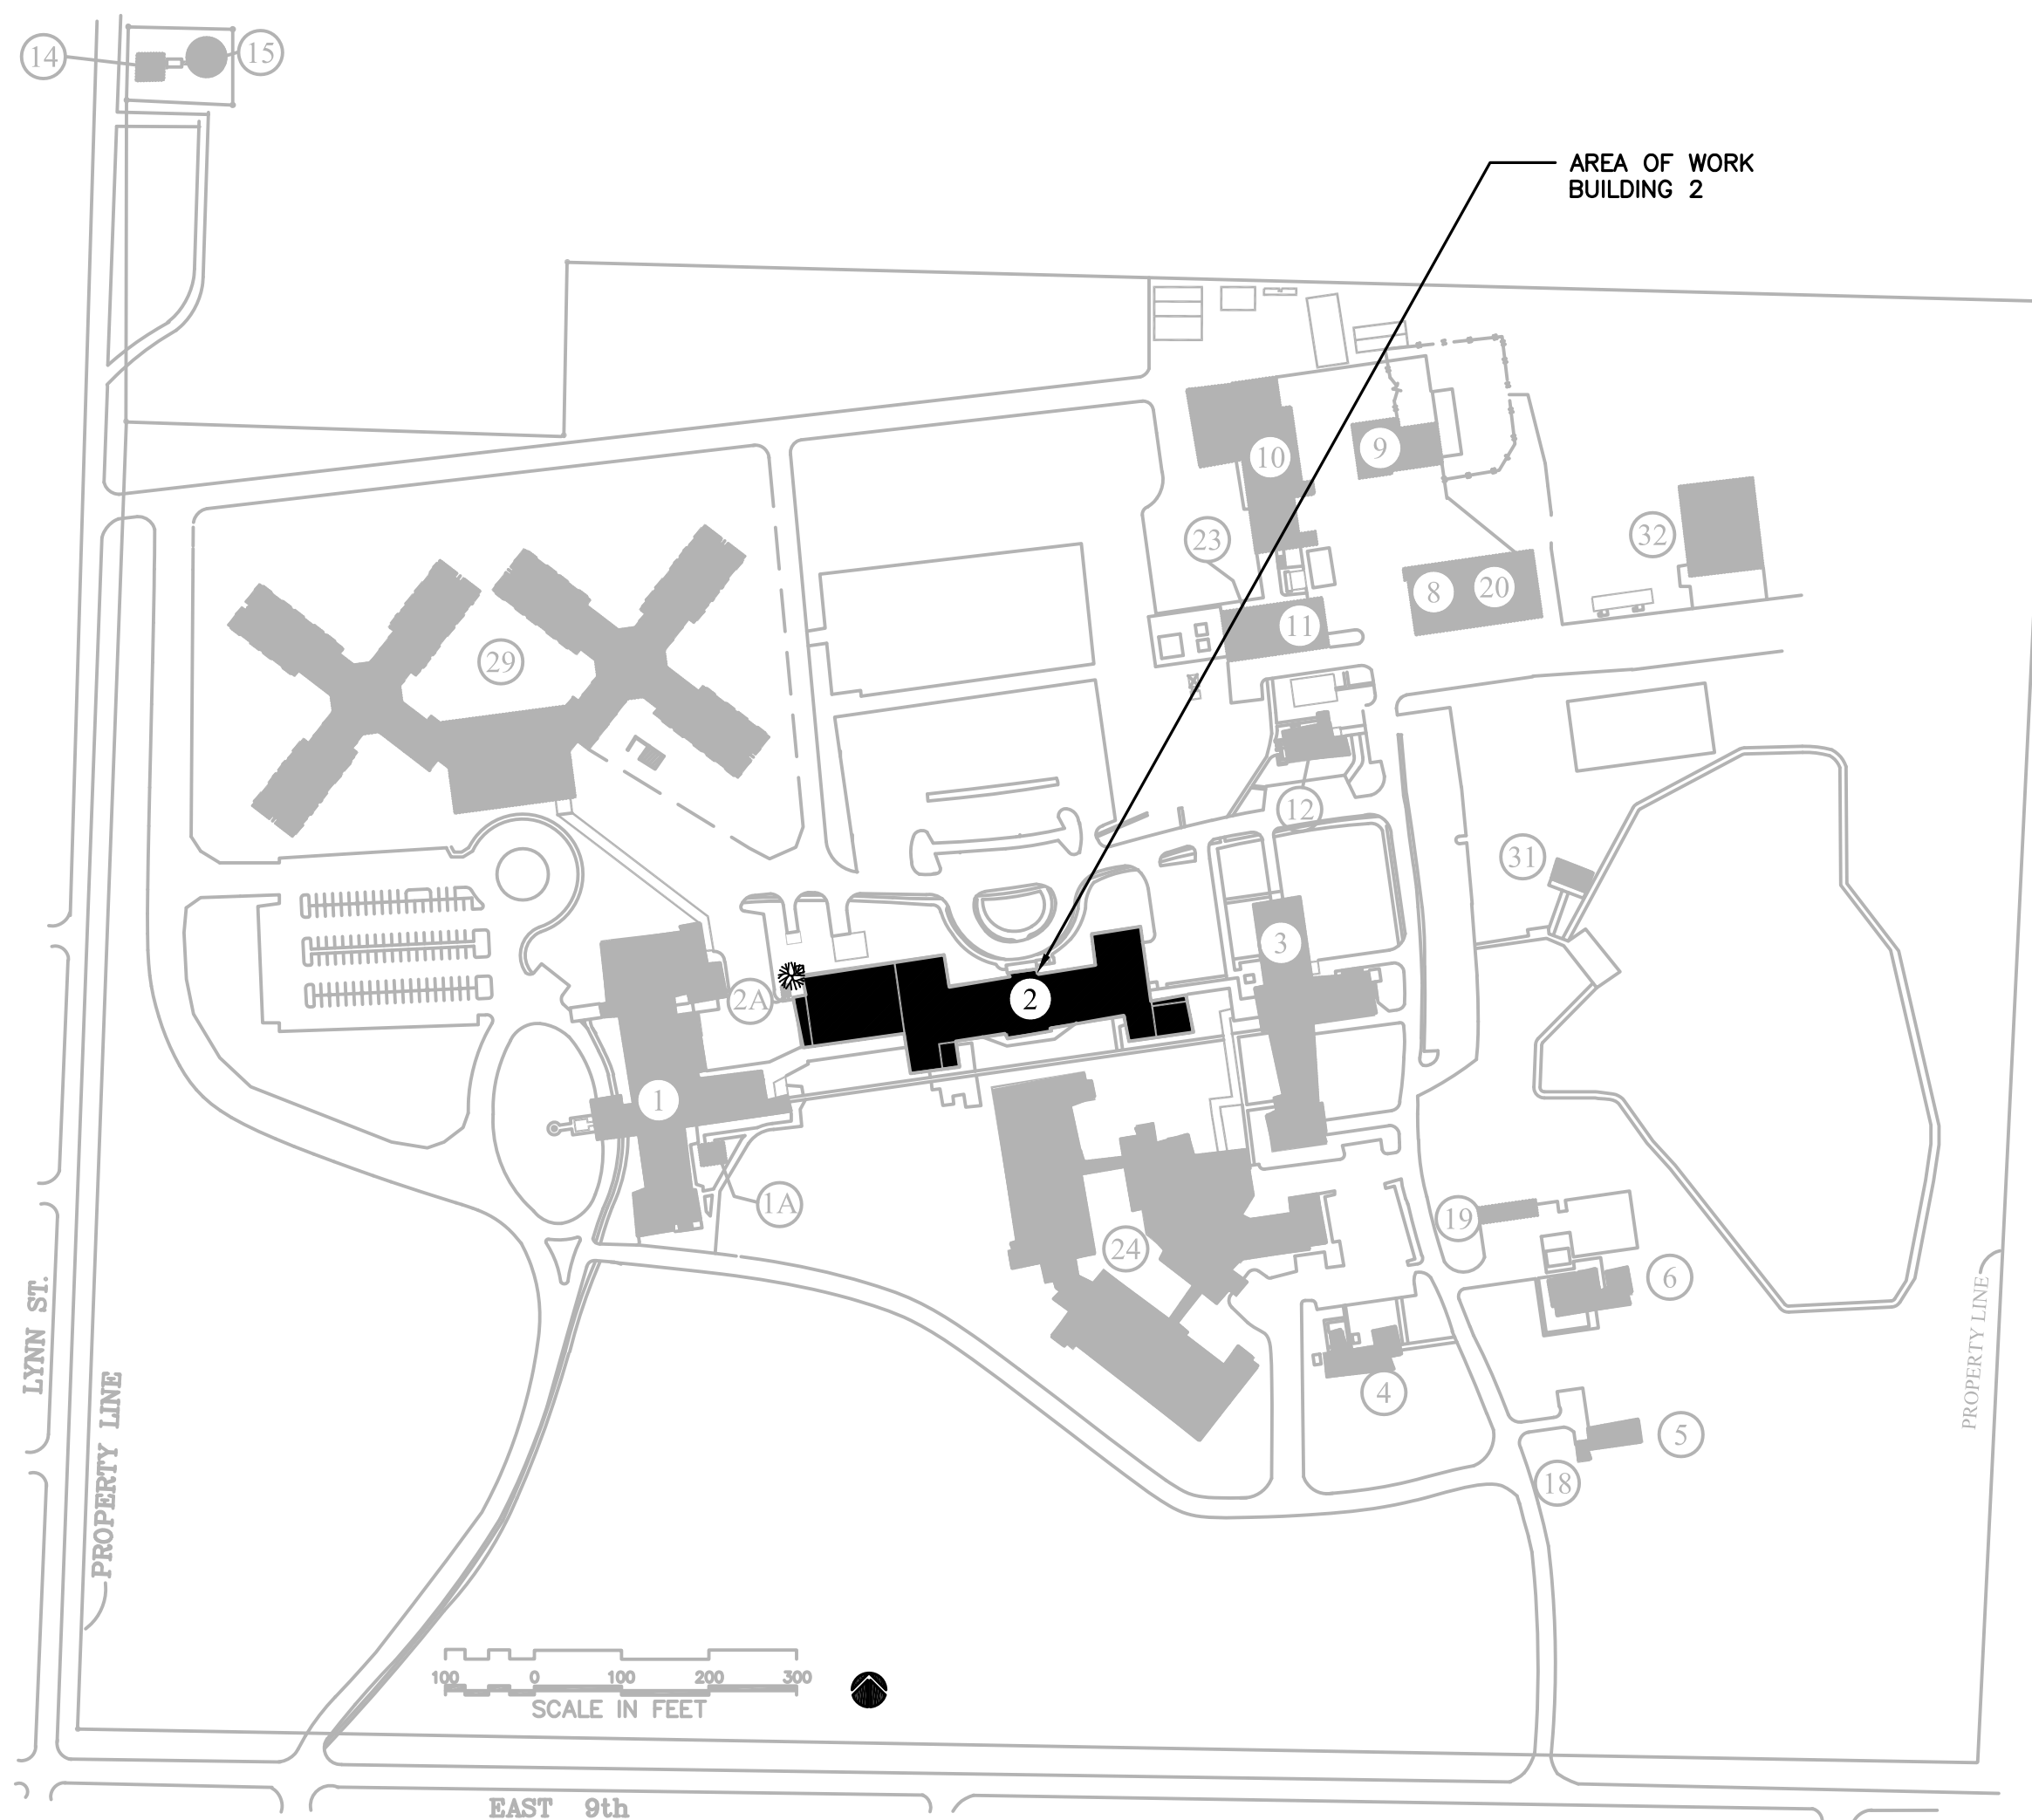

NO.	BUILDING SCHEDULE
1	HOSPITAL AND ADMINISTRATION
1A	EMERGENCY GENERATOR
2	DOMICILIARY-HCU-DIETETICS-CHAPEL
2A	EMERGENCY GENERATOR
3	RECREATION-CANTEN-RETAIL STORE-LIBRARY
4	HUMAN RESOURCES - MENTAL HYGIENE
5	DOCTOR'S QUARTERS
6	SUPPLY - CREDIT UNION - FISCAL
7	EQUIPMENT ROOM
8	MAINTENANCE SHOP
9	ENGINEERING OFFICES AND GARAGES
10	ENVIR. MGMT. SVC., LAUNDRY & WAREHOUSE
11	BOILER PLANT
12	MENTAL HYGIENE CLINIC
13	FLAG POLE
14	PUMP HOUSE
15	WATER TOWER
17	GROUND MATERIAL STORAGE
17A	DOCTOR'S QUARTERS GARAGE
17B	STORAGE
19	STORAGE
20	MAINTENANCE STORAGE
22	GREENHOUSE
23	CHILLER PLANT / EMERGENCY GENERATOR
24	NEW DOMICILIARY
25	INCINERATOR
26	EMERGENCY GENERATOR
27	EMERGENCY GENERATOR
28	EMERGENCY GENERATOR
29	NEW NURSING HOME CARE UNIT
31	PARK TOILET
32	MORTON STORAGE BUILDING
GP	GAS PUMP
GT	GAS TANKS
ST	STORAGE

Index of Drawings:

G001 COVER SHEET

Architectural

A101 KEY PLANS BASEMENT LEVEL THRU FOURTH FLOOR
A102 FLOOR PLANS DEMOLITION AND NEW WORK BASEMENT THRU FOURTH FLOOR
A201 INTERIOR ELEVATIONS, SCHEDULES AND DETAILS

Fire Protection


FP101 FLOOR PLANS FIRE PROTECTION SECOND THRU FOURTH FLOORS

Electrical

E001 ELECTRICAL GENERAL NOTES AND SCHEDULES
E002 SITE PLAN - ELECTRICAL
E003 SITE PLAN - UTILITY
E100 FLOOR PLAN - BASEMENT FLOOR ELECTRICAL DEMOLITION
E200 FLOOR PLAN - BASEMENT FLOOR ELECTRICAL
E201A FLOOR PLAN EAST - FIRST FLOOR ELECTRICAL
E201B FLOOR PLAN WEST - FIRST FLOOR ELECTRICAL
E202 FLOOR PLAN - SECOND FLOOR ELECTRICAL
E203 FLOOR PLAN - THIRD FLOOR ELECTRICAL
E204 FLOOR PLAN - FOURTH FLOOR ELECTRICAL
E300 ELECTRICAL RISER DIAGRAM EXISTING
E301 ELECTRICAL RISER DIAGRAM



ARCHITECTS

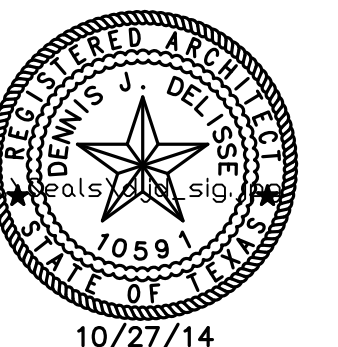

COKER ENGINEERING LLC

FIRE PROTECTION ENGINEER



2201 N. Collins, Suite 205
Addicks, Texas 75001-0008
(817) 461-2337 Fax: (817) 461-1005
F-1166

MECHANICAL / ELECTRICAL
ENGINEERS

SHEET NO. - G001

BUILDING 2 ELECTRICAL UPGRADE

BUILDING 2 ELECTRICAL UPGRADE