


- GENERAL NOTES:**
1. REFER TO SHEET E001 FOR GENERAL NOTES AND SYMBOL LEGEND.
 2. THIS PLAN IS INCLUDED FOR REFERENCE ONLY AND IS BASED ON "AS-BUILT" DOCUMENTATION. LINE LOCATIONS SHOWN MAY NOT BE 100% ACCURATE AND CARE SHOULD BE TAKEN WITH ANY EXCAVATION WORK.

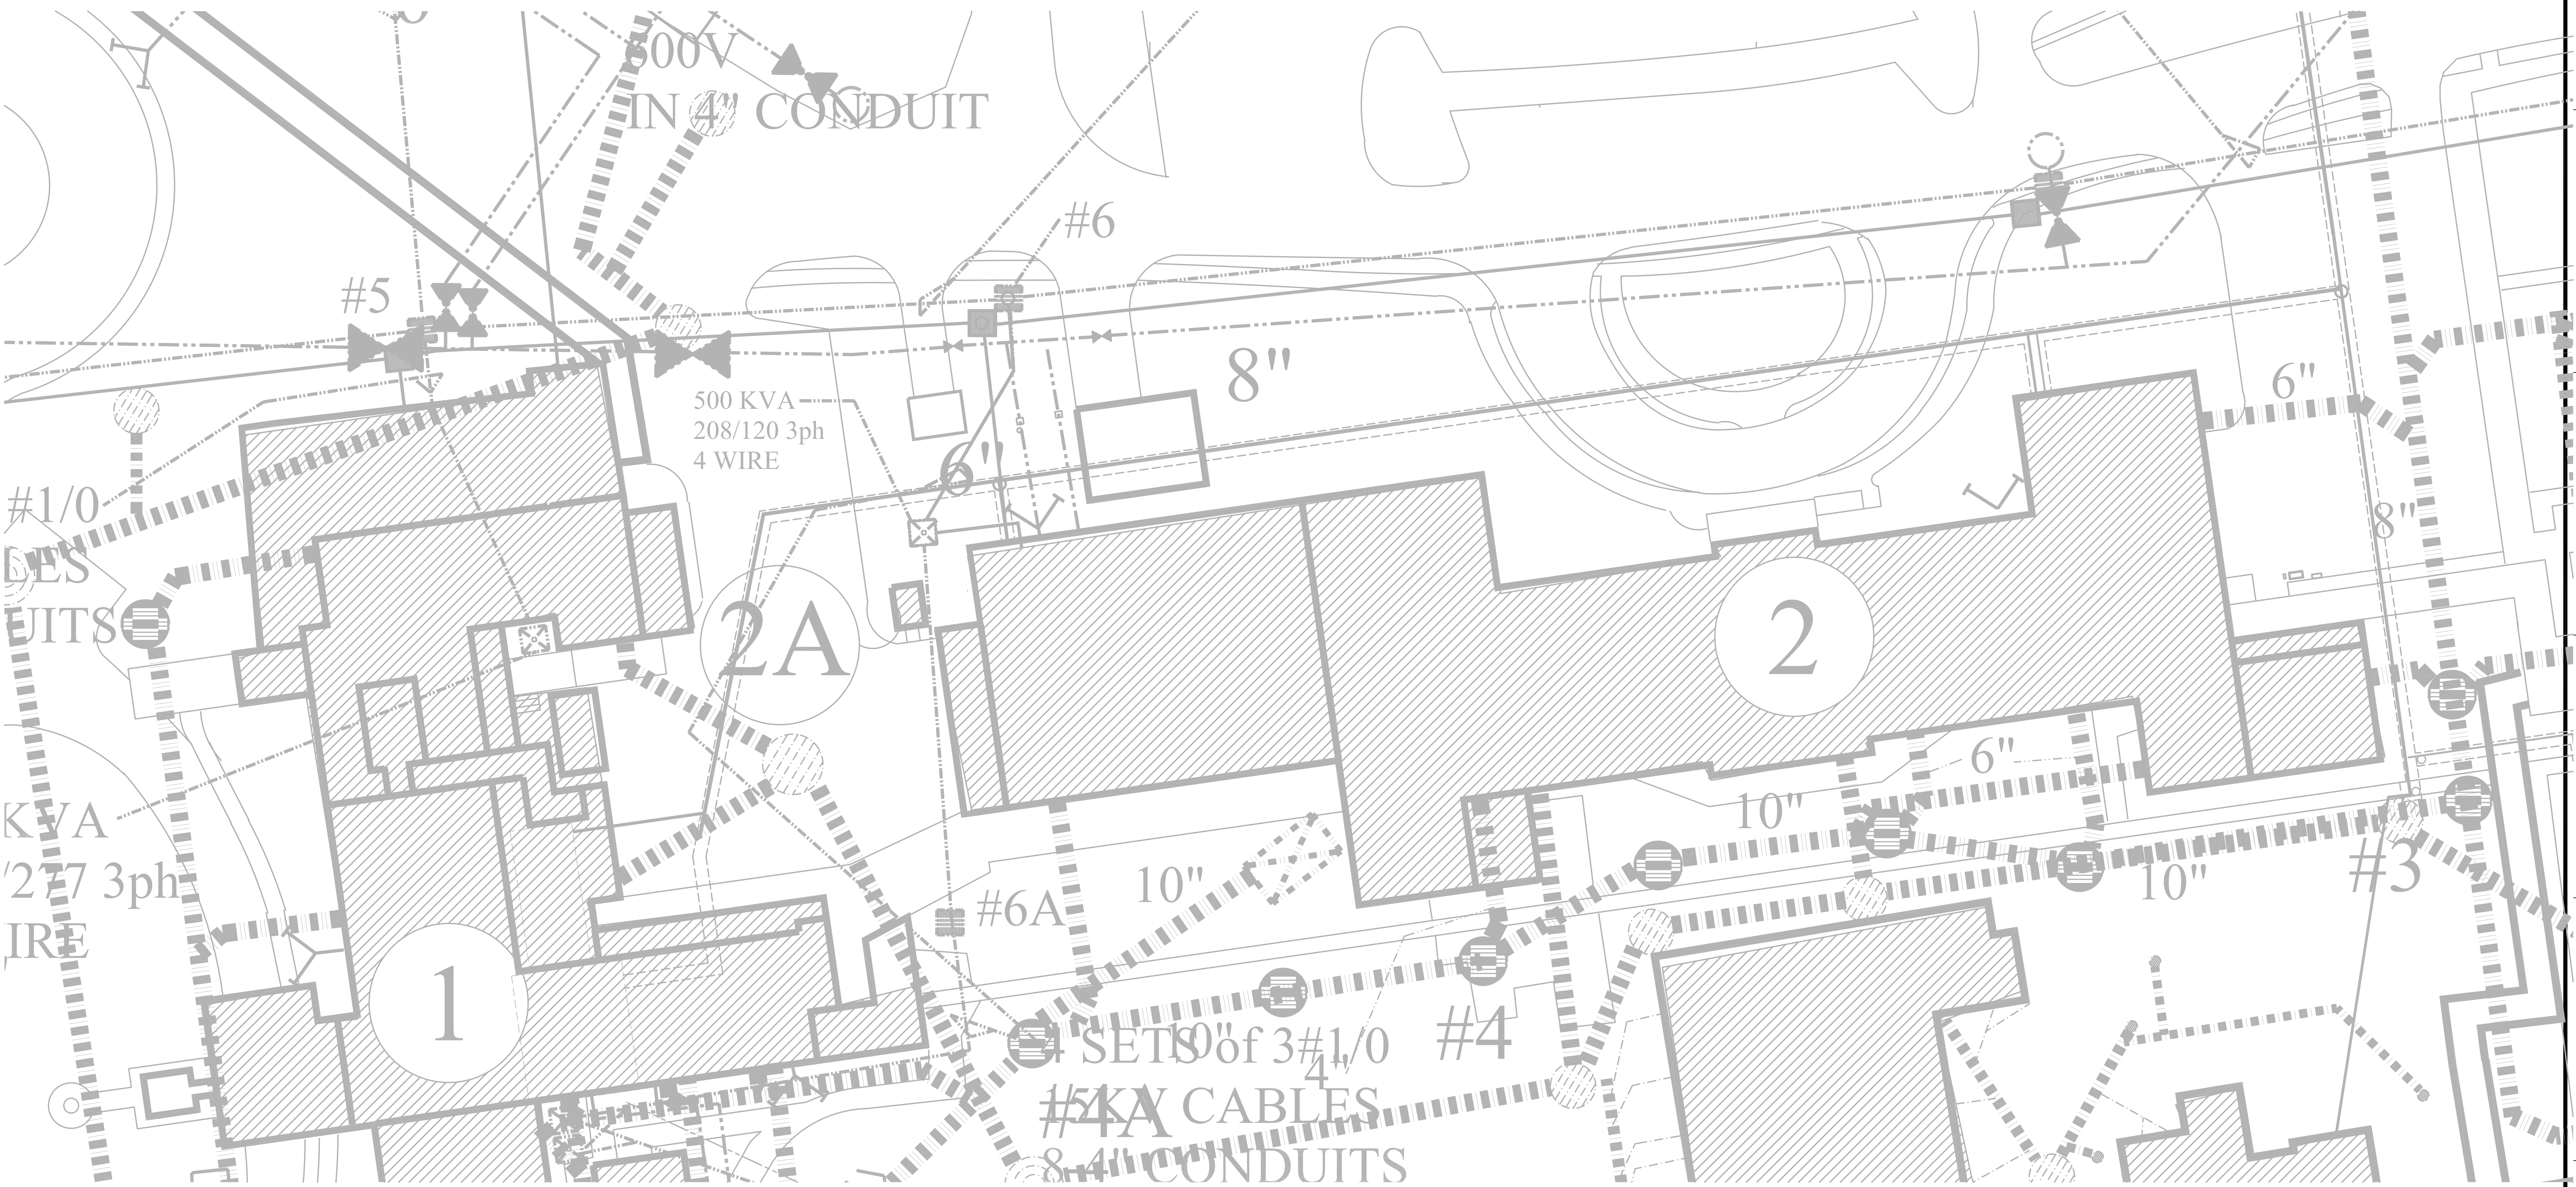

E003 UTILITY PLAN
SCALE: 1"=20'-0"

100% CONSTRUCTION ISSUE

<div>Computer Filename:</div> <table><tr><td> </td><td> </td></tr><tr><td> </td><td> </td></tr><tr><td> </td><td> </td></tr><tr><td> </td><td> </td></tr><tr><td>Revisions</td><td>Date</td></tr></table>									Revisions	Date	<div><div>2201 N Collins, Suite 200 Arlington, Texas 76011-2699 (817) 461-0333 Fax: (817) 461-1025 © 1999 MECHANICAL • ELECTRICAL • PLUMBING</div><div>FEI Project No.: 11019.01</div></div>	<div><div>Architecture ■ Planning ■ Interior Design 4949 Addison Circle ■ Addison, Texas 75001</div><div>MPI Project No.: 6110402</div></div>	<div>Seal</div> <div></div> <div>Seal</div>	<div>Drawing Title</div> <div>SITE PLAN – UTILITY PLAN</div> <div>Approved: Area Project Manager</div>	<div>Project Title</div> <div>V.A. BONHAM, TX BUILDING 2 ELECTRICAL UPGRADES</div> <div>Building Number</div> <div>2</div> <div>Location</div> <div>1201 East Ninth Street Bonham, Texas 75418</div>	<div>Date</div> <div>10/27/14</div> <div>Project No.</div> <div>549A4-11-102</div> <div>Drawing No.</div> <div>E003</div> <div>Dwg. of</div>	<div><div>VANTHCS Dallas, Texas</div></div>
Revisions	Date																