



GENERAL NOTES:


- REFER TO SHEET E001 FOR GENERAL NOTES AND SYMBOL LEGEND.
- ITEMS SHOWN AS HALF TONE DASHED ARE EXISTING TO REMAIN.
- REFER TO RISER DIAGRAMS FOR ADDITIONAL INFORMATION.

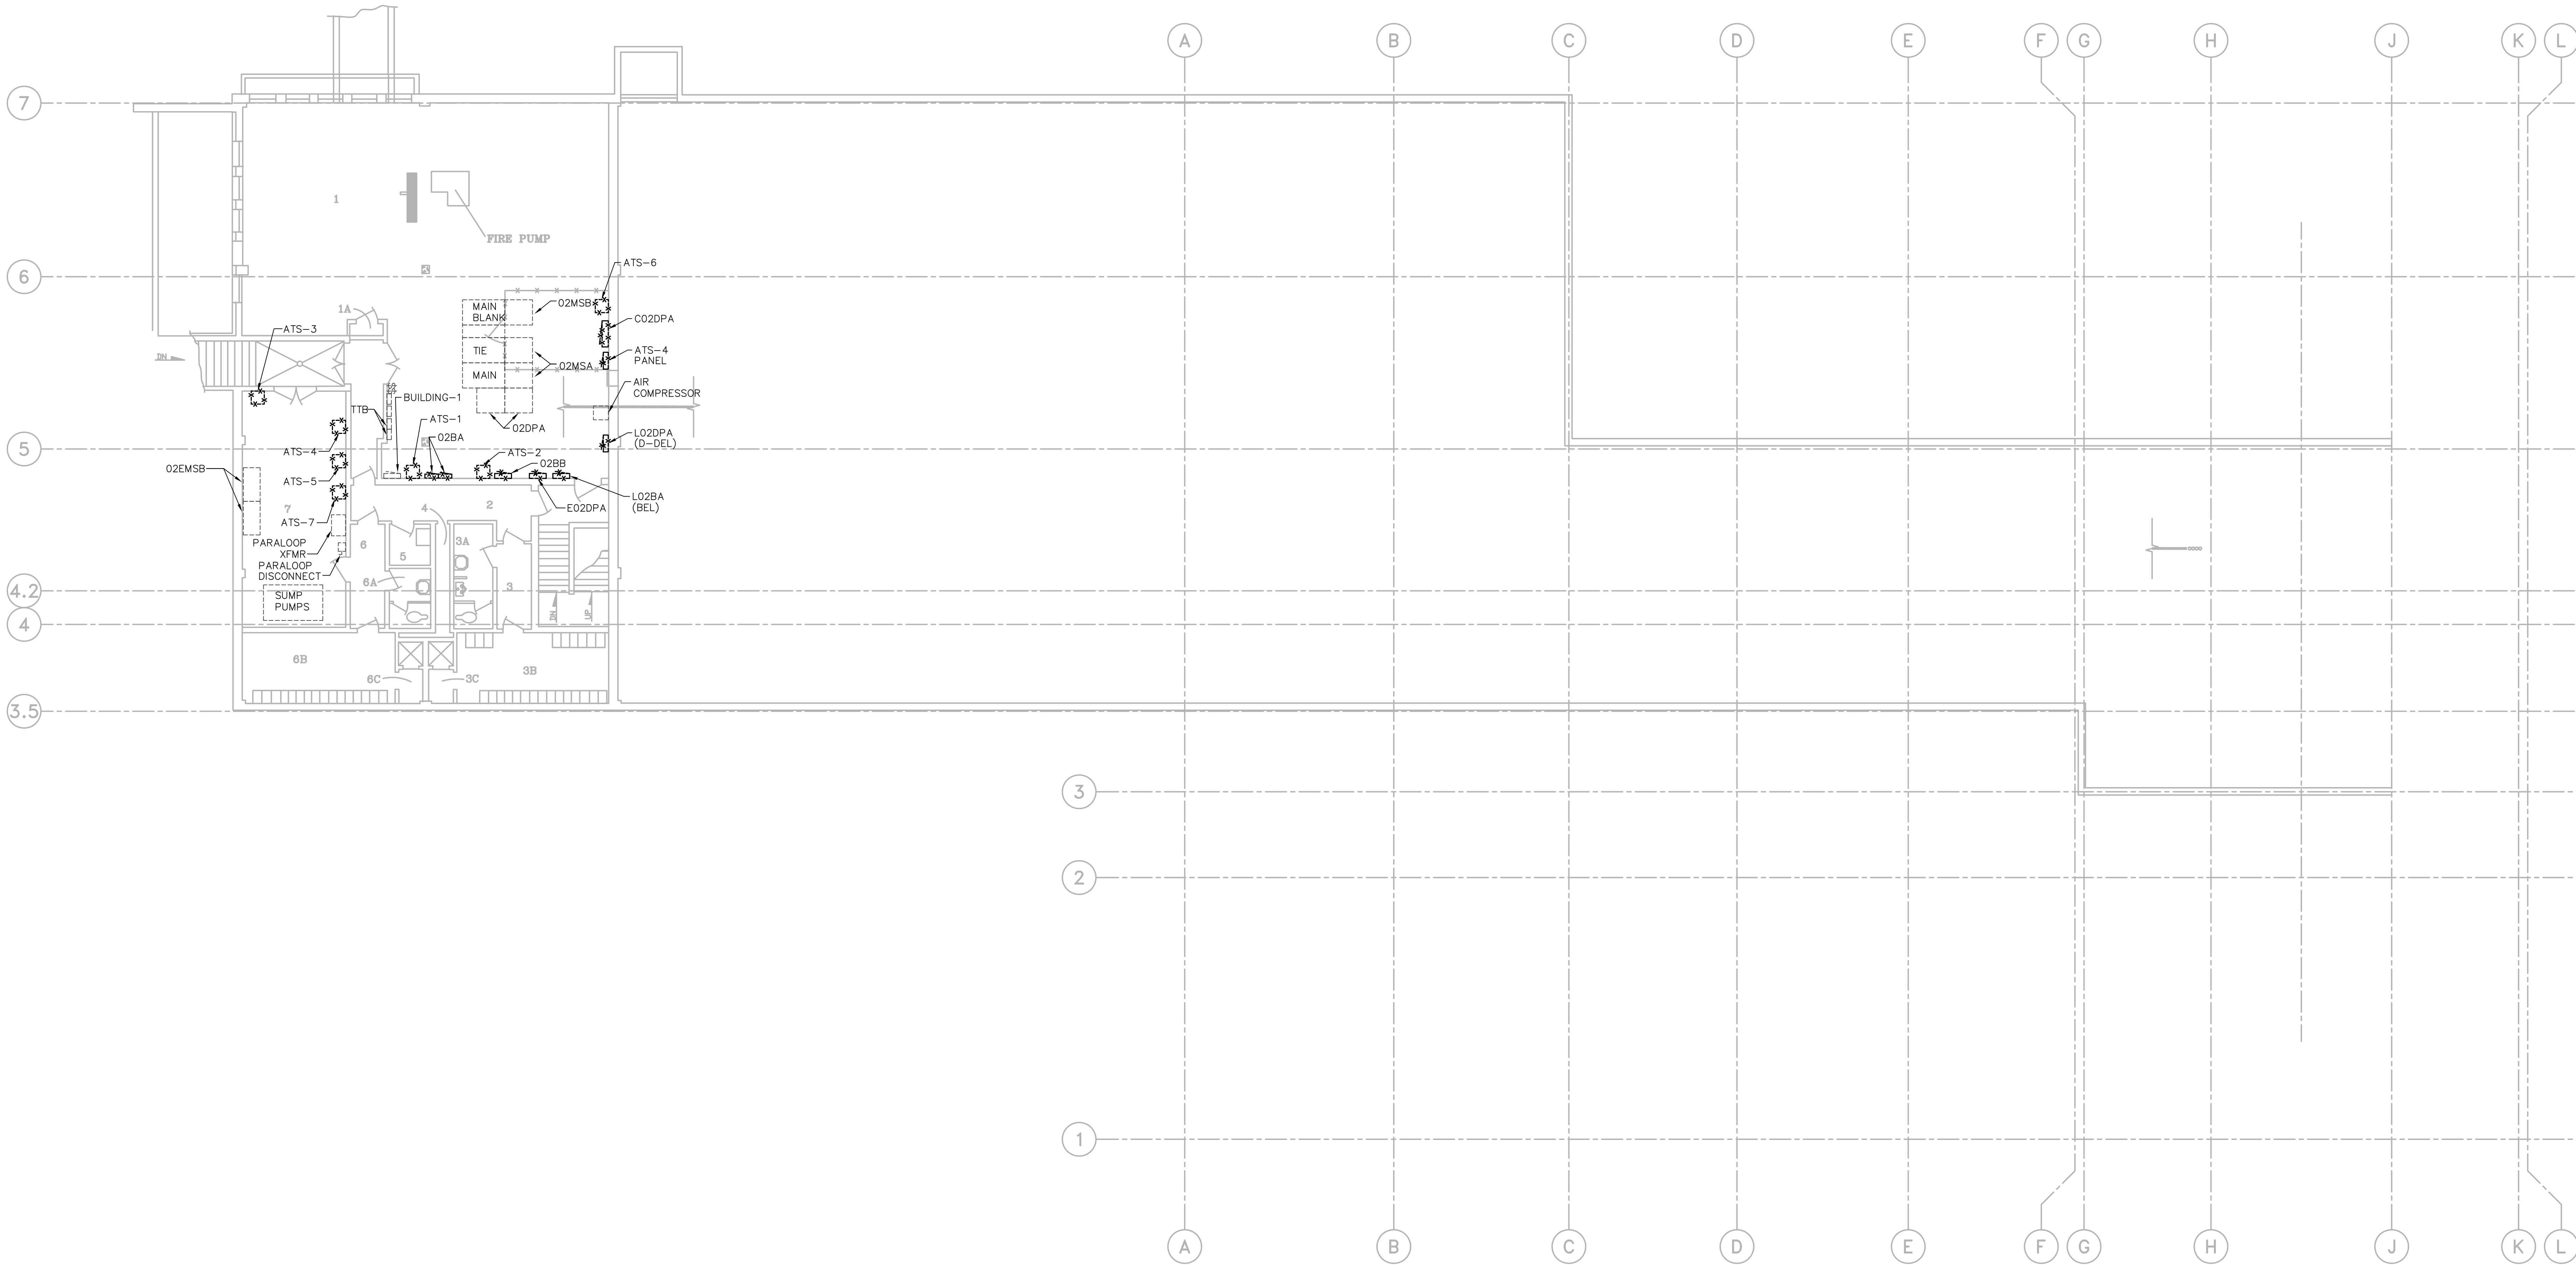

E100 FLOOR PLAN – BASEMENT FLOOR ELECTRICAL DEMOLITION
SCALE: 1/8"=1'-0"

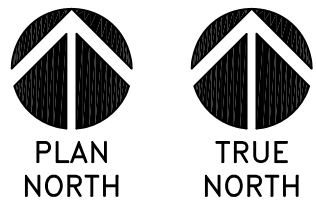


Revisions	Date



2201 N Collins, Suite 200
Arlington, Texas 76011-2600
(817) 461-0333 Fax: (817) 461-1025
E: info@fratoeng.com
MECHANICAL • ELECTRICAL • PLUMBING


FEI Project No.: 11019.01



Architecture ■ Planning ■ Interior Design
4949 Addison Circle ■ Addison, Texas 75001

MPI Project No.: 6110402

Seal



10-27-2014

Seal

Seal

Seal

Drawing Title
FLOOR PLAN – BASEMENT FLOOR ELECTRICAL DEMOLITION

Approved: Area Project Manager

Project Title
V.A. BONHAM, TX BUILDING 2 ELECTRICAL UPGRADES

Building Number
2

Location
1201 East Ninth Street
Bonham, Texas 75418

Date
10/27/14

Project No.
549A4-11-102

Drawing No.
E100

Dwg. of



VA
NORTH TEXAS
HEALTH CARE
SYSTEM

VANTHCS
Dallas, Texas

100% CONSTRUCTION ISSUE