



GENERAL NOTES:	NOTES BY SYMBOL: "□"
1. REFER TO SHEET E001 FOR GENERAL NOTES AND SYMBOL LEGEND. 2. REFER TO RISER DIAGRAMS FOR ADDITIONAL INFORMATION.	1. ROUTE CONDUCTORS FOR BUS RISERS FROM THE BASEMENT VIA CRAWLS SPACE TO THIS CHASE PROVIDED BY ARCHITECTURAL UP TO SECOND FLOOR START OF BUS RISERS. 2. REPLACE PANELBOARD IN PLACE. REFER TO RISER DIAGRAMS FOR ADDITIONAL INFORMATION.


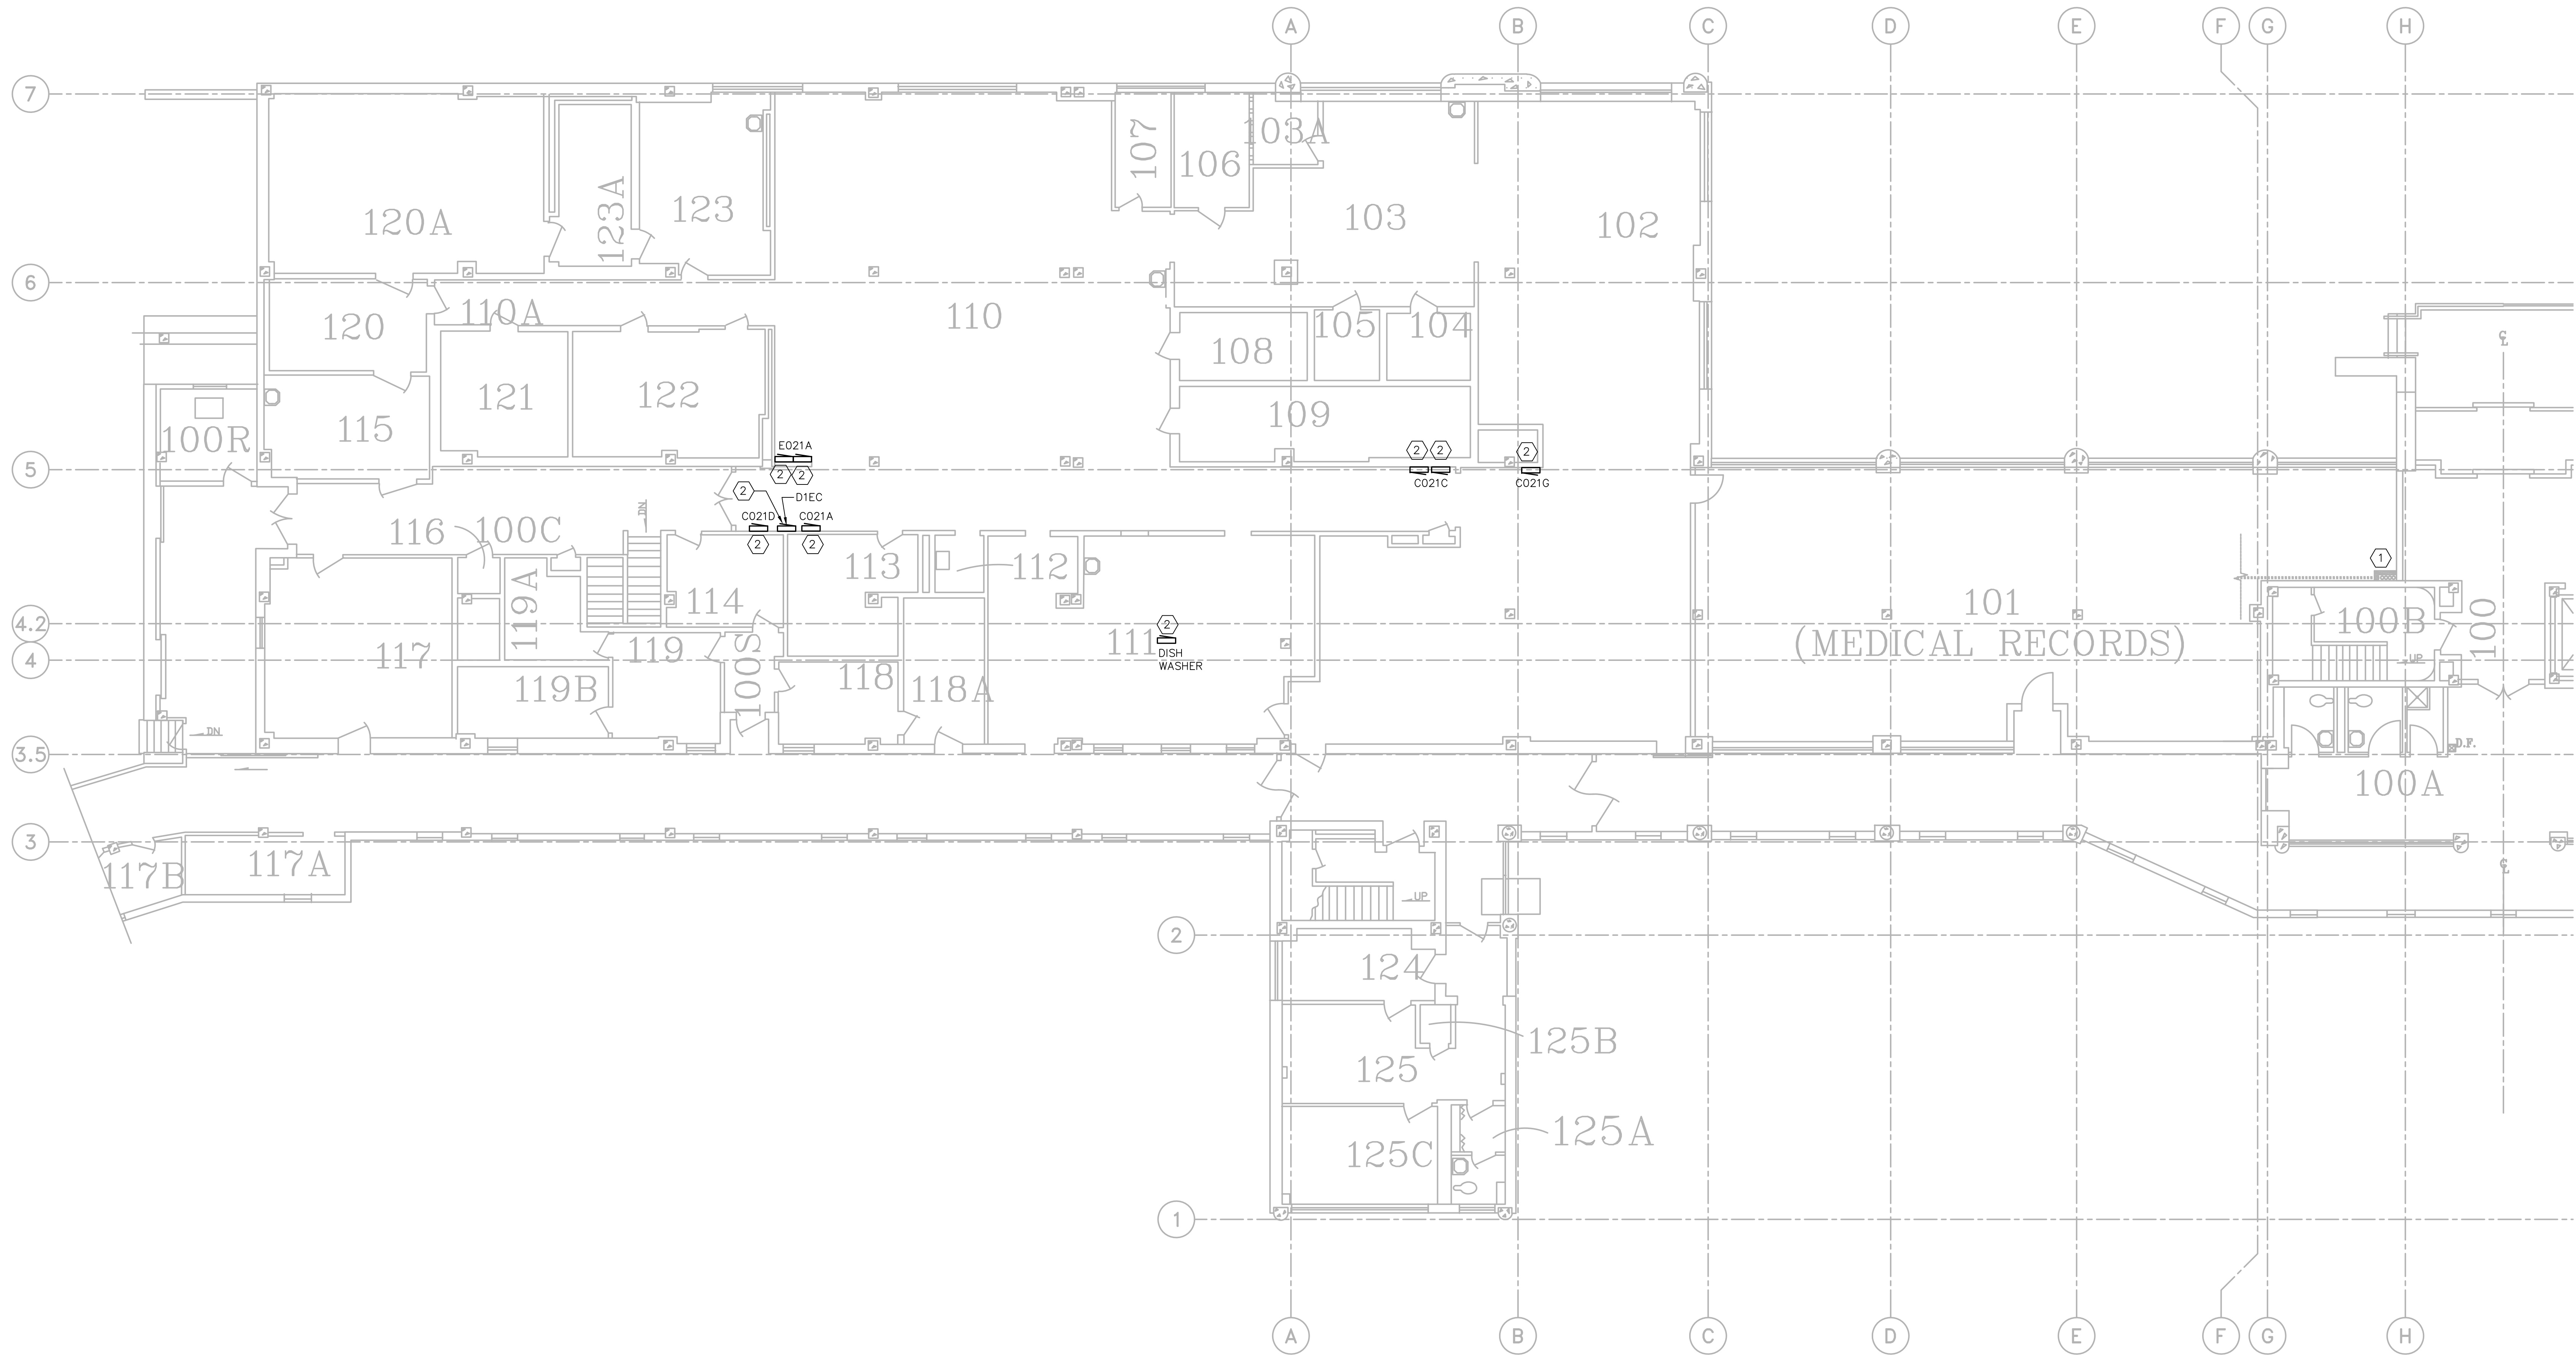


E201 FLOOR PLAN WEST- FIRST FLOOR ELECTRICAL
SCALE: 1/8"=1'-0"

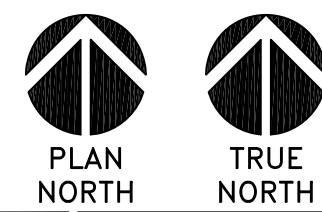

2201 N Collins, Suite 200
Arlington, Texas 76011-2600
(817) 461-0333 Fax: (817) 461-1025
MECHANICAL • ELECTRICAL • PLUMBING
FEI Project No.: 11019.01

MPI Architects
Architecture ■ Planning ■ Interior Design
4949 Addison Circle ■ Addison, Texas 75001
MPI Project No.: 6110402

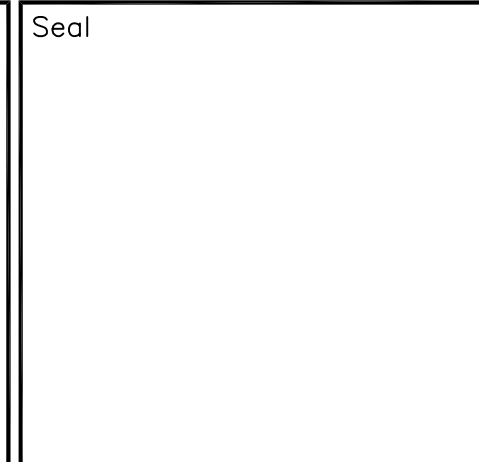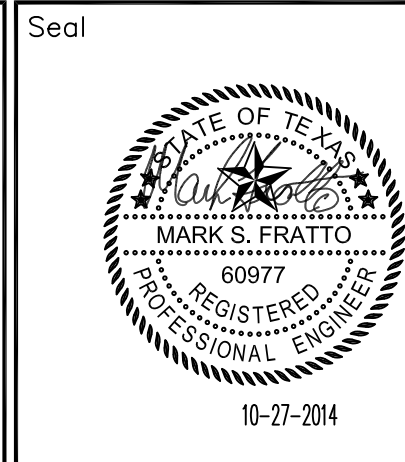

Drawing Title
FLOOR PLAN WEST - FIRST FLOOR ELECTRICAL
Approved: Area Project Manager

Project Title
V.A. BONHAM, TX BUILDING 2 ELECTRICAL UPGRADES
Building Number
2
Location
1201 East Ninth Street
Bonham, Texas 75418
Date
10/27/14
Project No.
549A4-11-102
Drawing No.
E201B
Dwg. of



VANTHCS
Dallas, Texas

100% CONSTRUCTION ISSUE