

VA MEDICAL CENTER EXPAND VISITOR/PATIENT PARKING GARAGE - PHASE 1

50 IRVING ST. N.W. WASHINGTON, D.C.



LIST OF DRAWINGS

GENERAL

G0.0 COVER SHEET

CIVIL

CD1.0 EXISTING CONDITIONS PLAN
 CD1.1 DEMOLITION PLAN
 CP1.0 CONSTRUCTION PHASING PLAN
 CS3.0 SITE, GRADING AND DRAINAGE PLAN
 CS3.1 SITE PAVING PLAN
 CS3.2 SITE DETAILS
 CG6.0 EROSION AND SEDIMENT CONTROL
 CG6.1 EROSION AND SEDIMENT CONTROL NOTES
 CG6.2 EROSION AND SEDIMENT CONTROL DETAILS
 LP7.0 LANDSCAPE PLAN
 LP7.1 LANDSCAPE NOTES AND DETAILS

ARCHITECTURAL

A0.1 CODE ANALYSIS
 A0.2 CODE ANALYSIS - TRAVEL DISTANCE
 A0.3 B2 & B1 TIER PLANS - EXISTING
 A0.4 GROUND TIER PLAN - EXISTING & DEMOLITION
 A0.5 DEMOLITION ELEVATIONS
 A1.1 GROUND & SECOND TIER PLANS - NEW WORK
 A1.2 THIRD & FOURTH TIER PLANS - NEW WORK
 A1.3 B2 & B1 TIER STRIPING PLANS - EXISTING & NEW WORK
 A1.4 GROUND TIER STRIPING PLAN & DETAILS - EXISTING & NEW WORK
 A1.5 SECOND TIER STRIPING PLAN - NEW WORK
 A1.6 THIRD & FOURTH TIER STRIPING PLANS - NEW WORK
 A2.1 BUILDING ELEVATIONS
 A2.2 BUILDING SECTIONS
 A2.3 ENLARGED BUILDING ELEVATIONS
 A2.4 ENLARGED SCREEN WALL ELEVATIONS
 A3.1 ELEVATOR/STAIR TOWER #1 ENLARGED PLANS
 A3.2 ELEVATOR/STAIR TOWER #2 ENLARGED PLANS
 A3.3 ELEVATOR/STAIR TOWER SECTIONS & DETAILS
 A3.4 CURTAIN WALL SECTIONS & ELEVATIONS
 A4.1 TYPICAL ELEVATOR LOBBY ELEVATIONS
 A4.2 ENCLOSED ELEVATOR LOBBY ELEVATIONS
 A4.3 SECURITY BOOTH & ELECTRICAL ROOM
 A5.1 SCHEDULES & DETAILS
 A5.2 ARCHITECTURAL DETAILS
 A6.1 SIGNAGE & GRAPHICS
 A6.2 SIGNAGE & GRAPHICS

STRUCTURAL

S0.1 STRUCTURAL GENERAL NOTES
 S0.2 STRUCTURAL GENERAL DETAILS
 S1.0 ANCHOR BOLT PLAN & DETAILS - EXISTING & NEW WORK
 S1.1 B2 & B1 TIER STRUCTURAL PLANS - EXISTING
 S1.2 GROUND TIER STRUCTURAL PLAN - EXISTING & NEW WORK
 S1.3 SECOND TIER STRUCTURAL PLAN - NEW WORK
 S1.4 THIRD TIER STRUCTURAL PLAN - NEW WORK
 S1.5 FOURTH TIER STRUCTURAL PLAN - NEW WORK
 S1.6 ELEVATOR/STAIR TOWER #1 STRUCTURAL PLANS
 S1.7 ELEVATOR/STAIR TOWER #1 ELEVATION & SECTIONS
 S1.8 ELEVATOR/STAIR TOWER #2 STRUCTURAL PLANS
 S1.9 ELEVATOR/STAIR TOWER #2 ELEVATION & SECTION
 S2.1 LIGHTWALL & SHEARWALL SECTIONS
 S2.2 WALL SECTIONS & SPANDREL DETAILS
 S2.3 WALL SECTIONS
 S3.1 PRECAST TEE DETAILS
 S3.2 PRECAST COLUMN PLAN DETAILS
 S3.3 PRECAST SECTION DETAILS
 S3.4 PRECAST DETAILS

MECHANICAL

M0.0 MECHANICAL NOTES & LEGENDS
 M1.1 B2 & B1 TIER MECHANICAL PLANS - EXISTING
 M1.2 GROUND & SECOND TIER MECHANICAL PLANS - EXISTING & NEW WORK
 M1.3 THIRD & FOURTH TIER MECHANICAL PLANS - NEW WORK

PLUMBING

P0.0 PLUMBING NOTES & LEGENDS
 P1.1 B2 & B1 TIER PLUMBING PLANS - EXISTING
 P1.2 GROUND & SECOND TIER PLUMBING PLANS - EXISTING & NEW WORK
 P1.3 THIRD & FOURTH TIER PLUMBING PLANS - NEW WORK

FIRE PROTECTION

FP0.0 FIRE PROTECTION NOTES & LEGENDS
 FP1.1 B2 & B1 TIER FIRE PROTECTION PLANS - EXISTING
 FP1.2 GROUND & SECOND TIER FIRE PROTECTION PLANS - EXISTING & NEW WORK
 FP1.3 THIRD & FOURTH TIER FIRE PROTECTION PLANS - NEW WORK

ELECTRICAL

E0.0 ELECTRICAL NOTES, LEGEND & ABBREVIATIONS
 E1.1 EXISTING CONDITIONS FACILITY SITE PLAN VIEW
 E1.2 SITE LIGHTING PLAN - EXISTING & NEW WORK
 E1.3 B2 & B1 TIER LIGHTING PLANS - EXISTING
 E1.4 GROUND TIER LIGHTING PLAN - DEMO & NEW WORK
 E1.5 SECOND TIER LIGHTING PLAN - NEW WORK
 E1.6 THIRD & FOURTH TIER LIGHTING PLANS - NEW WORK
 E2.1 B2 & B1 TIER POWER PLANS - EXISTING
 E2.2 GROUND & B2 TIER POWER PLAN - EXISTING & NEW WORK
 E2.3 GROUND & SECOND TIER POWER PLAN - NEW WORK
 E2.4 THIRD & FOURTH TIER POWER PLANS - NEW WORK
 E2.5 POWER RISER DIAGRAM
 E2.6 PANEL SCHEDULES & DETAILS
 E2.7 PANEL SCHEDULES & DETAILS
 E2.8 PANEL SCHEDULES
 E3.1 B2 & B1 TIER COMMUNICATIONS & LIFE SAFETY PLANS - EXISTING
 E3.2 GROUND & B2 TIER COMMUNICATIONS & LIFE SAFETY PLAN - EXISTING
 E3.3 GROUND & SECOND TIER COMMUNICATIONS & LIFE SAFETY PLANS - NEW WORK
 E3.4 THIRD & FOURTH TIER COMMUNICATION & LIFE SAFETY PLANS - NEW WORK
 E3.5 COMMUNICATIONS & LIFE SAFETY RISER DIAGRAMS

OWNER

DEPARTMENT OF VETERANS AFFAIRS
 DC VA MEDICAL CENTER
 FACILITIES MANAGEMENT SERVICES

ARCHITECT

MELVILLE THOMAS ARCHITECTS, INC.
 600 WYNDHURST AVENUE, SUITE 315
 BALTIMORE, MD 21210
 www.mtarx.com

STRUCTURAL ENGINEER/ PARKING GARAGE CONSULTANT

TIMOTHY HAAS & ASSOCIATES, INC.
 550 TOWNSHIP LINE ROAD, SUITE 100
 BLUE BELL, PA 19422
 www.timhaas.com

MECHANICAL/ELECTRICAL/PLUMBING ENGINEER

DCS INFRASTRUCTURE, INC.
 3249 ROUTE 112, SUITE 1B
 MEDFORD, NY 11763
 www.dcsllc.info



CIVIL ENGINEER

KCI TECHNOLOGIES, INC.
 936 RIDGEBROOK ROAD
 SPARKS, MD 21152
 www.kci.com

COST ESTIMATOR

DMS CONSTRUCTION CONSULTING SERVICES, INC.
 5550 STERRETT PLACE, SUITE 300
 COLUMBIA, MD 21044
 www.dmsccs.com

LOCATION MAP - NOT TO SCALE

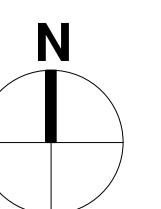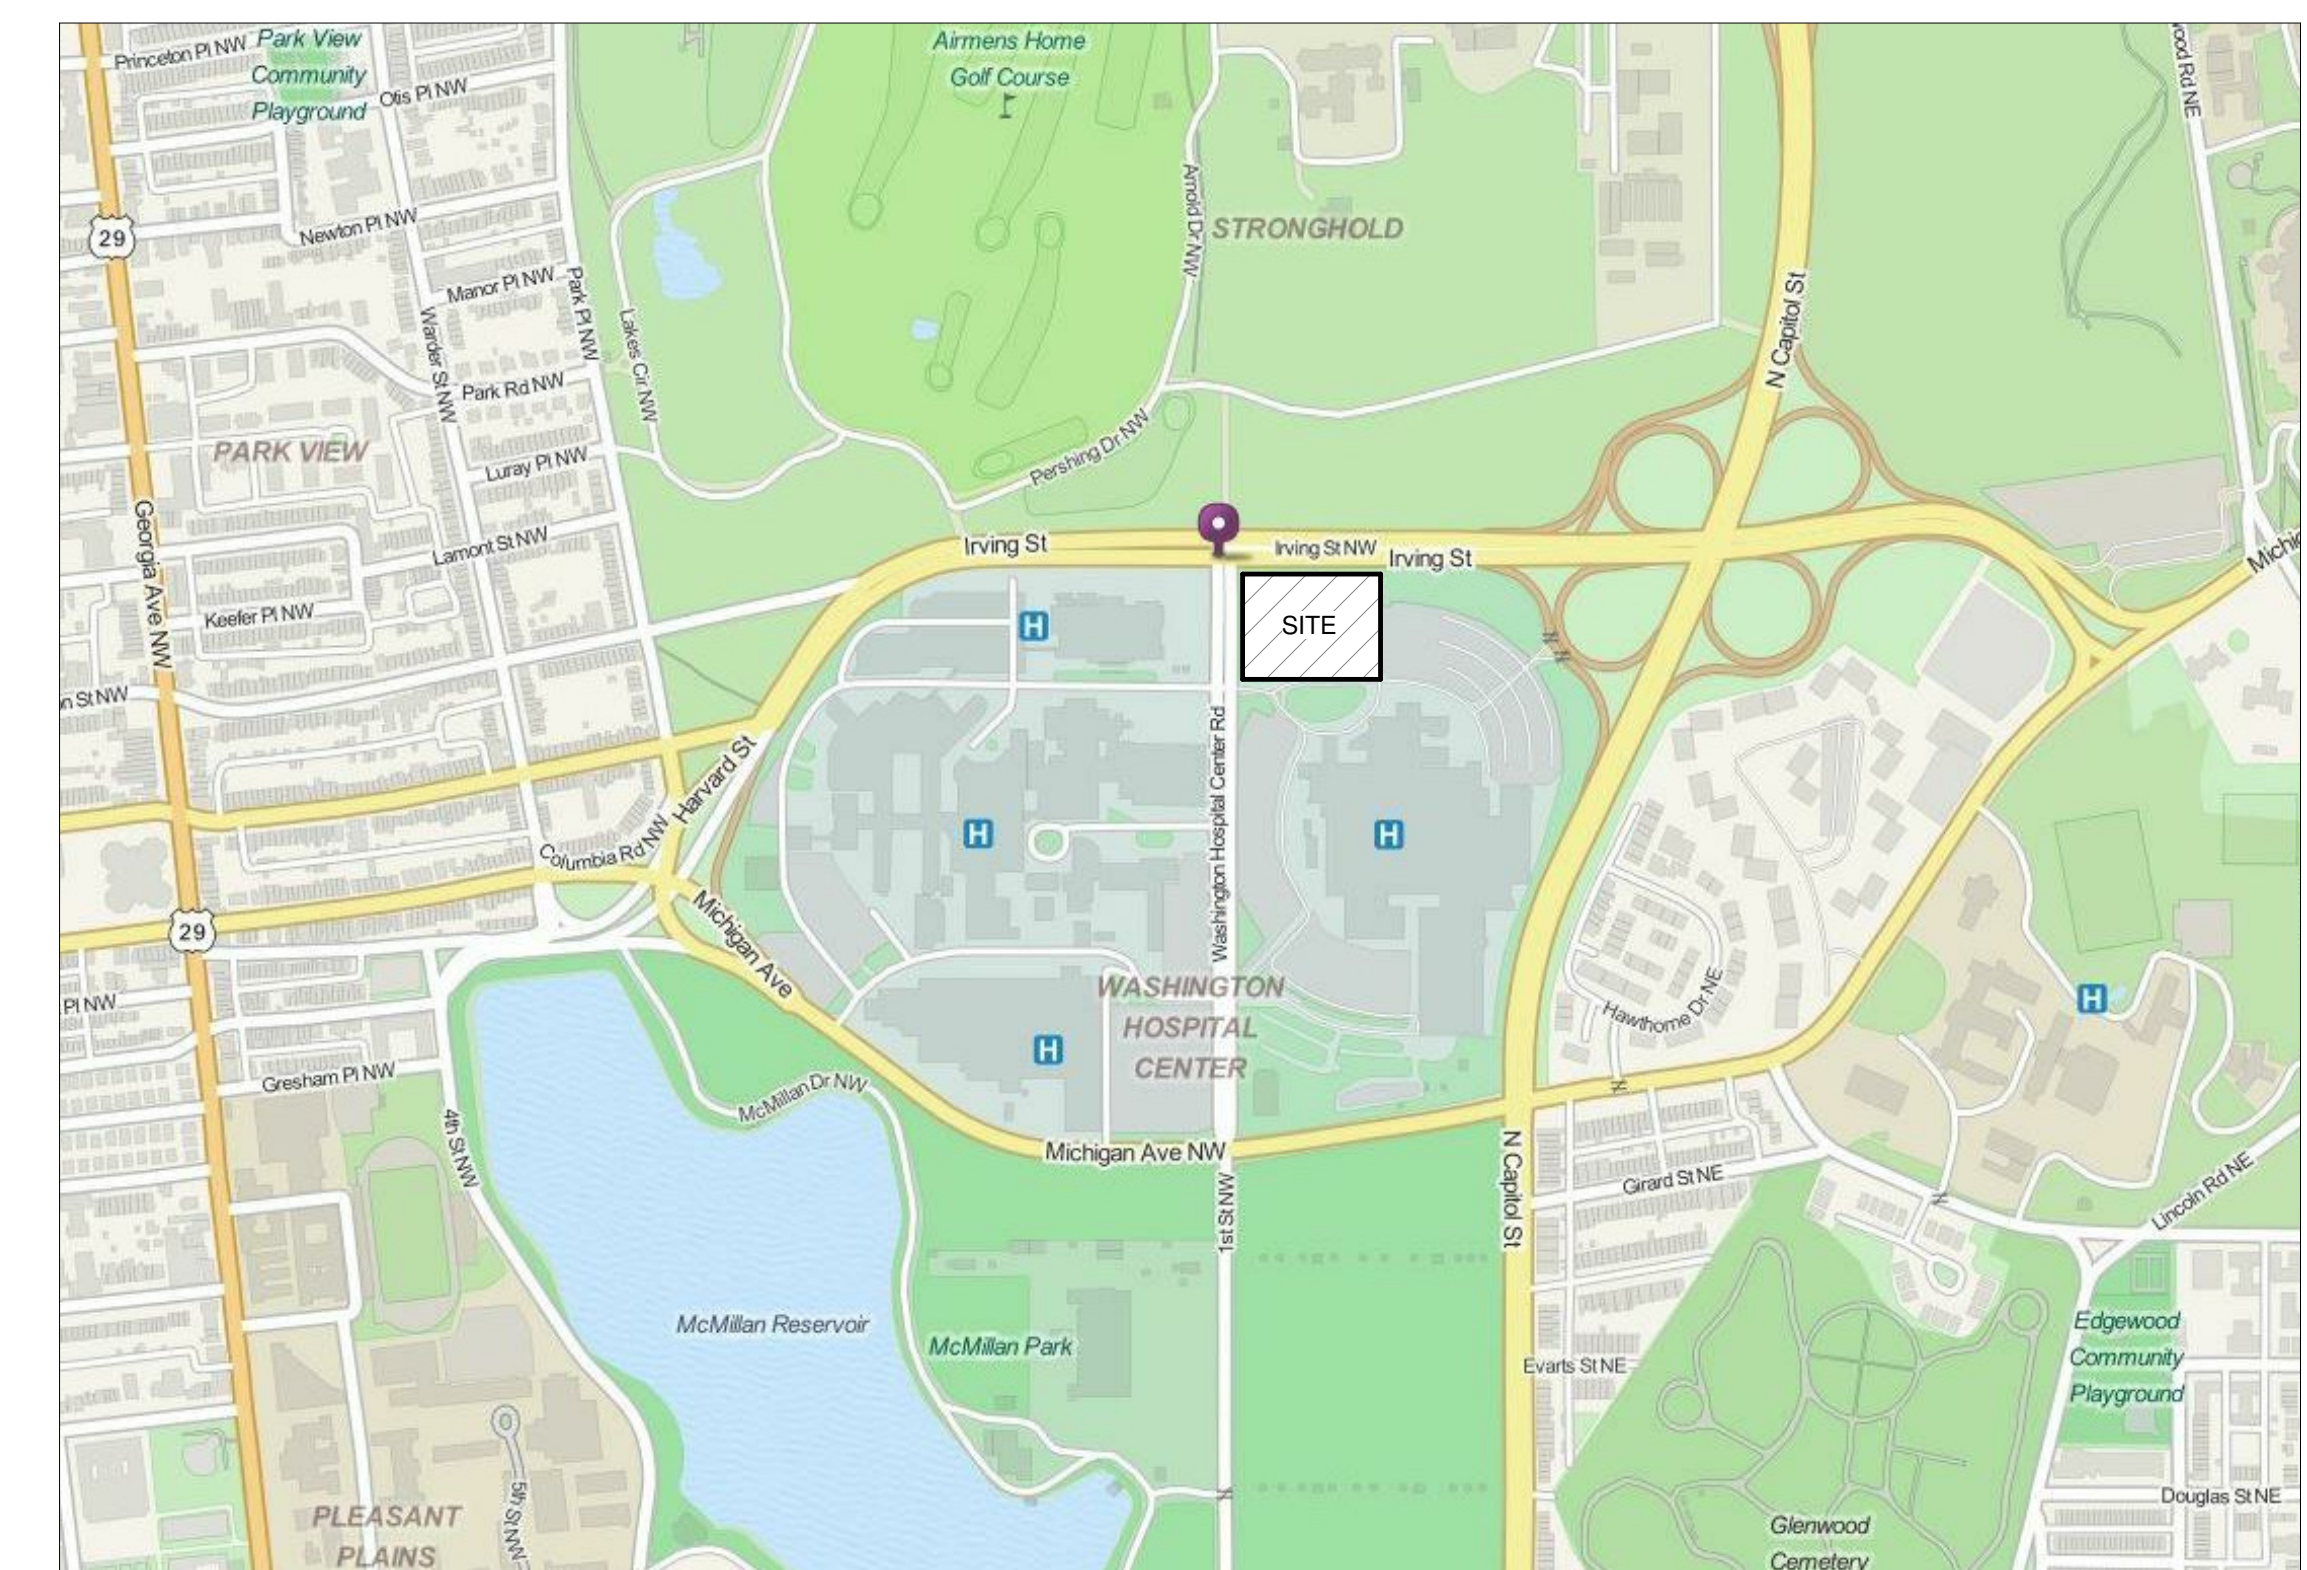

4	100% Submission	02/16/15
3	95% Submission	08/28/14
2	65% Submission	08/07/14
1	35% Submission	04/15/14
Revisions:		Date

SEAL:

ARCHITECT/ENGINEERS:

Melville Thomas Architects, Inc.
 ARCHITECTURE & PLANNING



400 Wyndhurst Ave., Suite 315 Baltimore, MD 21210
 T: 410.433.4400 F: 410.433.4719
 www.mtarx.com

Drawing Title
 COVER SHEET

Approved: Project Director

-

-

-

Project Title
 VA MEDICAL CENTER
 EXPAND VISITOR/PATIENT
 PARKING GARAGE - PHASE 1

Location
 50 IRVING ST. N.W. WASHINGTON, D.C.

Date
 02/16/15

Checked
 GT

Drawn
 MC

Project Number
 688-345

Building Number
 -

Drawing Number
 G0.0

Dwg. 01 of 89

Office of
 Construction
 and Facilities
 Management

