 
 
 

 
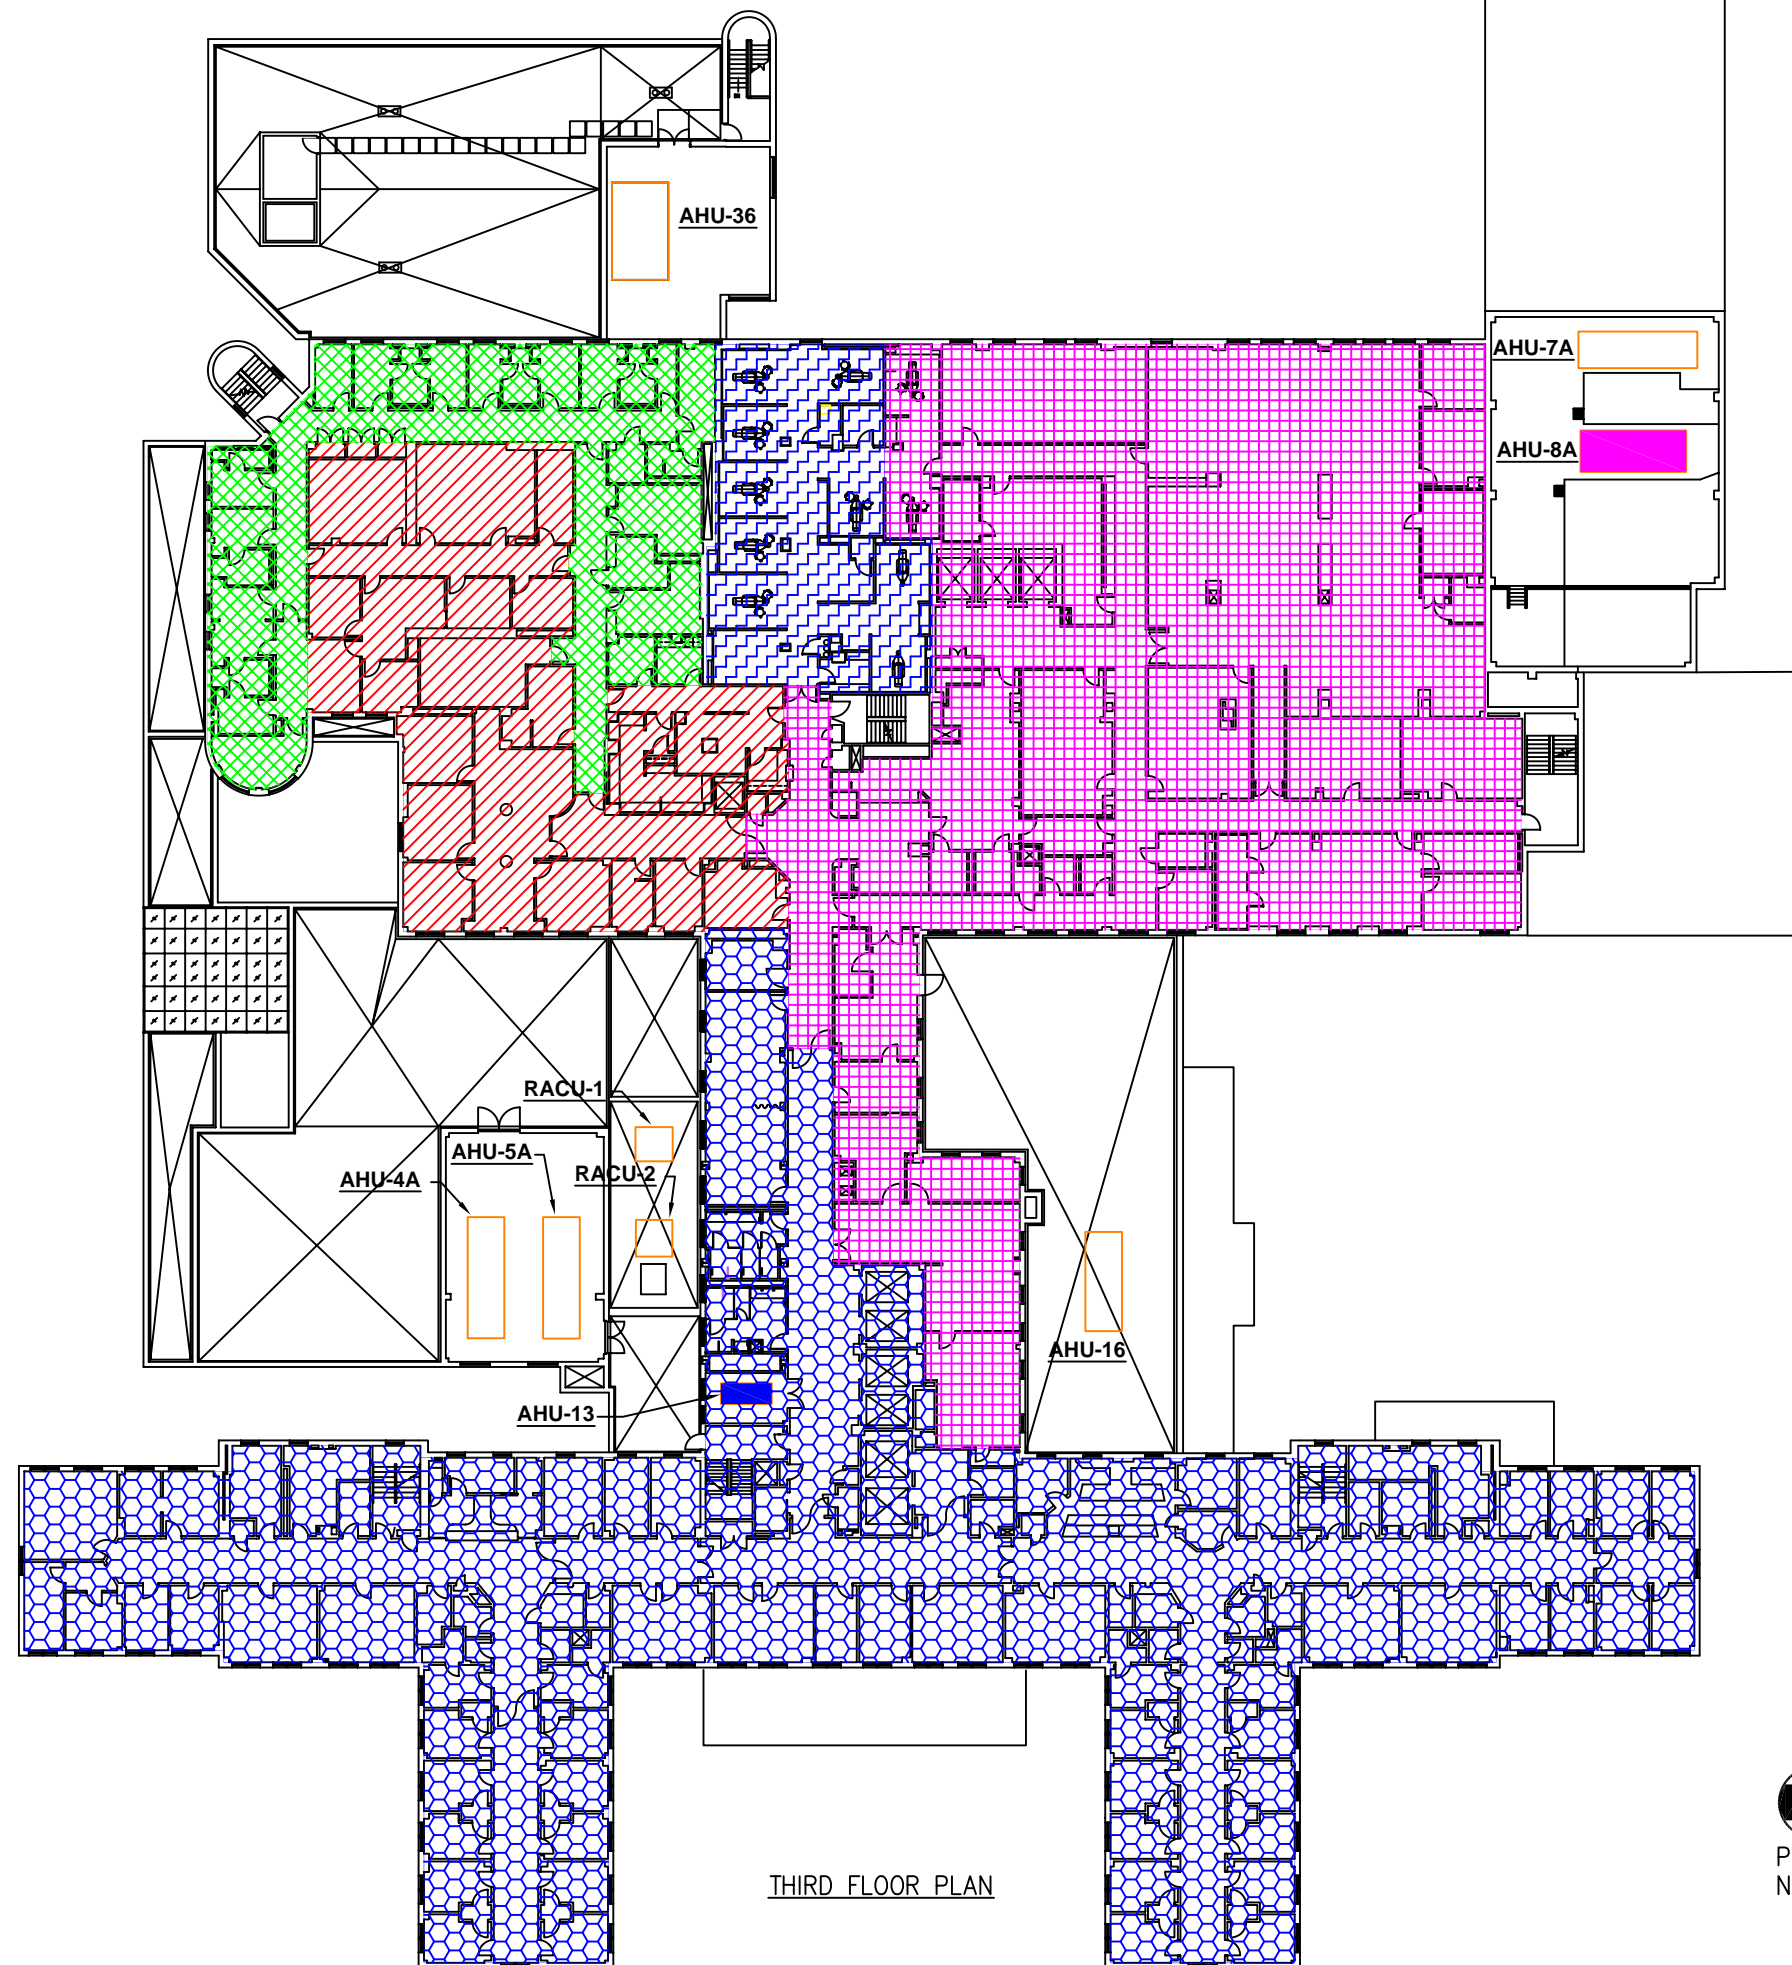


-  SERVICED BY AHU #13
-  SERVICED BY AHU #2A (LOCATED IN BASEMENT)
-  SERVICED BY AHU #3A (LOCATED IN BASEMENT)
-  SERVICED BY AHU #8A (LOCATED ON 2ND FLOOR)
-  SERVICED BY AHU #40



THIRD FLOOR PLAN



PROJECT: VA MEDICAL CENTER
LOUISVILLE, KY
HVAC & ELECTRICAL STUDY - 3RD FLOOR PLAN

COMM. # 74340 DATE: 03-25-05

DRAWN BY: MTR

DWG. # SK-3
REFERENCE: