


# PARKING LOT 7 EXPANSION

PROJECT NO. 528A5-16-505

V.A. MEDICAL CENTER  
CANANDAIGUA, NEW YORK 14424

## LIST OF DRAWINGS

SYMBOL	SHEET	TITLE
T-1	1 OF 20	COVER SHEET
C-001	2 OF 20	CONSTRUCTION NOTES
C-100	3 OF 20	EXISTING / DEMOLITION SITE PLAN
C-101	4 OF 20	PROPOSED SITE PLAN
C-102	5 OF 20	SIGNING AND PAVEMENT MARKING PLAN
C-103	6 OF 20	CONSTRUCTION LAYOUT PLAN
C-104	7 OF 20	EROSION AND SEDIMENT CONTROL PLAN
C-200	8 OF 20	STORMWATER PROFILES
C-500	9 OF 20	CONSTRUCTION DETAILS
C-501	10 OF 20	CONSTRUCTION DETAILS
C-502	11 OF 20	CONSTRUCTION DETAILS
C-503	12 OF 20	CONSTRUCTION DETAILS
C-504	13 OF 20	CONSTRUCTION DETAILS
C-505	14 OF 20	EROSION AND SEDIMENT CONTROL PLAN NOTES / DETAILS
C-506	15 OF 20	BOUNDARY SURVEY 1 OF 2
C-507	16 OF 20	BOUNDARY SURVEY 2 OF 2
E-100	17 OF 20	SITE ELECTRICAL PLAN
E-101	18 OF 20	SITE LIGHTING PLAN
E-110	19 OF 20	BUILDING 10 EXISTING AN NEW WORK ELECTRICAL PLANS
E-111	20 OF 20	ELECTRICAL EXISTING AND NEW WORK ONE LINE AND DETAILS

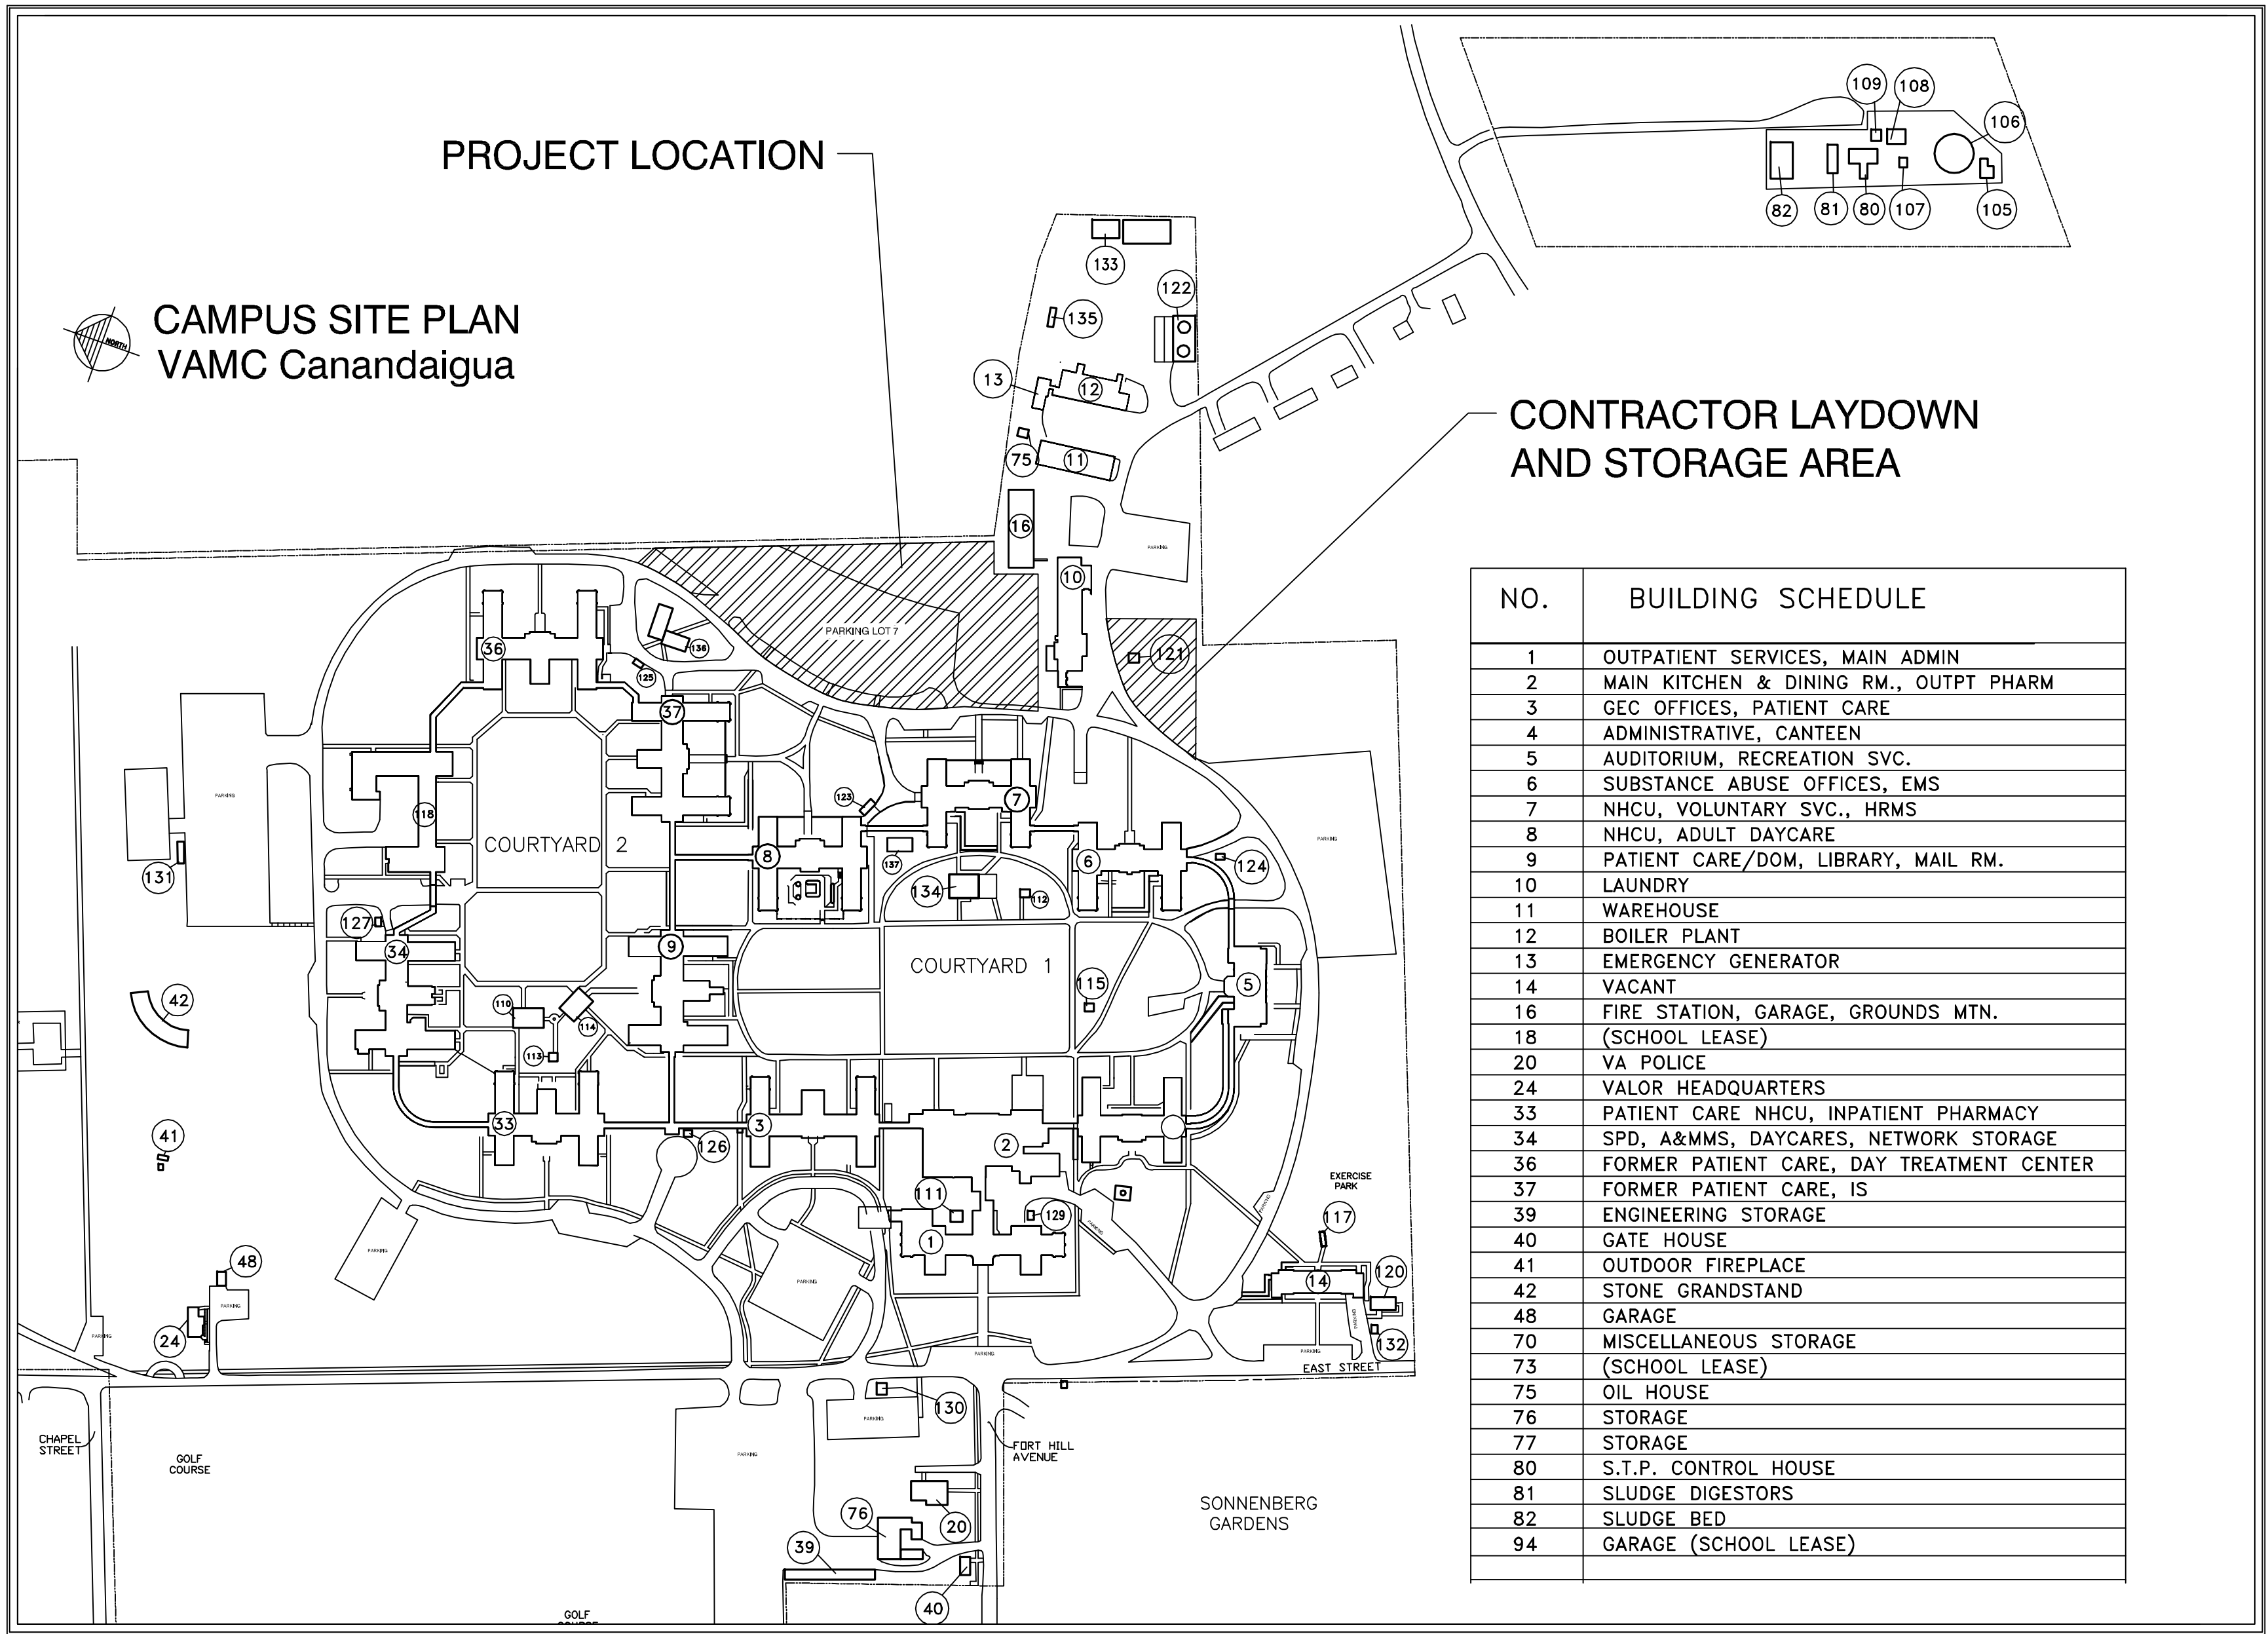

CONSTRUCTION DOCUMENTS



Consultant



ALL WORK TO BE IN ACCORDANCE WITH  
N.F.P.A., NATIONAL, STATE AND CITY  
CODES & O.S.H.A.

Approved: Logistics Manager. Date

Approved: Infection Control Mgr. Date

Approved: Chief Security Date

Approved: A.F.G.E. Date

Approved: Interior Designer Date

Approved: Info. Sys. Date

Approved: Women's Health Rep Date

Approved: Fire Chief Date

Approved: Safety Officer Date

Approved: Industrial Hygienist Date

Approved: Space Owner Date

Approved: Energy Engineer Date

Approved: M&R Foreman Date

Approved: Patient Safety Date

Approved: Associate Director Date

Drawing Title  
**COVER SHEET**

Approved: Eng. Project Supervisor Date

Approved: Medical Center Director Date

Project Title  
**PARKING LOT 7 EXPANSION**

Date  
**06/23/2016**  
Project No.  
**528A5-16-505**

Building No.  
**LOT 7**

Checked  
**CJC**

Drawn  
**TAD**

Location  
**CANANDAIGUA, NEW YORK**

DRAWING NO.  
**T-1**  
Dwg. 1 of 20

V.A.