


- LEGEND
- EXISTING CONTOUR MINOR
 - 800--- EXISTING CONTOUR MAJOR
 - 800--- PROPOSED CONTOUR MAJOR
 - 801--- PROPOSED CONTOUR MINOR
 - ===== EXISTING GRANITE CURB
 - ===== PROPOSED GRANITE CURB
 - G--- EXISTING GAS LINE/GAS VALVE
 - H--- EXISTING FIRE HYDRANT
 - W--- EXISTING WATER LINE/VALVE
 - S--- EXISTING SANITARY LINE/SANITARY MANHOLE
 - O--- EXISTING STORM LINE/STORM INLET
 - E--- EXISTING OVERHEAD ELECTRIC TELEPHONE/CABLE UTILITY POLE
 - UE--- EXISTING UNDERGROUND ELECTRIC/LIGHT POLE
 - *UE--- PROPOSED UNDERGROUND ELECTRIC/LIGHT POLE
 - PROPOSED STORM LINE/STORM INLET
 - --- PROPERTY LINE
 - --- PROPOSED PAVEMENT MARKING
 - O--- PROPOSED SIGN
 - ===== PROPOSED BITUMINOUS PAVEMENT
 - ===== PROPOSED CONCRETE WALK
 - ===== PROPOSED LANDSCAPE RESTORATION
 - X--- PROPOSED CHAINLINK FENCE
 - +--- PROPOSED GUIDERAIL

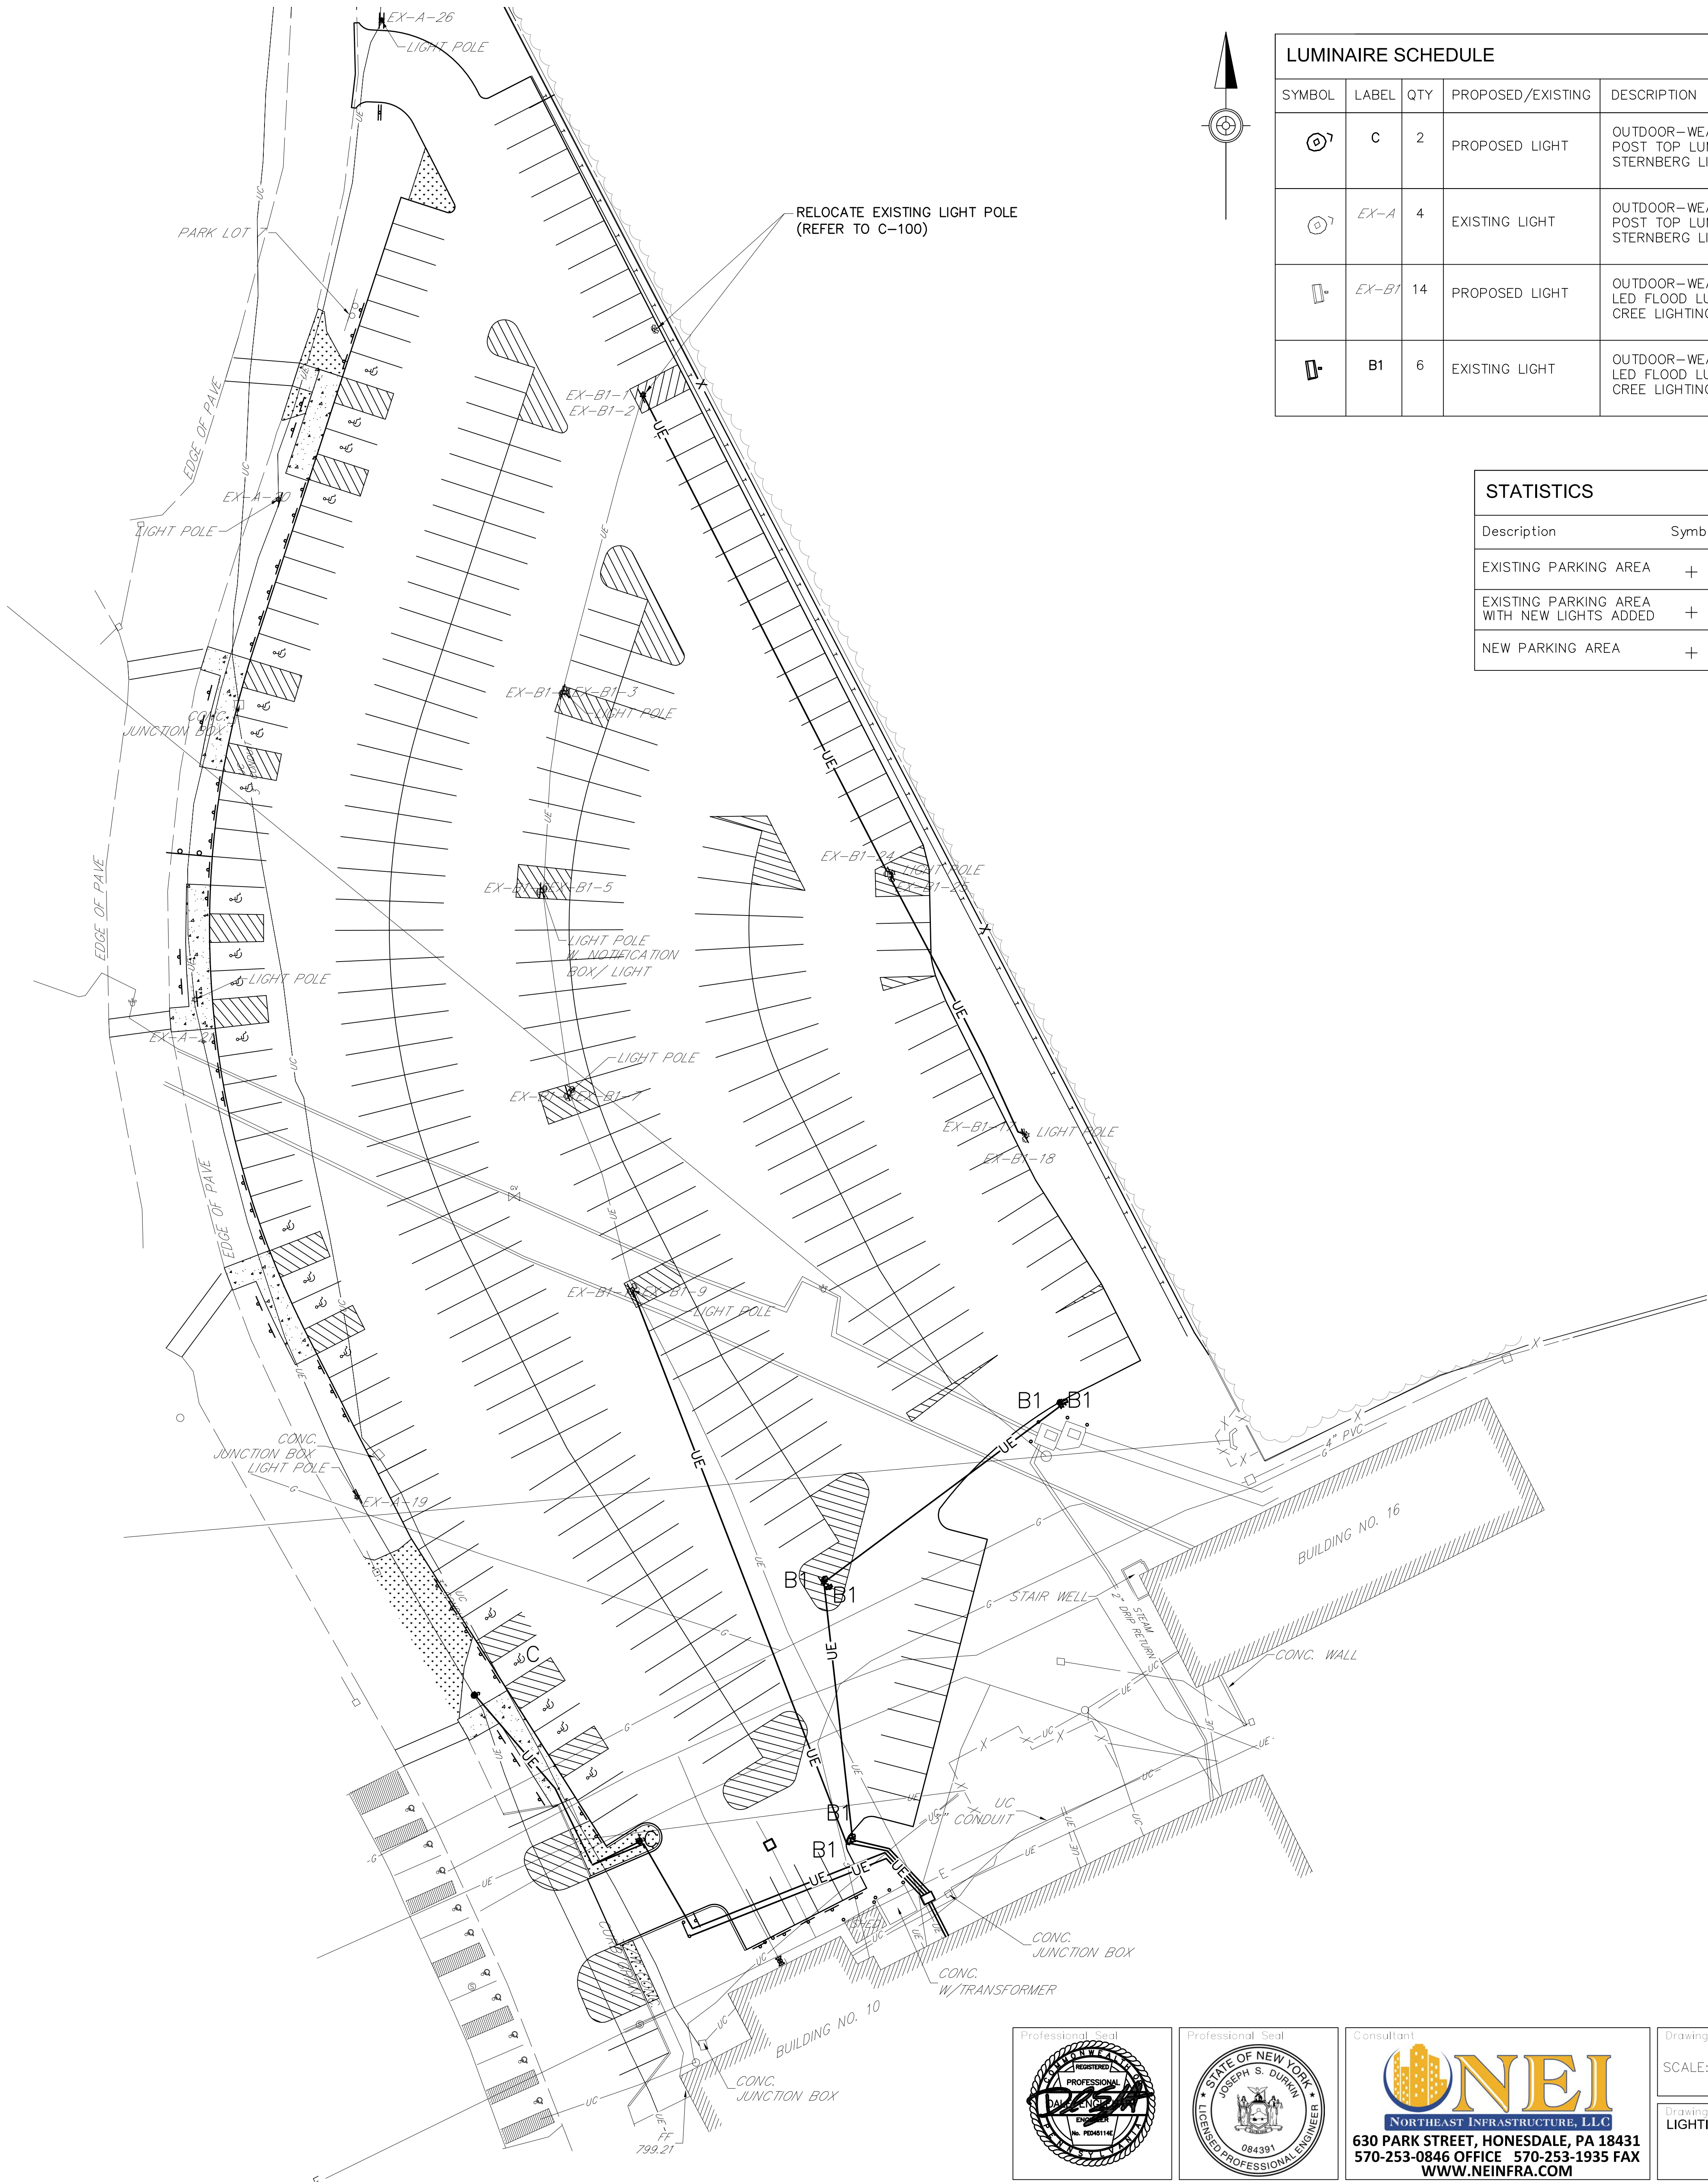

LUMINAIRE SCHEDULE					
SYMBOL	LABEL	QTY	PROPOSED/EXISTING	DESCRIPTION	ADDITIONAL INFORMATION
	C	2	PROPOSED LIGHT	OUTDOOR-WEATHERTIGHT POST TOP LUMINAIRE BY STERNBERG LIGHTING	SEE THE LIGHTING FIXTURE SCHEDULE ON SHEET E-100 FOR COMPLETE LIGHTING FIXTURE DESCRIPTION.
	EX-A	4	EXISTING LIGHT	OUTDOOR-WEATHERTIGHT POST TOP LUMINAIRE BY STERNBERG LIGHTING	SEE THE LIGHTING FIXTURE SCHEDULE ON SHEET E-100 FOR COMPLETE LIGHTING FIXTURE DESCRIPTION.
	EX-B1	14	PROPOSED LIGHT	OUTDOOR-WEATHERTIGHT LED FLOOD LUMINAIRE BY CREE LIGHTING	SEE THE LIGHTING FIXTURE SCHEDULE ON SHEET E-100 FOR COMPLETE LIGHTING FIXTURE DESCRIPTION.
	B1	6	EXISTING LIGHT	OUTDOOR-WEATHERTIGHT LED FLOOD LUMINAIRE BY CREE LIGHTING	SEE THE LIGHTING FIXTURE SCHEDULE ON SHEET E-100 FOR COMPLETE LIGHTING FIXTURE DESCRIPTION.

STATISTICS						
Description	Symbol	Avg	Max	Min	Max/Min	Avg/Min
EXISTING PARKING AREA	+	1.5 fc	13.0 fc	0.1 fc	130.0:1	14.6:1
EXISTING PARKING AREA WITH NEW LIGHTS ADDED	+	1.6 fc	13.0 fc	0.2 fc	65.0:1	8.0:1
NEW PARKING AREA	+	2.0 fc	13.2 fc	0.5 fc	26.4:1	4.0:1

LUMINAIRE LOCATIONS					
No.	Label	MH	Orientation	Tilt	
1	EX-B1	20.0	-85.8	45.0	
2	EX-B1	20.0	208.5	45.0	
3	EX-B1	20.0	102.3	45.0	
4	EX-B1	20.0	-76.7	45.0	
5	EX-B1	20.0	91.6	45.0	
6	EX-B1	20.0	270.0	45.0	
7	EX-B1	20.0	85.2	45.0	
8	EX-B1	20.0	261.6	45.0	
9	EX-B1	20.0	65.0	45.0	
10	EX-B1	20.0	250.0	45.0	
11	B1	20.0	-79.9	45.0	
12	B1	20.0	-15.2	45.0	
13	B1	20.0	-37.2	45.0	
14	B1	20.0	150.9	45.0	
15	B1	20.0	-20.3	45.0	
16	B1	20.0	-41.0	45.0	
17	EX-B1	20.0	262.1	45.0	
18	EX-B1	20.0	234.1	45.0	
19	EX-A	12.0	62.0	0.0	
20	EX-A	12.0	108.0	0.0	
21	EX-A	12.0	88.3	0.0	
22	C	12.0	66.6	0.0	
23	C	12.0	67.8	0.0	
24	EX-B1	20.0	-89.7	45.0	
25	EX-B1	20.0	216.1	45.0	
26	EX-A	12.0	153.0	0.0	

CONSTRUCTION DOCUMENTS

Revisions	Date



Consultant

ONEI
NORTHEAST INFRASTRUCTURE, LLC
630 PARK STREET, HONESDALE, PA 18431
570-253-0846 OFFICE 570-253-1935 FAX
WWW.NEINFRA.COM

Drawing Scale

SCALE: 0 25 50 FEET

Drawing Title
LIGHTING PLAN

Project Title
PARKING LOT 7 EXPANSION

Building No.
LOT 7

Location
CANANDAIGUA, NEW YORK

Date
06/23/2016

Project No.
528A5-16-505

E-101

Draw 18 of 20

V.A.