


VICINITY MAP

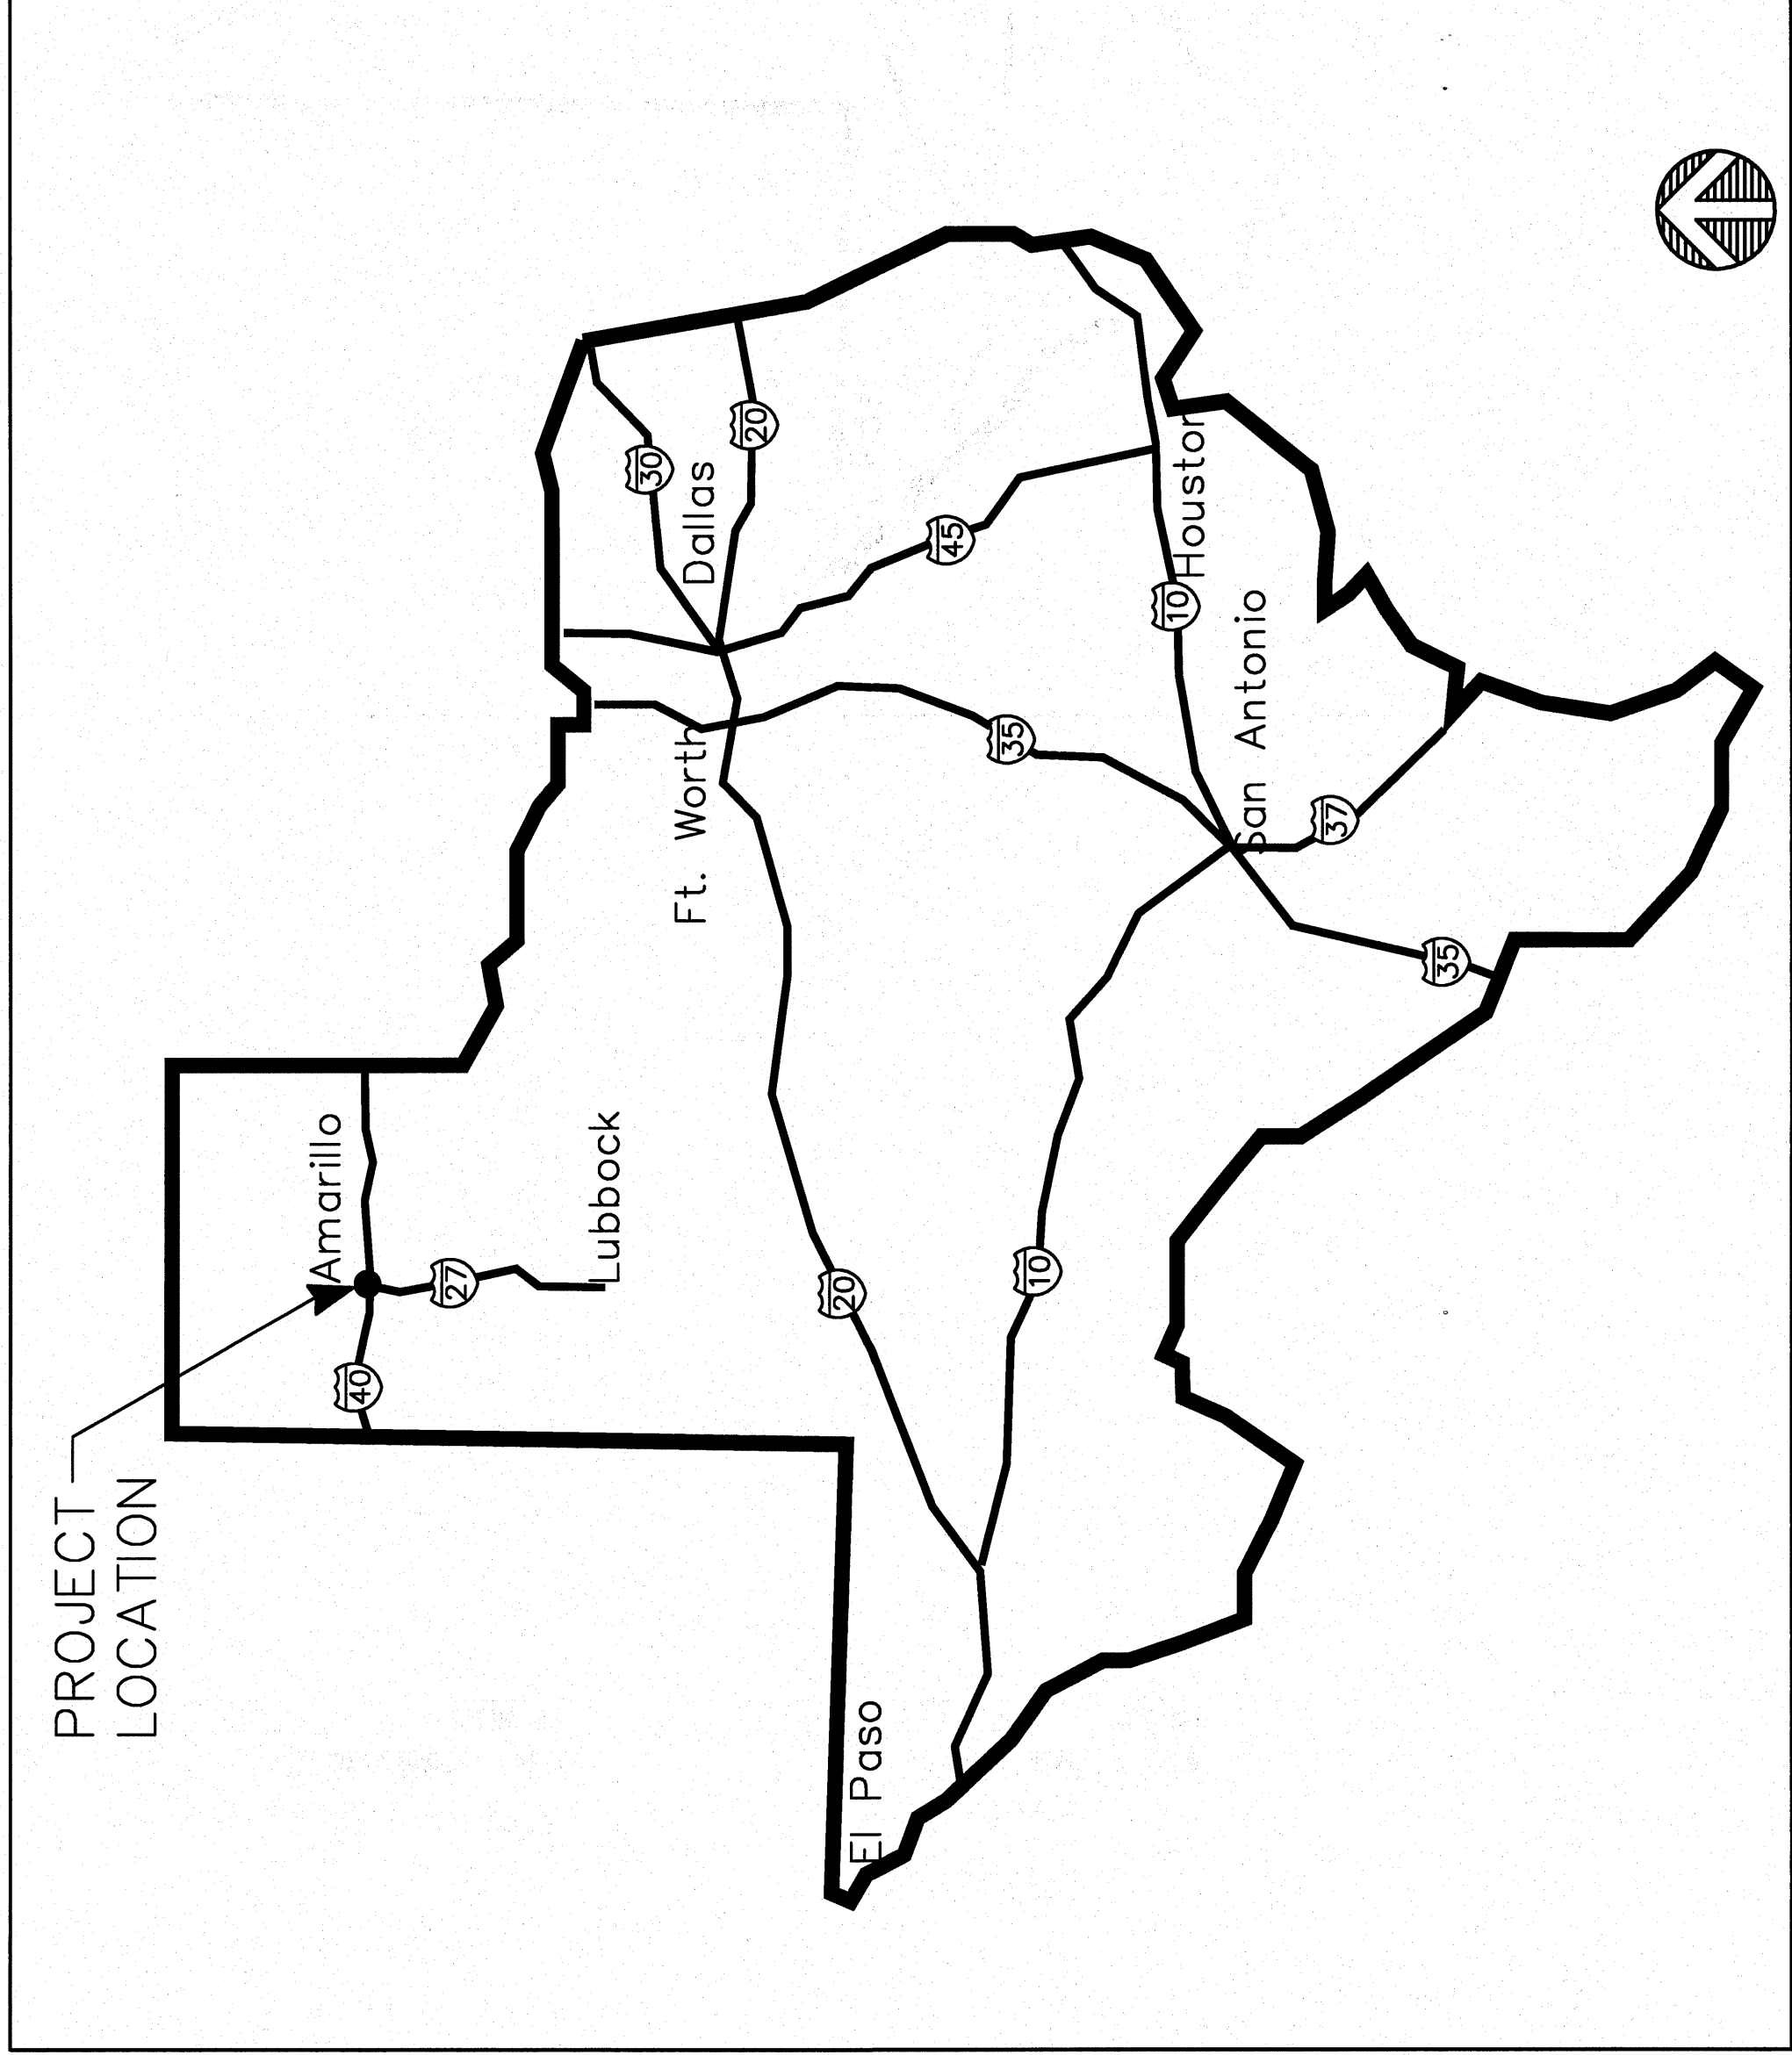

SITE MAP



PROJECT TEAM

OWNER

Department of Veterans Affairs
Amarillo VA Health Care System
6010 Amarillo Boulevard West
Amarillo, Texas 79106
CONTACT: Janice Johnson
PHONE: 806.355.9703 ext 7435
EMAIL: Janice.Johnson@dvrna.va.gov

ARCHITECT

The Hartman + Maguire DESIGN GROUP
120 Vassar Drive SE Suite 100
Albuquerque, NM 87106
CONTACT: Wendy E.S. Ceruso, Project Manager
PHONE: 505.242.6880
EMAIL: wceruso@designgroupnm.com

MECHANICAL ENGINEER

Bridgers & Paxton Consulting Engineers, Inc.
4800-C Montgomery Boulevard NE
Albuquerque, NM 87109
CONTACT: Larry O'Hara
PHONE: 505.883.4111
EMAIL: LOHara@bpce.com

ELECTRICAL ENGINEER

Bridgers & Paxton Consulting Engineers, Inc.
4800-C Montgomery Boulevard NE
Albuquerque, NM 87109
CONTACT: John F. Heck, PE
PHONE: 505.883.4111
EMAIL: jheck@bpce.com

INTERIOR DESIGNER

The Hartman + Maguire DESIGN GROUP
120 Vassar Drive SE Suite 100
Albuquerque, NM 87106
CONTACT: John F. Heck, PE
PHONE: 505.242.6880
EMAIL: RDCCap@designgroupnm.com

DRAWING INDEX

GENERAL

G100 TITLE SHEET
G701 TITLE SHEET GUIDELINES, PARTITION TYPES, ABBREVIATIONS AND SYMBOLS

ARCHITECTURAL

A101 DEMOLITION PLAN / FLOOR PLAN
A102 FINISH PLAN / REFLECTED CEILING PLAN
A501 INTERIOR ELEVATIONS / ENLARGED FLOOR PLANS / SECTIONS

PLUMBING

P001 PLUMBING LEGEND, SYMBOLS AND ABBREVIATIONS
P101 PLUMBING DEMOLITION AND NEW WORK PLANS
P102 PLUMBING DEMOLITION AND NEW WORK PLANS

MECHANICAL

M001 MECHANICAL GENERAL NOTES, SYMBOLS, ABBREVIATIONS AND DETAILS
MH101 MECHANICAL DEMOLITION AND NEW WORK PLANS
M701 MECHANICAL EQUIPMENT SCHEDULES

ELECTRICAL

E001 ELECTRICAL SYMBOLS, LEGENDS
EH101 ELECTRICAL DEMOLITION PLANS
E101 ELECTRICAL NEW WORK PLANS

FURNITURE

I-101 SYSTEMS FURNITURE

THOMAS E. CREEK VA MEDICAL CENTER

ICU ENDO STORAGE WAITING ROOM RENOVATION

AMARILLO, TEXAS


100% CONSTRUCTION DOCUMENTS
OCTOBER 12, 2011

NOTE TO BIDDER

DEDUCTIVE ALTERNATES

1. DELETE DEMOLITION AND NEW WORK ASSOCIATED WITH ROOM 4247 CLEAN STORAGE EXCLUDING PLUMBING WORK.
2. DELETE DEMOLITION AND NEW WORK ASSOCIATED WITH ROOM 4248 TOILET.
3. DELETE MECHANICAL WORK ASSOCIATED WITH ROOM 4248 TOILET.
4. REPLACE SOLID SURFACE COUNTERTOPS WITH PLASTIC LAMINATE COUNTERTOPS.

Key Plan

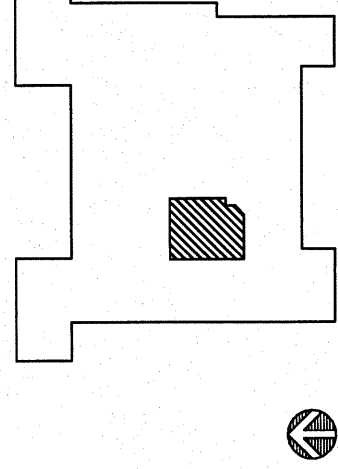

THE DESIGN GROUP
ARCHITECTS • PLANNERS • INTERIOR DESIGN
120 VASSAR DRIVE SE SUITE 100
ALBUQUERQUE, NEW MEXICO 87106
PHONE: 505.242.6880 FAX: 505.242.6881



Architect

Engineer

Revisions
△
△
△
△
△

Initials	Date

Approved For:	Director	Associate Director	Chief of Staff	Chief of Services	Chief of Engineering	Chief, Project Section
Construction Submittal						

Drawing Title	Project Title	Date
TITLE SHEET	ICU ENDO STORAGE WAITING ROOM RENOVATION Building 28	October 12, 2011

Project No.	504-10-101
Building Number	Amarillo VA Health Care Center
Building Number	28
Location	4th Floor
Checked By	
Drawing No.	G100
Dwg.	G100

Veterans Administration