



GRADING AND DRAINAGE PLAN

SECTION '1'

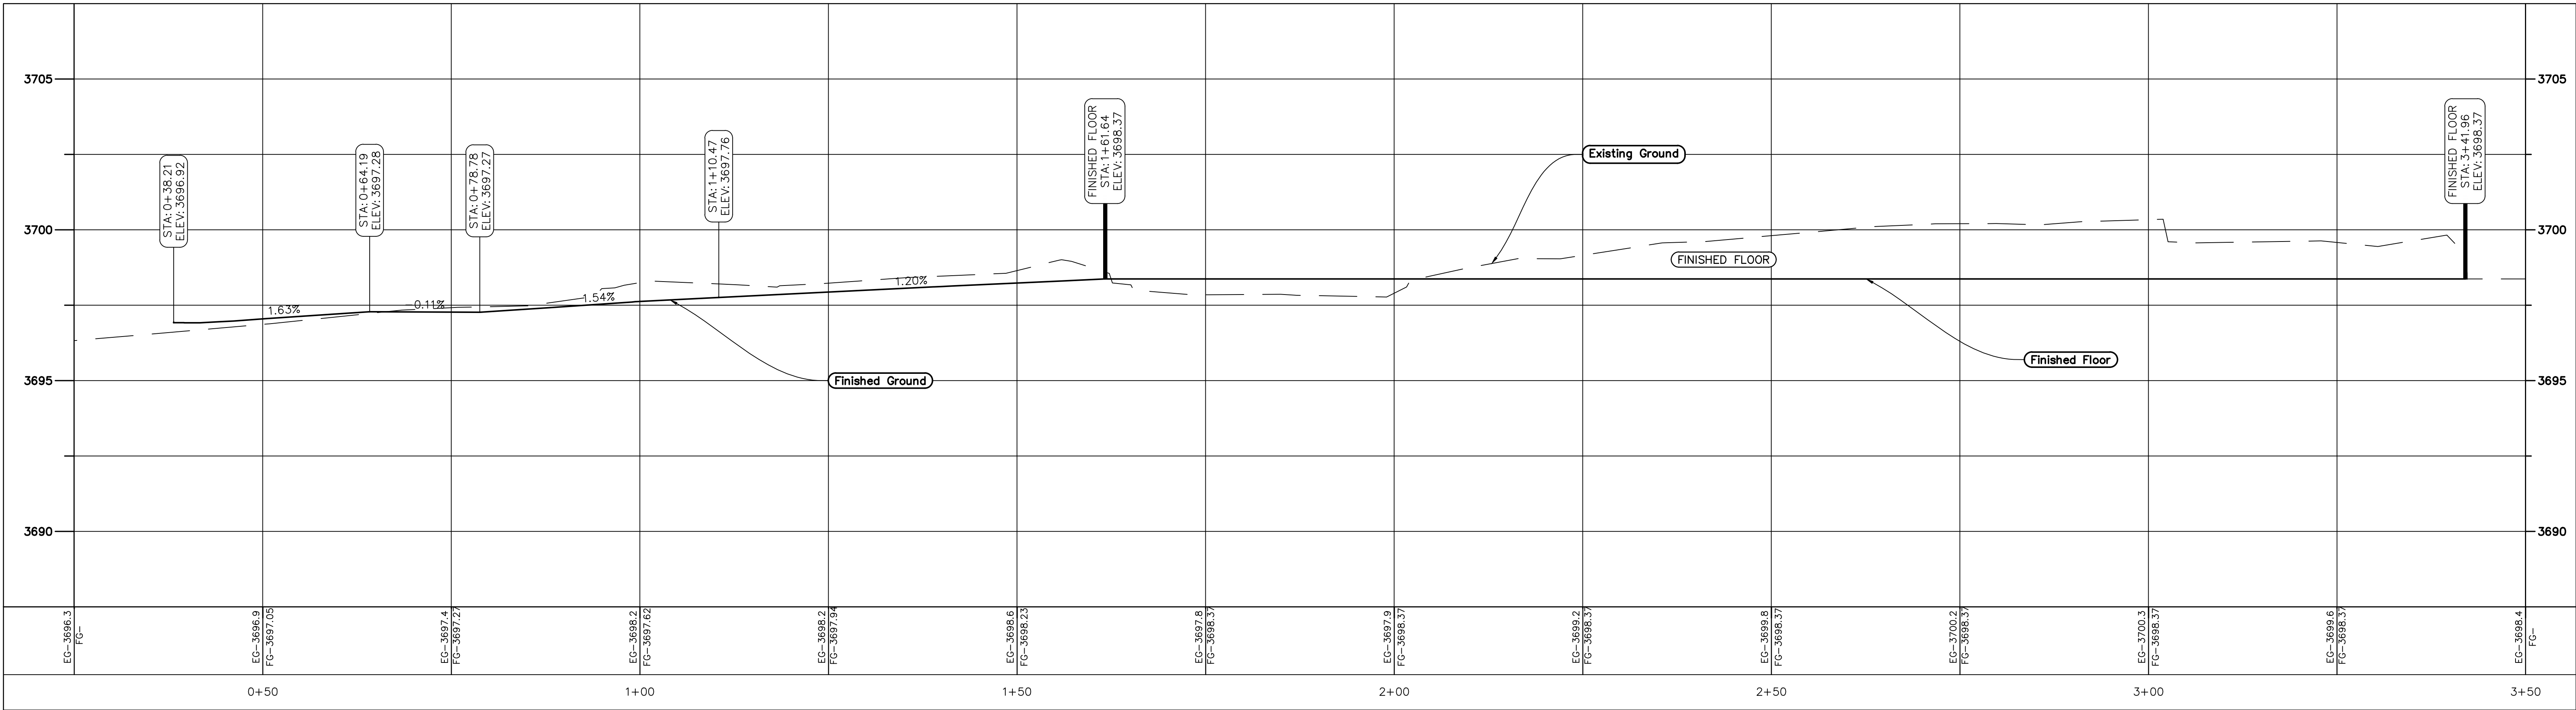

SECTION '2'

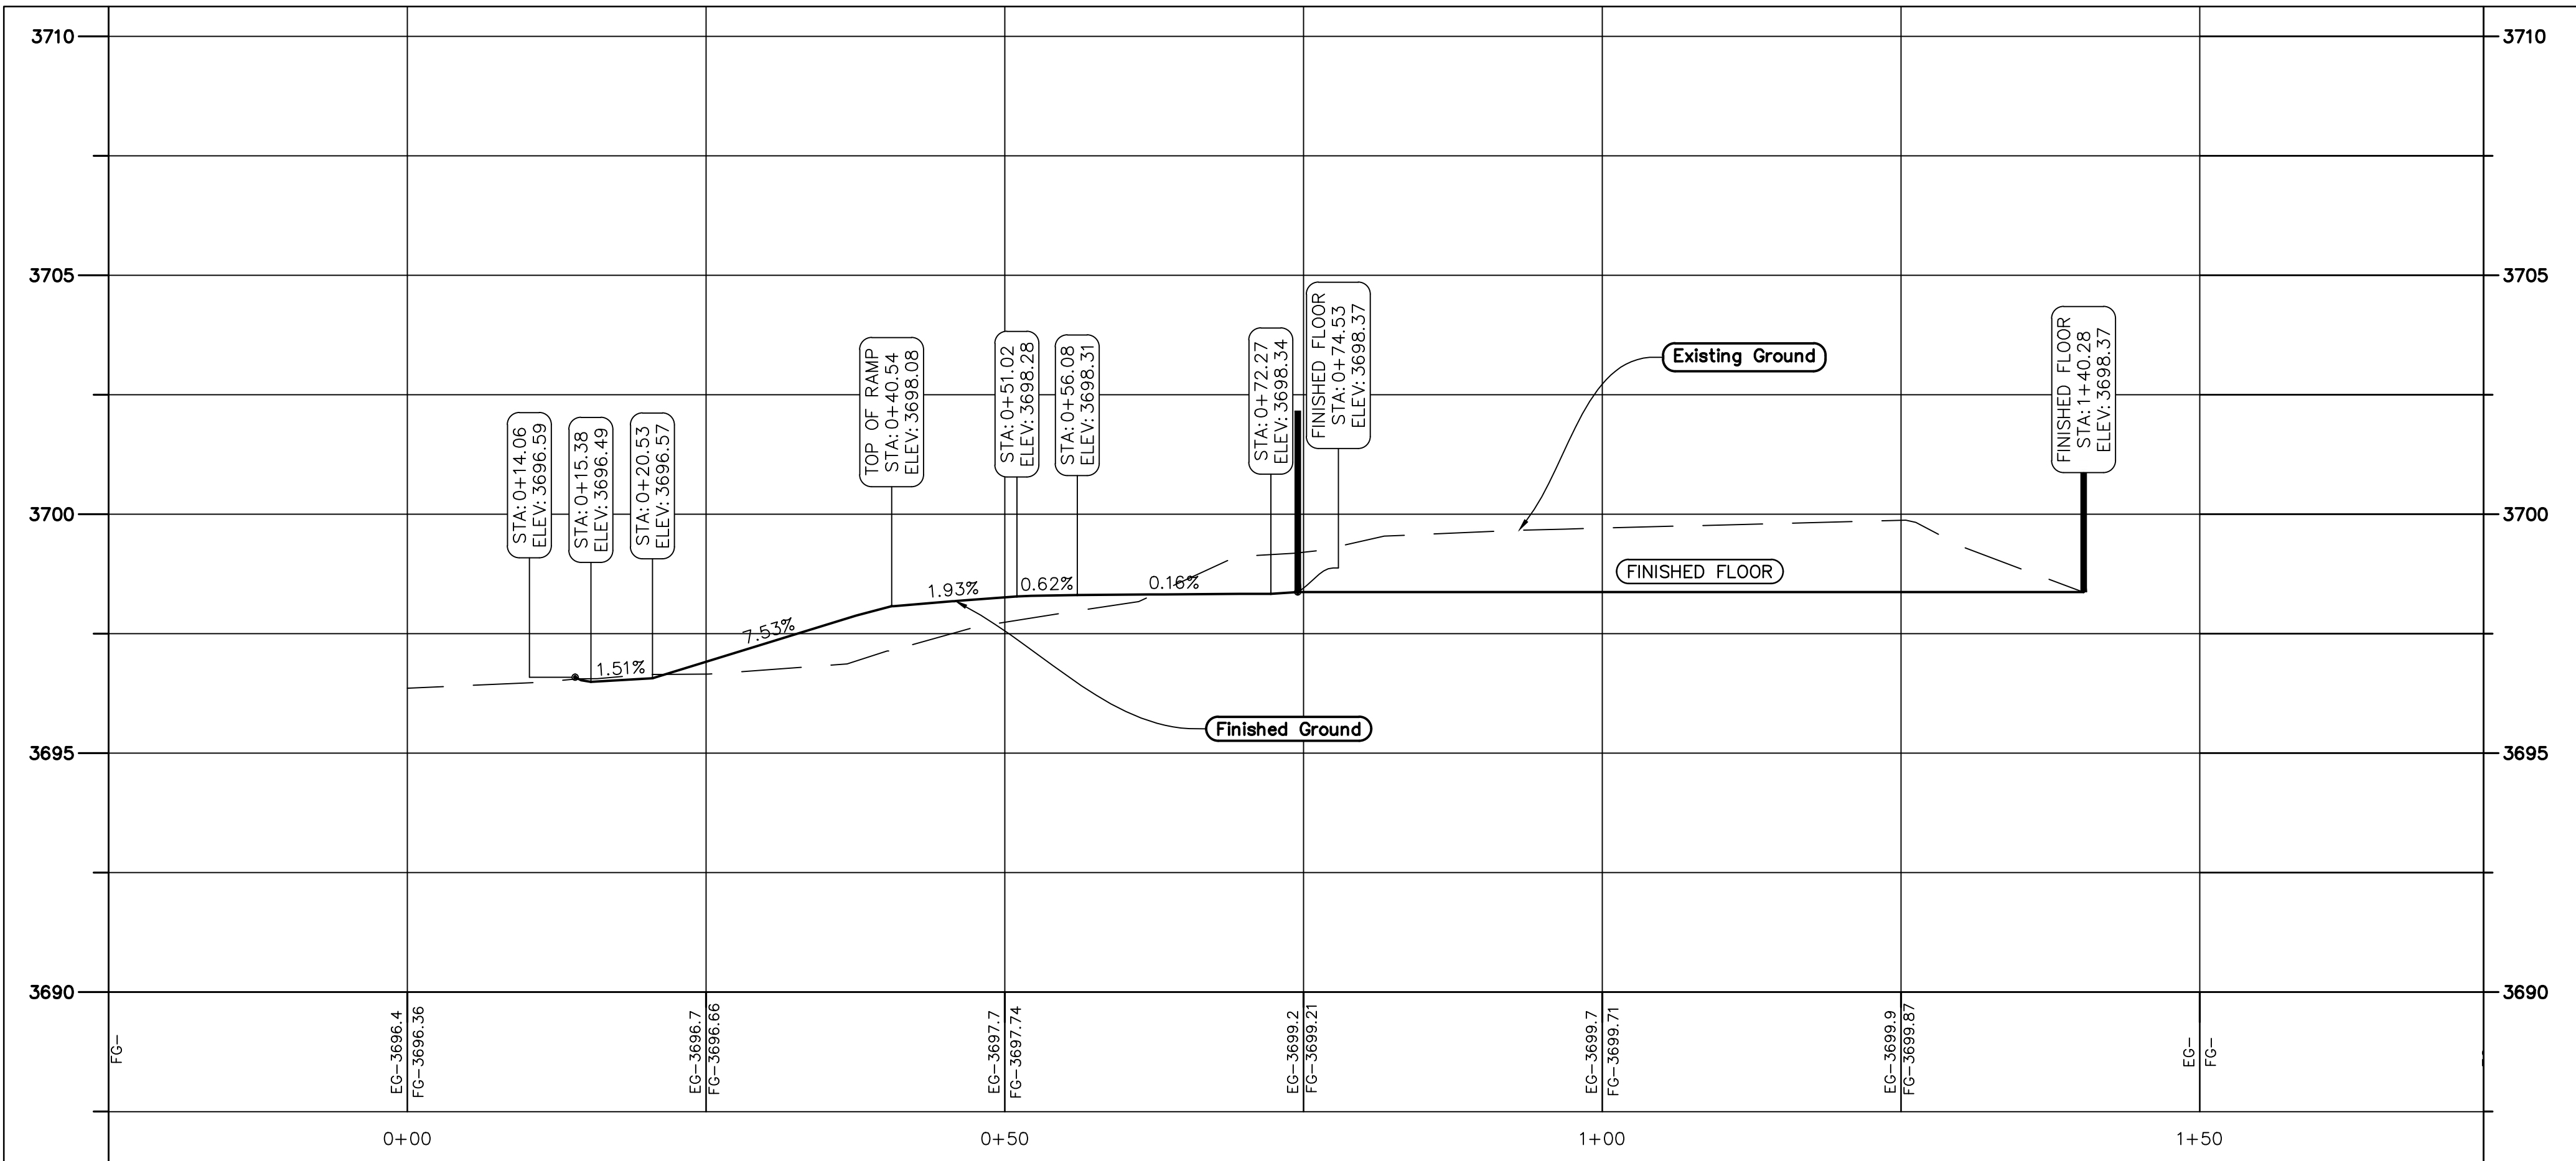

(24"x36")
HORIZONTAL 1" = 10'
VERTICAL 1" = 2.5'

(11"x17")
HORIZONTAL 1" = 20'
VERTICAL 1" = 5'


B.E.L. JOB NO. 10-111

RODERICK ENGINEERING L.L.C.

CIVIL & STRUCTURAL ENGINEERS
6859 E. REMBRANDT AVE. SUITE 124
MESA, AZ 85212
PH 480-926-6333
FAX 480-926-3999

6350 N. CAMINO DE LA TIERRA SUITE 140
TUCSON, AZ 85741
PH 520-887-9416
FAX 520-887-9486

STATE OF TEXA
JEFF L. WIMMER
106617
LICENSED PROFESSIONAL ENGINEER
7-15-2011

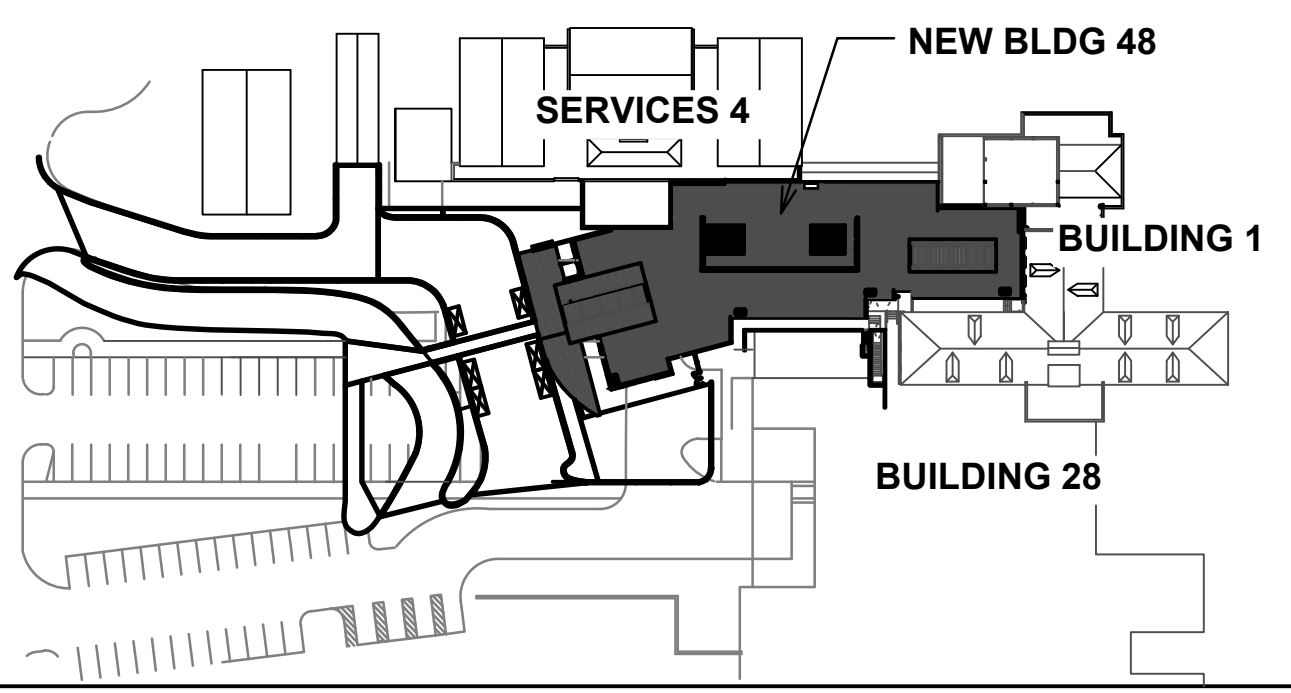

ARCHITECT OF RECORD:

SBB Architecture + Planning
1001 North Alvarado Way # 105, Tucson, Arizona 85711
T: 520.620.0255 F: 520.620.0535 E: sbb@sbbatc.com



EMERGENCY DEPARTMENT
AMARILLO VA HEALTH CARE SYSTEM
AMARILLO, TEXAS

Approved: VA Area Proj. Mgr.

V.A. PROJECT NO: VA258-P-0196
SBBL PROJECT NO:1010
DRAWN BY: MPZ
CHECKED BY: JLW
DATE: 07/15/2011

Δ	Date	Revision

Approved: Med. Ctr. Director

Approved: Asst. Admin Engineering Service

Approved: Asst. VA Medical Director

Approved: Chief of Facilities

Approved: Chief of Engineering

Approved: Chief of Projects

CIVIL PLAN
GRADING
SECTIONS