




ELECTRICAL LEVEL 1 FLOOR PLAN

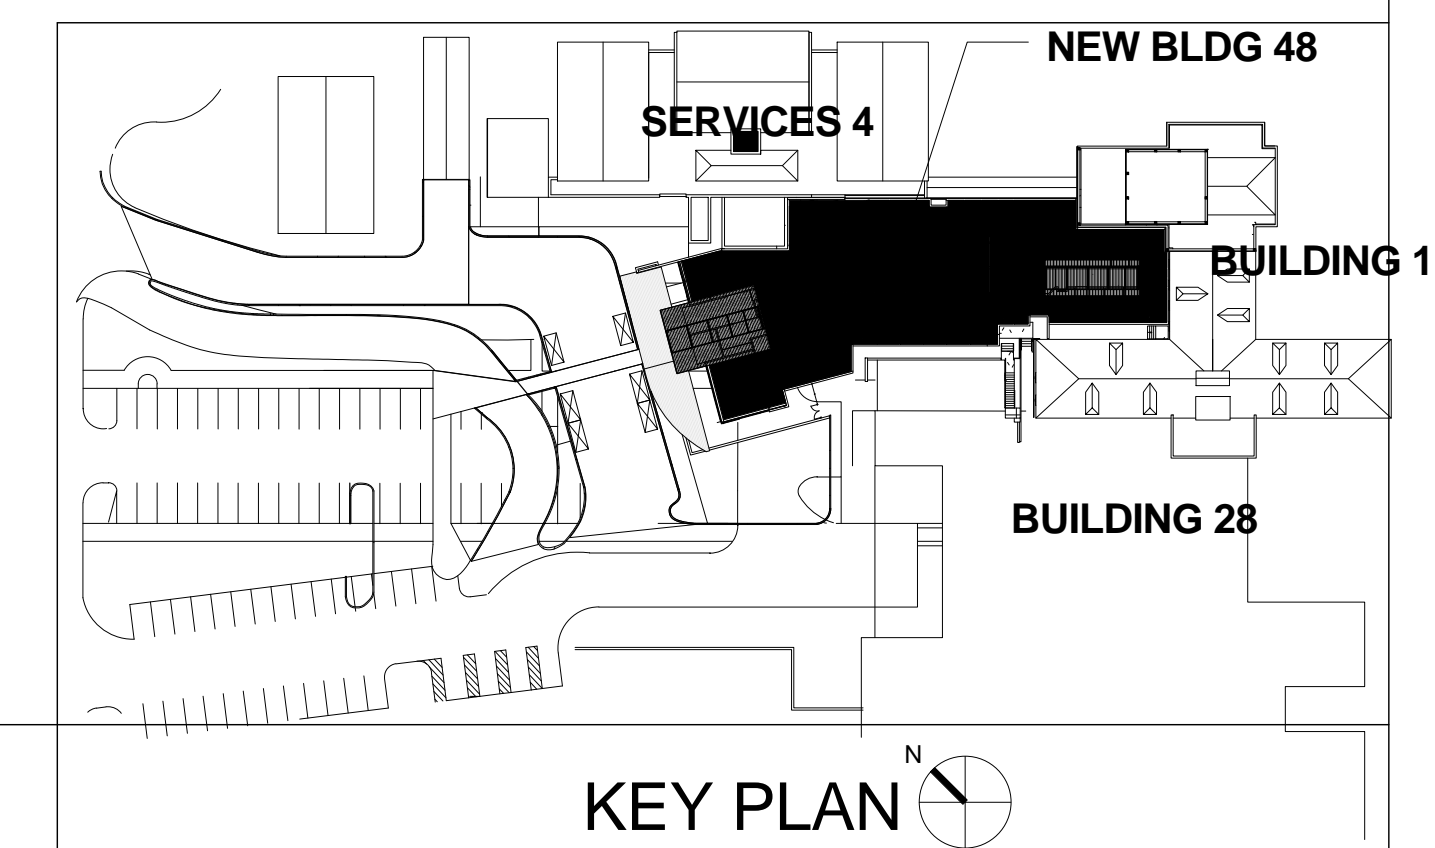

EMERGENCY DEPARTMENT	AMARILLO VA HEALTH CARE SYSTEM AMARILLO, TEXAS
Approved: VA Area Proj. Mgr.	
V.A. PROJECT NO: SBBIL PROJECT NO: DRAWN BY: CHECKED BY:	VA258-P-0196 0110.00.0 Author Checker
DATE: 07/15/11	

[illegible]

48-ES2.1