

Measures one inch
or not to scale!

CUSTOM VA FORM 08-6231B
MAY 2010

Approved: VHSO Director

Approved: Service Chief

Drawing Title
LAUNDRY AND SHOPS/ BASEMENT

Location
FAYETTEVILLE, AR

Drawn
Scale:
Date
NTS 21 JULY 2016

Project Number
564-16-118

Building Number
BLDG 9

Drawing Number
E101

Sheet
1 of 3

Engineering
Service


VETERANS HEALTH CARE SYSTEM
OF THE OZARKS

BUILDING 9 BASEMENT

BUILDING 34 STORAGE

**BUILDING 11 BASEMENT
ELECTRICAL ROOM**

BUILDING 10 BOILER PLANT

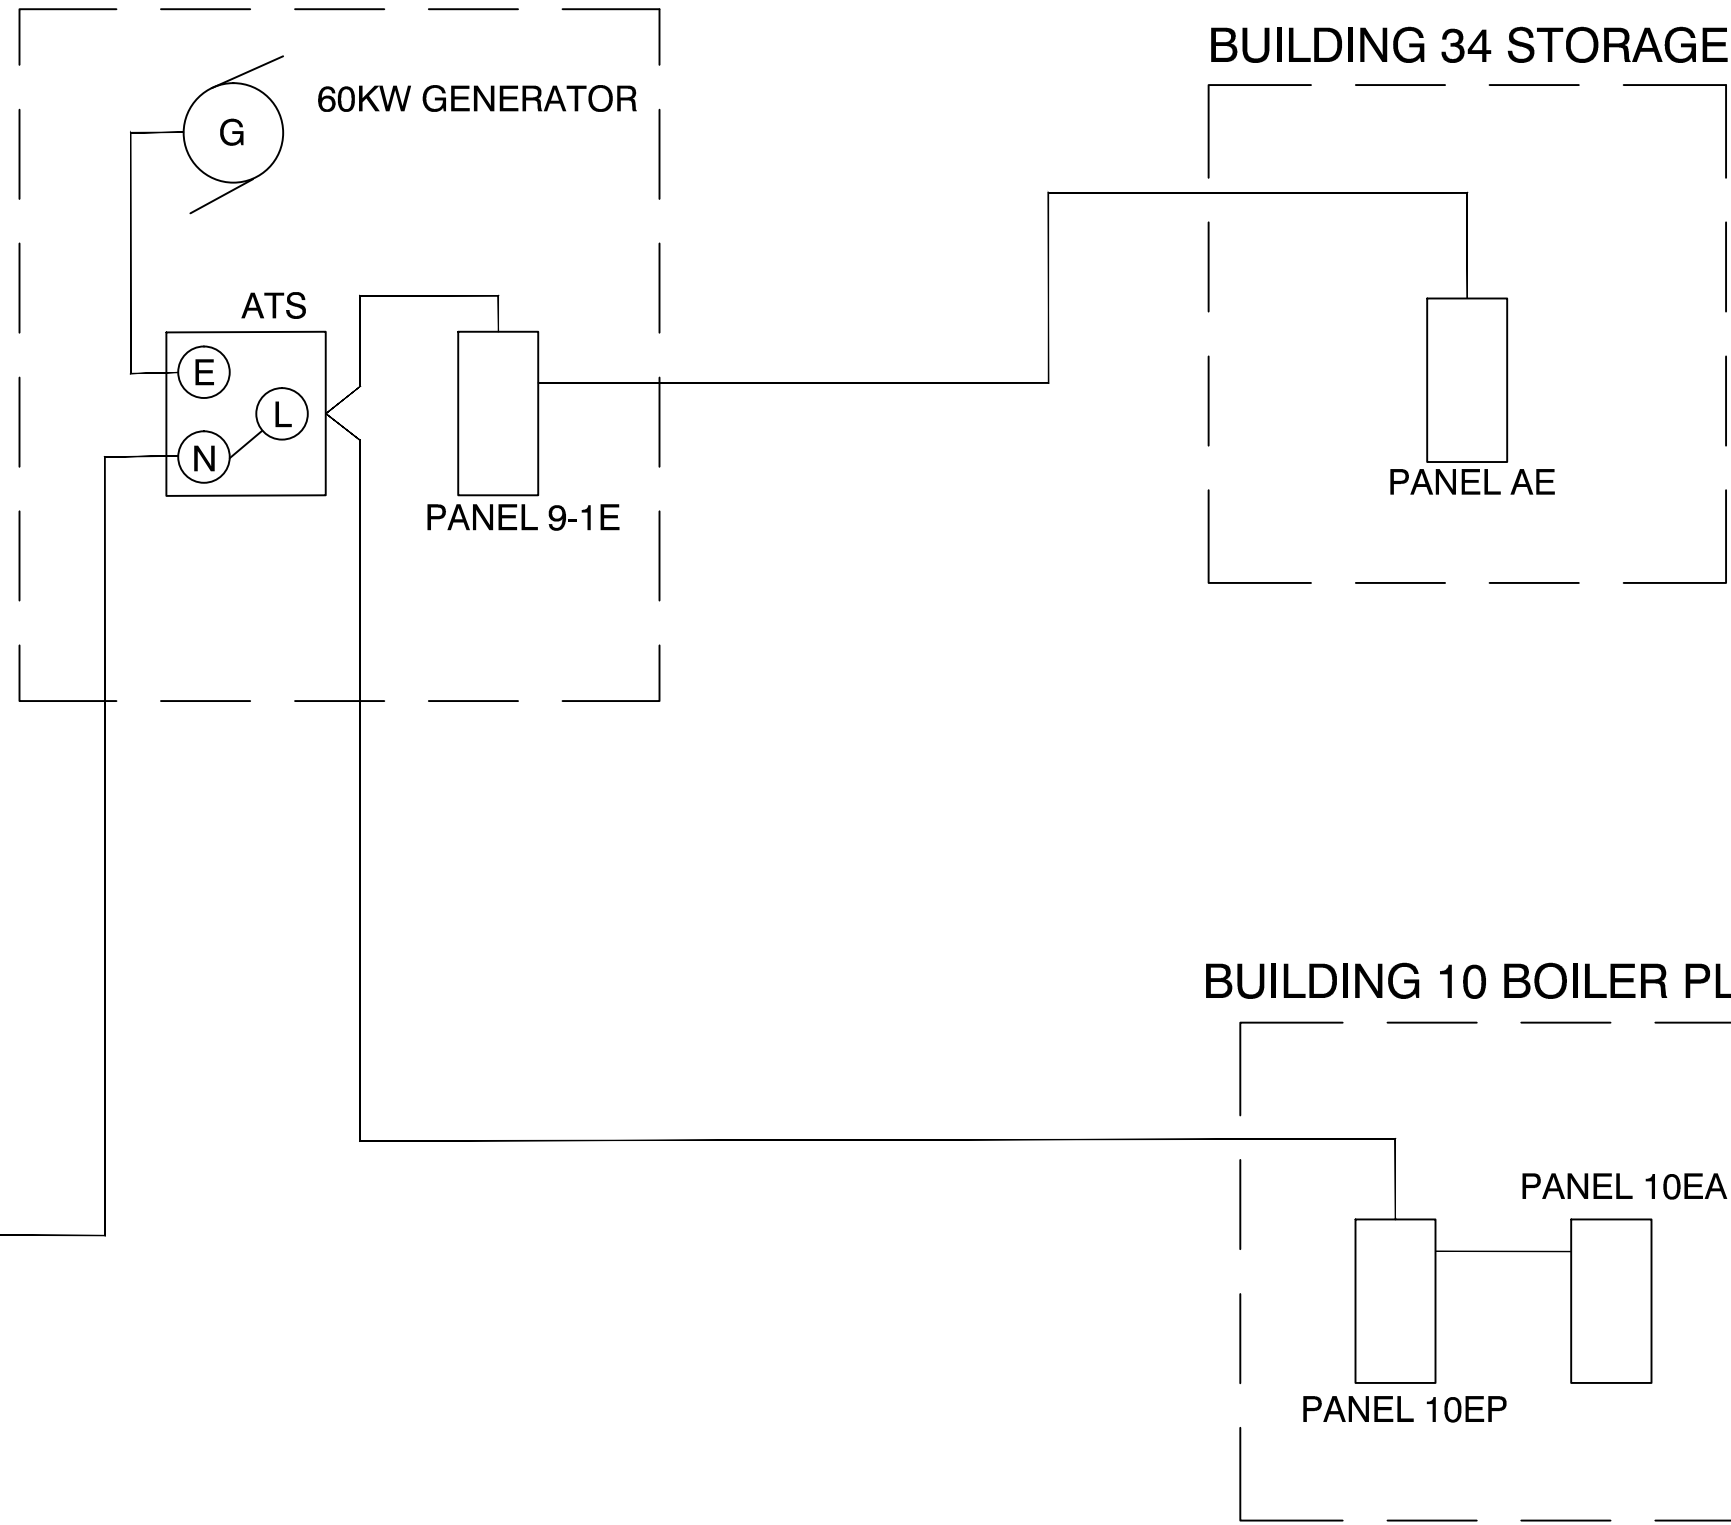

Measures one inch
or not to scale!



CUSTOM VA FORM 08-6231B
MAY 2010

Approved: VHSO Director

Approved: Service Chief

Drawing Title
**EXISTING ELECTRICAL SYSTEM
ONE LINE DIAGRAM**

Location
FAYETTEVILLE, AR

Drawn: _____ Scale: **NTS** Date: **21 JULY 2016**

Project Number
564-16-118


Building Number
BLDG 9

Drawing Number
E101

Sheet **2 of 3**

Engineering
Service



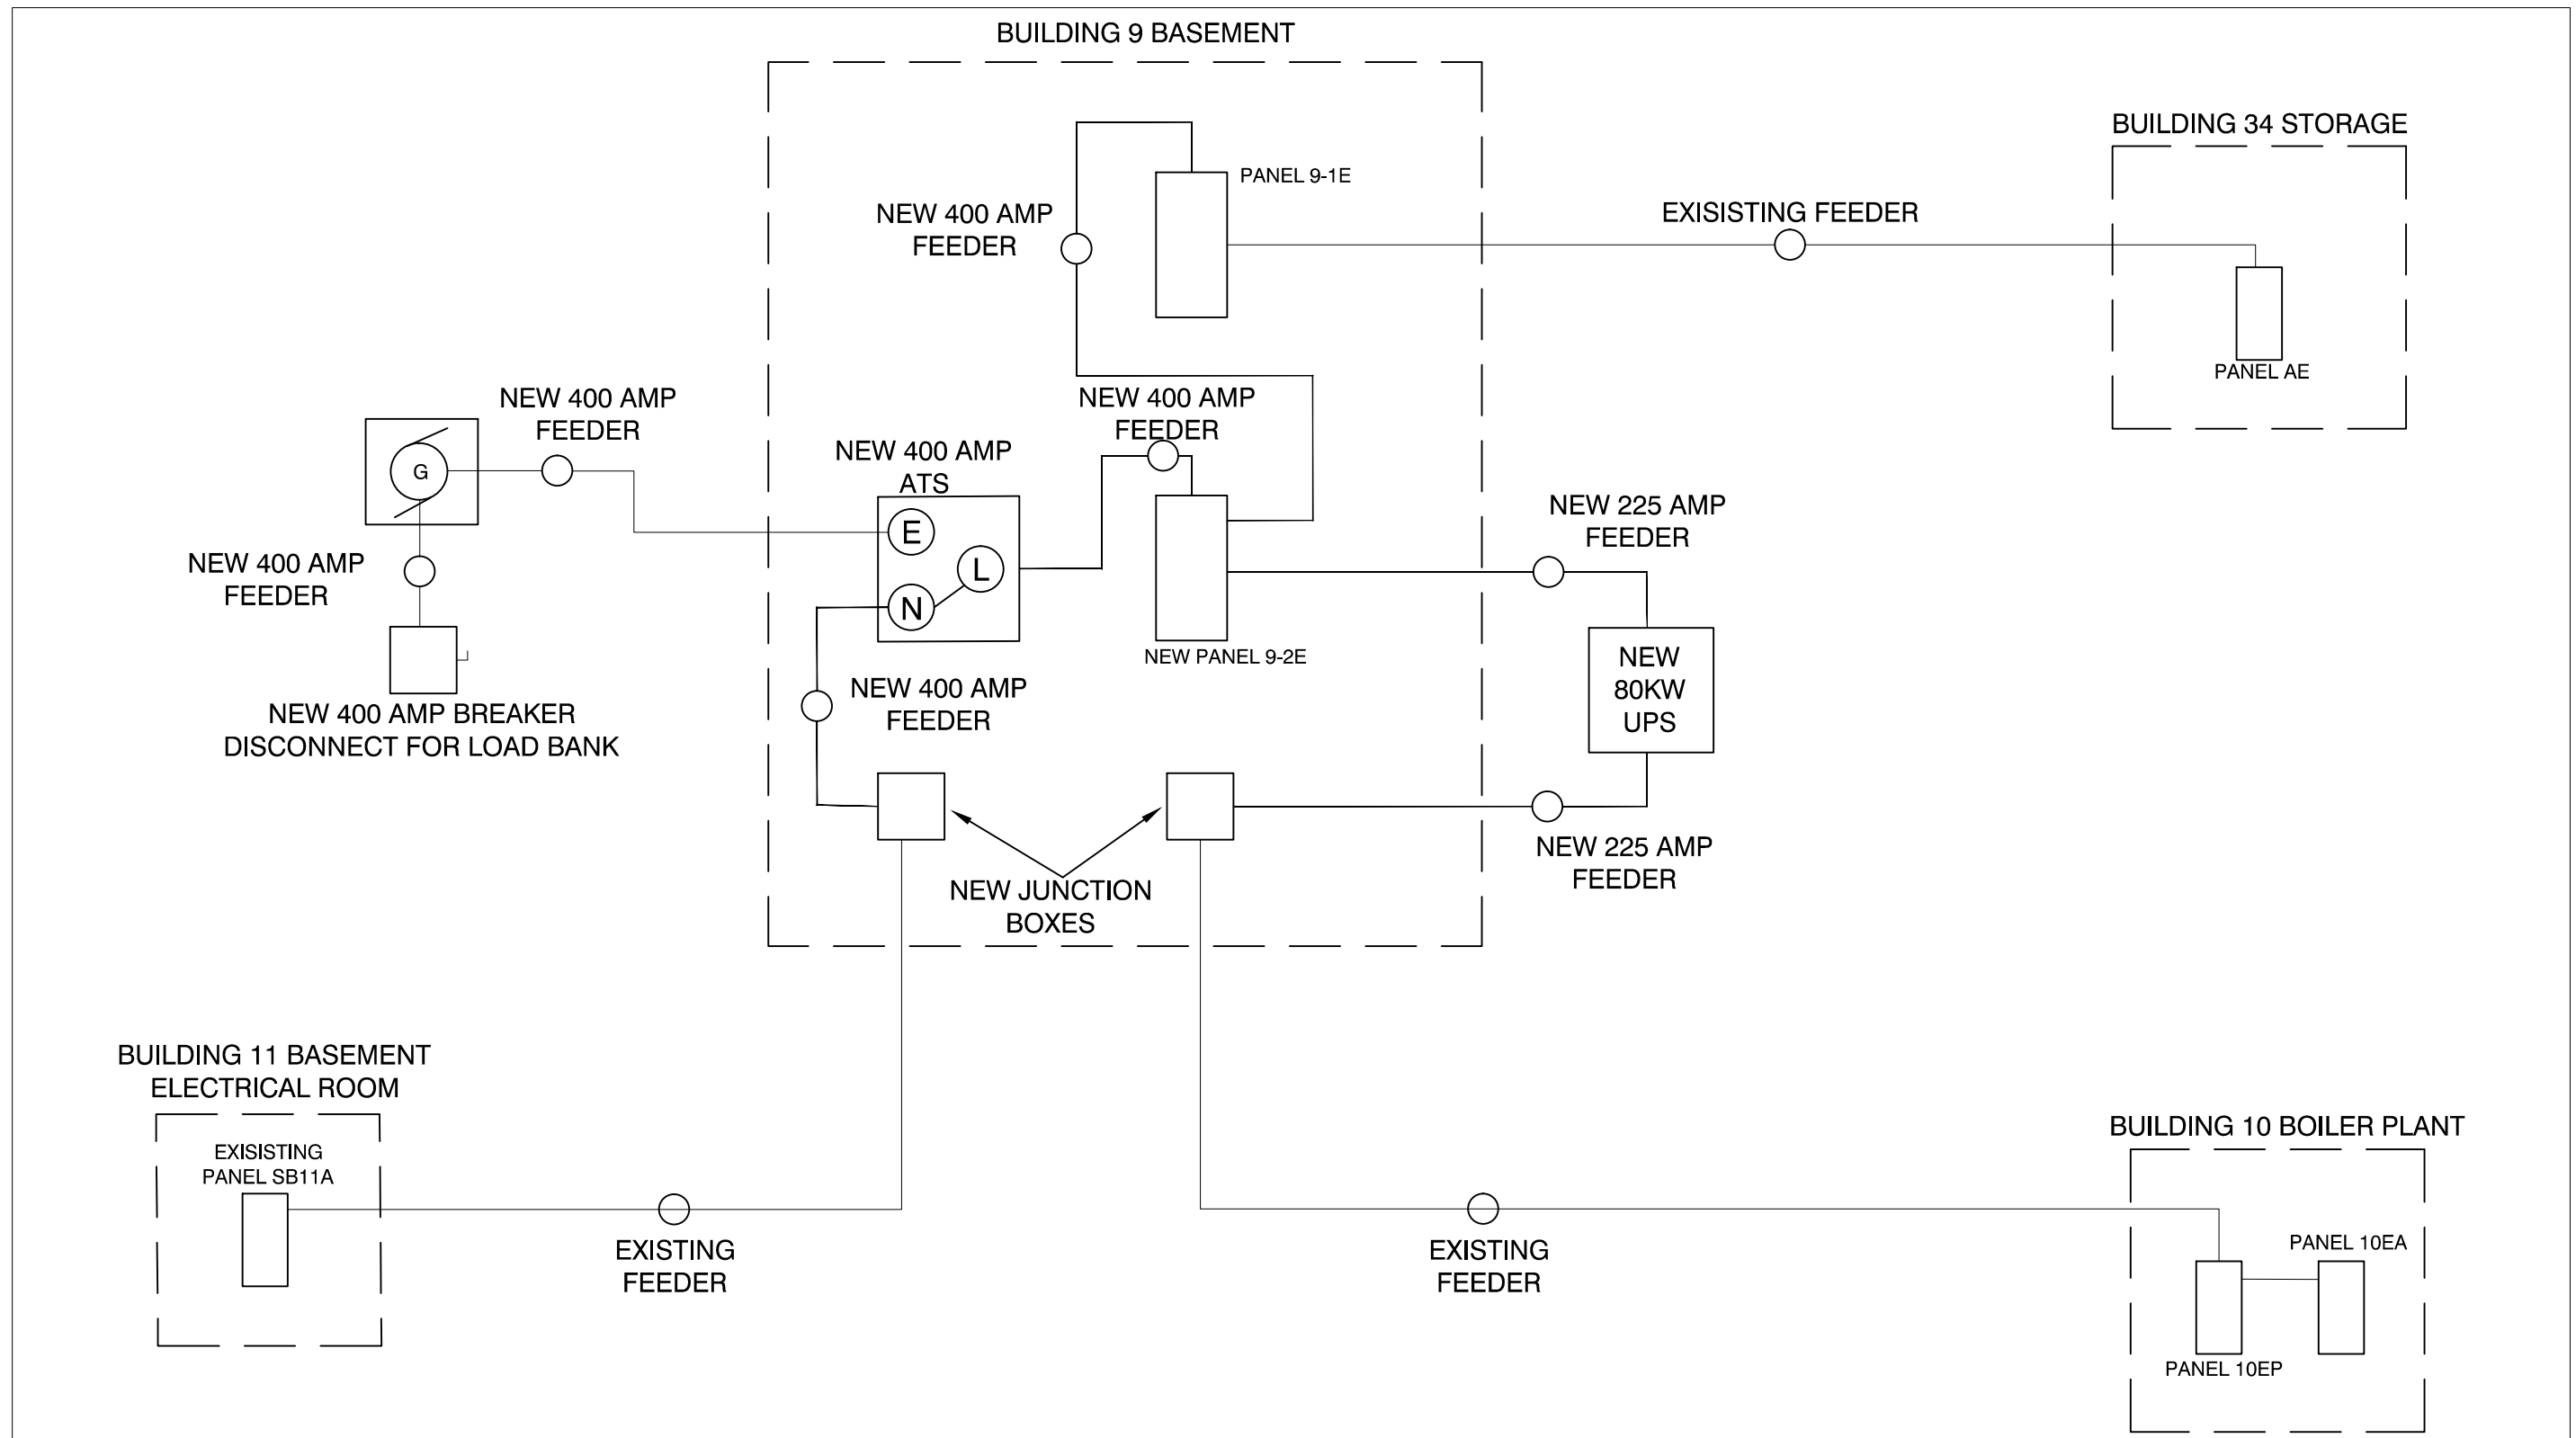

Measures one inch
or not to scale!



CUSTOM VA FORM 08-6231B
MAY 2010

Approved: VHSO Director

Approved: Service Chief

Drawing Title

NEW ELECTRICAL SYSTEM
ONE LINE DIAGRAM

Location

FAYETTEVILLE, AR

Drawn

Scale:

NTS

Date

21 JULY 2016

Project Number

564-16-118

Building Number

BLDG 9

Drawing Number

E101

Sheet

3 of 3

Engineering
Service



VETERANS HEALTH CARE SYSTEM
OF THE OZARKS