
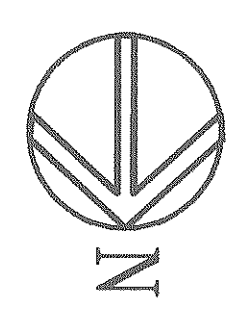


**KEYED NOTES:**  
 ① TO KELTRON SECURITY SYSTEM TERMINAL  
 IN FIRE ALARM CONTROL PANEL.

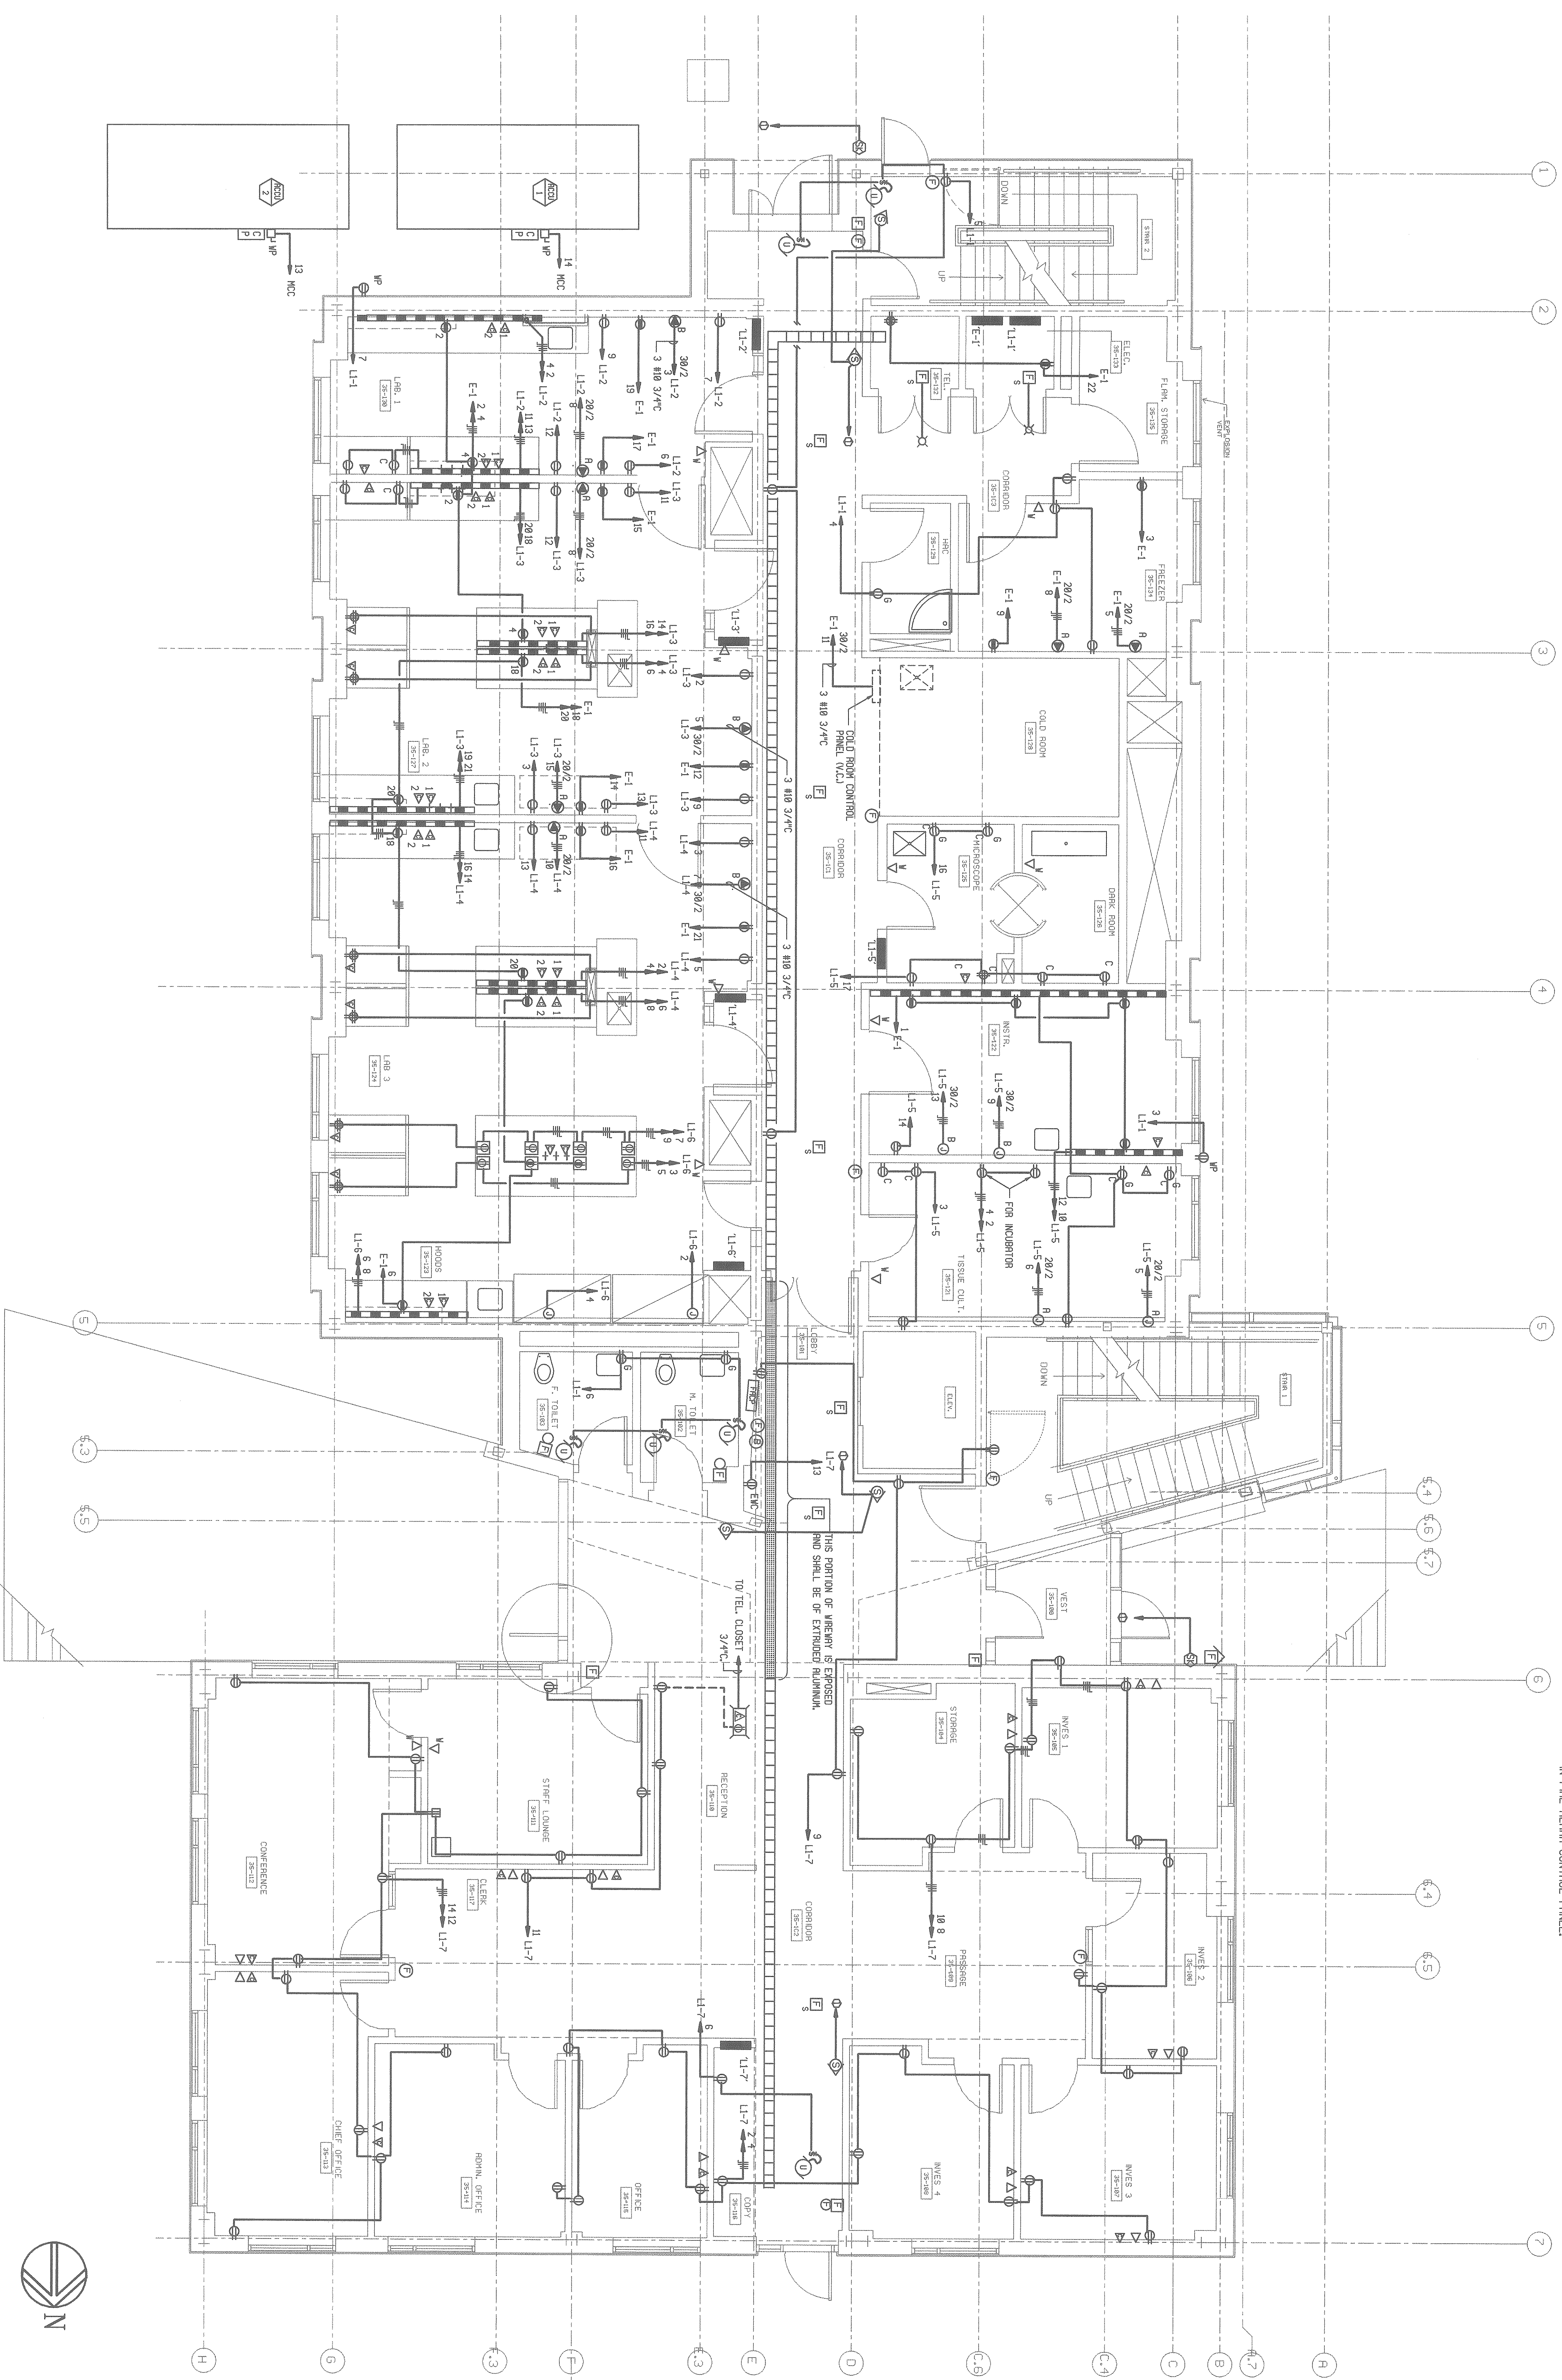

REVISION	Date

NOTES:

Stamp  
 RAYMOND P. JARVIS  
 REGISTERED PROFESSIONAL ENGINEER  
 No. 457  
 5/17/95

**Rothenman**  
 Heilmann  
 771 Atlantic Avenue  
 Boston, MA 02111  
 (617) 461-6990  
 (617) 423-3945 FAX

Planning, Mechanical  
 Electrical, and  
 Instrumentation  
 TROSPER CONSULTANTS INC.  
 525 Hill Street  
 Norwin, MA 02728

Structural Consultants  
 CAROL R. JOHNSON RESCORLA INC.  
 777 Massachusetts Avenue  
 Cambridge, MA 02138

Drawing Title  
**FIRST FLOOR PLAN  
 POWER & SIGNAL**

Prepared by: *[Signature]*  
 Checked by: *[Signature]*  
 Drawn by: *[Signature]*  
 Date: 5/17/95

Project Title  
**CONSTRUCT  
 RESEARCH BUILDING**

Building Number: 35  
 Location: PROVIDENCE, RI

Date: 15 MAY 1995  
 Project No.: 650-067  
 Drawing No.: **35 E-9**  
 Dwg. 9<sup>th</sup> of 19

