



GENERAL NOTES

1. EXISTING DATA CABLE IS COILED IN CLOSET OF BUILDING #17. THIS CONTRACTOR TO PULL THE CABLE OUT TO EXISTING DATA HANDHOLE & REINSTALL TO NEW RESEARCH BUILDING.

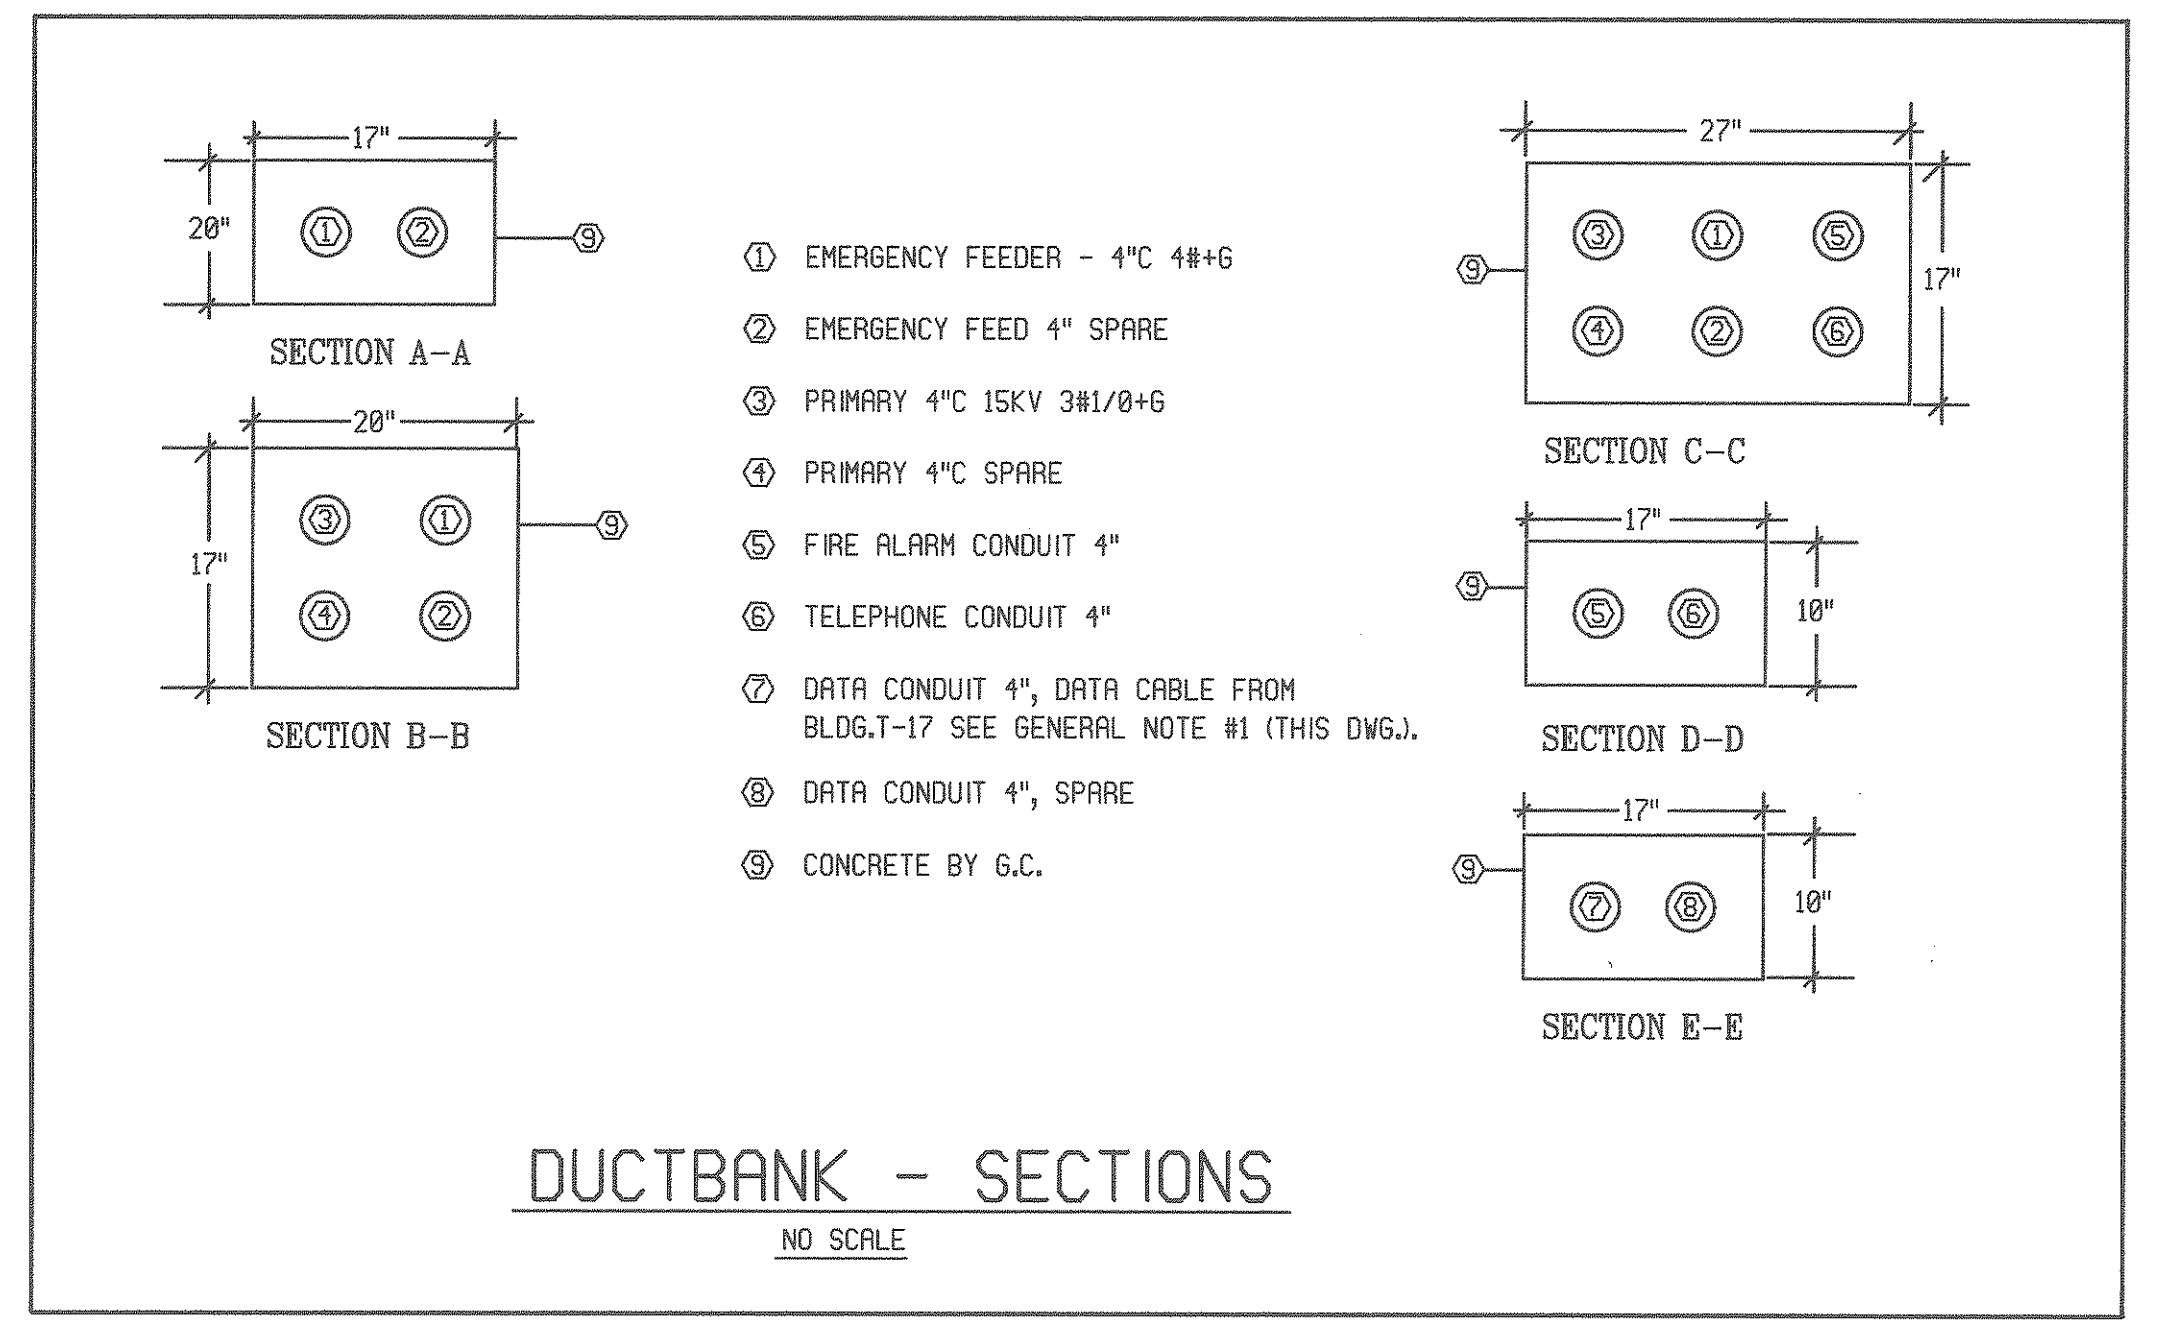

Revision	Date

NOTES:

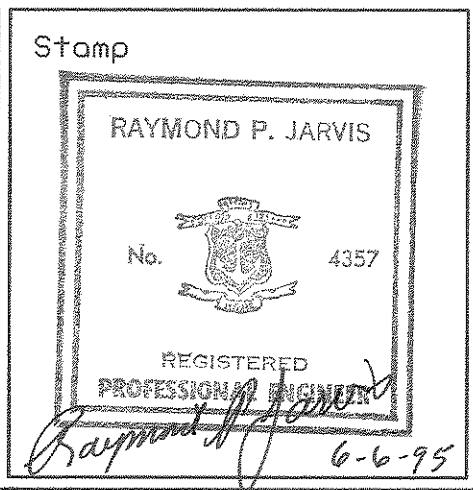

Rothman
Rothman
Heinemann ARCHITECTS INC.
 711 Atlantic Avenue
 Boston MA 02111
 (617) 451 6990
 (617) 423 3946 FAX

Plumbing, Mechanical,
 and Electrical Consultants
THOMPSON CONSULTANTS INC.
 525 Hill Street
 Marion MA 02738

Cost Consultants
VERHEULENS, INC.
 181 Federal Street, Suite 1908
 Boston MA 02189

Structural Consultants
LIN CONSULTANTS, INC.
 727 Massachusetts Avenue
 Cambridge MA 02138

Landscape Architect
CHARL R. JOHNSON ASSOC., INC.
 1108 Massachusetts Avenue
 Cambridge MA 02138

Drawing Title
ELECTRICAL
SITE PLAN
 Approved Safety Manager
 Approved Project Engineer
 Approved Chief, Eng. Svc.

Project Title
CONSTRUCT
RESEARCH BUILDING

Building Number	Checked	Drawn	Scale
35	R.E.L.	D.P.	1"=20'-0"

Location **PROVIDENCE, RI**

Date
 15 MAY 1995

Project No.
 650-067

Drawing No.
35 E-5
 Dwg. 5 of 17

