




19	BULL 015G - VE	10/15/2013
15	BULL 015B - PRE-AWARD	08/20/2013
REVISIONS:		
		DATE

CONSULTANTS:
DESMAN ASSOCIATES / PARKING
CODE CONSULTANTS, INC. / CODE CONSULTANT
THE SEXTANT GROUP / AV & ACOUSTICAL
HAMMER DESIGN ASSOCIATES / FOOD SERVICE
PYBURN & ODOM / ADA/STATEMENT
TATA & HOWARD / TANK CONSULTANT
I.S.C. GROUP, INC. / IRRIGATION
DAN EUSER WATER ARCHITECTURE, INC. / WATER FEATURE

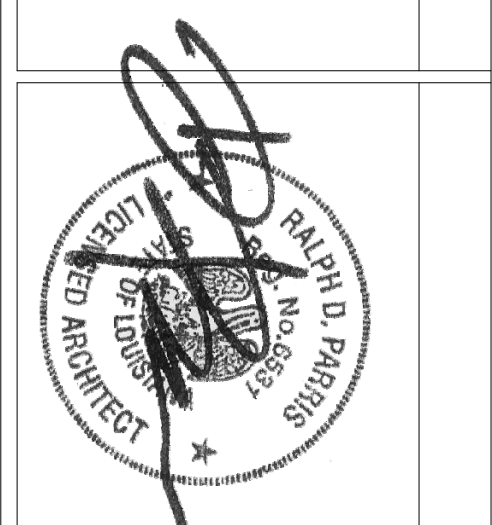

ARCHITECT/ENGINEERS:
studio NOVA
SCHRECK & PETERSON CONSULTING ENGINEERS / CIVIL
KORDANEMETH ENGINEERING / STRUCTURAL
BRA CONSULTING ENGINEERS / MECH. ELECT. PLUMBING, LOW VOLTAGE
ARCHITECTURAL ENGINEERING / PLUMBING
SCALES ASSOCIATES / FIRE PROTECTION

DRAWING TITLE
BLDG 2 OVERALL THIRD FLOOR PLAN

PROJECT TITLE
SLYVCS REPLACEMENT MEDICAL
CENTER PROJECT

LOCATION
NEW ORLEANS, LOUISIANA

DATE
February 29, 2012

CHECKED
MIL

DRAWN
AGIDMK

PROJECT NUMBER
629-HS2-401

DOCUMENT SET PACKAGE
WP_08

BUILDING NUMBER
2A1103


OFFICE OF
CONSTRUCTION
AND FACILITIES
MANAGEMENT




REFER TO THE FOLLOWING SKETCH FOR CHANGES:
SK-8-4-NJ 2A1003

SEE RFI 03824 FOR CONTROL JOINT LOCATION


MATCH LINES AND/OR MATCHLINE TAGS
REMOVED THIS SHEET

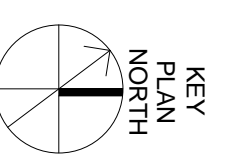

CONSTRUCTION DOCUMENTS 1

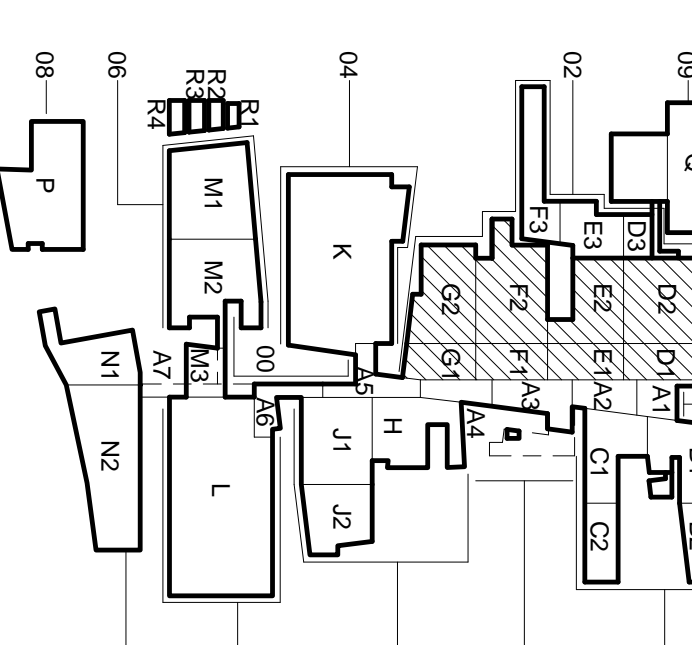

1 BLDG 2 OVERALL THIRD FLOOR PLAN
SCALE: 1/16" = 1'-0"

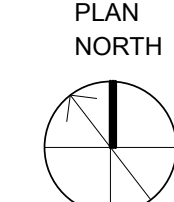

GENERAL NOTES
GNI1 REFER TO EMBR BULL 010C FOR CM AT CONNECTIONS.
GLAZING HEADSILL HEIGHTS VARY & MAY NOT APPEAR
IN PLAN VIEW DUE TO CUTTING PLANE.
WPS 01B L17 GA MTL FRAMING CONTRACTOR TO
COORDINATE W/ EMBR CM CONTRACTOR FOR FINAL
OPENING DIMENSIONS.
REFER TO WPS 01B PLANS FOR TYPICAL INTERIOR
DETAILS AT CONNECTOR OPENINGS.