





Department of
Veterans Affairs

GENERATOR FOR MRI-RADIOLOGY-LAB

VAMC LEBANON, PA
PROJECT No. 595-12-107

LIST OF DRAWINGS		
SHEET No	DWG No.	TITLE - SHEET DESCRIPTION
1	T-1	TITLE SHEET
2	GI-1	GENERAL NOTES
3	C-1	GENERATOR SITE PLAN
4	C-2	SITE DETAILS
5	A-1	GENERATOR BUILDING FOUNDATION AND FLOOR PLANS
6	A-2	GENERATOR SLAB ELEVATIONS
7	A-3	GENERATOR FOUNDATION SECTIONS AND DETAILS
8	A-4	ATS BUILDING PLANS, ELEVATIONS AND SECTION
9	P-1	GENERATOR GAS PIPING
10	E-1	ELECTRICAL GENERAL NOTES LEGEND AND ABBREVIATIONS
11	E-2	ELECTRICAL ONE-LINE DIAGRAM
12	E-3	GENERATOR BUILDING AND ATS BUILDING POWER AND LIGHTING PLANS
13	E-4	GENERATOR BUILDING AND ATS BUILDING COMMUNICATION AND GROUNDING PLANS
14	E-5	ELECTRICAL DETAILS 1 OF 2
15	E-6	ELECTRICAL DETAILS 2 OF 2
16	-	-
17		
18		
19		
20		
21		
22		
23		
24		
25		
26		
27		
28		

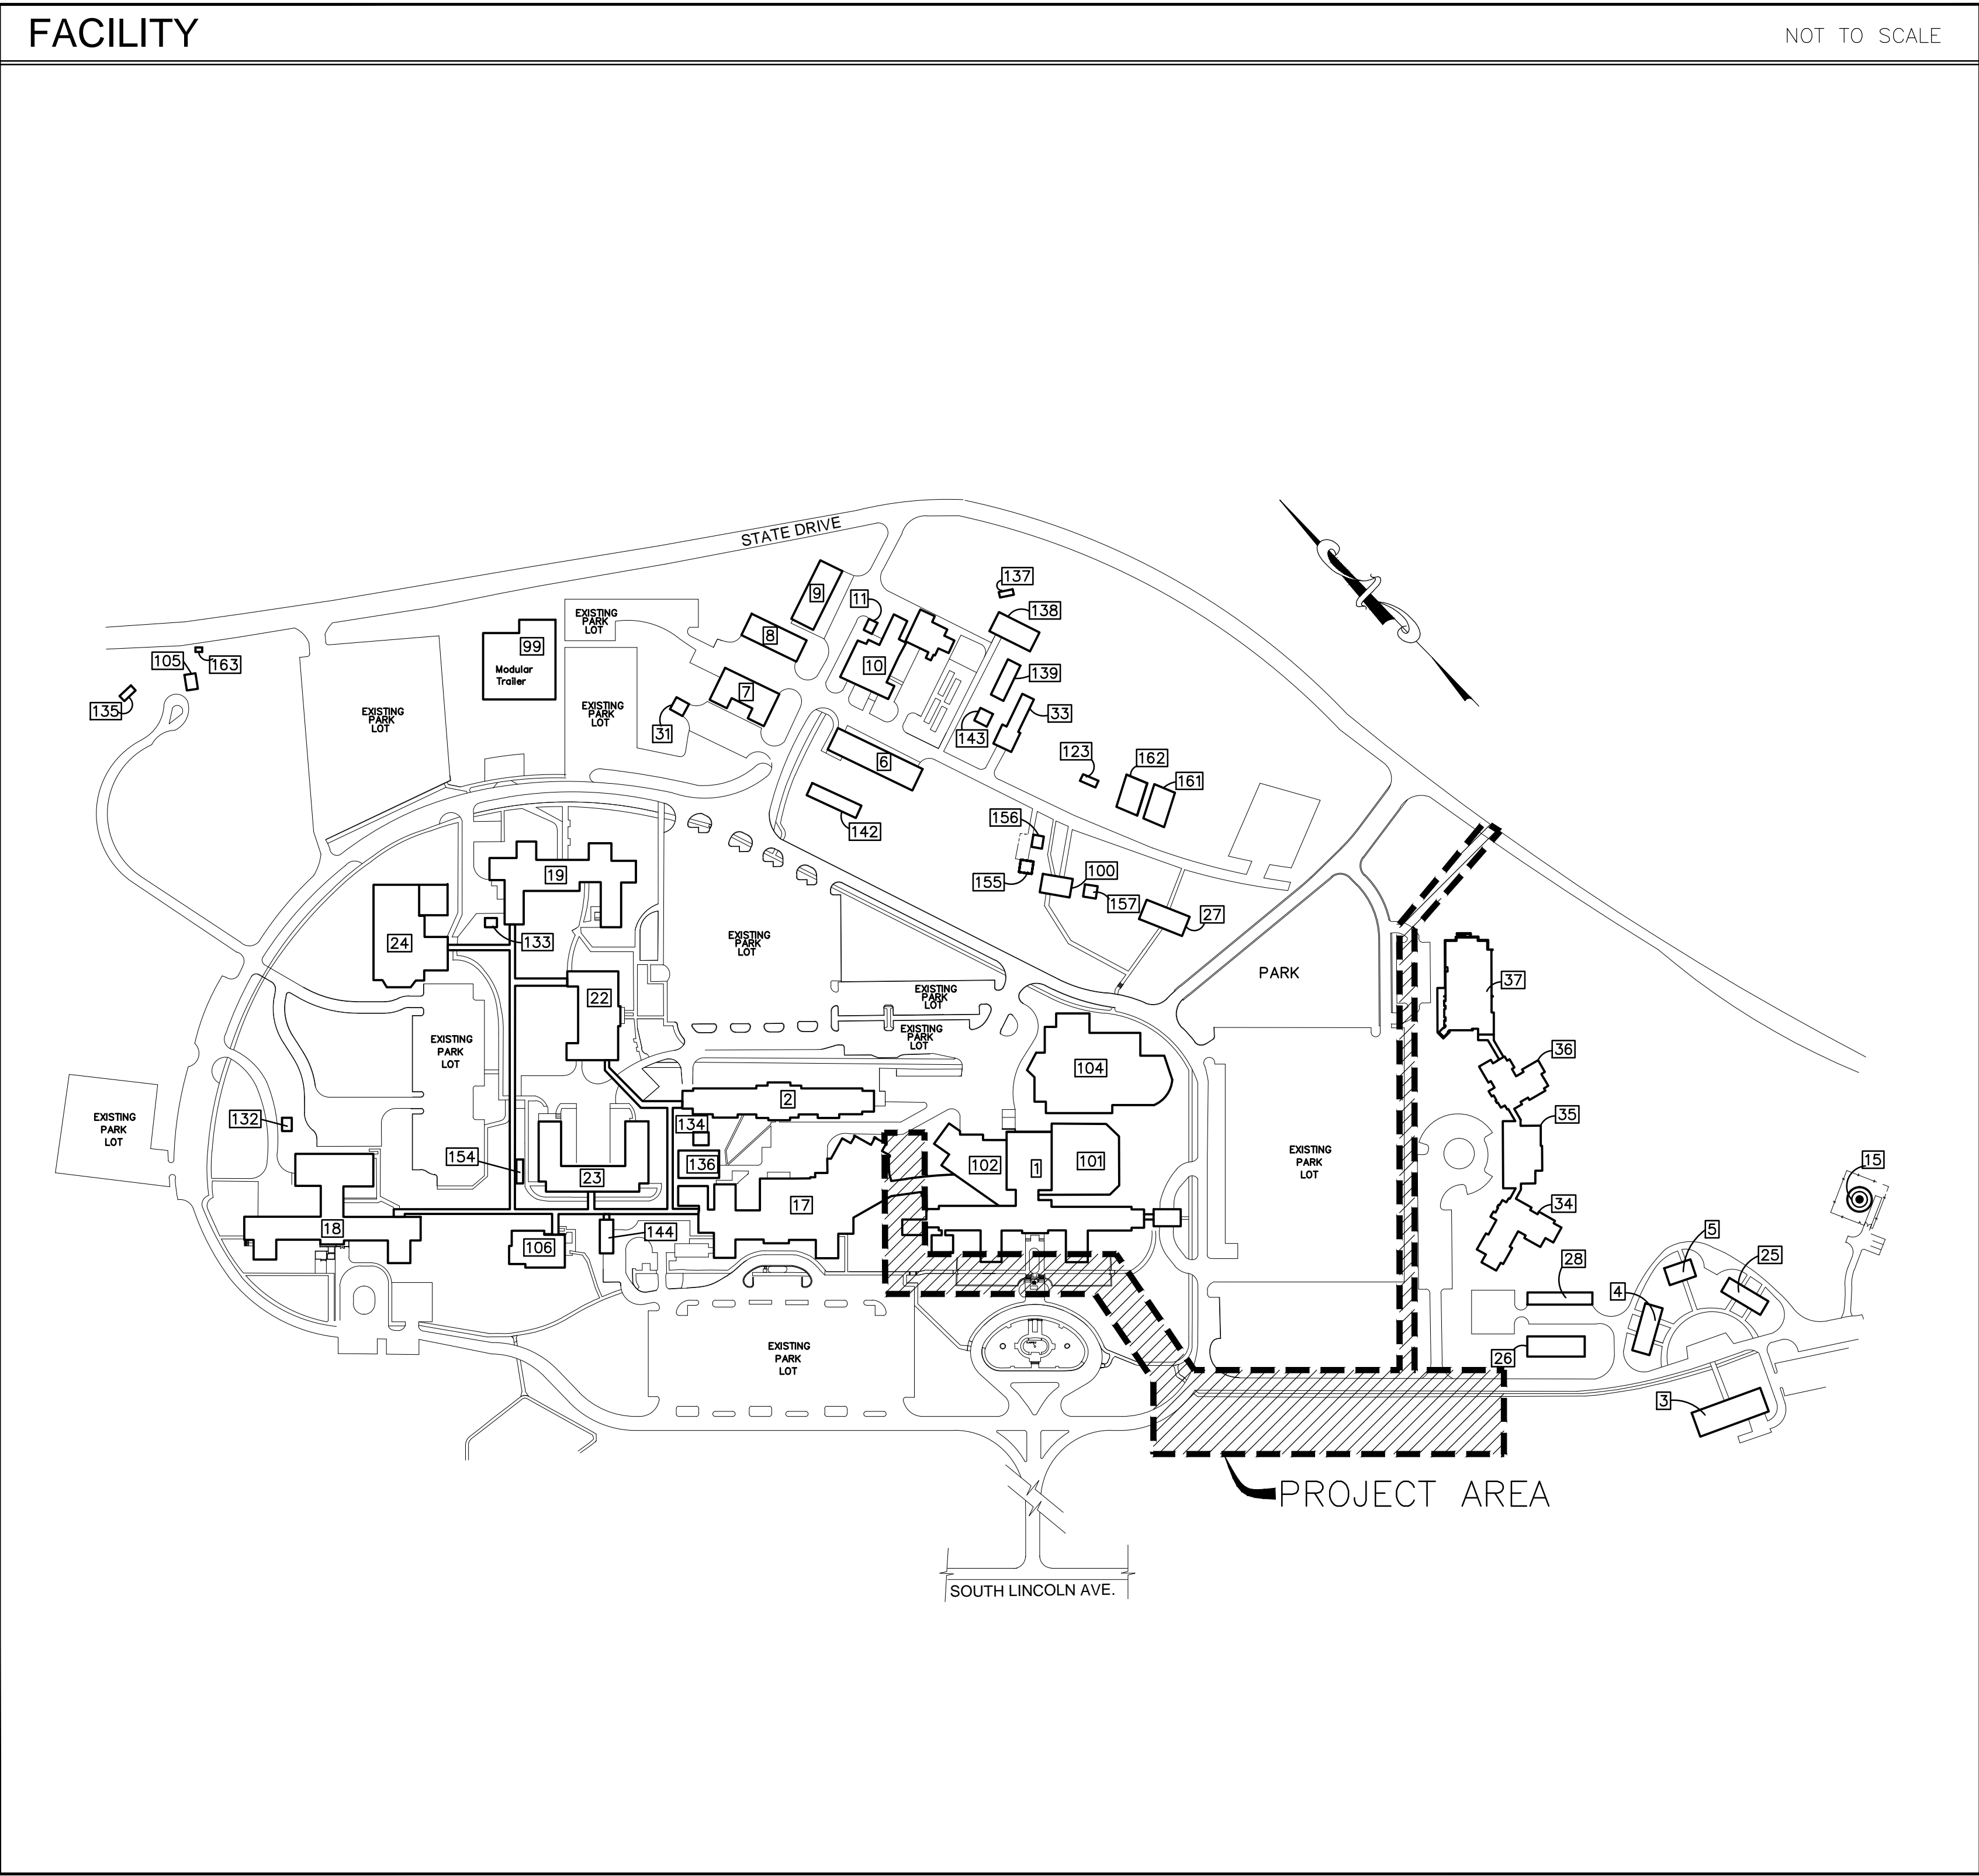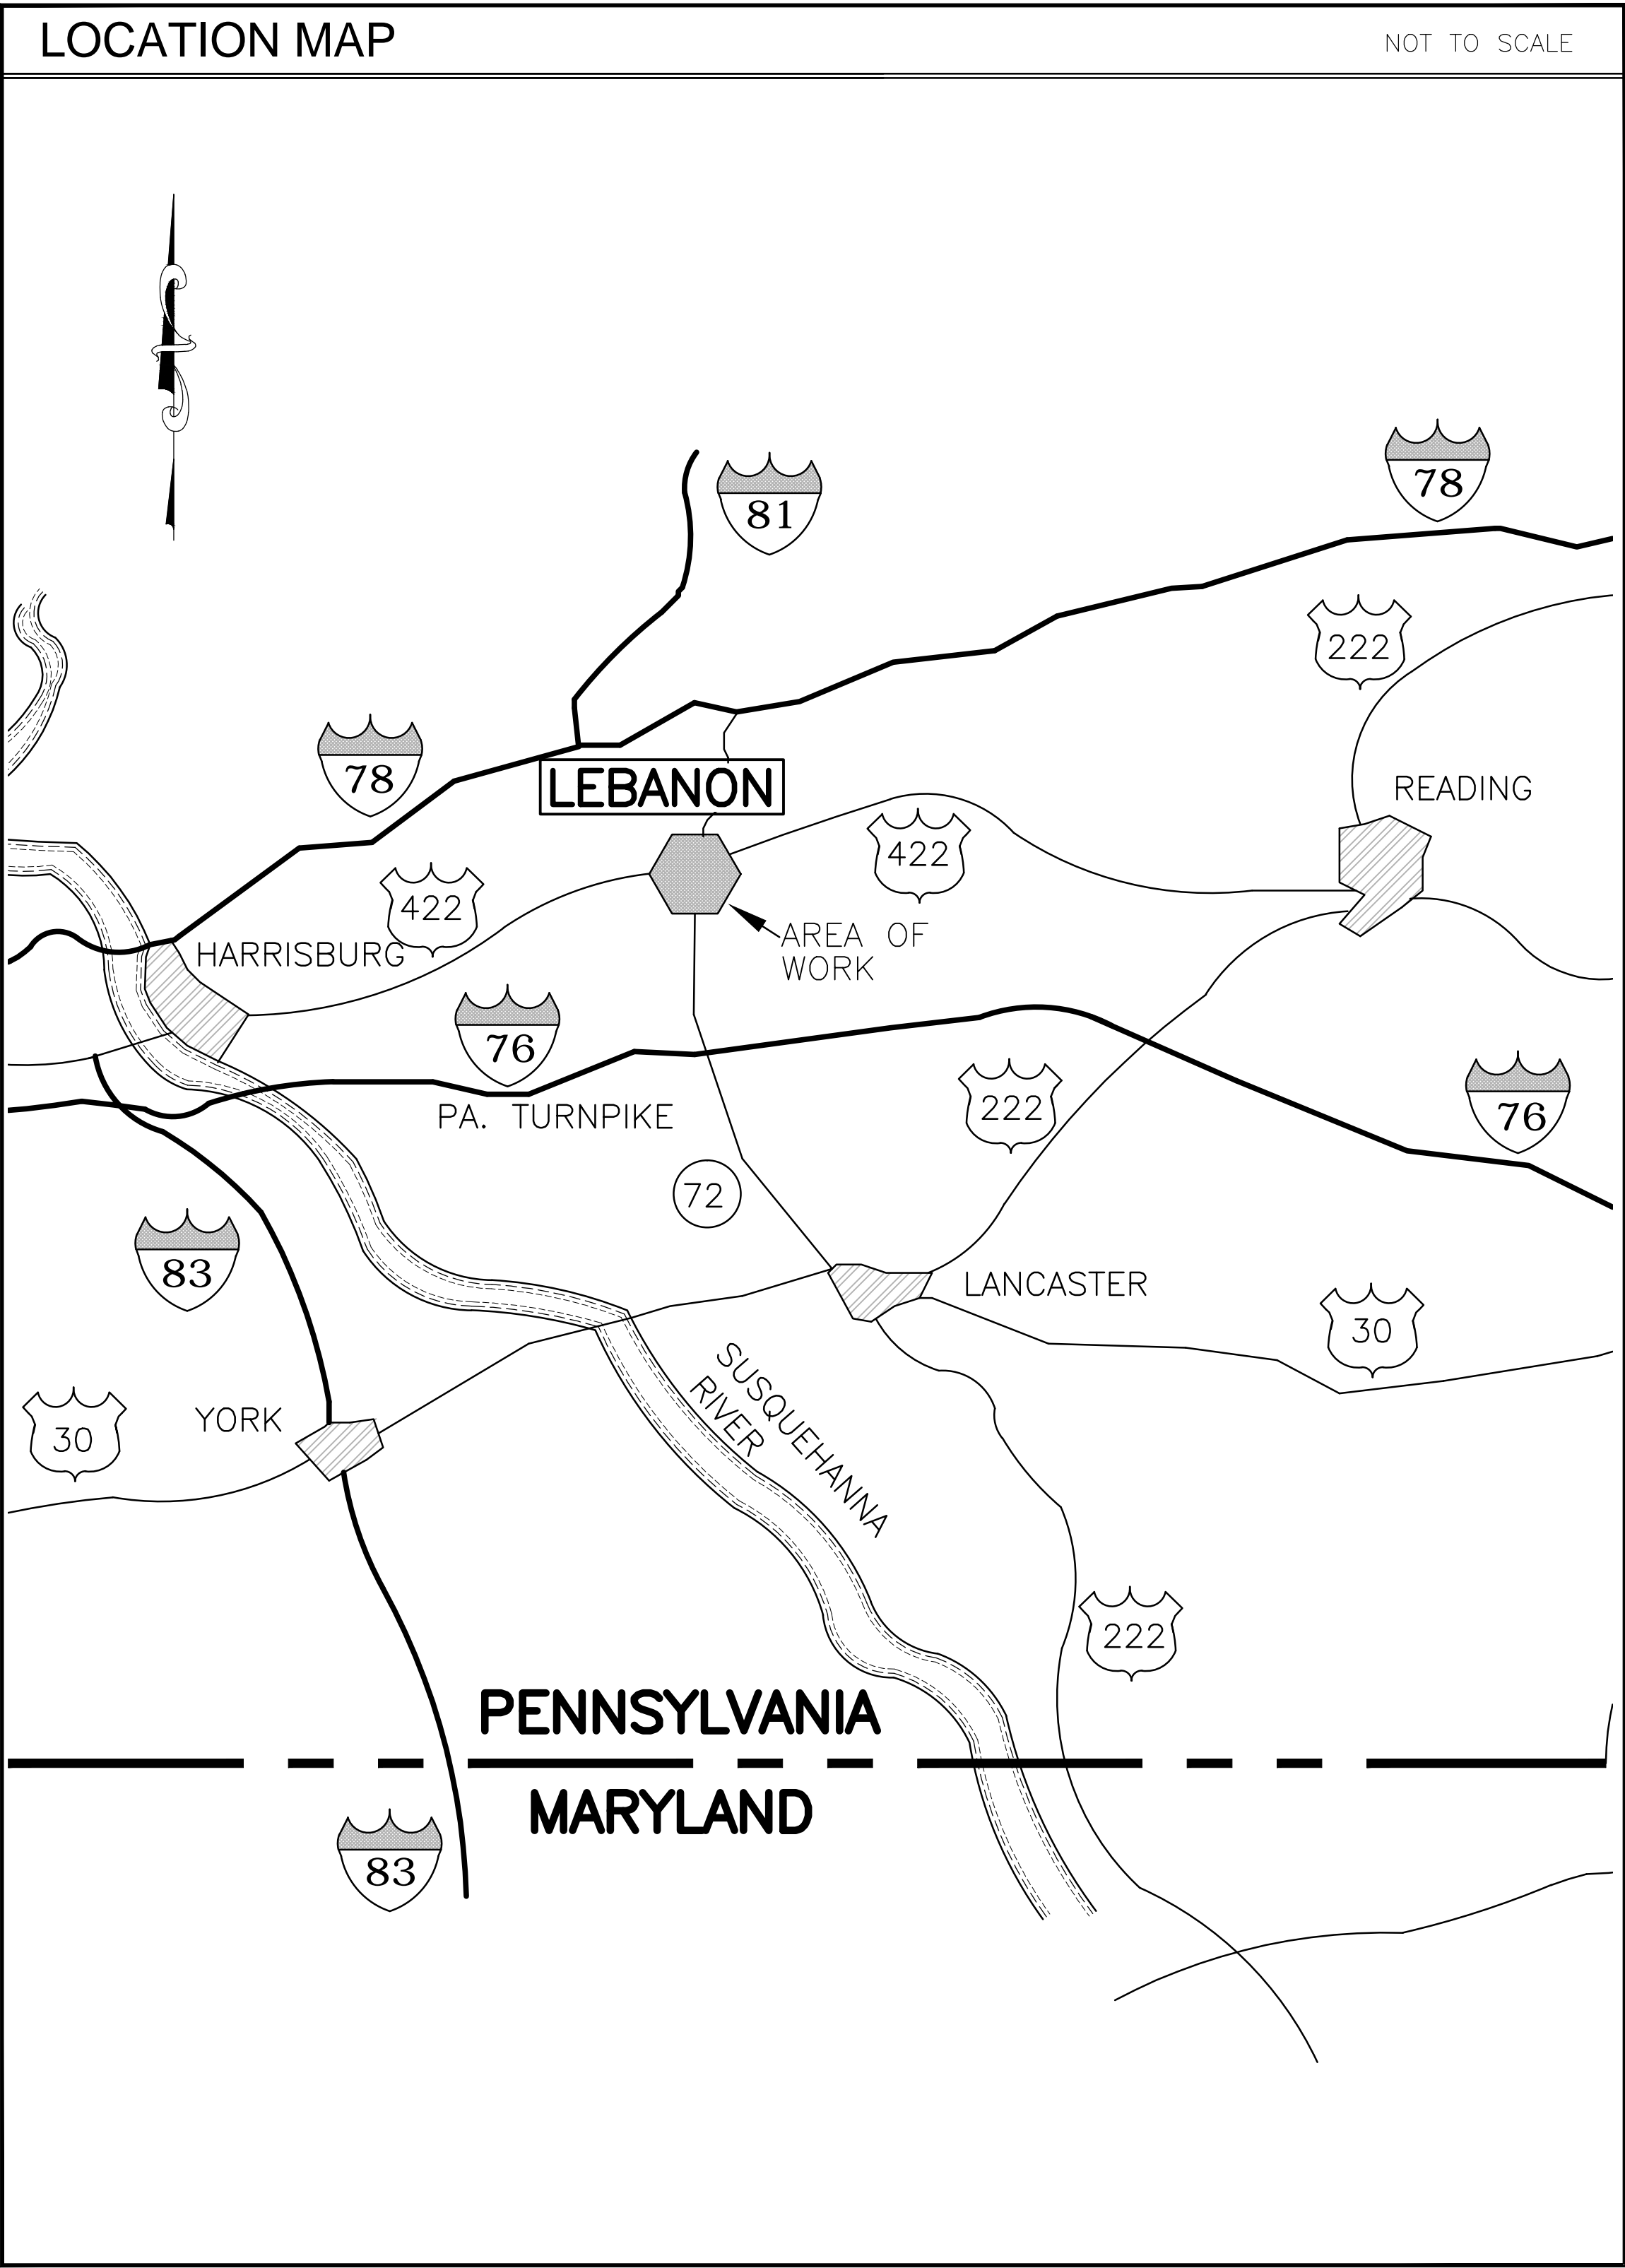

100% Construction Documents	02/10/16
95% Design Development	12/11/15
75% R1 Design Development	10/30/15
75% Design Development	11/29/13
50% Design Development	04/05/13
25% Design Development	02/26/13
Revisions:	Date



DCS INFRASTRUCTURE, LLC
DESIGN & CONSTRUCTION SERVICES
3249 ROUTE 112
BLDG. 4, STE. 1B
MEDFORD, N.Y. 11763
631-320-1706

Drawing Title TITLE SHEET
Approved : Division Chief
Approved : Service Director

Project Title		
GENERATOR FOR MRI- RADIOLOGY- LAB		
Building Number	Checked KF	Drawn PB
Location VAMC - LEBANON, PA		

Date 02/10/2016
Project Number 595-12-107
Drawing Number T-1 Dwg. 1 of 15

BID DOCUMENTS
NOT SPRINKLERED

