

REPLACE ROOFS BUILDINGS 39 & 40
DEPARTMENT OF VETERANS
AFFAIRS MEDICAL CENTER
TUSCALOOSA, ALABAMA

ADDRESS: 3701 LOOP ROAD EAST
TUSCALOOSA, ALABAMA 35404
BUILDING NUMBER - 39 & 40

VA PROJECT NUMBER: 679-10-103
ARCHITECT'S PROJECT NUMBER: 108-09

PROJECT DIRECTORY:

KEY PLAN - VAMC, TUSCALOOSA


OWNER:
DEPARTMENT OF VETERANS AFFAIRS
3701 LOOP ROAD EAST
TUSCALOOSA, ALABAMA 35404
(205) 933-4492

ARCHITECT:
BIRCHFIELD PENUEL AND ASSOCIATES
2805 CRESCENT AVENUE SUITE 200
BIRMINGHAM, ALABAMA 35209
(205) 870-1876 FAX: (205) 870-3054


ELECTRICAL:
SAJADIEH ENGINEERING
389 BRENTWOOD AVE.
TRUSSVILLE, ALABAMA 35173
(205) 833-7033

ARCHITECTURAL DRAWINGS	
39-A2.0	Building 39 - First Floor Building Access Plan
39-A2.1	Building 39 - Roof Plan
40-A2.0	Building 40 - First Floor Building Access Plan
40-A2.1	Building 40 - Roof Plan
A6.1	Buildings 39 & 40 - Details
A6.2	Buildings 39 & 40 - Details


SITE PLAN

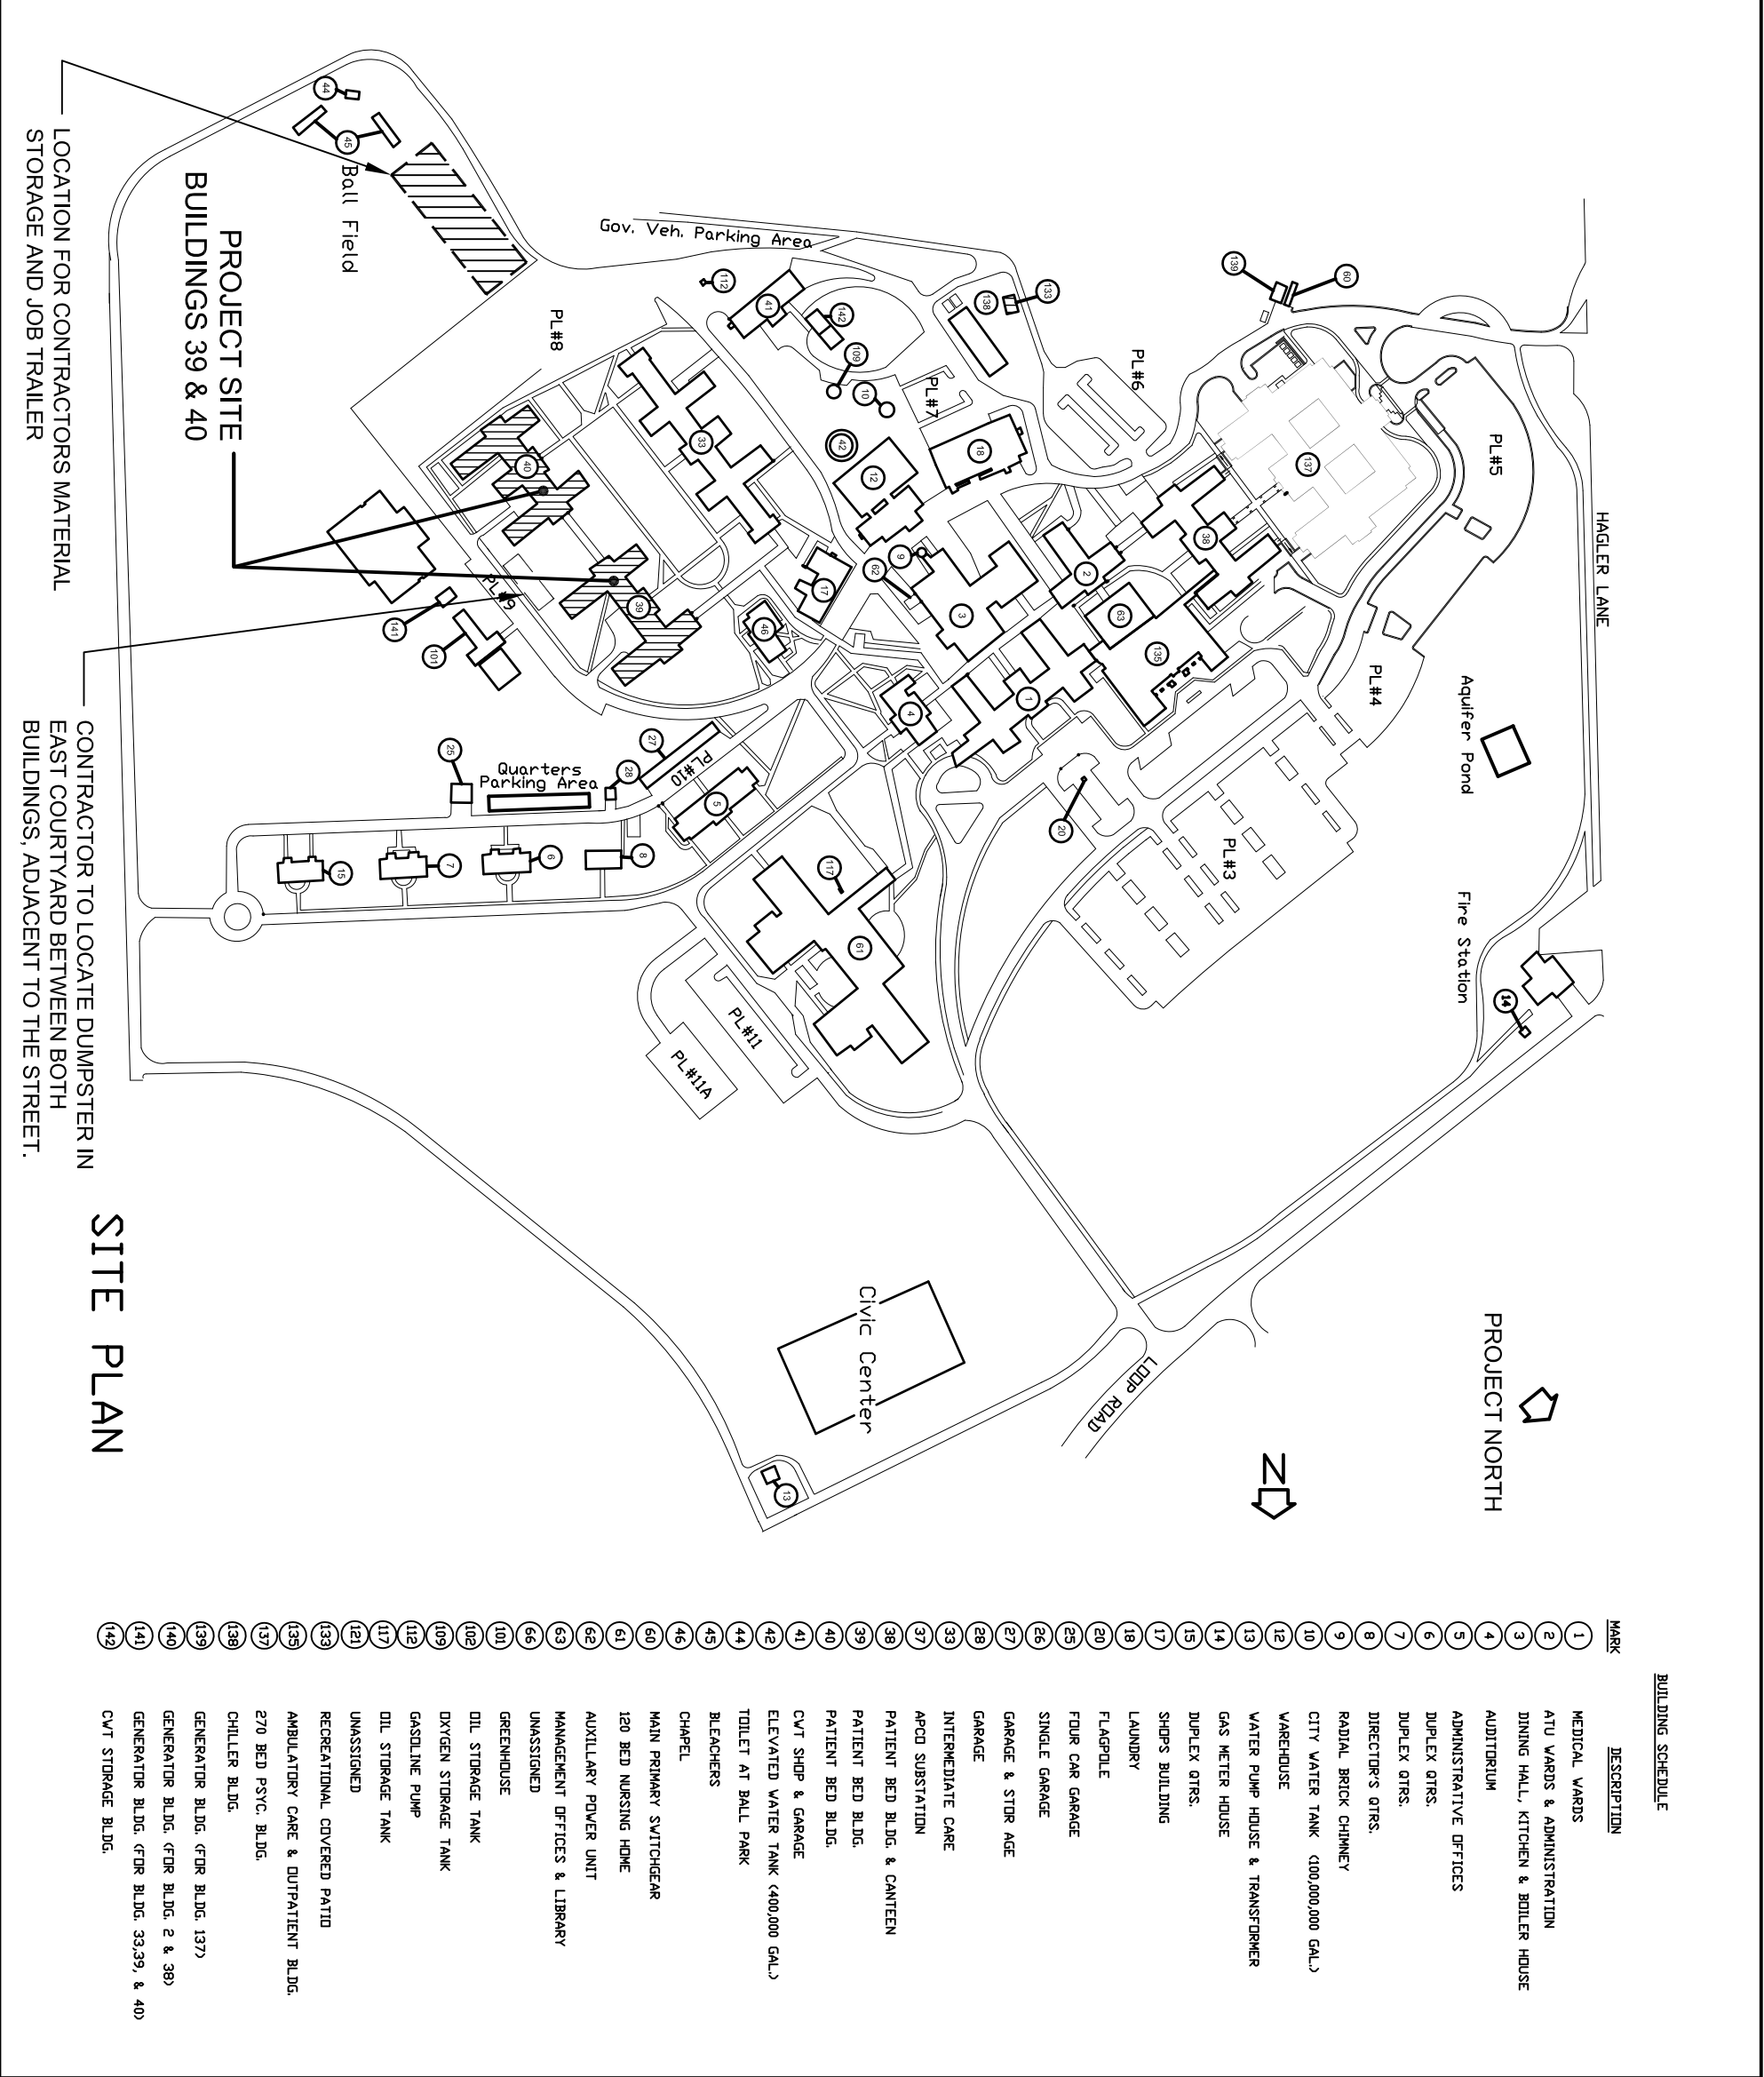


AREA MAP

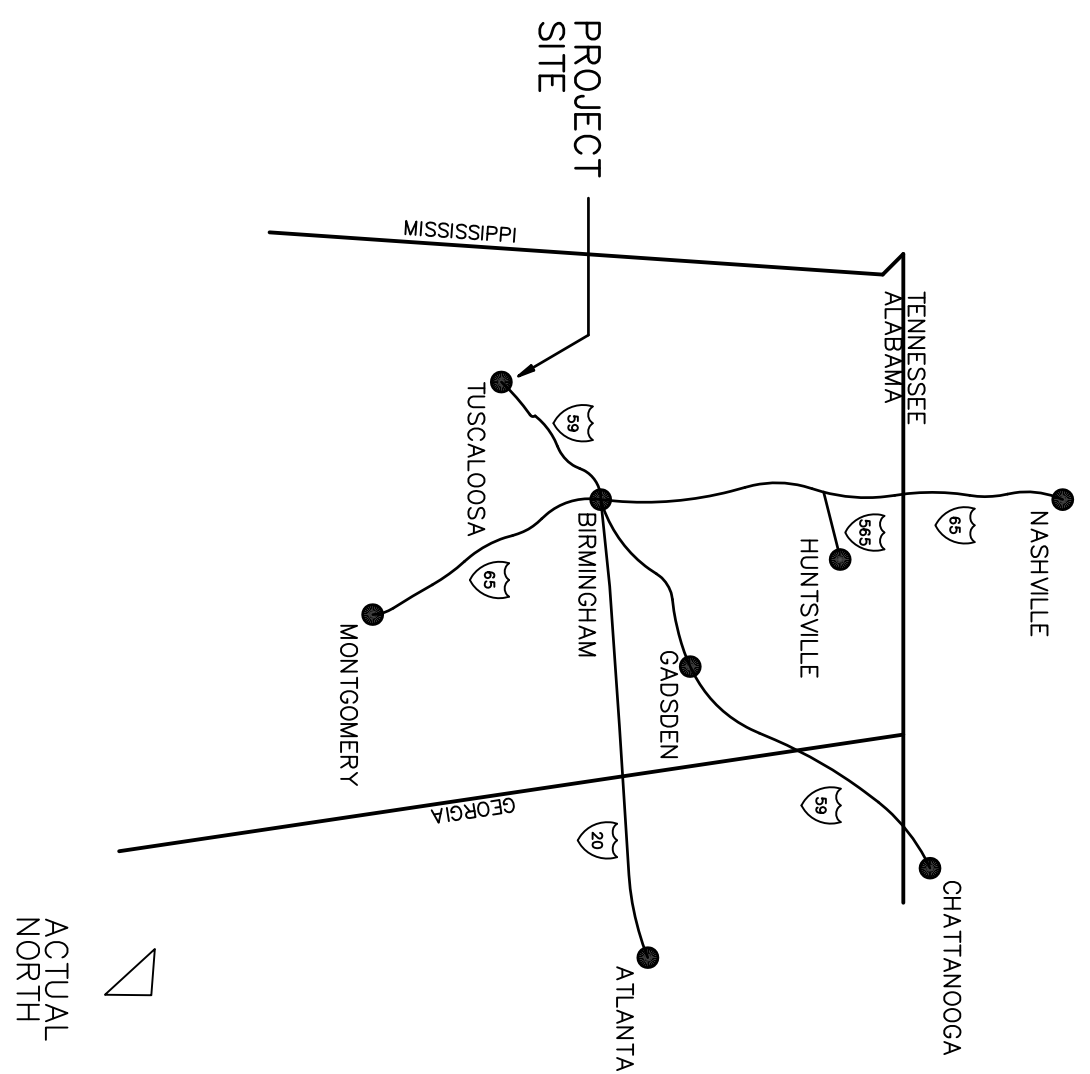


VICINITY PLAN - VAMC, TUSCALOOSA

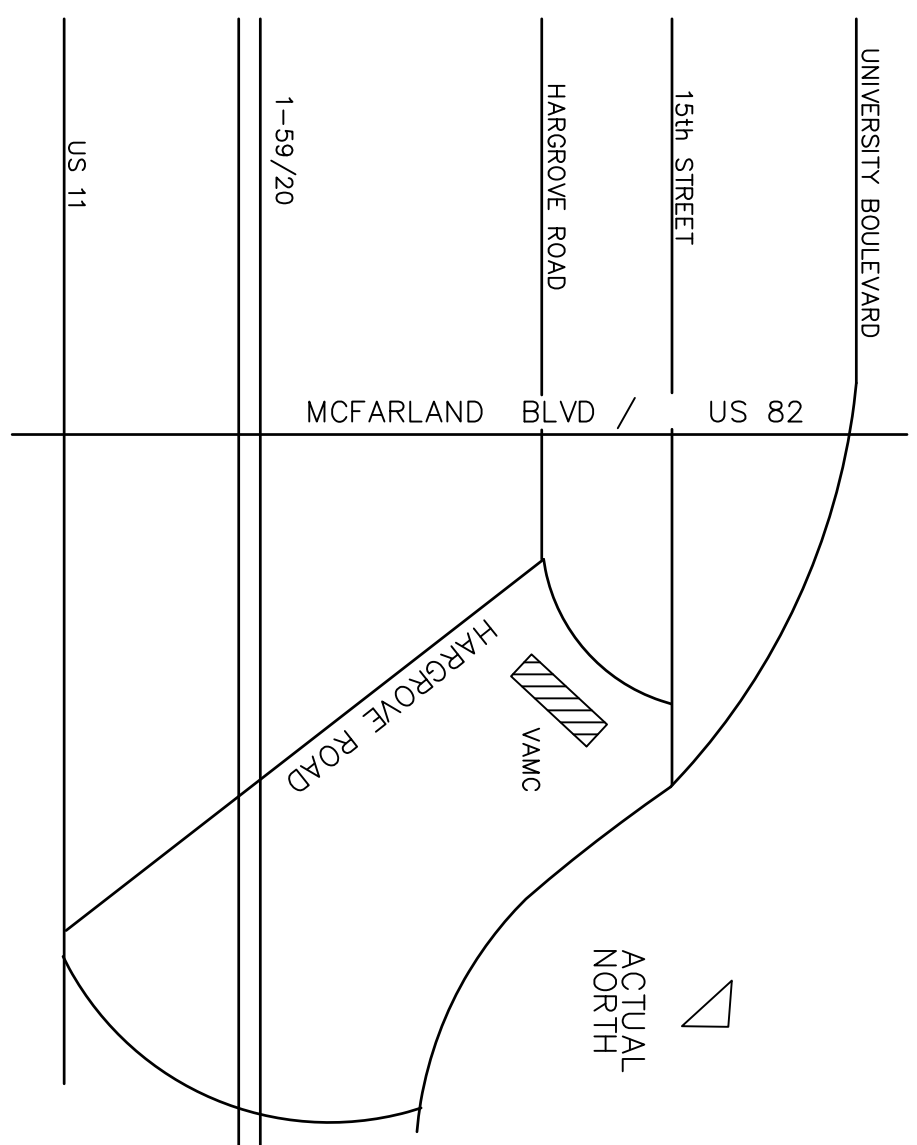

MATERIALS LEGEND:

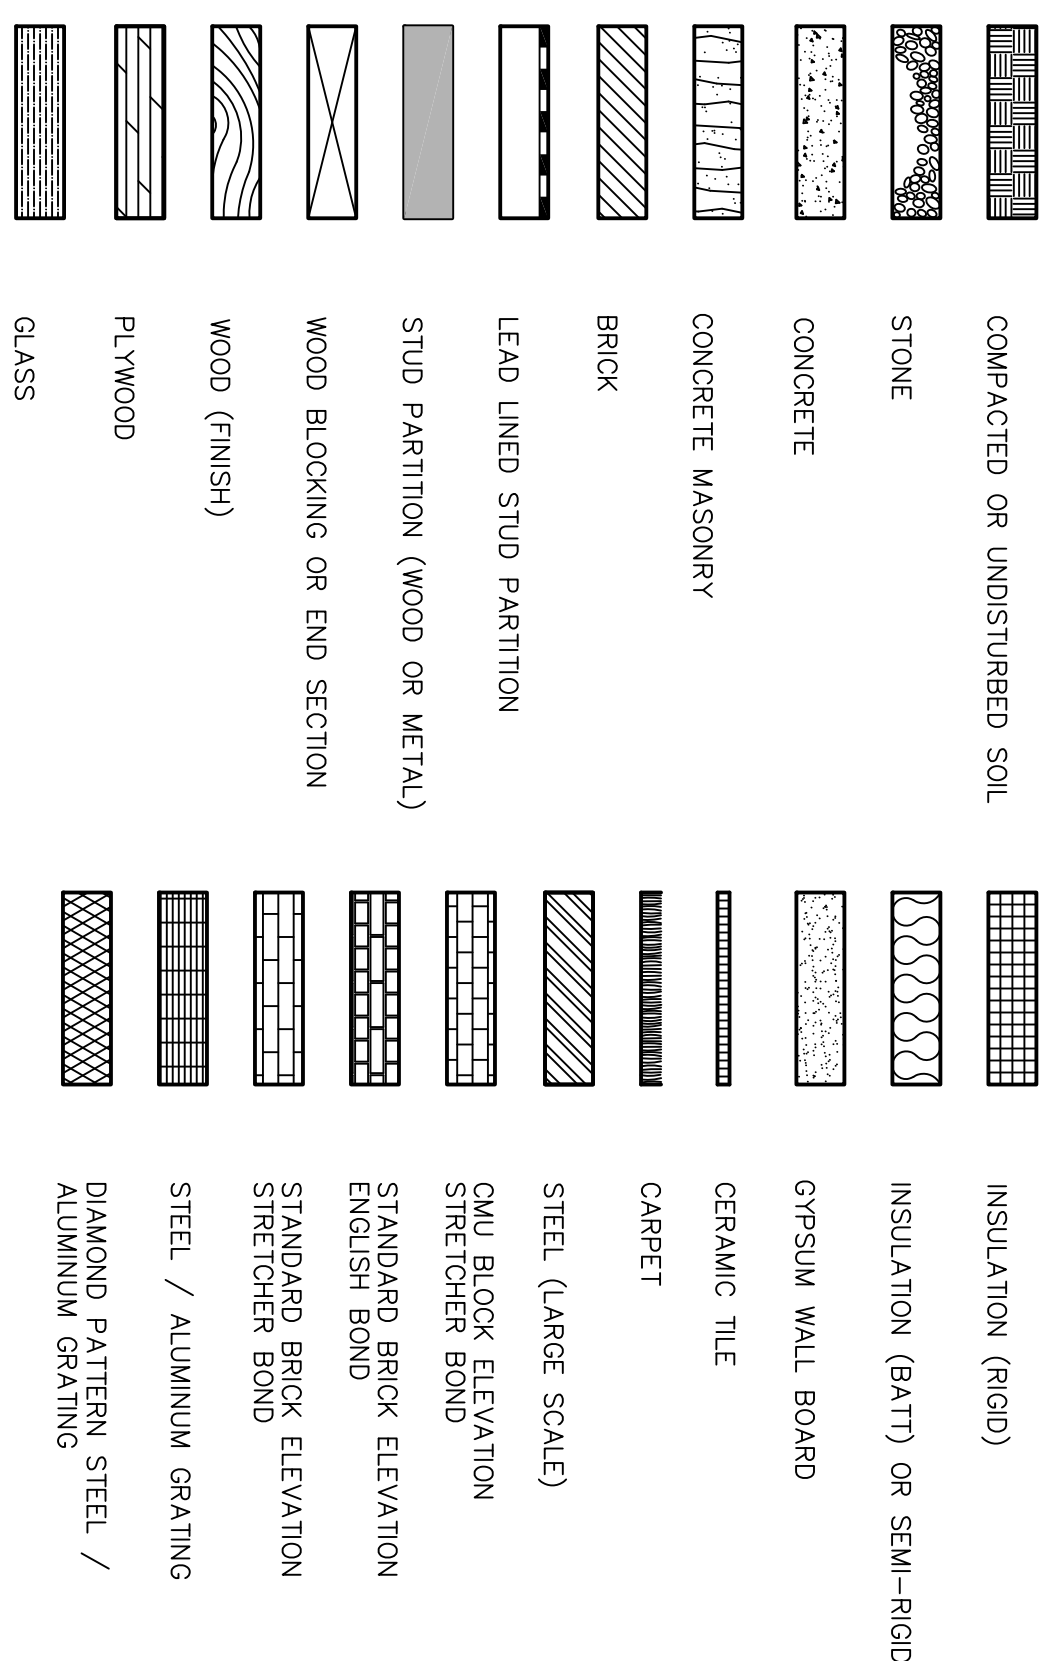

SYMBOLS LEGEND:

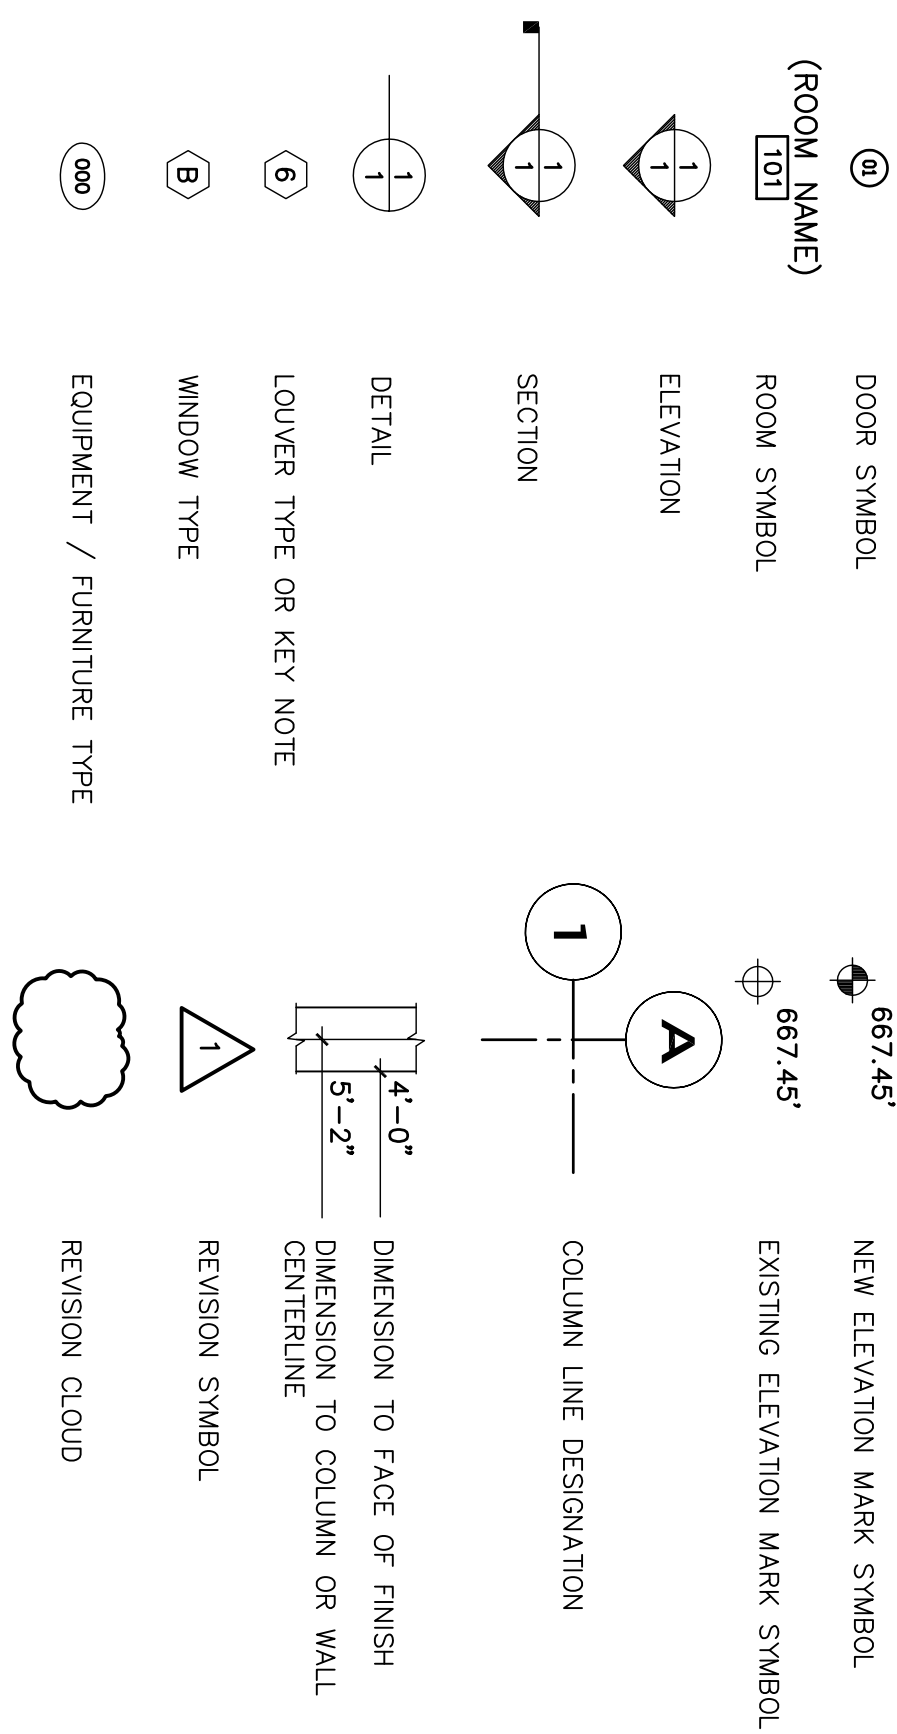

DESIGN CRITERIA:

INTERNATIONAL BUILDING CODE 2006

ABBREVIATIONS:

[illegible]

PROJECT TITLE

Replace Roofs - Buildings 39 & 40
Department of Veterans Affairs
MEDICAL CENTER
TUSCALOOSA, ALABAMA

	Drawing Title	Date :	08-30-2010
Approved: Entry Manager	TITLE SHEET NOTES, SYMBOLS & ABBREVIATIONS	Project Title	REPLACE ROOFS - BUILDINGS
Approved: Inspection Control Nurses		38 & 40	
Approved: Safety Manager	DEPARTMENT OF VETERANS AFFAIRS	Project Number :	679-10-103
	Approved: Chief Engineer	DRAWING NO.:	A0.1
	Approved: Director	Building Numbers	39 & 40
		Crossed	WCB
		Drawn	DB
		Location	VA MEDICAL CENTER TUSCALOOSA, ALABAMA
		Drawn 01	or 10

Veterans Administration