

1 1ST FLR - ENLARGED NURSE STATION
1/4" = 1'-0"

CORR
A1-C07

NURSES STATION
A1-220

CORR
A1-C03

CONSULTANTS:



Syska Hennessy Group, Inc.
425 California Street
Suite 700
San Francisco, CA 94104
Tel: 415.288.9060
Fax: 415.835.0385
www.syska.com



ARCHITECT/ENGINEERS:



ENGINEERS ARCHITECTS
ONE KAISER PLAZA SUITE 445
OAKLAND CALIFORNIA 94612
TEL 510.271.6701 FAX 510.271.6707
© THE KPA GROUP 2013
KPA Project No. 563.00

Drawing Title
**1ST FLR - TYPICAL
ROOM LAYOUTS**

Approved: Project Director

**VAPAHCS PLANNING
AND ENGINEERING**

Project Title
**BUILDING 100 - UPGRADE
NURSE CALL SYSTEM**

Location VAPAHCS - PALO ALTO CAMPUS 3801 MIRANDA AVE, PALO ALTO, CA 94303		
Date Mar. 4, 2015	Checked HC	Drawn CC


Project Number	640-14-117
Building Number	100

Drawing Number
T-20


FULLY SPRINKLERED

Office of
Construction and
Facilities
Management




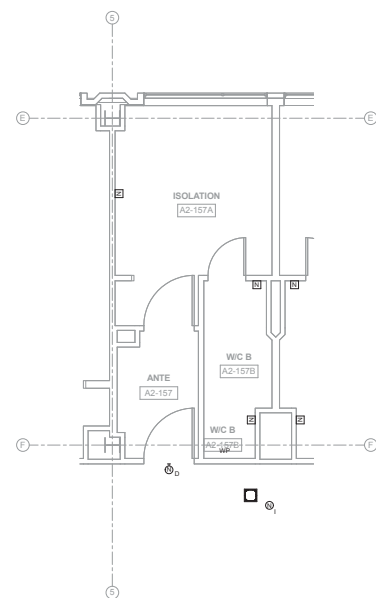

① 2ND FLR - TYPICAL ISOLATION ROOM
1/4" = 1'-0"

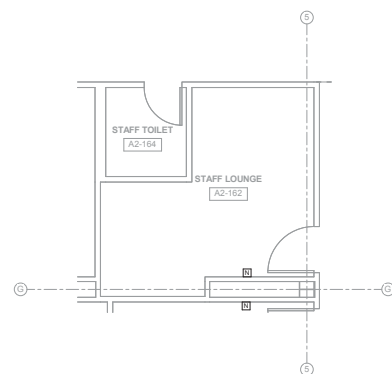

② 2NDFLR - TYPICAL STAFF ROOM
1/4" = 1'-0"

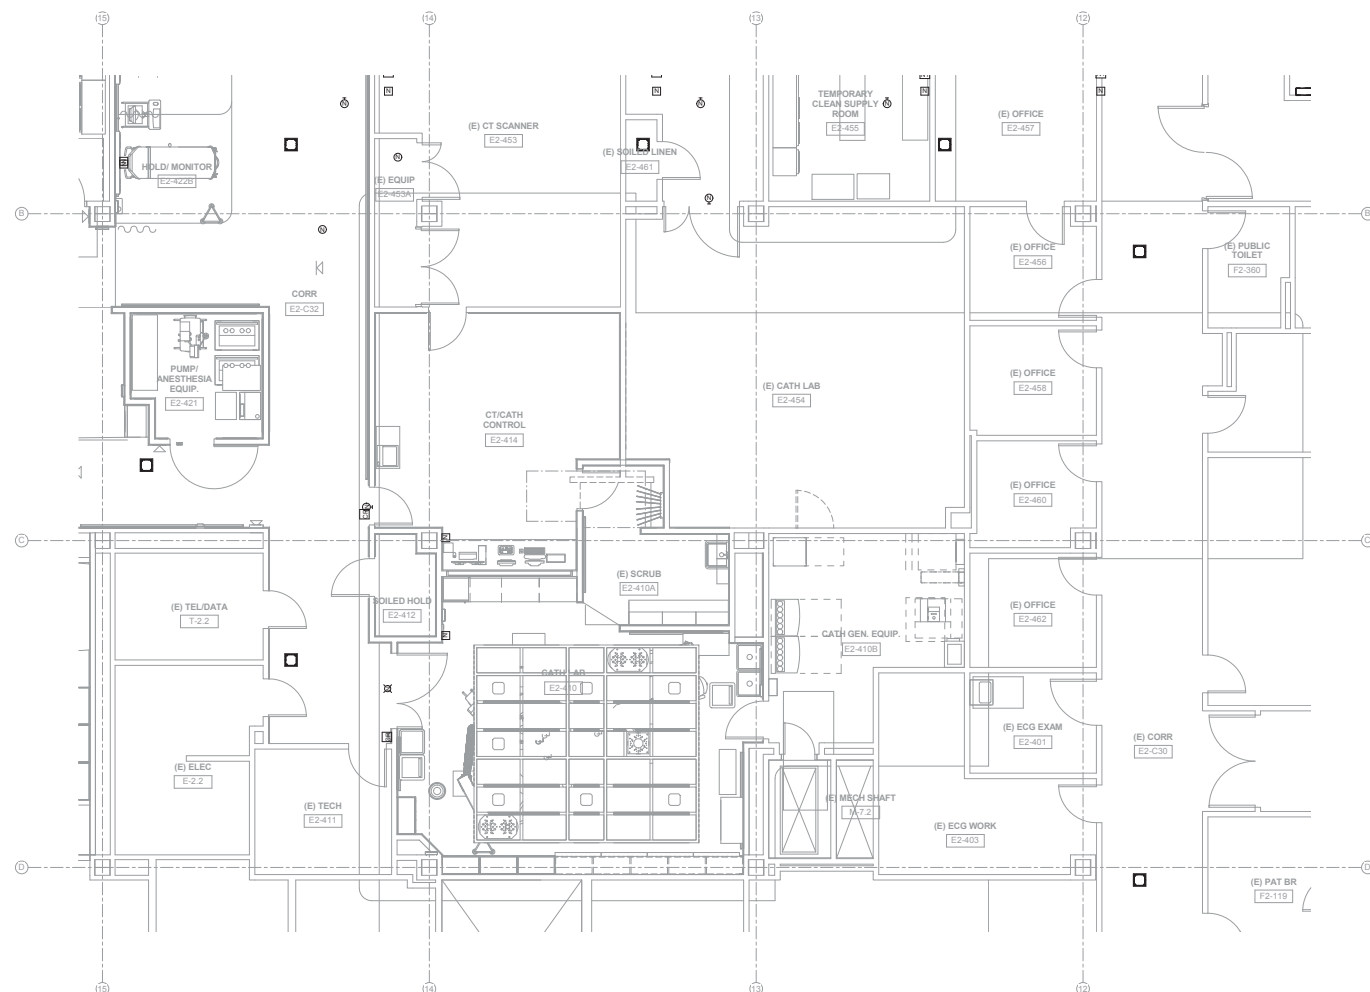


③ 2ND FLR - ENLARGED CATH LAB
1/4" = 1'-0"

[illegible]

CONSULTANTS:



 Syska Hennessy Group, Inc.
425 California Street
Suite 700
San Francisco, CA 94104
Tel: 415.288.9060
Fax: 415.835.0385
www.syska.com



ARCHITECT/ENGINEERS:



ENGINEERS ARCHITECTS
ONE KAISER PLAZA SUITE 445
OAKLAND CALIFORNIA 94612
TEL 510.271.6701 FAX 510.271.6707

Drawing Title
**2ND FLR - TYPICAL
ROOM LAYOUTS**

Approved: Project Director

VAPAHCS PLANNING
AND ENGINEERING

Project Title
**BUILDING 100 - UPGRADE
NURSE CALL SYSTEM**

Location	VAPAHCS - PALO ALTO CAMPUS 3801 MIRANDA AVE. PALO ALTO, CA 94304
----------	---

Date	Checked	Drawn
Mar 1 2015	MS	22

Project Number	640-14-117
Building Number	100


Drawing Number
T-20





1-20


FULLY SPRINKLERED

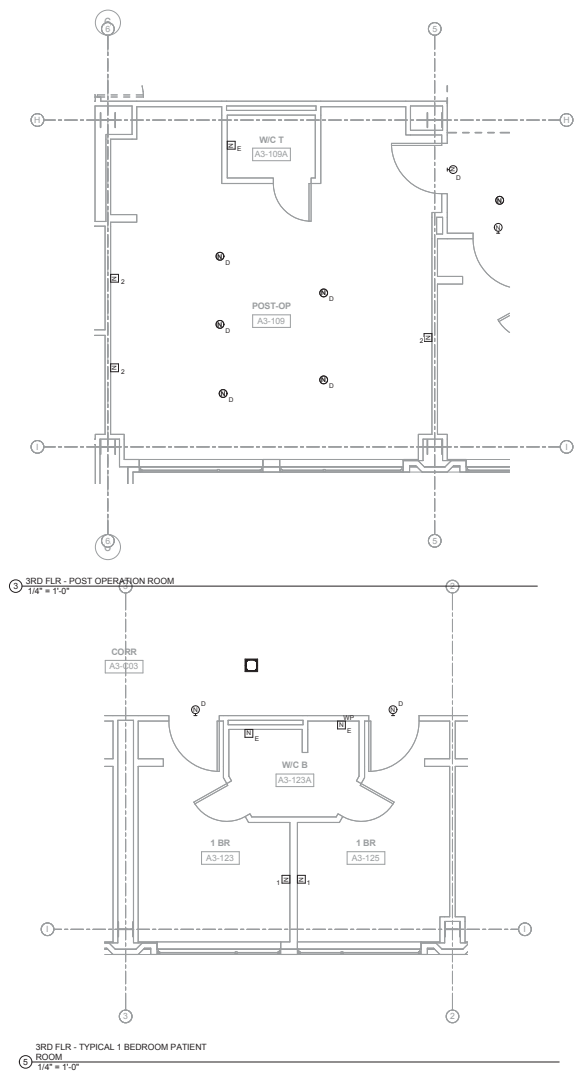Construction and
Facilities
Management








		CONSULTANTS:				ARCHITECT/ENGINEERS:		Drawing Title 3RD FLR - TYPICAL ROOM LAYOUTS		Project Title BUILDING 100 - UPGRADE NURSE CALL SYSTEM		Project Number 640-14-117		Office of Construction and Facilities Management			
		 SYKES HENNESSY A member company of SH Group, Inc.		Sykes Hennessy Group, Inc. 425 California Street Suite 700 San Francisco, CA 94104 Tel: 415-355-0385 www.sykeshennessy.com		 ENGINEERS ARCHITECTS ONE KAISER PLAZA SUITE 445 OAKLAND CALIFORNIA 94612 TEL 510.271.6701 FAX 510.271.6702 THE KPA GROUP		Approved: Project Director VAPAHCS PLANNING AND ENGINEERING		Location VAPAHCS - PALO ALTO CAMPUS 3501 MIRANDA AVE. PALO ALTO, CA 94304		Drawing Number T-208					
Revisions: _____ _____ _____ _____ _____		Date _____								Date Mar 4, 2015		Checked HC		Drawn CC		Dwg. - of -	
																	

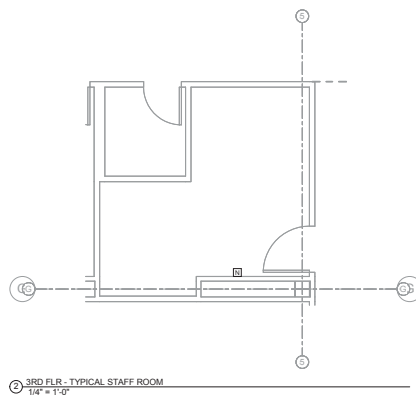

② 3RD FLR - TYPICAL STAFF ROOM
1/4" = 1'-0"

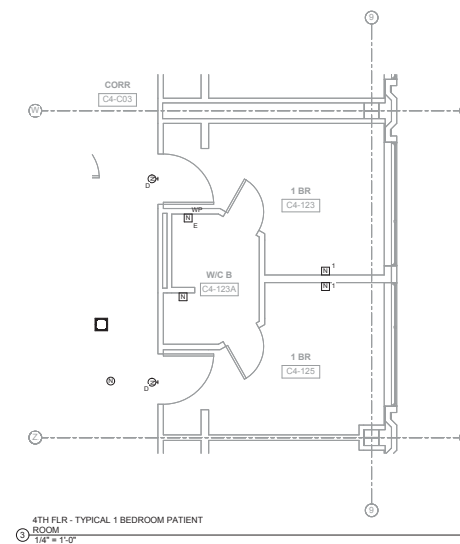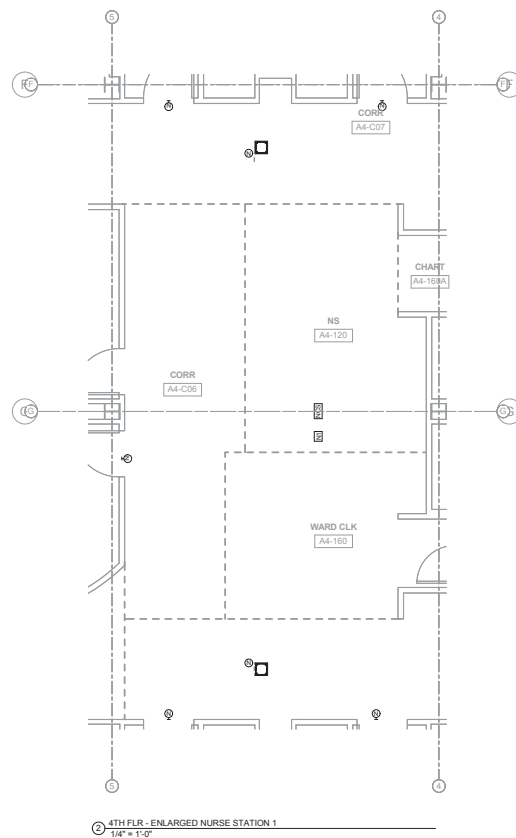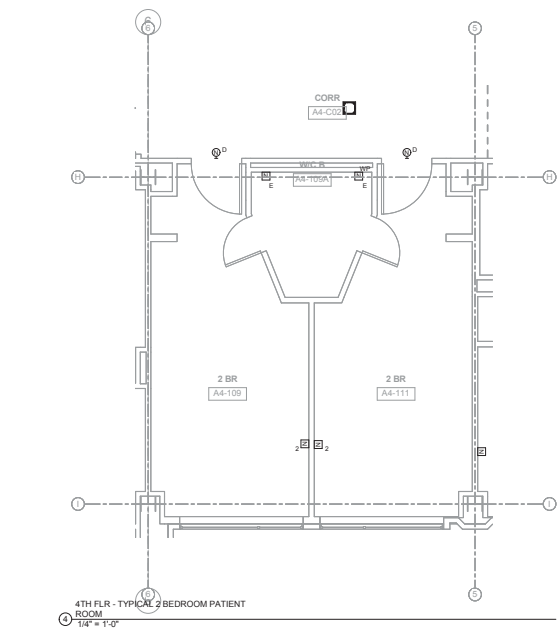[illegible]



1. EXISTING NURSE CALL TERMINAL CABINET TO BE DEMOLISHED. ALL NURSE CALL DEVICE CABLEING TO TERMINAL CABINET TO BE REMOVED.
2. PROVIDE NEW NURSE CALL TERMINAL CABINET WITH ELECTRONICS AND BATTERY BACKUP. PROVIDE NEW CABLEING TO NEW NURSE CALL DEVICES PER Riser DIAGRAM.
3. EXISTING NURSE CALL TERMINAL CABINET TO REMAIN.

SHEET NOTES:

VA FORM 08-6231, OCT 1978

VA FORM 08-6231, OCT 1976



SHEET NOTES:

TYPICAL DJB IDENTIFICATION:

NURSE CALL/FIRE
ALARM/SIGNAL SYSTEM
DISTRIBUTION JUNCTION
BOX (DJB'S).


2-16 ← ROOM NUMBER, TYPICAL


		CONSULTANTS:		ARCHITECT/ENGINEERS:		Drawing Title TECHNOLOGY NURSE CALL SINGLE LINE DIAGRAM		Project Title BUILDING 100 - UPGRADE NURSE CALL SYSTEM		Project Number 640-14-117		Office of Construction and Facilities Management	
		 SYSKA HENNESSY GROUP A member company of SH Group, Inc.		 ENGINEERS ARCHITECTS ONE KAISER PLAZA SUITE 445 OAKLAND CALIFORNIA 94612 TEL: 510.271.6701 FAX: 510.271.6707 WWW.SYSKA.COM		 THE KPA GROUP		Approved: Project Director VAPAHCS PLANNING AND ENGINEERING		Location VAPAHCS - PALO ALTO CAMPUS 3801 MISSISSAUGA AVE. PALO ALTO, CA 94304		Drawing Number T-801	
Revisions:		Date						Date Mar. 4, 2015		Checked HC		Drawn CC	
										Diag. — of —			

FULLY SPRINKLERED

Office of
Construction and
Facilities
Management

VA & PAHCS
Veterans Affairs Public Health Care System

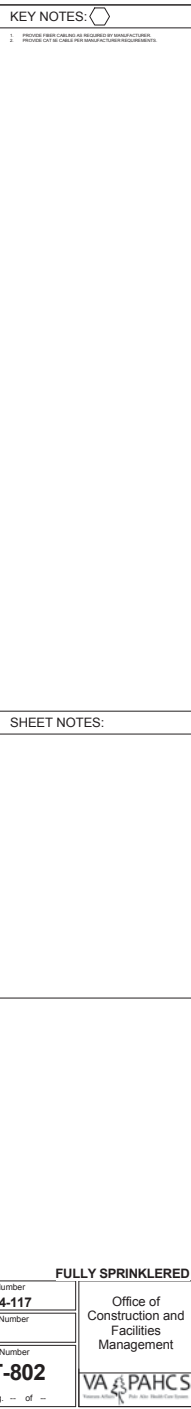

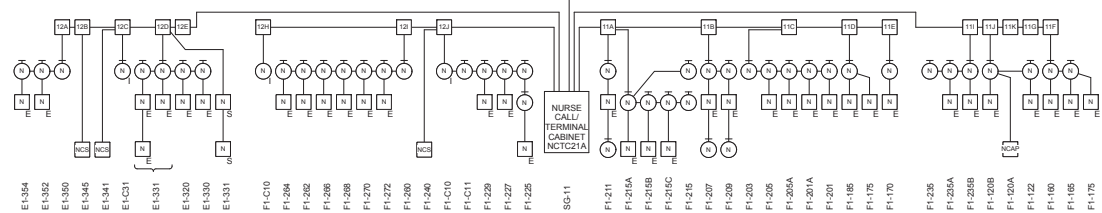

1. PROVIDE FIBER CARLING AS REQUIRED BY MANUFACTURER.
2. DISPOSE CAT ME CASE & REM MANUFACTURER WITH SUCH INSTRUCTIONS

FULLY SPRINKLERED

VA & PAHCS
Veterans Affairs Public Health Care System



SYSKA HENNESSY
GROUP
A member company of SH Group, L.P.

Syska Hennessy Group, Inc.
425 California Street
Suite 700
San Francisco, CA 94104
Tel: 415.288.9060
Fax: 415.835.0385
www.syska.com



KPA
THE KPA GROUP

ENGINEERS ARCHITECTS
ONE KAISER PLAZA SUITE 445
OAKLAND CALIFORNIA 94612
TEL 510.271.6701 FAX 510.271.6707

VAPAHCS PLANNING
AND ENGINEERING

Date Mar. 4, 2015	Checked HC	Drawn CC
----------------------	---------------	-------------

Page -- of

VA & PAHCS
Veterans Affairs Public Health Care System

