
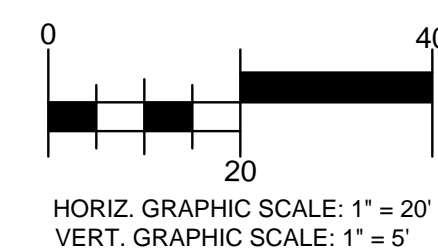
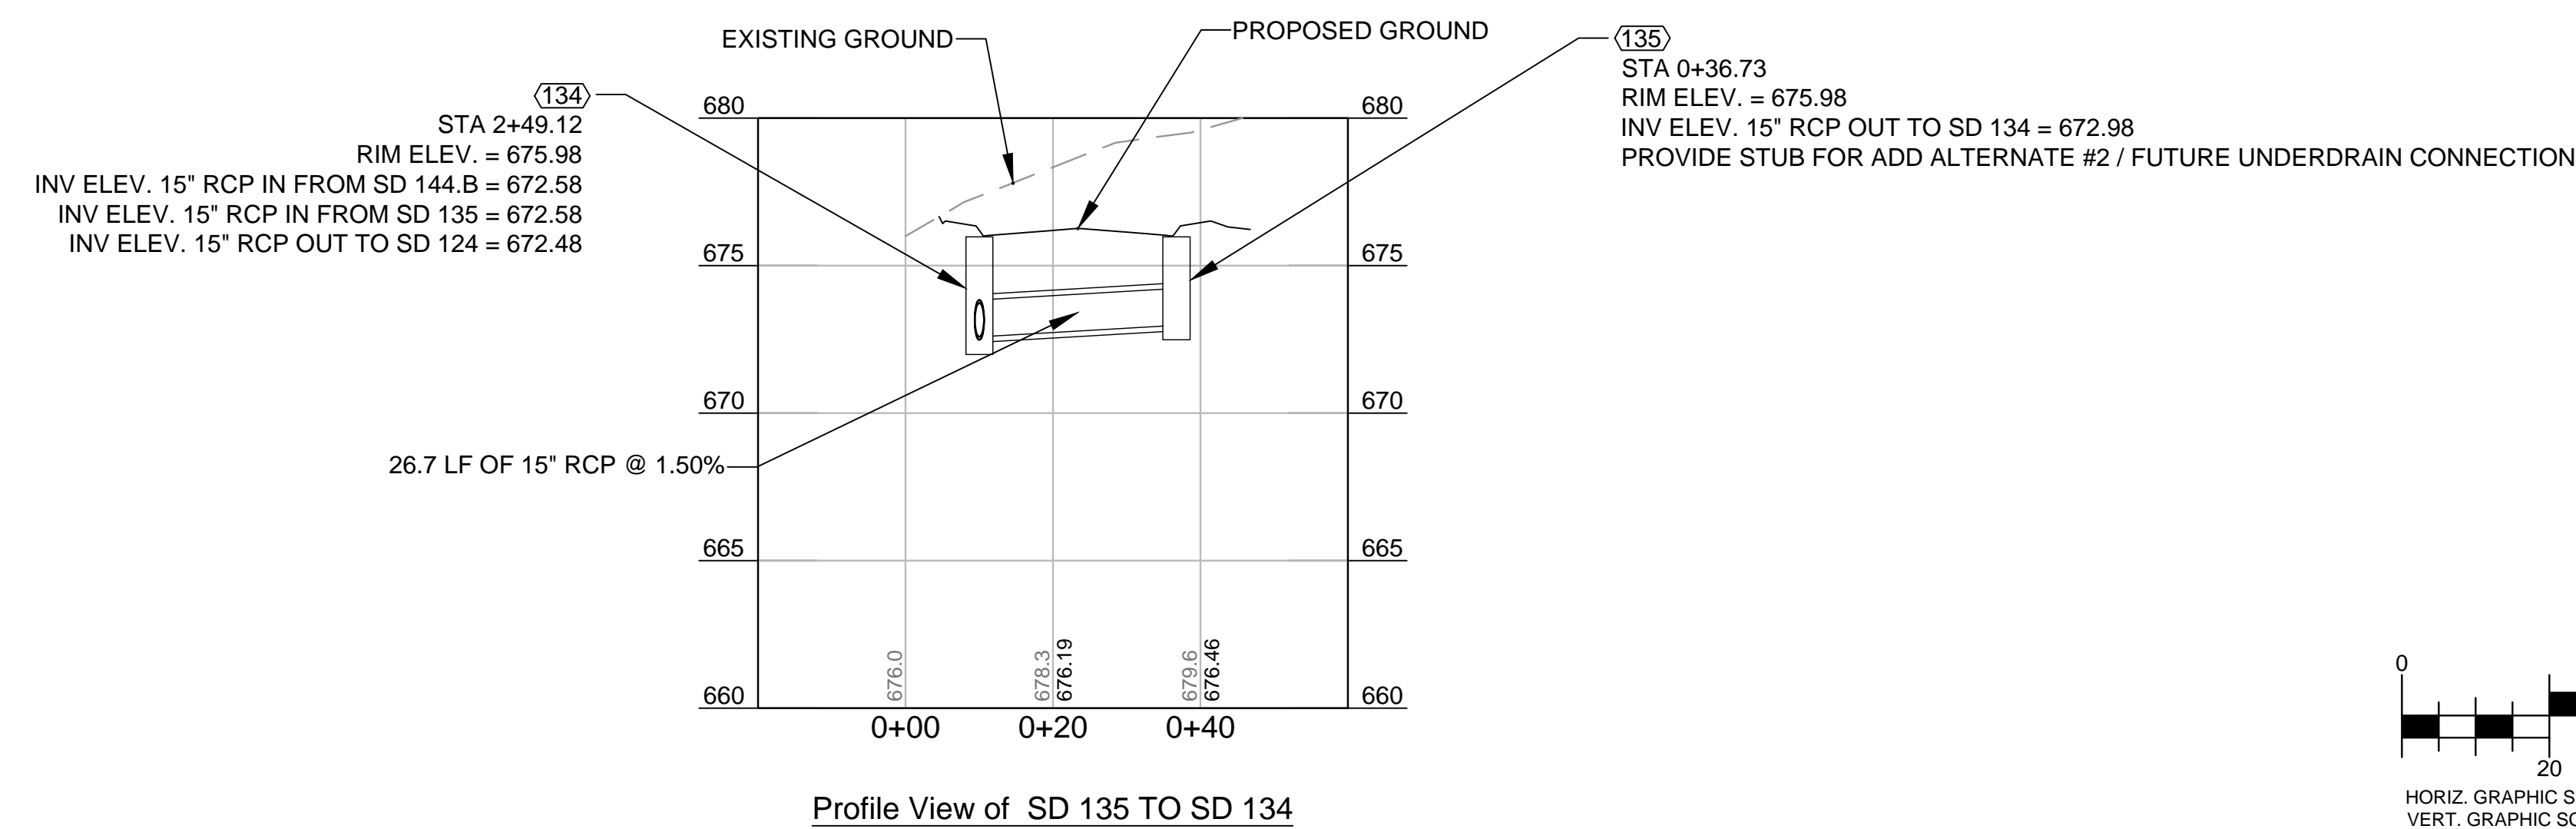
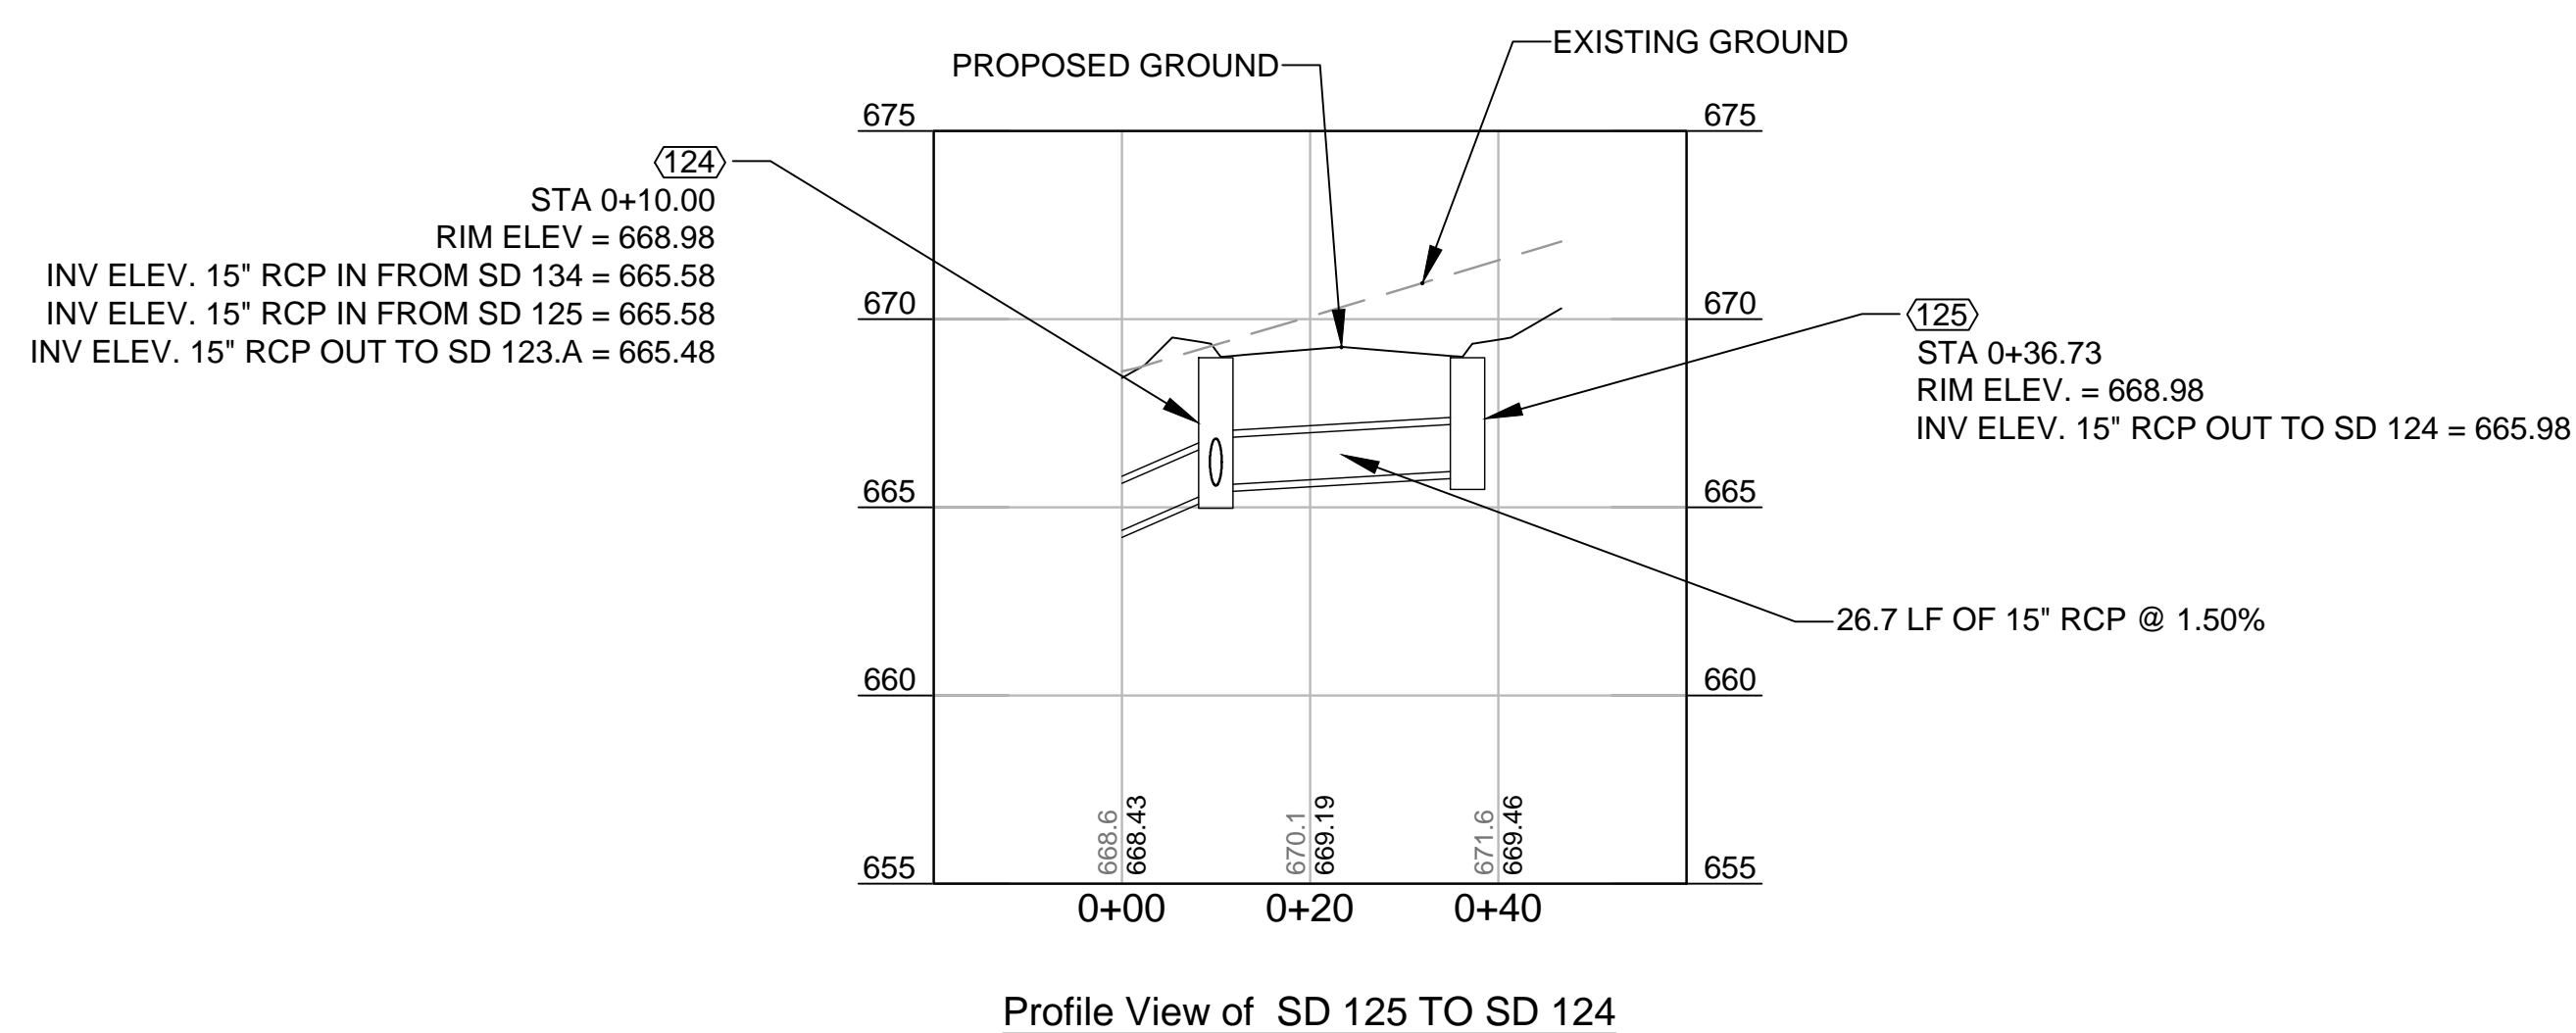
 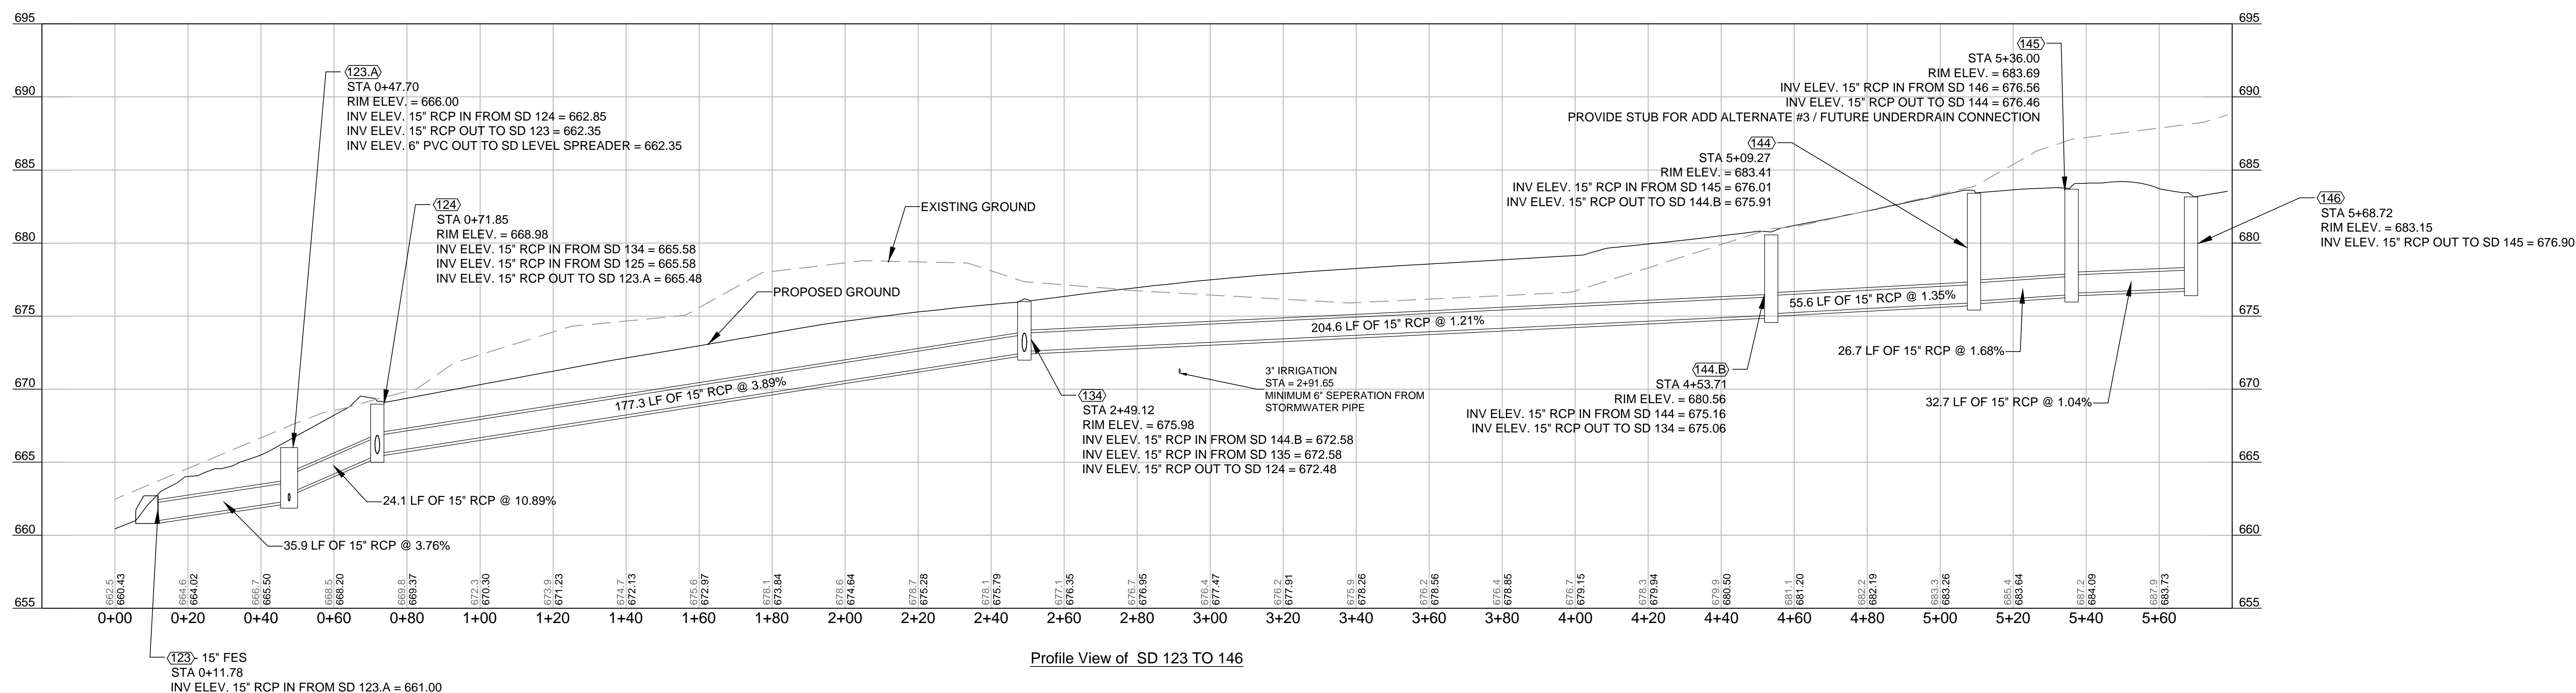



- GENERAL NOTES**
1. REFER TO SHEETS C-301 AND C-302 FOR STORM DRAINAGE LAYOUT.
 2. FULLY SEAL ALL PIPE AND STRUCTURE JOINTS.
 3. RIM ELEVATIONS FOR ALL CURB INLETS IS LOCATED AT BOTTOM FACE OF CURB. RIM ELEVATION FOR ALL FLOW SPLITTER BOXES ARE MEASURED TO TOP OF MANHOLE RIM.
- LEGEND
- FES = FLARED END SECTION. SEE DETAIL C7/C-507
- TBC = TOP BACK CURB
- ELEV.=ELEVATION
- INV = INVERT

[illegible]

Terracon
Consulting Engineers and Scientists




PEAKS TO PLAINS DESIGN
LANDSCAPE ARCHITECTURE • PLANNING • CIVIL ENGINEERING
404 NORTH 31ST STREET, SUITE 405
BILLINGS, MONTANA 59101
(406) 294-9499 • (406) 294-9670 FAX
WWW.PEAKSTOPLAINS.COM


Aqua Engineering Inc.
Innovative Water Solutions

3202 West Main
Suite C
Rapid City, South Dakota 57702
phone: 605.343.9606 fax: 605.341.7395

575 E. Horseshoe Road, Building 2-4
Fort Collins, CO 80525-3196
870.229.9688 office
870.226.3855 fax
www.aquaengineering.com

Albertson Engineering Inc.

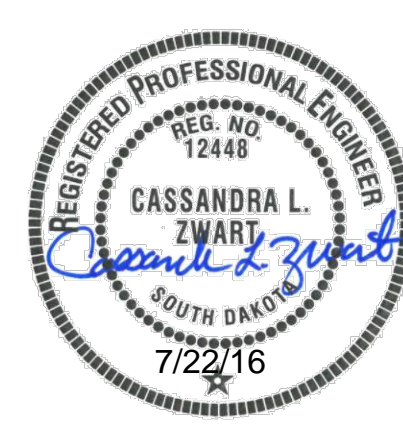

FOURFRONT
REAL ESTATE

517 7th street
rapid city sd 57701
p 605.342.9470
f 605.342.2377
www.4front.biz

Drawing Title	STORM DRAINAGE PROFILES #1
---------------	----------------------------

Approved: Project Director

Project Title	SALISBURY NATIONAL CEMETERY GRAVESITE EXPANSION
---------------	--

Location	SALISBURY NAT SALISBURY, NC
----------	--------------------------------

☒ Checked

METERY

Project Number

Building Number	N/A
-----------------	-----

Drawing Number

C-401

BID DOCUMENTS

NCA DESIGN
AND CONSTRUCTION
SERVICE

