




Profile View of SD 218 TO SD 217

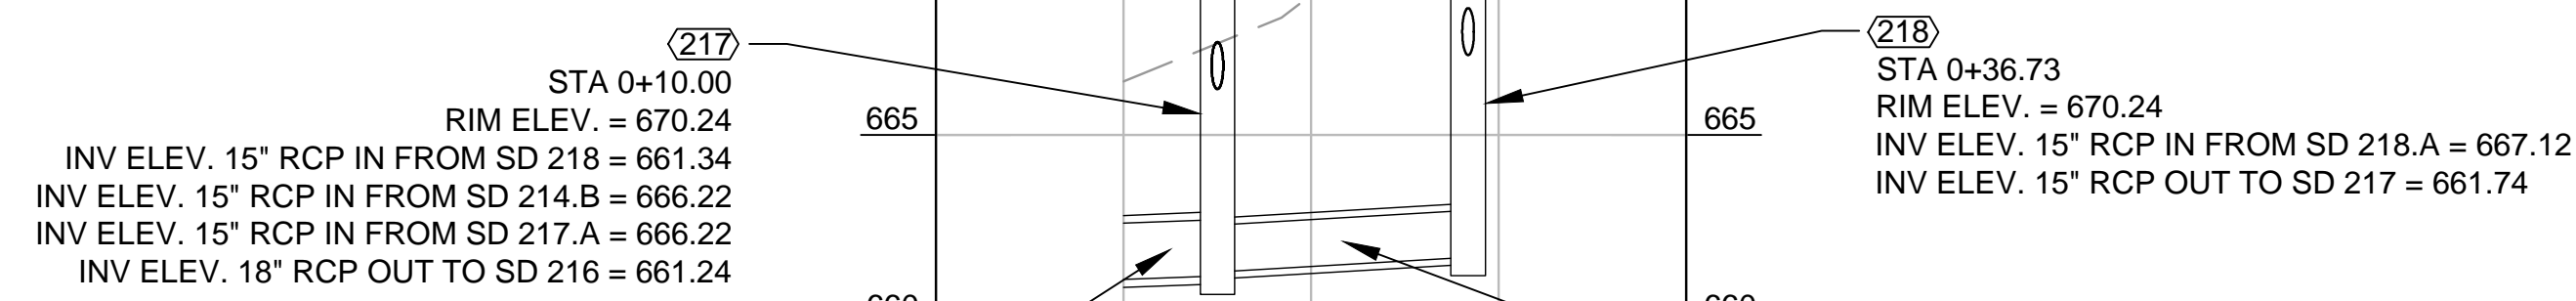

Profile View of SD 217.A TO 217

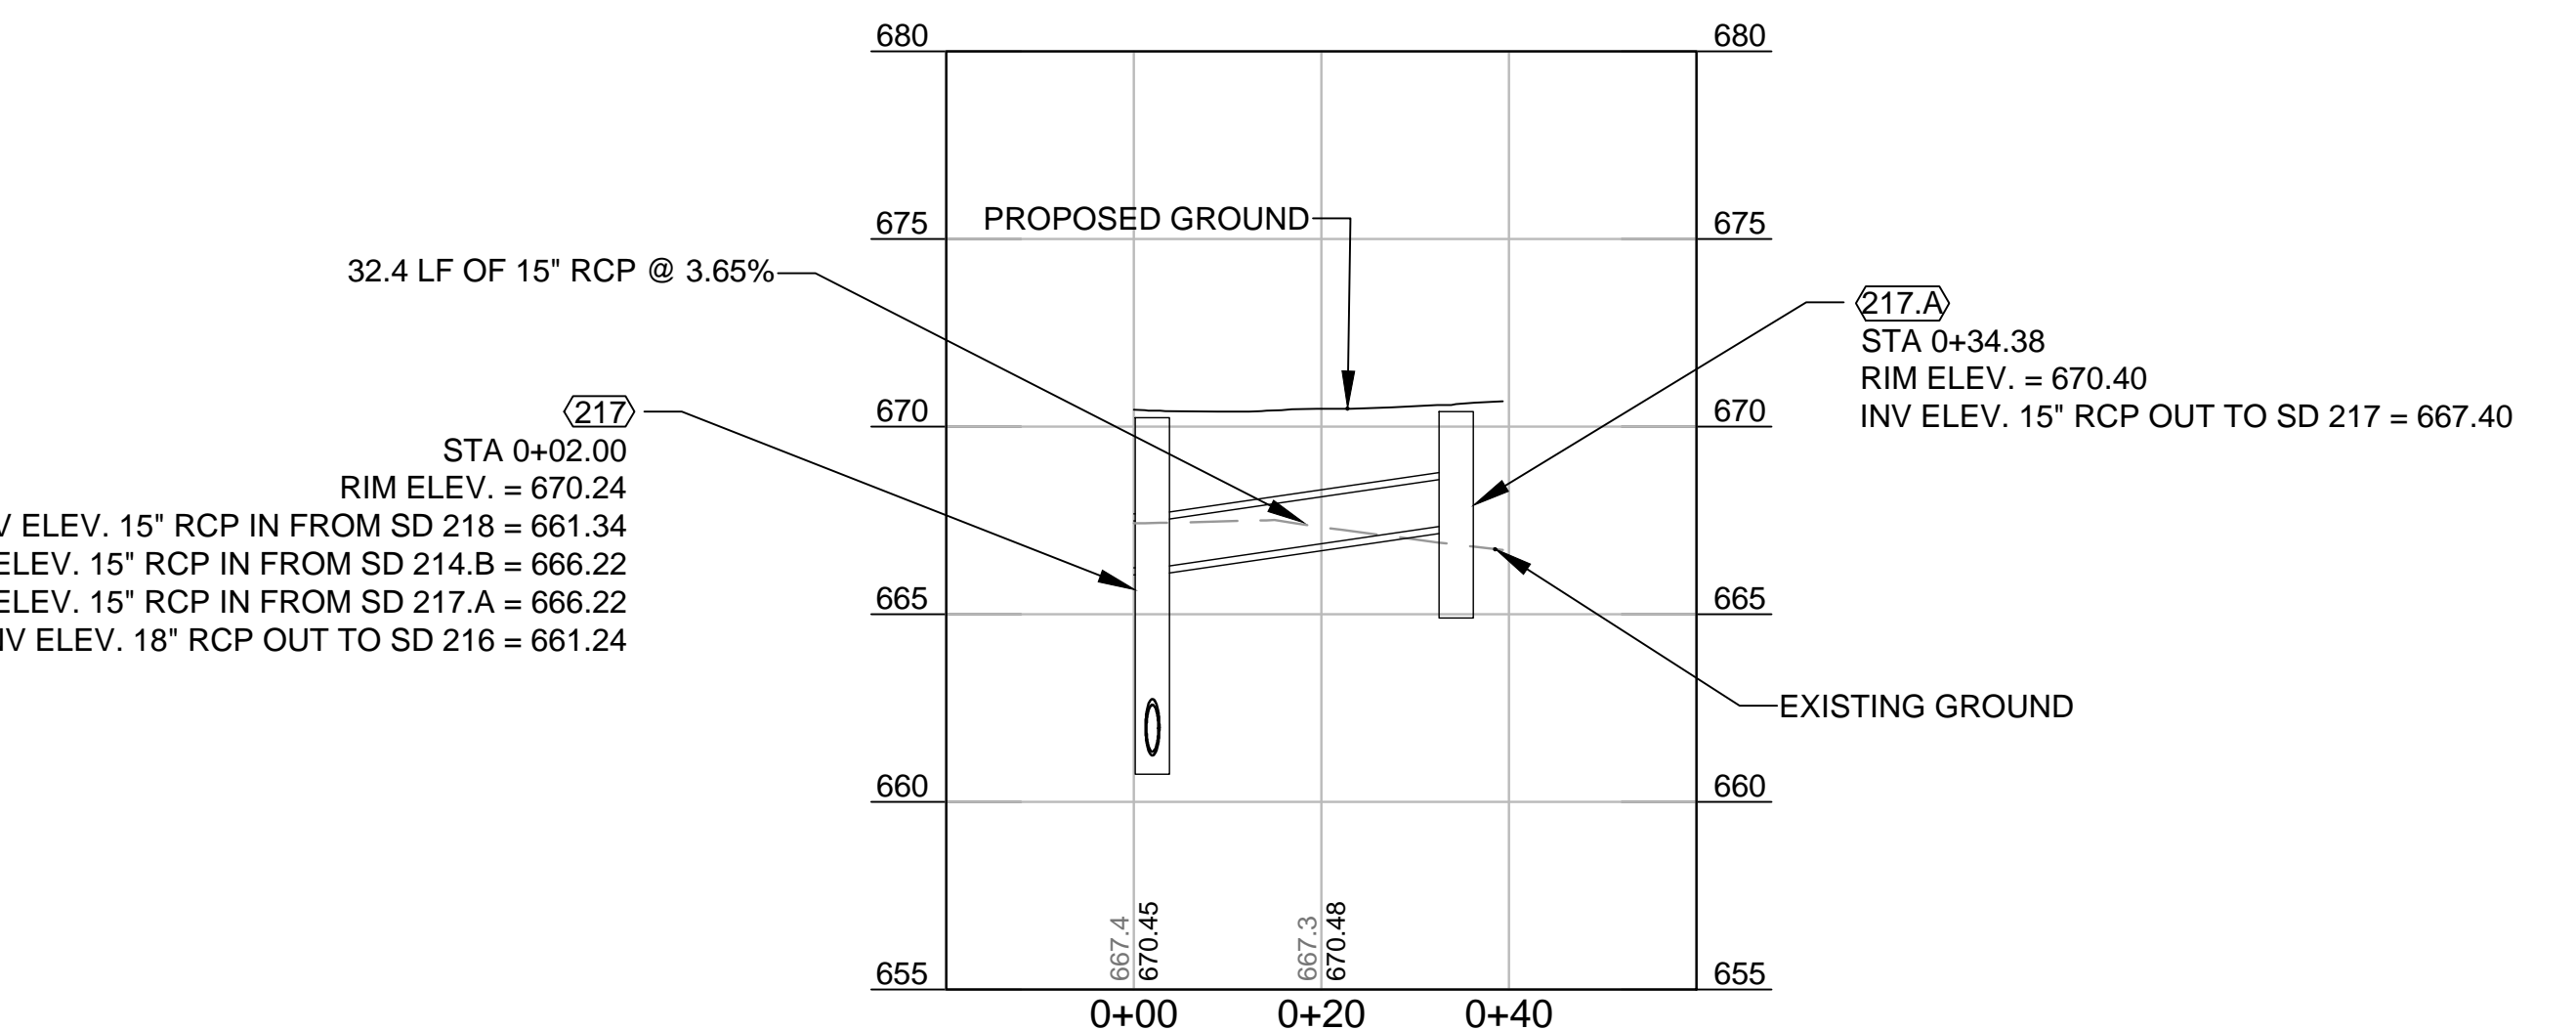

Profile View of SD 150 TO SD 151

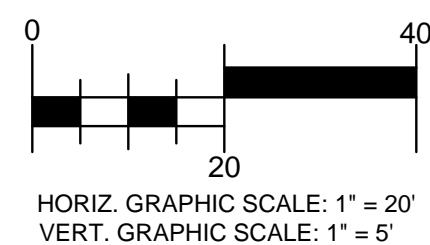

- ### GENERAL NOTES
-
1. REFER TO SHEETS C-301 AND C-302 FOR STORM DRAINAGE LAYOUT.
 2. FULLY SEAL ALL PIPE AND STRUCTURE JOINTS.
 3. RIM ELEVATIONS FOR ALL CURB INLETS IS LOCATED AT BOTTOM FACE OF CURB. RIM ELEVATION FOR ALL FLOW SPLITTER BOXES ARE MEASURED TO TOP OF MANHOLE RIM.

LEGEND

FES = FLARED END SECTION. SEE DETAIL C7/C-507.



TBC = TOP BACK CURB

ELEV. =ELEVATION

INV = INVERT

[illegible]

CONSULTANTS:

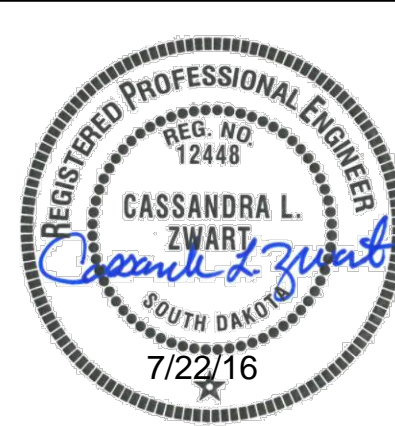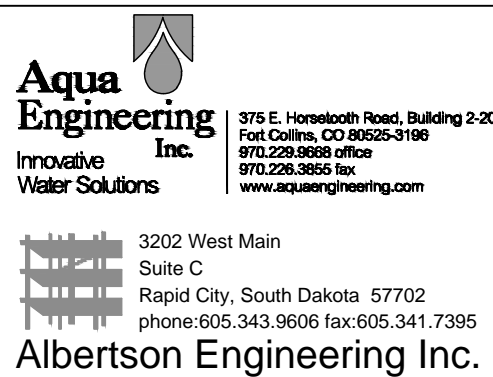

ARCHITECT/ENGINEERS:



517 7th street
pid city sd 57701
p 605.342.9470
f 605.342.2377
www.4front.biz

Drawing Title STORM DRAINAGE PROFILES #2		Project Title SALISBURY NATIONAL CEMETERY GRAVESITE EXPANSION		Project Number 876CM3021	
Approved: Project Director		Location SALISBURY NATIONAL CEMETERY SALISBURY, NC		Building Number N/A	
		Date 7/22/16		Checked CZ	
		Drawn JM		Drawing Number <div style="font-size: 2em; font-weight: bold;">C-402</div> Dwg. 22 of 63	

NCA DESIGN
AND CONSTRUCTION
SERVICE

