


A REFER TO SHEET P001 FOR LEGEND, SYMBOLS & INDEX OF DRAWINGS.

1 EXISTING TO REMAIN.

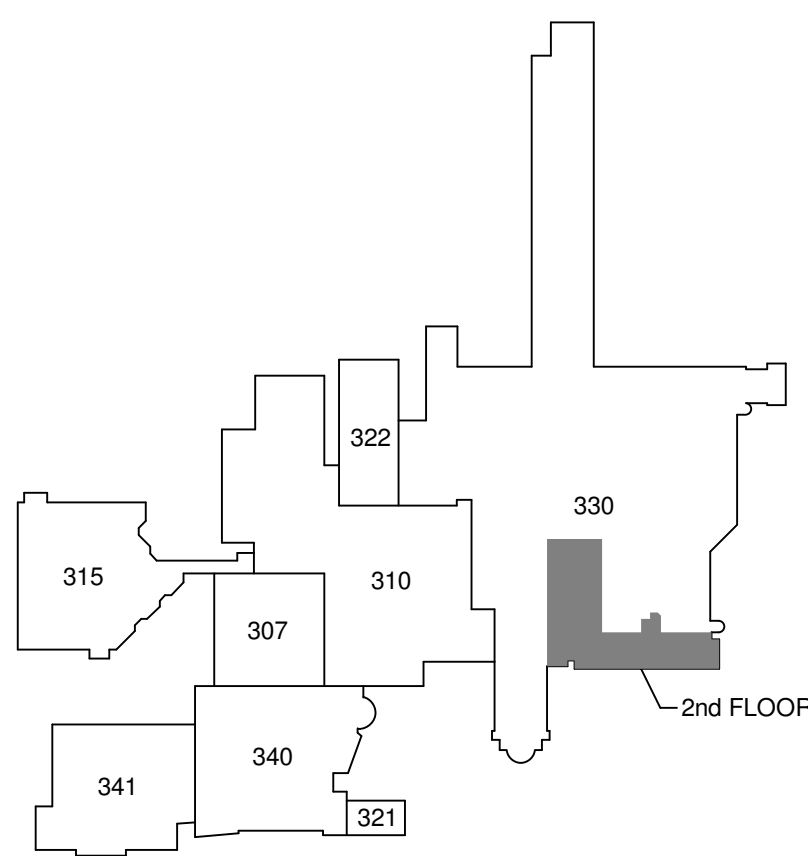

Scale: N.T.S.

Scale: N.T.S.

CONSULTANTS:



Heapy Engineering


MEP Design Technology Planning Commissioning Energy

Nationally Recognized Leader in Sustainability

1400 W Dorothy Lane, Dayton, OH 45409-1310
Ph 937-224-0861 Fax 937-224-5777 www.heapy.com

Heapy Project No.: 2014-04034 Firm License No.: 01528



Project Title RELOCATE PROSTHETICS AND PODIATRY CLINICS			Project No. VA Project No. 552-15-502 JPA Project No. 14006.00		Office of Construction and Facilities Management
Location Dayton, Ohio			Building Number 999		
Date			Drawing Number P902		
Checked			Drawn		 Department of Veterans Affairs